


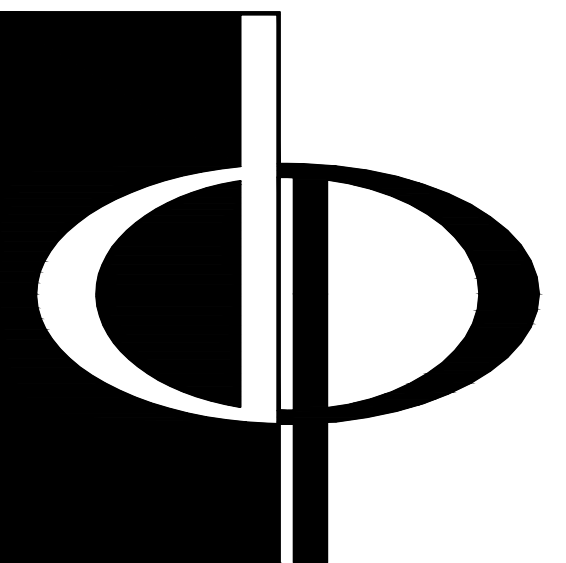

**THE PRESTON  
PARTNERSHIP, LLC**  
A MULTI-DISCIPLINARY DESIGN FIRM

SOUTH TERRACES  
115 PERIMETER CENTER PLACE, SUITE 950  
ATLANTA, GEORGIA 30346  
TELEPHONE: 770.396.7248  
FAX: 770.396.2945  
WWW.THEPRESTONPARTNERSHIP.COM

CONSULTANT

**DEI**  
DESIGN  
ENVIRONMENTS  
INC.

SEAL

PROJECT

**CIRCLE 75  
PHASE II**

CIRCLE 75  
COBB COUNTY, GA 30339

FOR

**ATLANTIC REALTY  
PARTNERS**

3438 PEACHTREE ROAD  
SUITE 1425  
ATLANTA, GA 30326

△ ISSUE DATE  
XXXXXXX 00.00.00  
XXXXXXX 00.00.00

DATE 07.20.16

JOB NUMBER 15303

DRAWN BY KD, MS

CHECKED BY MG

DEI JOB #

15303

SHEET TITLE


**LEVEL 2 REFLECTED  
CEILING PLAN**

SHEET NUMBER

**ID.201**

COMMENTS

© 2015 The Preston Partnership, LLC

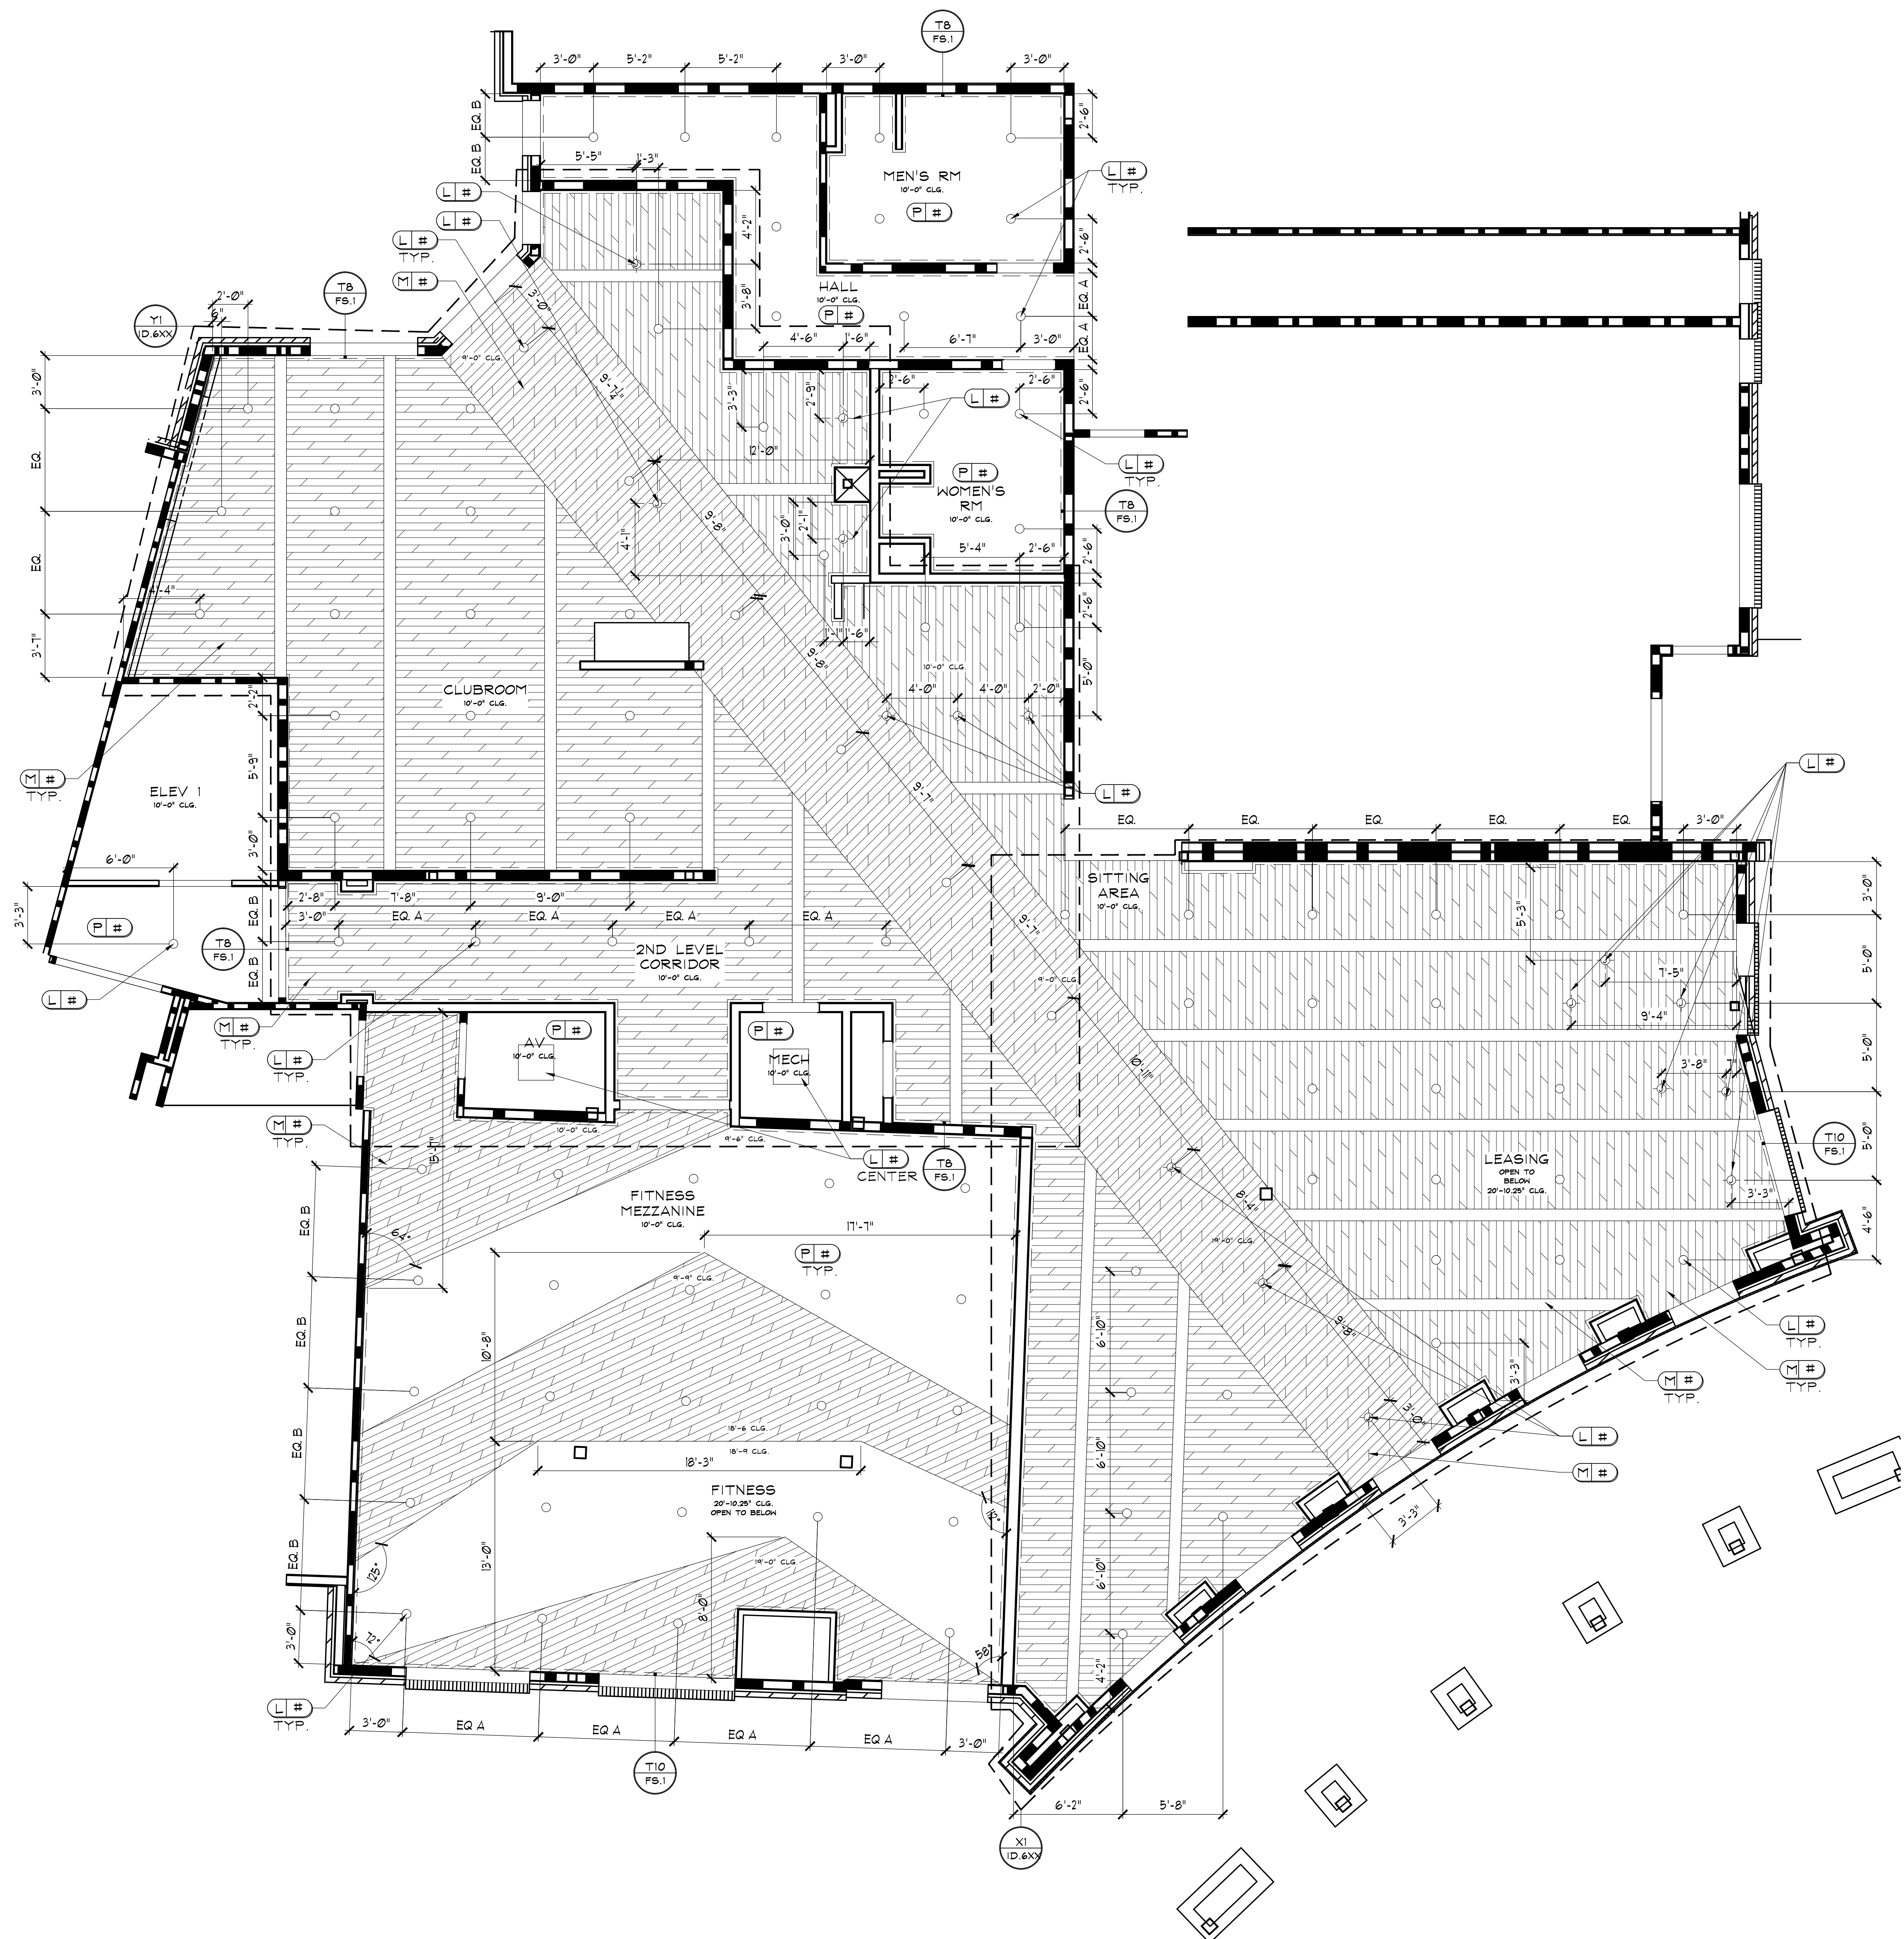

**REFLECTED CEILING NOTE:**  
LIGHTING LOCATIONS PER ARCH UNLESS OTHERWISE NOTED

**REFLECTED CEILING KEY:**

- JUNCTION BOX
- RECESSED CAN
- 2'-0" X 4'-0" FLUORESCENT LIGHT

**ELECTRICAL NOTES:**  
ELECTRICAL OUTLET, JUNCTION BOX, AND LIGHTING MUST BE REFERRED TO AND CONFIRMED WITH ELECTRICAL ENGINEER'S DRAWINGS AS WELL AS STATE REQUIREMENTS. LOCATIONS AS SHOWN ARE DESIRABLE IN ACCORDANCE WITH DESIGN. REFER TO ELECTRICAL ENGINEER'S DRAWING FOR ELECTRICAL INFORMATION.

**LEVEL 2 REFLECTED CEILING PLAN**  
SCALE : 1/4" = 1'-0"