

CONSULTANT

D*E*i
—
**DESIGN
ENVIRONMENTS
INC.**
—

PROJECT _____

CIRCLE 75
PHASE II

CIRCLE 75
COBB COUNTY, GA 30339

OR _____

ATLANTIC REALTY
PARTNERS

3438 PEACHTREE ROAD
SUITE 1425
ATLANTA, GA 30326

| ISSUE | DATE |
|----------|----------|
| XXXXXXXX | 00.00.00 |
| XXXXXXXX | 00.00.00 |

DATE 07.20.16

JOB NUMBER 15303

RAWN BY _____ KD, MS

CHECKED BY _____ MC

EI JOB # _____

15303

SHEET TITLE LEVEL 6 REFLECTED

CEILING PLAN




SHEET NUMBER CEILING PLAN

ID 202


COMMENTS _____

© 2015 The Preston Partnership, LLC

LIGHTING LOCATIONS PER ARCH UNLESS OTHERWISE NOTED

 JUNCTION BOX
 RECESSED CAN
 2'-0" X 2'-0" FLUORESCENT LIGHT

ELECTRICAL OUTLET, JUNCTION BOX, AND LIGHTING MUST BE REFERRED TO AND CONFIRMED WITH ELECTRICAL ENGINEER'S DRAWINGS AS WELL AS STATE REQUIREMENTS. LOCATIONS AS SHOWN ARE DESIRABLE IN ACCORDANCE WITH DESIGN. REFER TO ELECTRICAL ENGINEER'S DRAWING FOR ELECTRICAL INFORMATION.

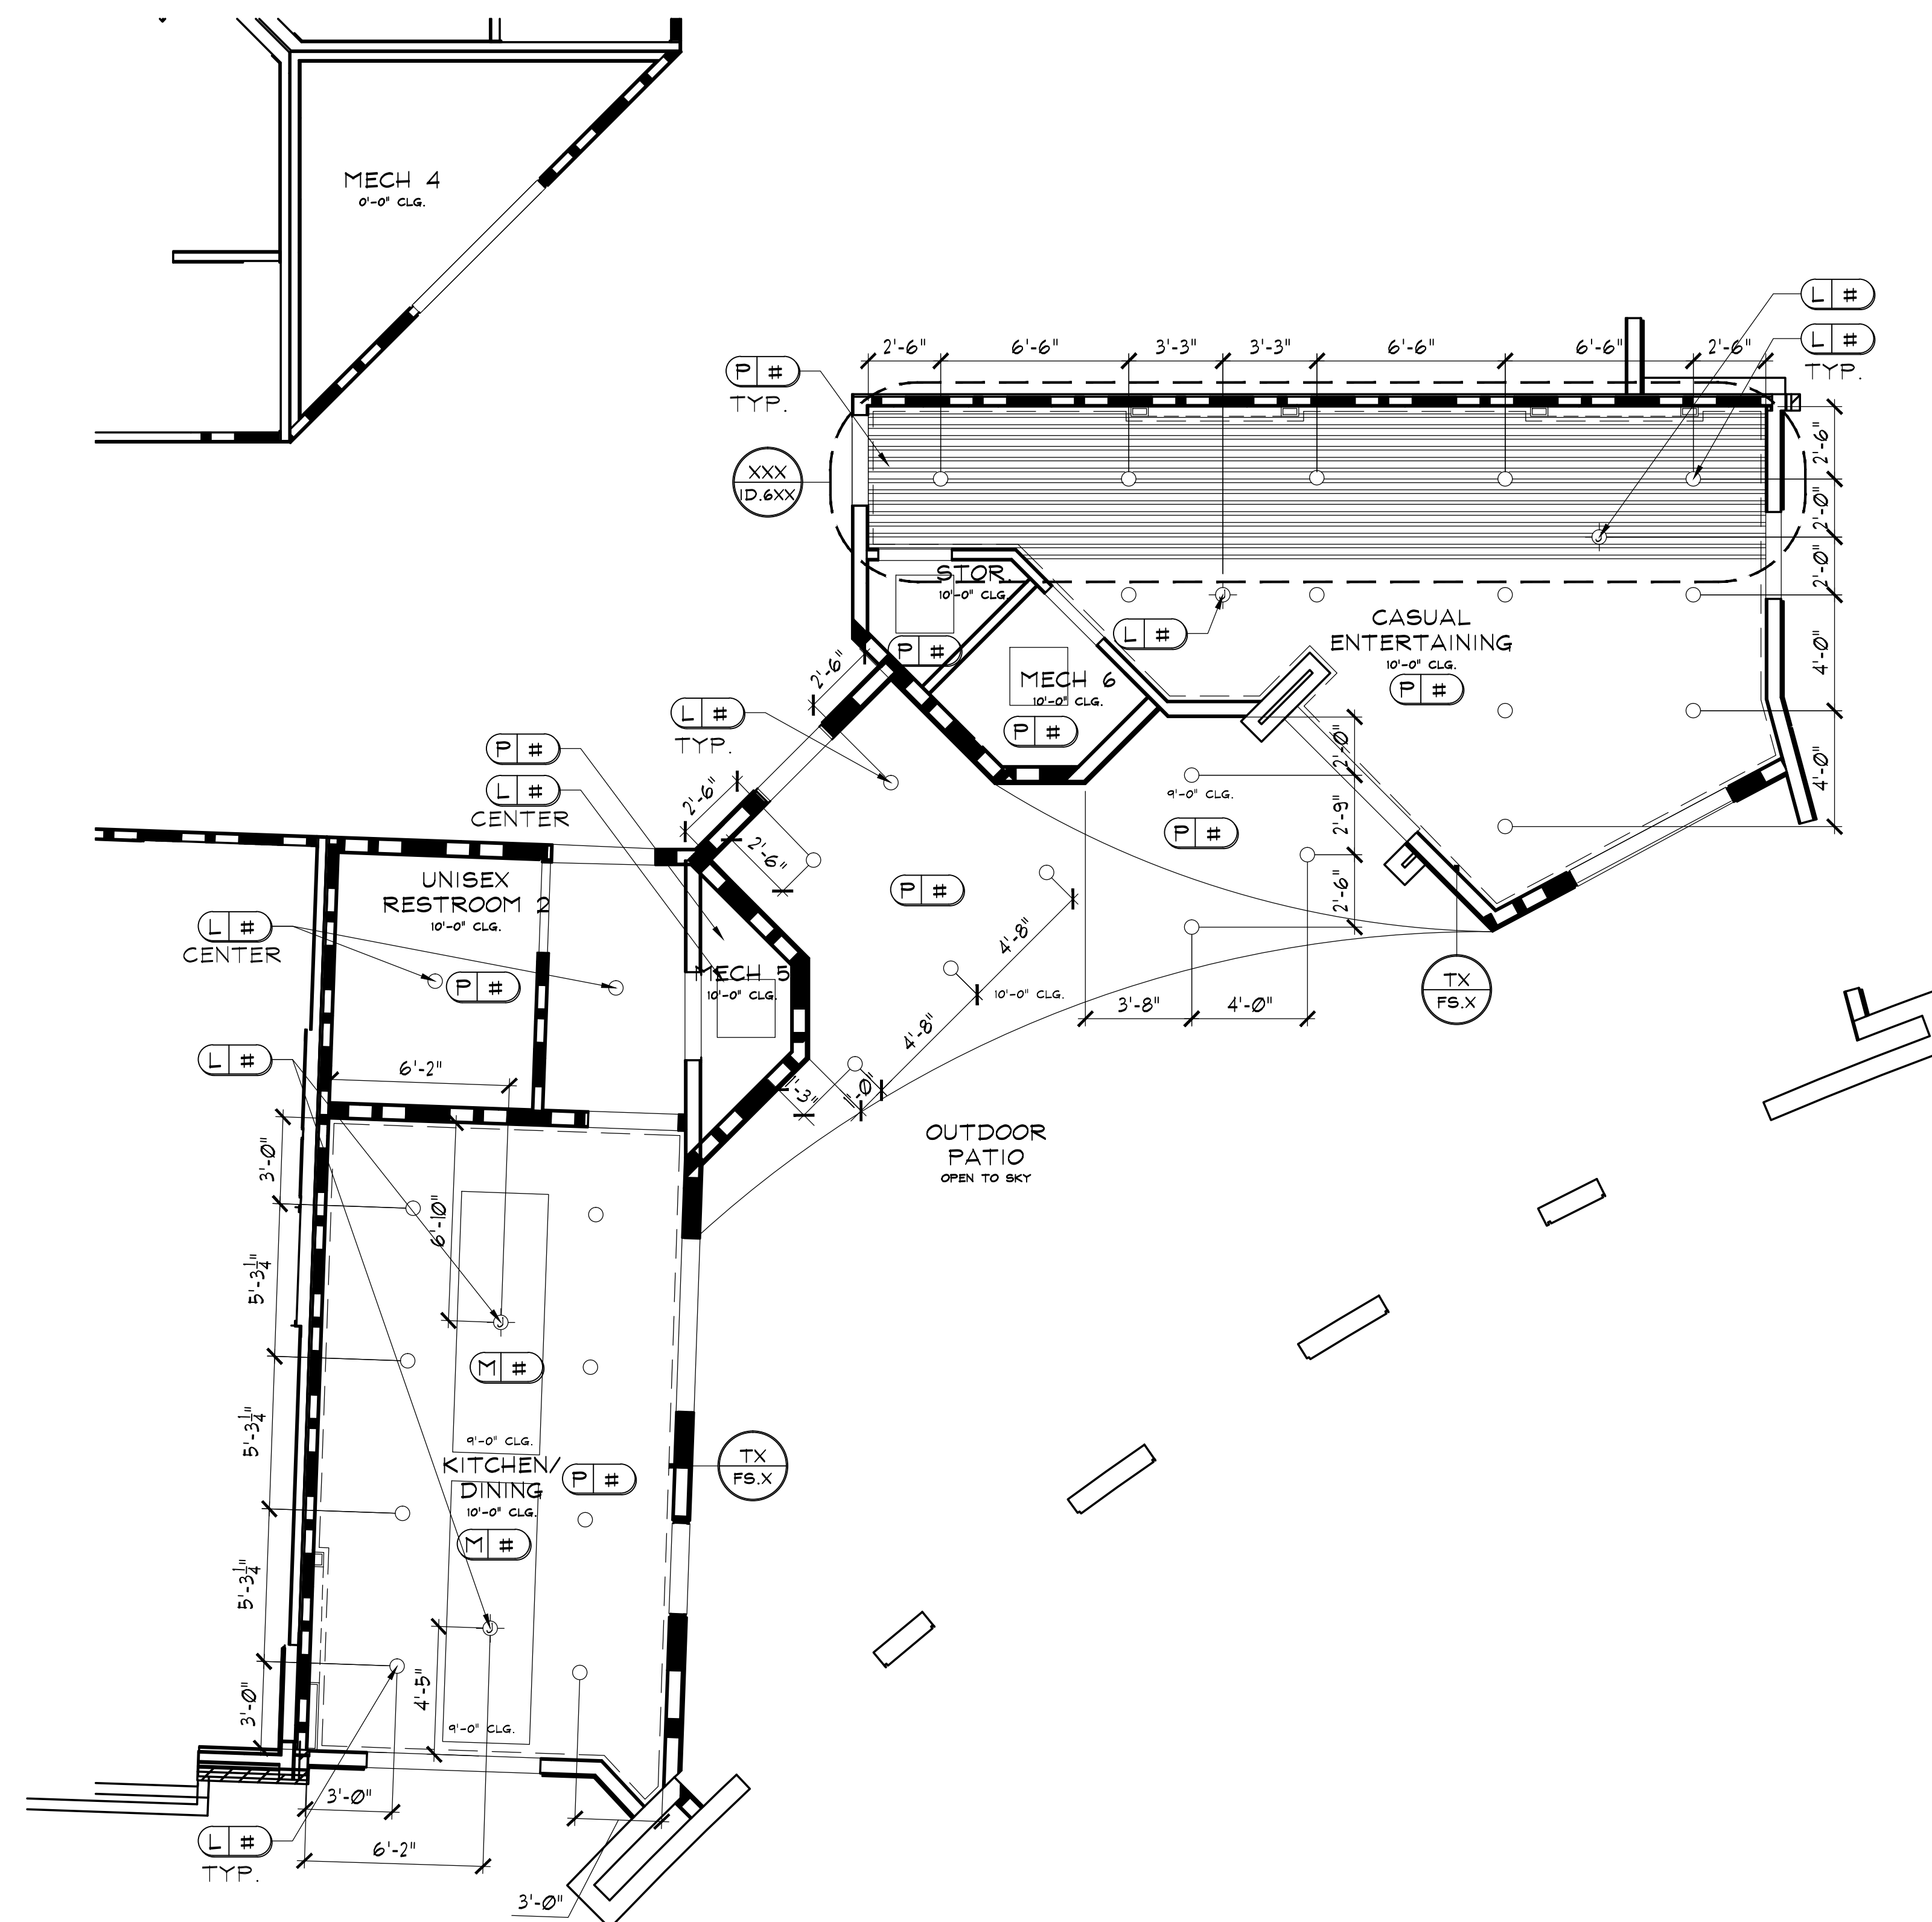

1
ID 202

LEVEL 6 REFLECTED CEILING PLAN

SCALE : 1/4" = 1'-0"