

Job #	Job_Location	Job Name	Job Address1	PO_Number	Equipment Type	Equipment #	Make	Model
1 - ALEXAN NORTH STA	6919 PEACHTREE DUNWOODY RD., SANDY SPRING	ALEXAN NORTH STATION	6919 PEACHTREE DUNWOODY RD	STEVE L	007-0253 25-27 RT SCISSOR	787727	GENIE	GS2669RT
1 - AVALON	2800 OLD MILTON PARKWAY, ALPHARETTA	AVALON	2800 OLD MILTON PARKWAY	CHAD	049-0002 PALLET FORKS - LARGE SKID	780894	BOBCAT	6540183
1 - AVALON	2800 OLD MILTON PARKWAY, ALPHARETTA	AVALON	2800 OLD MILTON PARKWAY	CHAD	150-1475 SKIDSTEER LOADER BUCKET	BUCKS		
1 - NORTH GA JOBS	1376 AIRPORT IND PARK DRIVE, MARIETTA	NORTH GA JOBS	1376 AIRPORT IND PARK DRIVE	JOB# UNDER EQUIPMENT	048-0510 1500-2100LB TRACK SKIDSTEER	529780	BOBCAT	T590
1 - NORTH GA JOBS	1376 AIRPORT IND PARK DRIVE, MARIETTA	NORTH GA JOBS	1376 AIRPORT IND PARK DRIVE	JOB# UNDER EQUIPMENT	150-0175 STEEL AIR HAMMER MOIL POINT	STEELP		
1 - NORTH GA JOBS	1376 AIRPORT IND PARK DRIVE, MARIETTA	NORTH GA JOBS	1376 AIRPORT IND PARK DRIVE	JOB# UNDER EQUIPMENT	064-0120 JUMPING JACK TAMPER 135-165LB CLASS	639217	MQ	MTX60HD
1 - NORTH GA JOBS	1376 AIRPORT IND PARK DRIVE, MARIETTA	NORTH GA JOBS	1376 AIRPORT IND PARK DRIVE	JOB# UNDER EQUIPMENT	120-0120 65LB CLASS DEMOLITION HAMMER	868182	DEWALT	D25980K
1 - NORTH GA JOBS	1376 AIRPORT IND PARK DRIVE, MARIETTA	NORTH GA JOBS	1376 AIRPORT IND PARK DRIVE	JOB# UNDER EQUIPMENT	001-0008 TOOLFLEX8	TOOLFLEX8		
1 - NORTH GA JOBS	1376 AIRPORT IND PARK DRIVE, MARIETTA	NORTH GA JOBS	1376 AIRPORT IND PARK DRIVE	JOB# UNDER EQUIPMENT	064-0120 JUMPING JACK TAMPER 135-165LB CLASS	801655	MQ	MTX70HD
1 - NORTH GA JOBS	1376 AIRPORT IND PARK DRIVE, MARIETTA	NORTH GA JOBS	1376 AIRPORT IND PARK DRIVE	JOB# UNDER EQUIPMENT	064-0120 JUMPING JACK TAMPER 135-165LB CLASS	730022	WACKER	95504S
1 - NORTH GA JOBS	1376 AIRPORT IND PARK DRIVE, MARIETTA	NORTH GA JOBS	1376 AIRPORT IND PARK DRIVE	JOB# UNDER EQUIPMENT	064-0120 JUMPING JACK TAMPER 135-165LB CLASS	597925	MQ	MTX70HD
1 - NORTH STATION OF	6903 PEACHTREE DUNWOODY RD., SANDY SPRING	NORTH STATION OFFICE COMPLEX	6903 PEACHTREE DUNWOODY RD.	JOB# UNDER EQUIPMENT	150-0180 AIR HAMMER CHISEL	STEELC		
1 - POST CENTENNIAL	306 WILLIAMS ST NW, ATLANTA	POST CENTENNIAL	306 WILLIAMS ST NW	102283	007-0025 19" ELECT SCISSORLIFT	952226	GENIE	GS1930
1 - POST CENTENNIAL	306 WILLIAMS ST NW, ATLANTA	POST CENTENNIAL	306 WILLIAMS ST NW	JOB#10273	035-0130 6,000LB MINI EXCAVATOR	648825	JOHN DEERE	27D
1 - THE SPRINGS @ MC	325 SOUTH POINT BLVD, MCDONOUGH	THE SPRINGS @ MCDONOUGH	325 SOUTH POINT BLVD	JOB#10273	150-0660 18" COMPACT EXCAVATOR BUCKET	BECL8		
1 - THE SPRINGS @ MC	325 SOUTH POINT BLVD, MCDONOUGH	THE SPRINGS @ MCDONOUGH	325 SOUTH POINT BLVD	10289	064-0120 JUMPING JACK TAMPER 135-165LB CLASS	611406	MQ	MTX70HD
1 - THE SPRINGS @ MC	325 SOUTH POINT BLVD, MCDONOUGH	THE SPRINGS @ MCDONOUGH	325 SOUTH POINT BLVD	10289	035-0150 11,000LB MINI EXCAVATOR	798944	JOHN DEERE	50G
1010 1010 WEST PEACHTREE ST, ATLANTA	MILLER MECHANICAL CONTRS INC	MILLER MECHANICAL CONTRS INC	1010 WEST PEACHTREE STREET	N/R	10289 150-0662 24" COMPACT EXCAVATOR BUCKET	BECL24		
10259 400 PHARR RD NE, ATLANTA	HANOVER PARK PLACE	HANOVER PARK PLACE	400 PHARR RD NE		007-0011 25-26" ELECT SCISSOR NARROW	734598	JLG	2632ES
1028 693 PEACHTREE ST NE, ATLANTA	MULTI FAMILY	MULTI FAMILY	693 PEACHTREE ST NE		10259 007-0025 19" ELECT SCISSORLIFT	585403	JLG	1932MS
1028 693 PEACHTREE ST NE, ATLANTA	MULTI FAMILY	MULTI FAMILY	693 PEACHTREE ST NE		10284 035-0130 6,000LB MINI EXCAVATOR	626018	JOHN DEERE	27D
1028 693 PEACHTREE ST NE, ATLANTA	MULTI FAMILY	MULTI FAMILY	693 PEACHTREE ST NE		10284 150-0660 18" COMPACT EXCAVATOR BUCKET	BECL8		
2 - AVALON - AVALON	9000 AVALON BLVD, ALPHARETTA	AVALON	9000 AVALON BLVD		10279 058-0455 45" ART MANLIFT	801660	MQ	MTX70HD
2 - TOWNE CENTER - T	300 VILLAGE DRIVE, KING OF PRUSSIA	TOWNE CENTER	300 VILLAGE DRIVE	HANOVER JOBSITE	059-0515 UTILITY VEHICLE 2 SEAT 4WD DSL	364326	JLG	450A
2 - TOWNE CENTER - T	300 VILLAGE DRIVE, KING OF PRUSSIA	TOWNE CENTER	300 VILLAGE DRIVE	VILLAGE DR	035-0125 9,500LB MINI EXCAVATOR CAB	549907	BOBCAT	3400
2 - TOWNE CENTER - T	300 VILLAGE DRIVE, KING OF PRUSSIA	TOWNE CENTER	300 VILLAGE DRIVE	VILLAGE DR	150-0658 12" COMPACT EXCAVATOR BUCKET	405131	BOBCAT	324
3150 3150 ROSWELL RD, ATLANTA	HANOVER BUCKHEAD VILLAGE	HANOVER BUCKHEAD VILLAGE	3150 ROSWELL RD	CHAD	007-0253 25-27 RT SCISSOR	BECL2		
3150 3150 ROSWELL RD, ATLANTA	HANOVER BUCKHEAD VILLAGE	HANOVER BUCKHEAD VILLAGE	3150 ROSWELL RD	CHAD	007-0010 25-26" ELECT SCISSORLIFT 46" WIDE	753565	GENIE	GS2669RT
3150 3150 ROSWELL RD, ATLANTA	HANOVER BUCKHEAD VILLAGE	HANOVER BUCKHEAD VILLAGE	3150 ROSWELL RD	CHAD	055-0235 5000LB FORKLIFT LOW MAST GAS / PROPANE	586802	GENIE	GS2646
56- MILLER MECHANICA	1155 HAMMOND DRIVE, ATLANTA	HAMMOND CENTER/APARTMENTS	1155 HAMMOND DRIVE	CHAD	100 007-0011 25-26" ELECT SCISSOR NARROW	613171	TOYOTA	8FGU25
75- MILLER MECHANICA	880 WEST PEACHTREE STREET, ATLANTA	MILLER MECHANICAL CONTRS INC	880 WEST PEACHTREE STREET NW	STEVE	150-0662 24" COMPACT EXCAVATOR BUCKET	582987	SKYJACK	SJH1 3226
75- MILLER MECHANICA	880 WEST PEACHTREE STREET, ATLANTA	MILLER MECHANICAL CONTRS INC	880 WEST PEACHTREE STREET NW	STEVE	035-0150 11,000LB MINI EXCAVATOR	BECL24		
						902757	BOBCAT	E50

PLUMBING LEGEND

1	2	3	100
1	2	3	100
1	2	3	64	6																																			

[illegible]


GAS FIRED WATER HEATER SCHEDULE									
MODEL	MANUFACTURER/MODEL	STANDARD	SEASONAL EFFICIENCY % (FEDERAL ENERGY GUIDE)	INPUT BTU/Hr	NET INPUT BTU/Hr	HEATING FUEL	ELECTRIC	REMARKS	
WH1700-3	ATL BURNER A-500								

PUMP SCHEDULE									
PUMP NO.	Q _{MAX} GPM	HEAD FT.	TYPE	SERVICE	PUMP	MODEL	HOURS		REMARKS
							START DATE	STOP DATE	
				WATER HEATING	POD		-	00	179
HPCA-1	10	7	BLINE	WATER HEATING	POD	118	-	1A	179
HPCA-2	10	7	BLINE	WATER HEATING	POD	118	-	1A	179
HPCA-3	10	7	BLINE	WATER HEATING	POD	118	-	1A	179
HPCA-155	10	7	BLINE	WATER HEATING	POD	118	-	1A	179
HPCA-156	10	7	BLINE	WATER 					


[illegible]

SHEET TITLE
Plumbing Schedules, Notes and

NO.	DATE	DESCRIPTION
1	01/15/2019	ISSUED FOR PERMIT
2	01/15/2019	ISSUED FOR PERMIT
3	01/15/2019	ISSUED FOR PERMIT
4	01/15/2019	ISSUED FOR PERMIT
5	01/15/2019	ISSUED FOR PERMIT
6	01/15/2019	ISSUED FOR PERMIT
7	01/15/2019	ISSUED FOR PERMIT
8	01/15/2019	ISSUED FOR PERMIT
9	01/15/2019	ISSUED FOR PERMIT
10	01/15/2019	ISSUED FOR PERMIT
11	01/15/2019	ISSUED FOR PERMIT
12	01/15/2019	ISSUED FOR PERMIT
13	01/15/2019	ISSUED FOR PERMIT
14	01/15/2019	ISSUED FOR PERMIT
15	01/15/2019	ISSUED FOR PERMIT
16	01/15/2019	ISSUED FOR PERMIT
17	01/15/2019	ISSUED FOR PERMIT
18	01/15/2019	ISSUED FOR PERMIT
19	01/15/2019	ISSUED FOR PERMIT

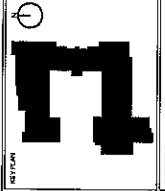


Basement Level Plan - Plumbing

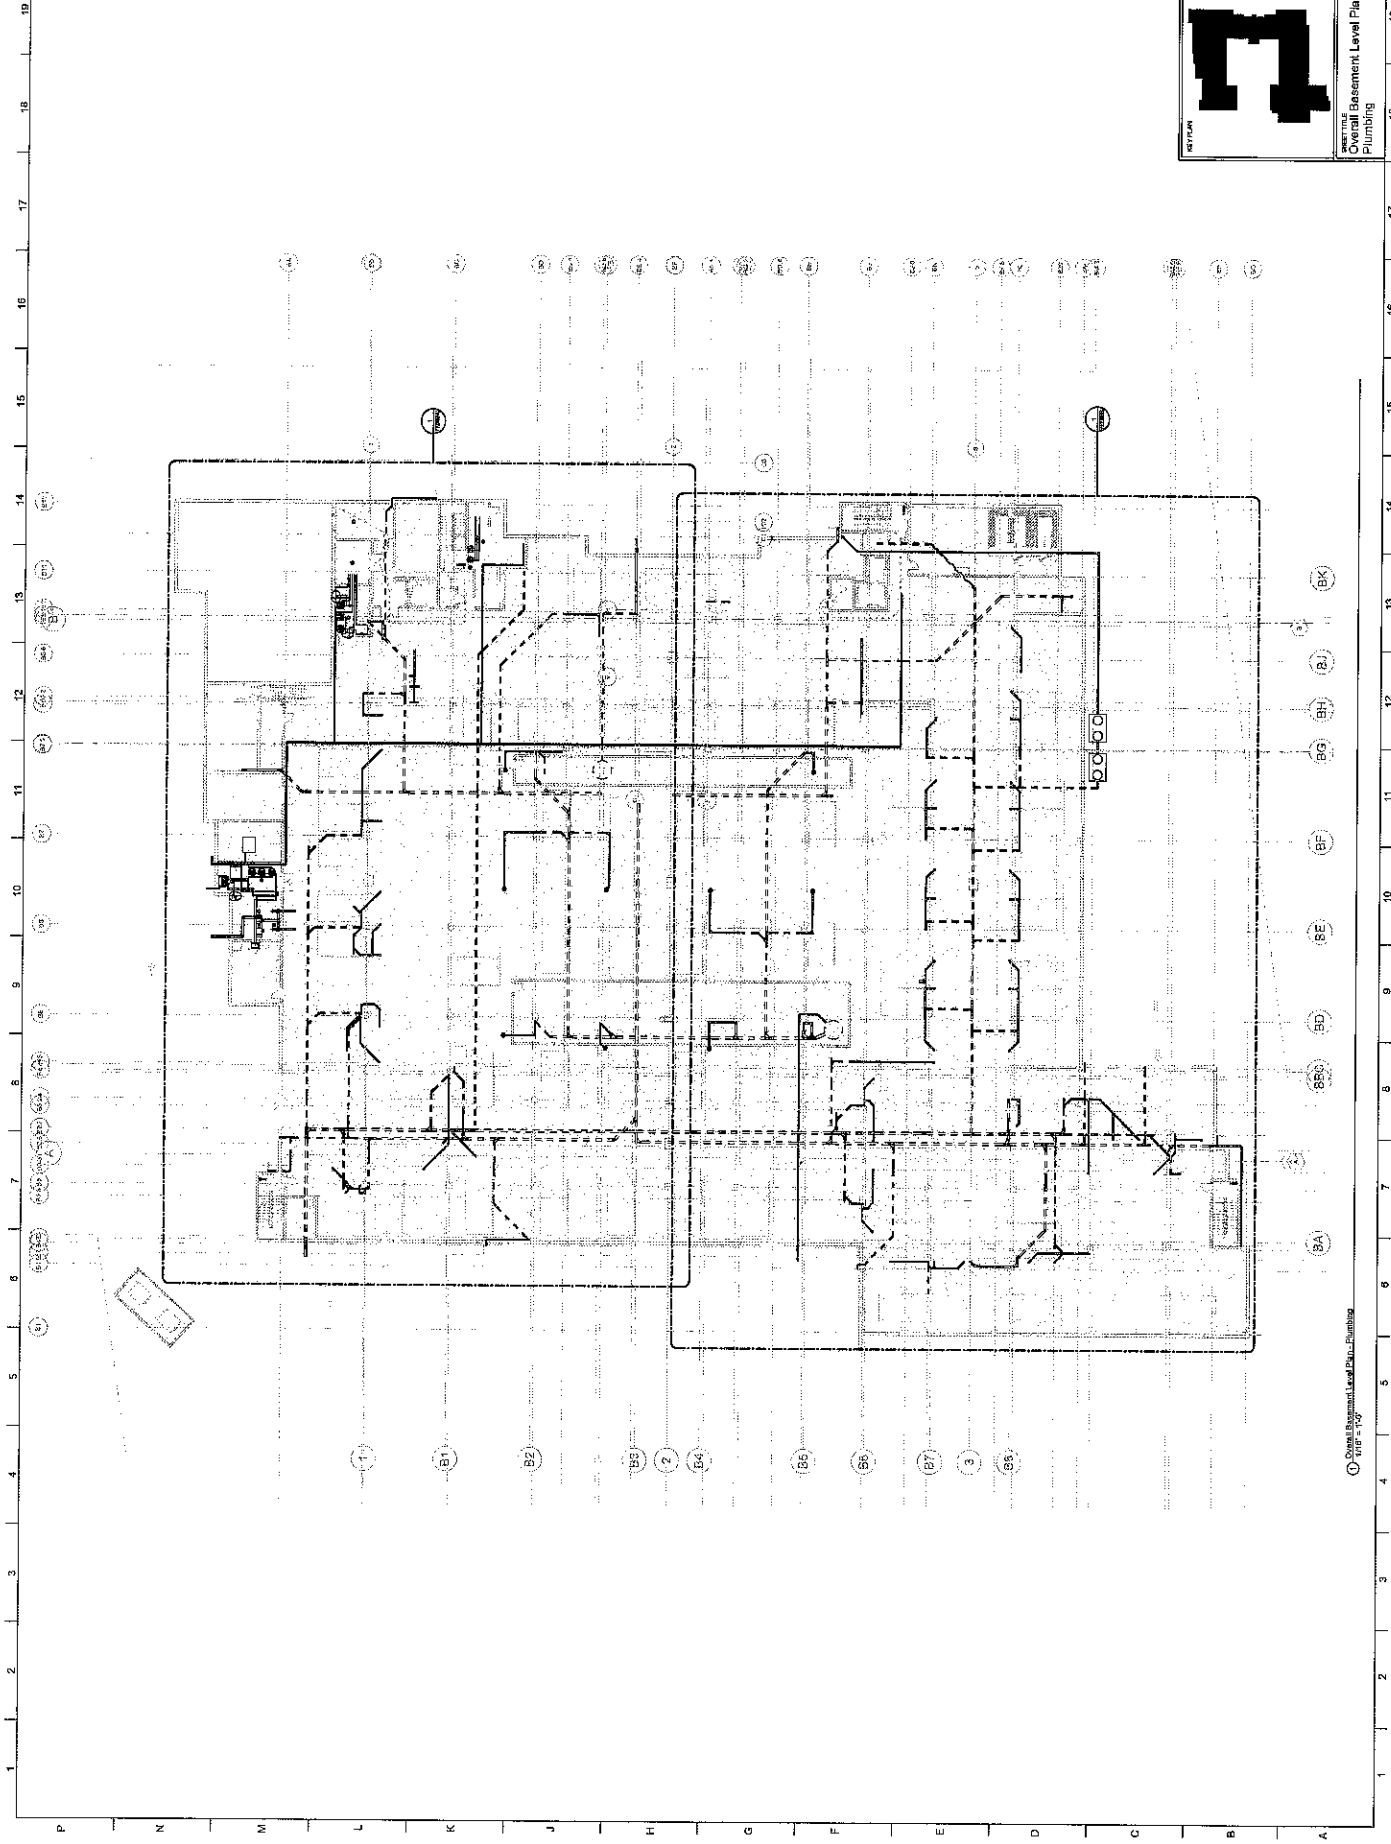

Basement Level Plan - Plumbing



NO.	REVISION	DATE	BY	CHKD.
1	ISSUED FOR PERMIT	08/14/2018	CDH	CDH
2	REVISION			
3	REVISION			
4	REVISION			
5	REVISION			
6	REVISION			
7	REVISION			
8	REVISION			
9	REVISION			
10	REVISION			
11	REVISION			
12	REVISION			
13	REVISION			
14	REVISION			
15	REVISION			
16	REVISION			
17	REVISION			
18	REVISION			
19	REVISION			

Overall Basement Level
 Overall Basement Plan - Plumbing

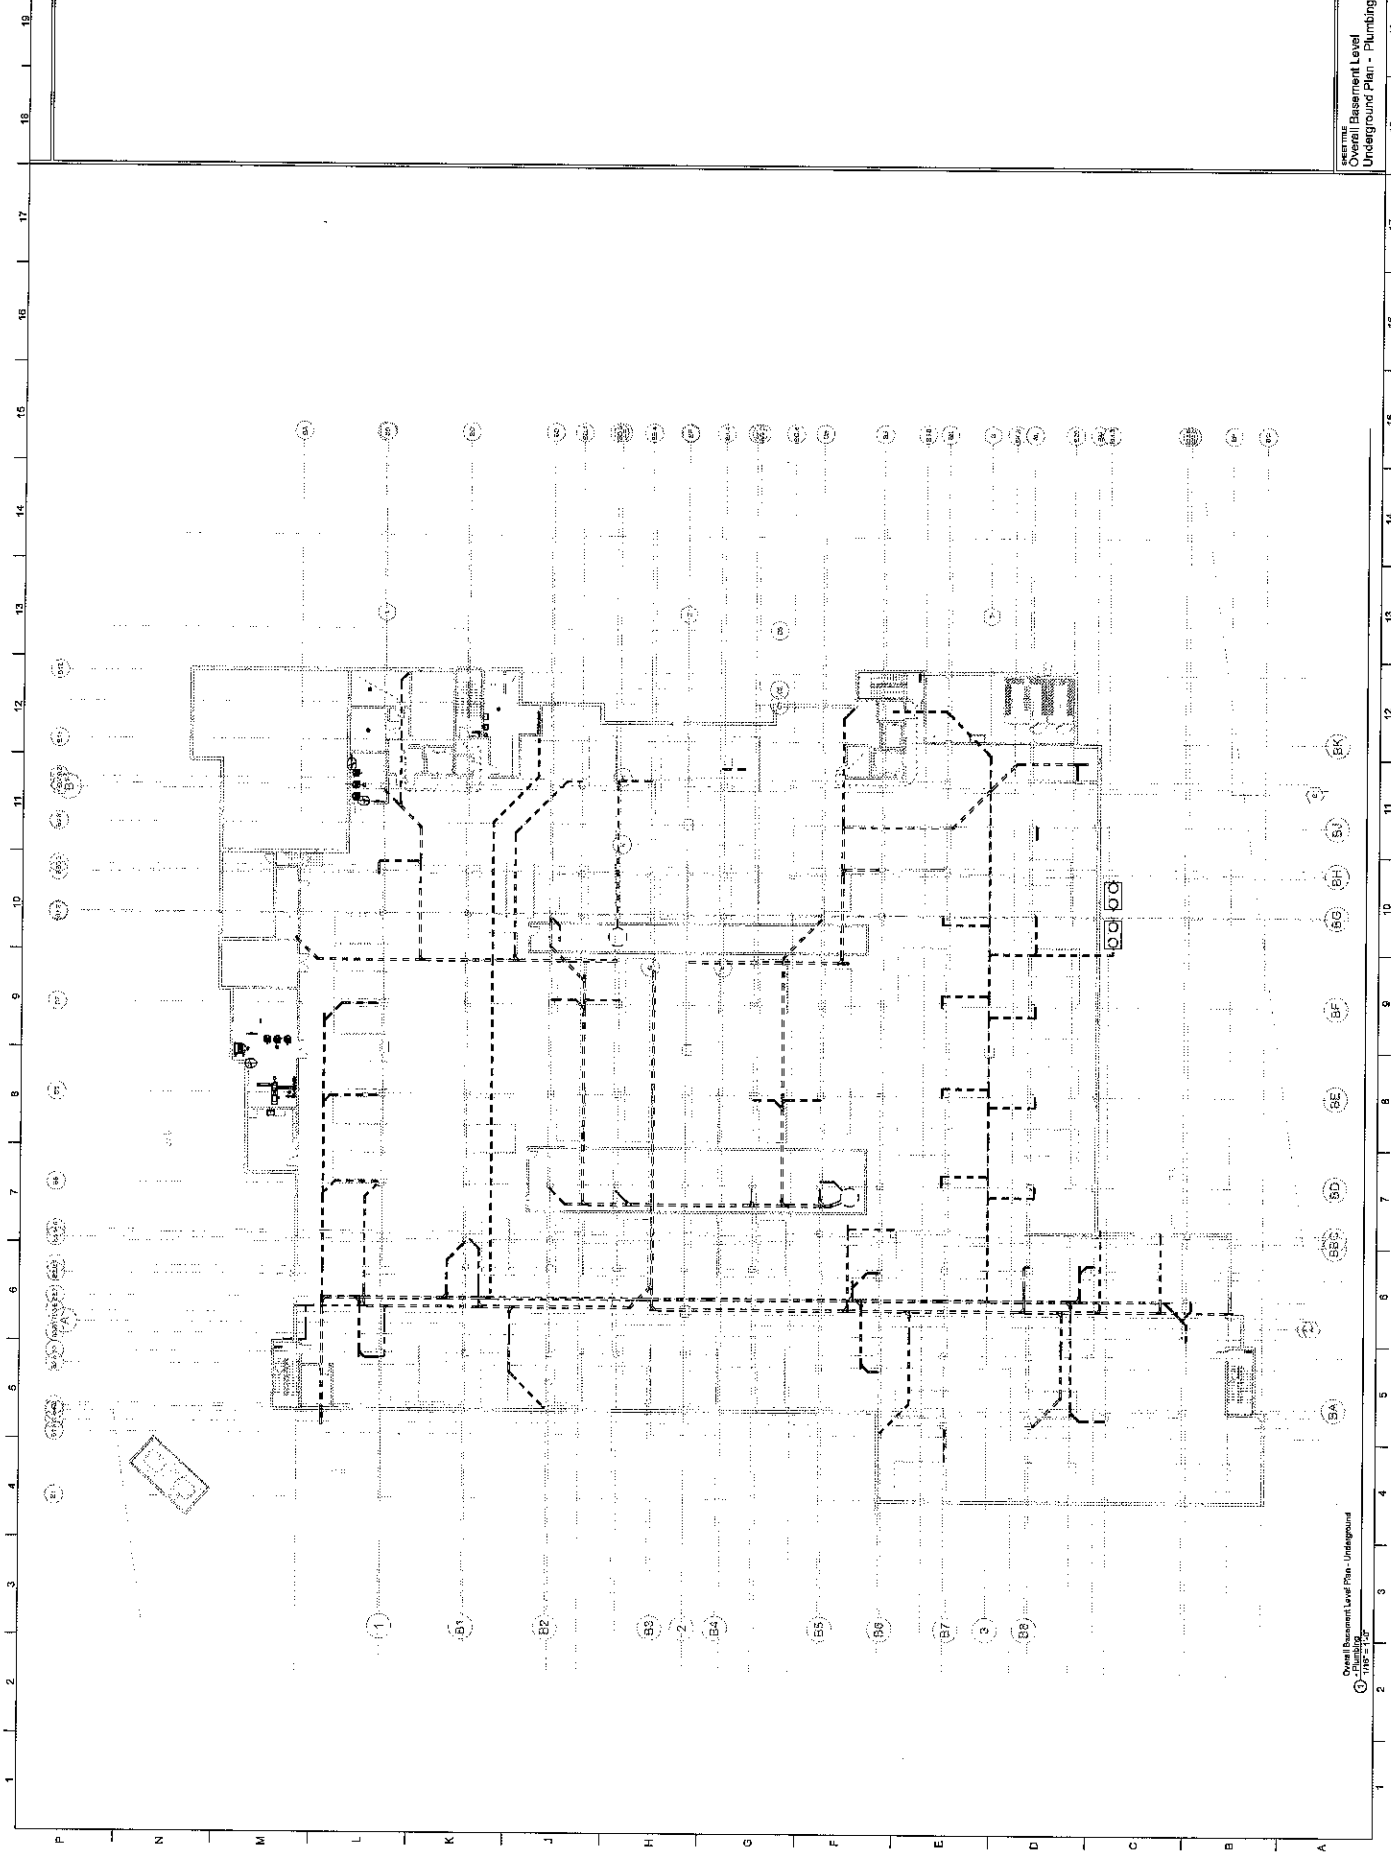



Overall Basement Level Plan - Underground
 11/18/2018

DATE	DESCRIPTION	BY	CHKD

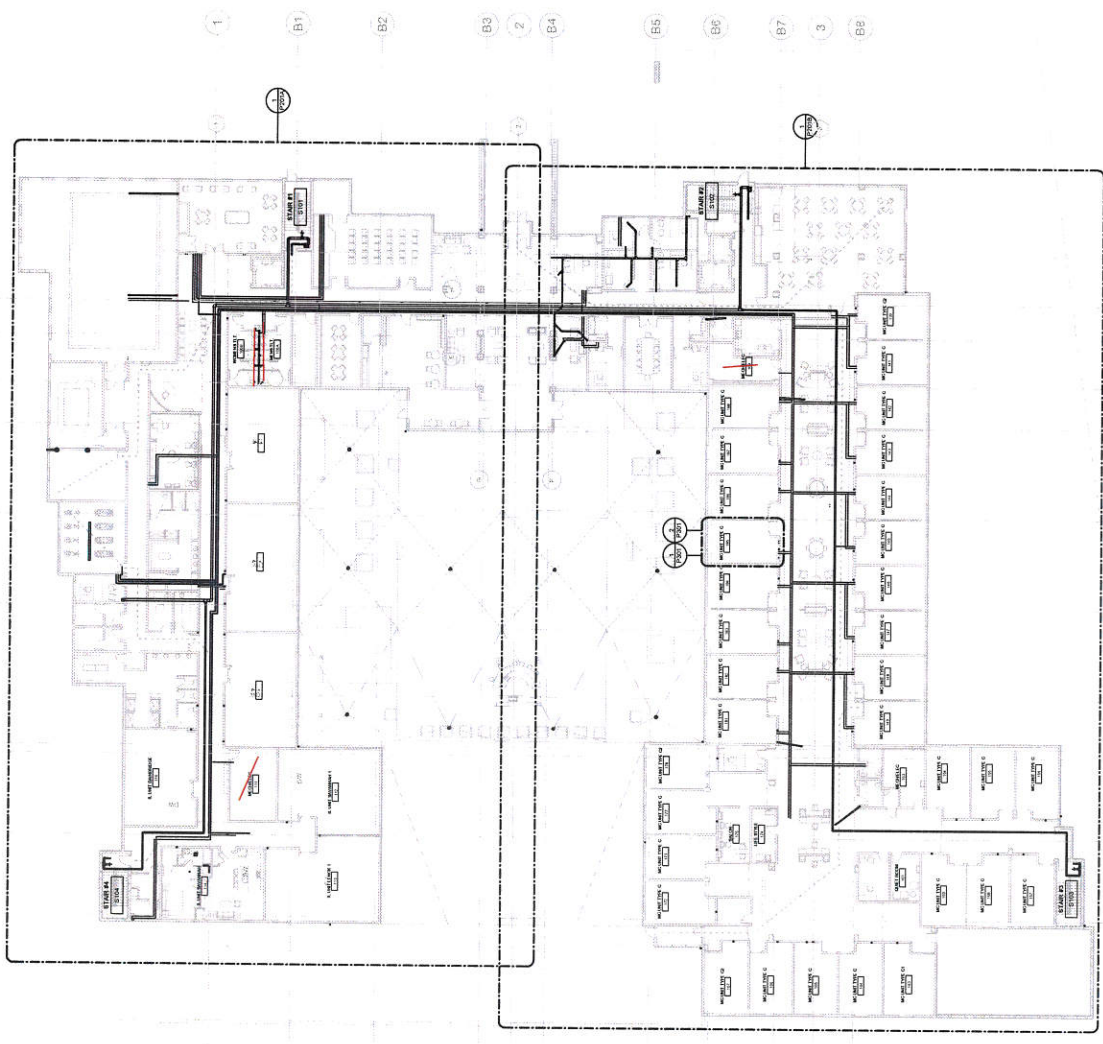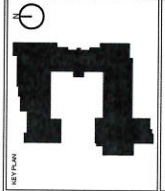


Overall 1st Level Plan - Plumbing
1/16" = 1'-0"

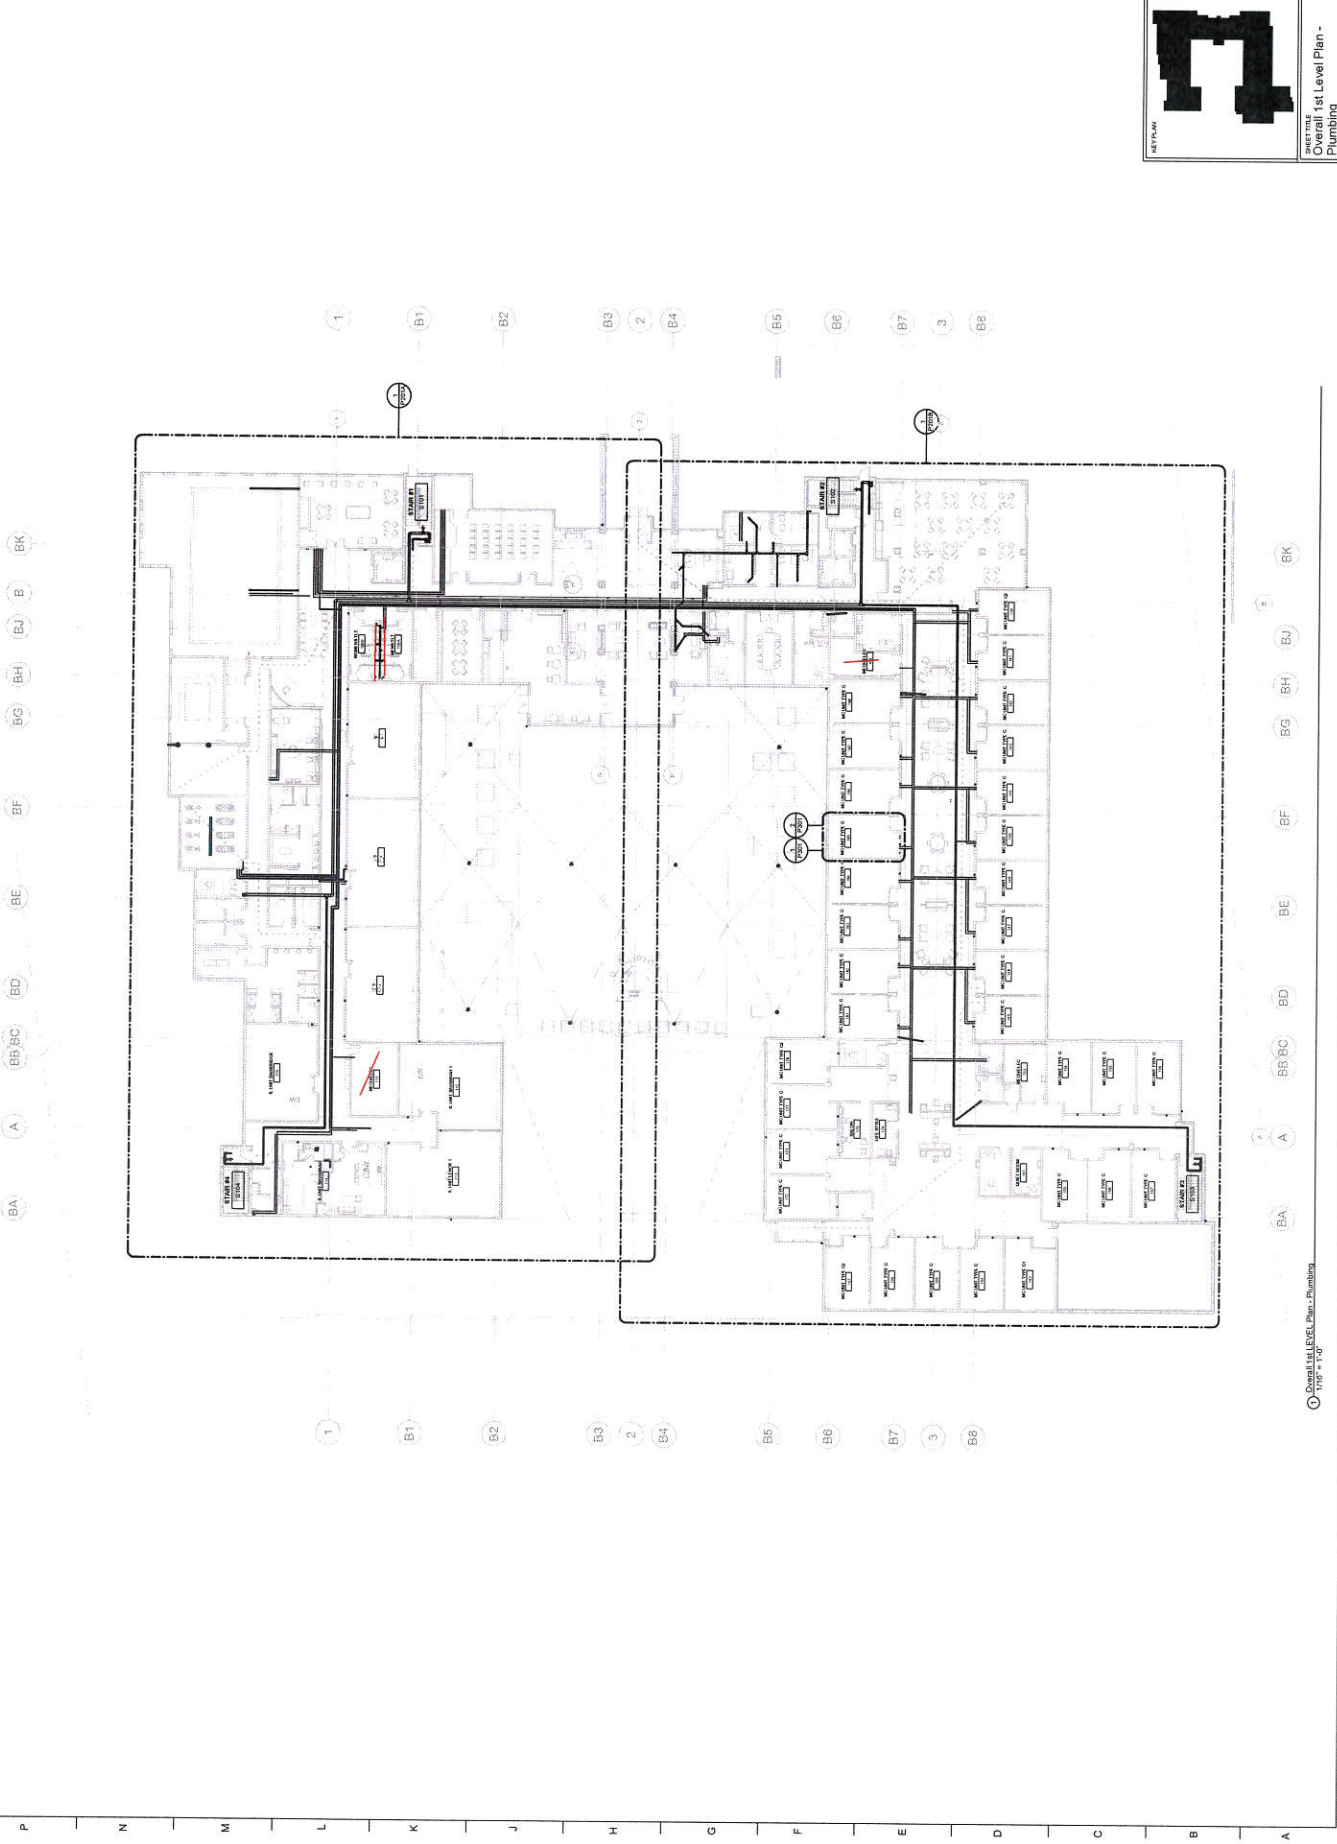

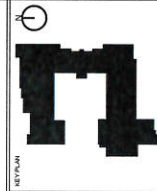


Overall 2nd Level Plan -
Plumbing

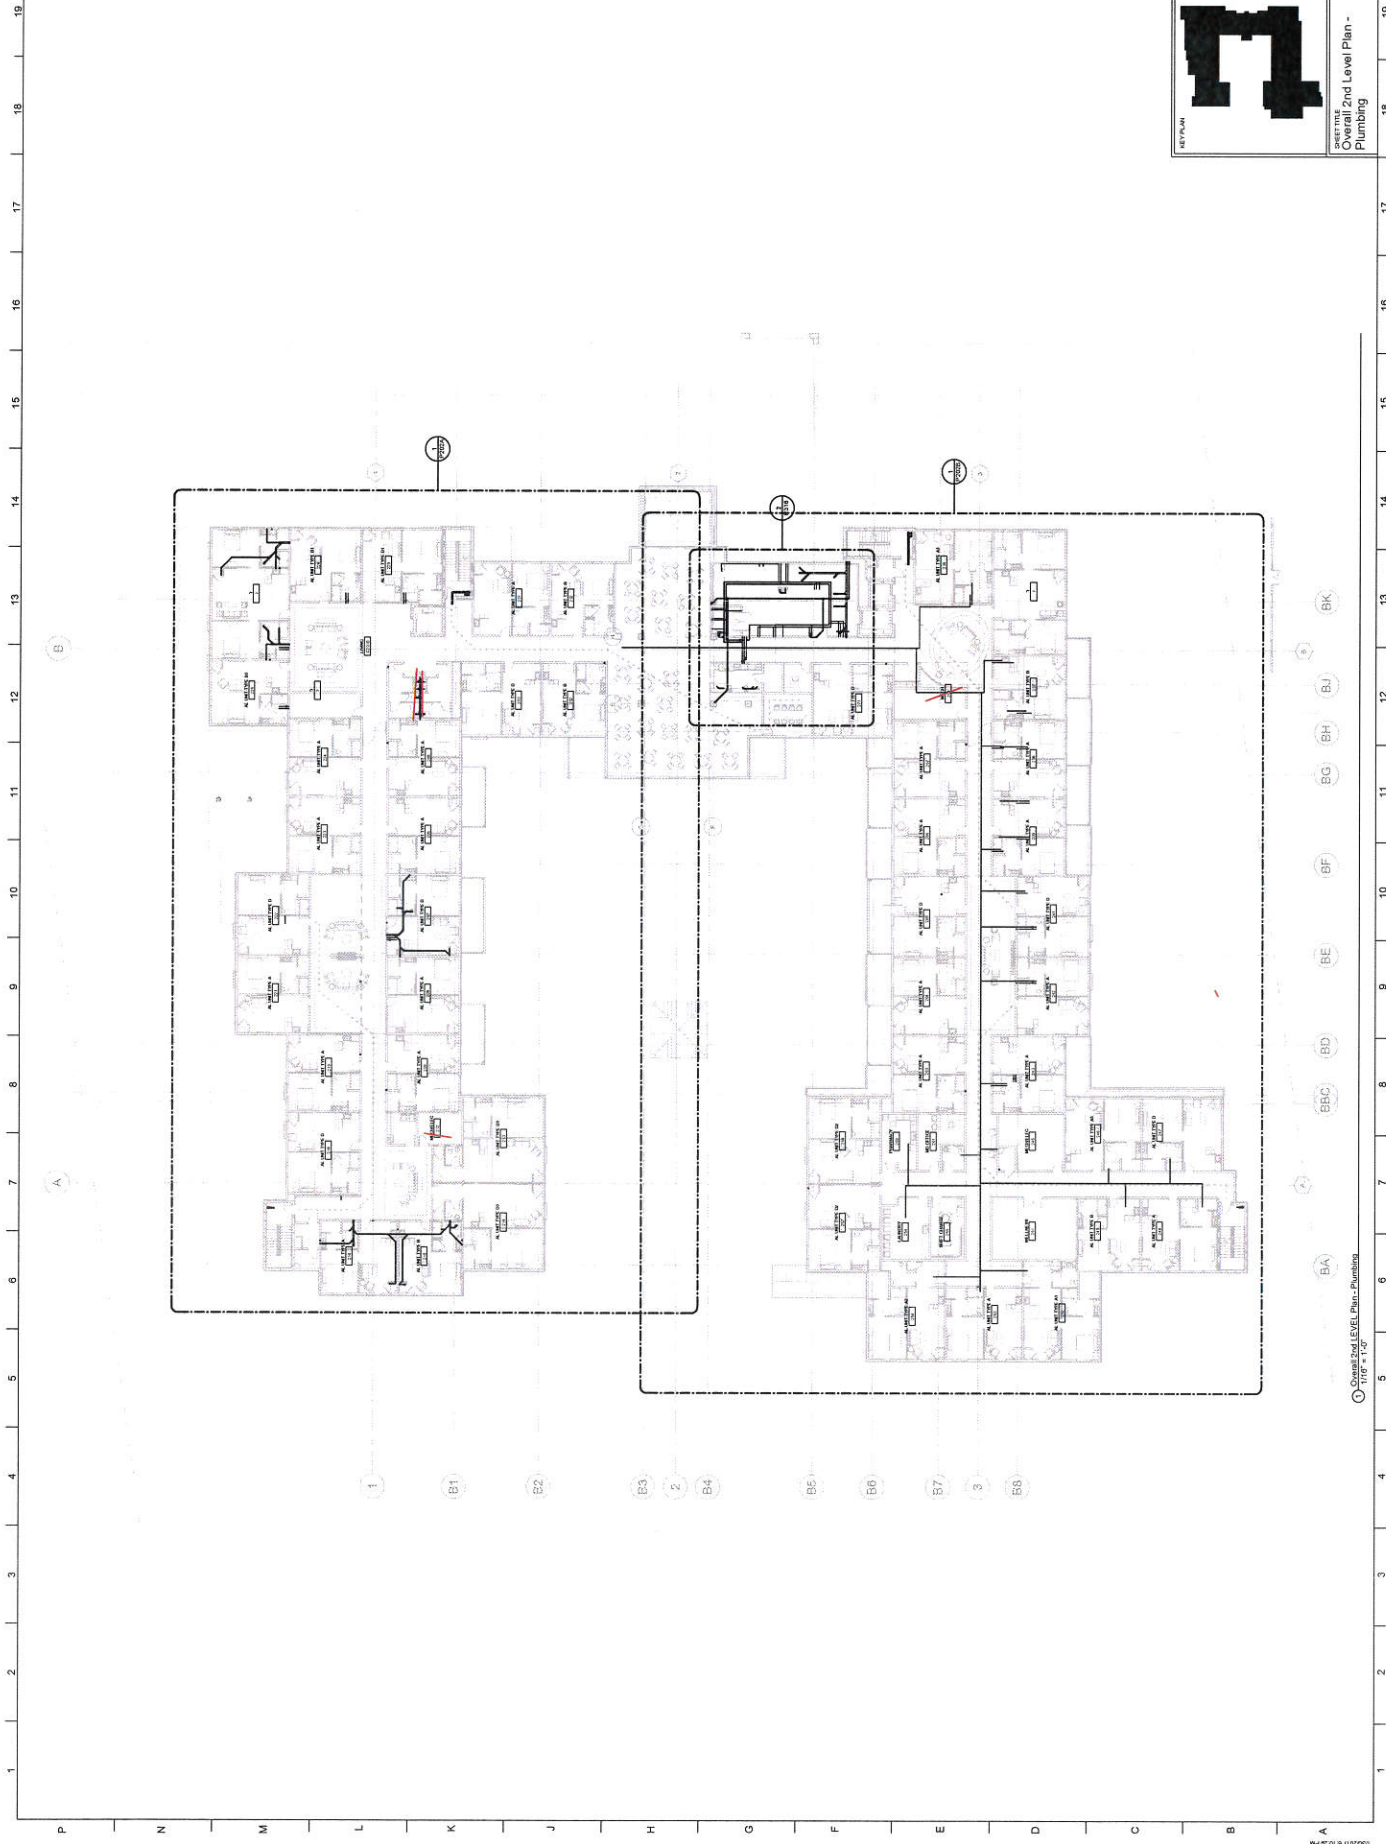


Overall 2nd Level Plan - Plumbing
1/16/17

NO.	DESCRIPTION	DATE
1	ISSUED FOR PERMIT	08/11/2011
2	ISSUED FOR PERMIT	08/11/2011
3	ISSUED FOR PERMIT	08/11/2011
4	ISSUED FOR PERMIT	08/11/2011
5	ISSUED FOR PERMIT	08/11/2011
6	ISSUED FOR PERMIT	08/11/2011
7	ISSUED FOR PERMIT	08/11/2011
8	ISSUED FOR PERMIT	08/11/2011
9	ISSUED FOR PERMIT	08/11/2011
10	ISSUED FOR PERMIT	08/11/2011
11	ISSUED FOR PERMIT	08/11/2011
12	ISSUED FOR PERMIT	08/11/2011
13	ISSUED FOR PERMIT	08/11/2011
14	ISSUED FOR PERMIT	08/11/2011
15	ISSUED FOR PERMIT	08/11/2011
16	ISSUED FOR PERMIT	08/11/2011
17	ISSUED FOR PERMIT	08/11/2011
18	ISSUED FOR PERMIT	08/11/2011
19	ISSUED FOR PERMIT	08/11/2011

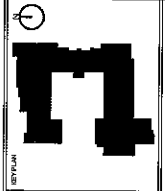


SHEET TITLE
**Overall 3rd Level Plan -
 Plumbing**

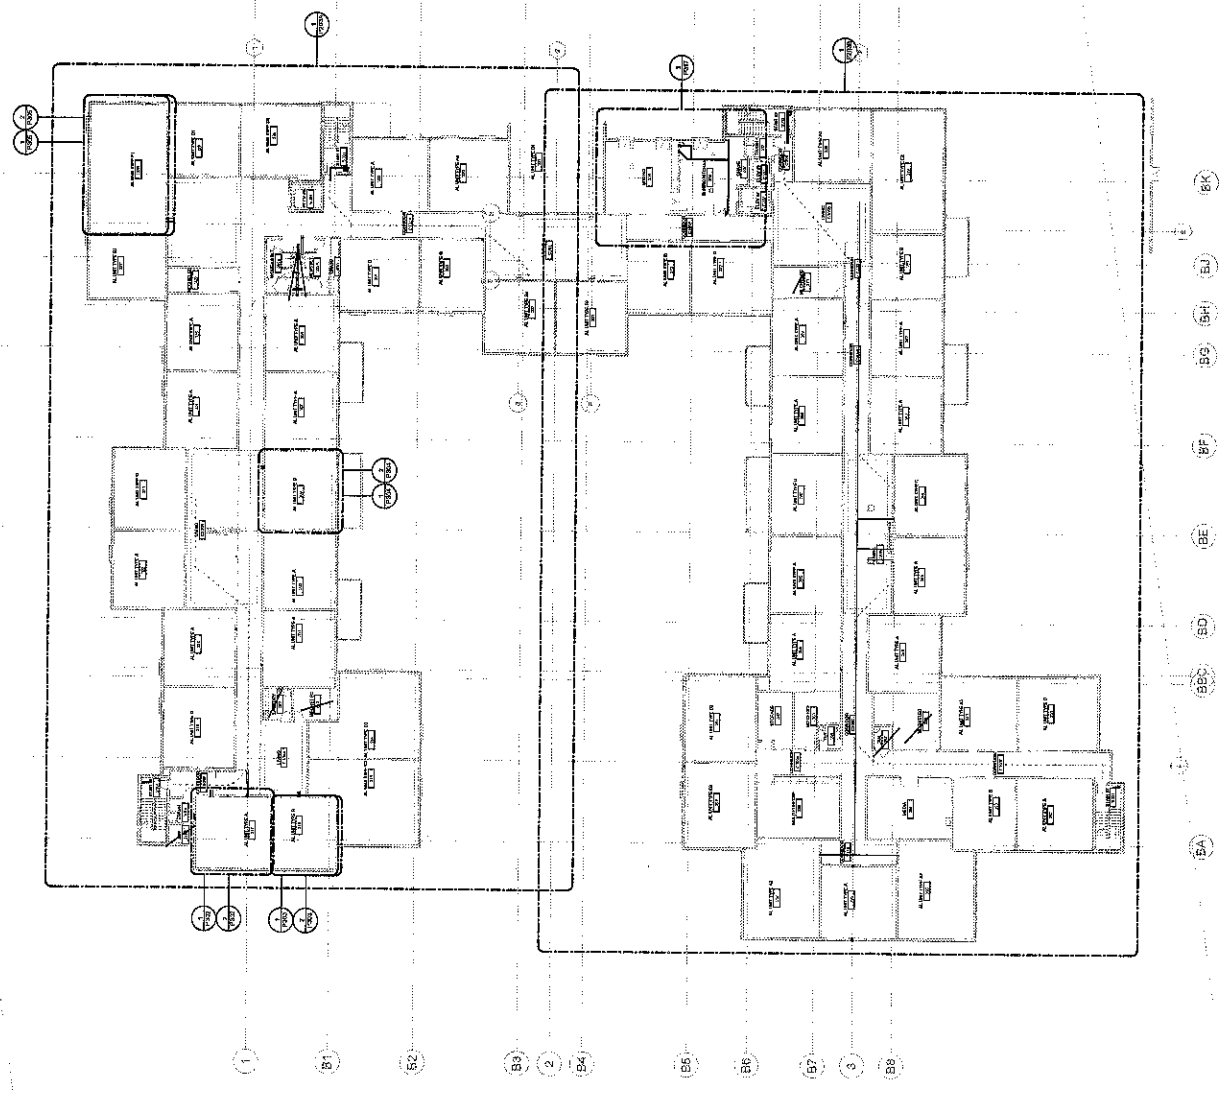


Original and Plan - Plumbing
 V10-11-11

1	2	3	4	5	6	7	8	9	10	11	12	13	14	15	16	17	18	19

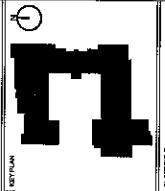

4th Level Plan - Plumbing

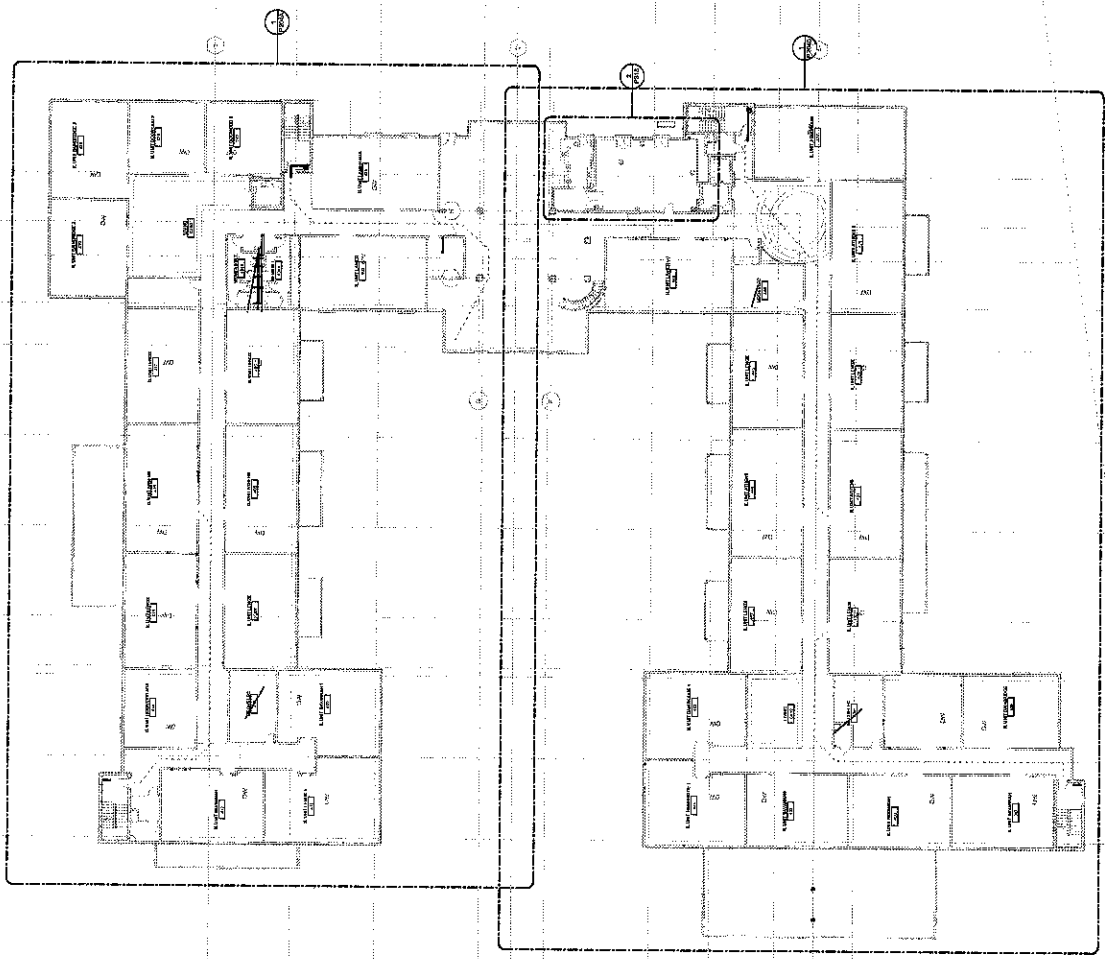

- BA
- BB
- BC
- BD
- BE
- BF
- BG
- BH
- BI
- BJ
- BK

① 4th Level Plan - Plumbing
 11/18/17


1. L&S DESIGN	2. 10/1/2016
3.	
4.	
5.	
6.	
7.	
8.	
9.	
10.	
11.	
12.	
13.	
14.	
15.	
16.	
17.	
18.	
19.	

PROJECT NO. 15002
 SHEET NO. P105
 DRAWING NUMBER

P105




Overall 5th Level Plan - Plumbing

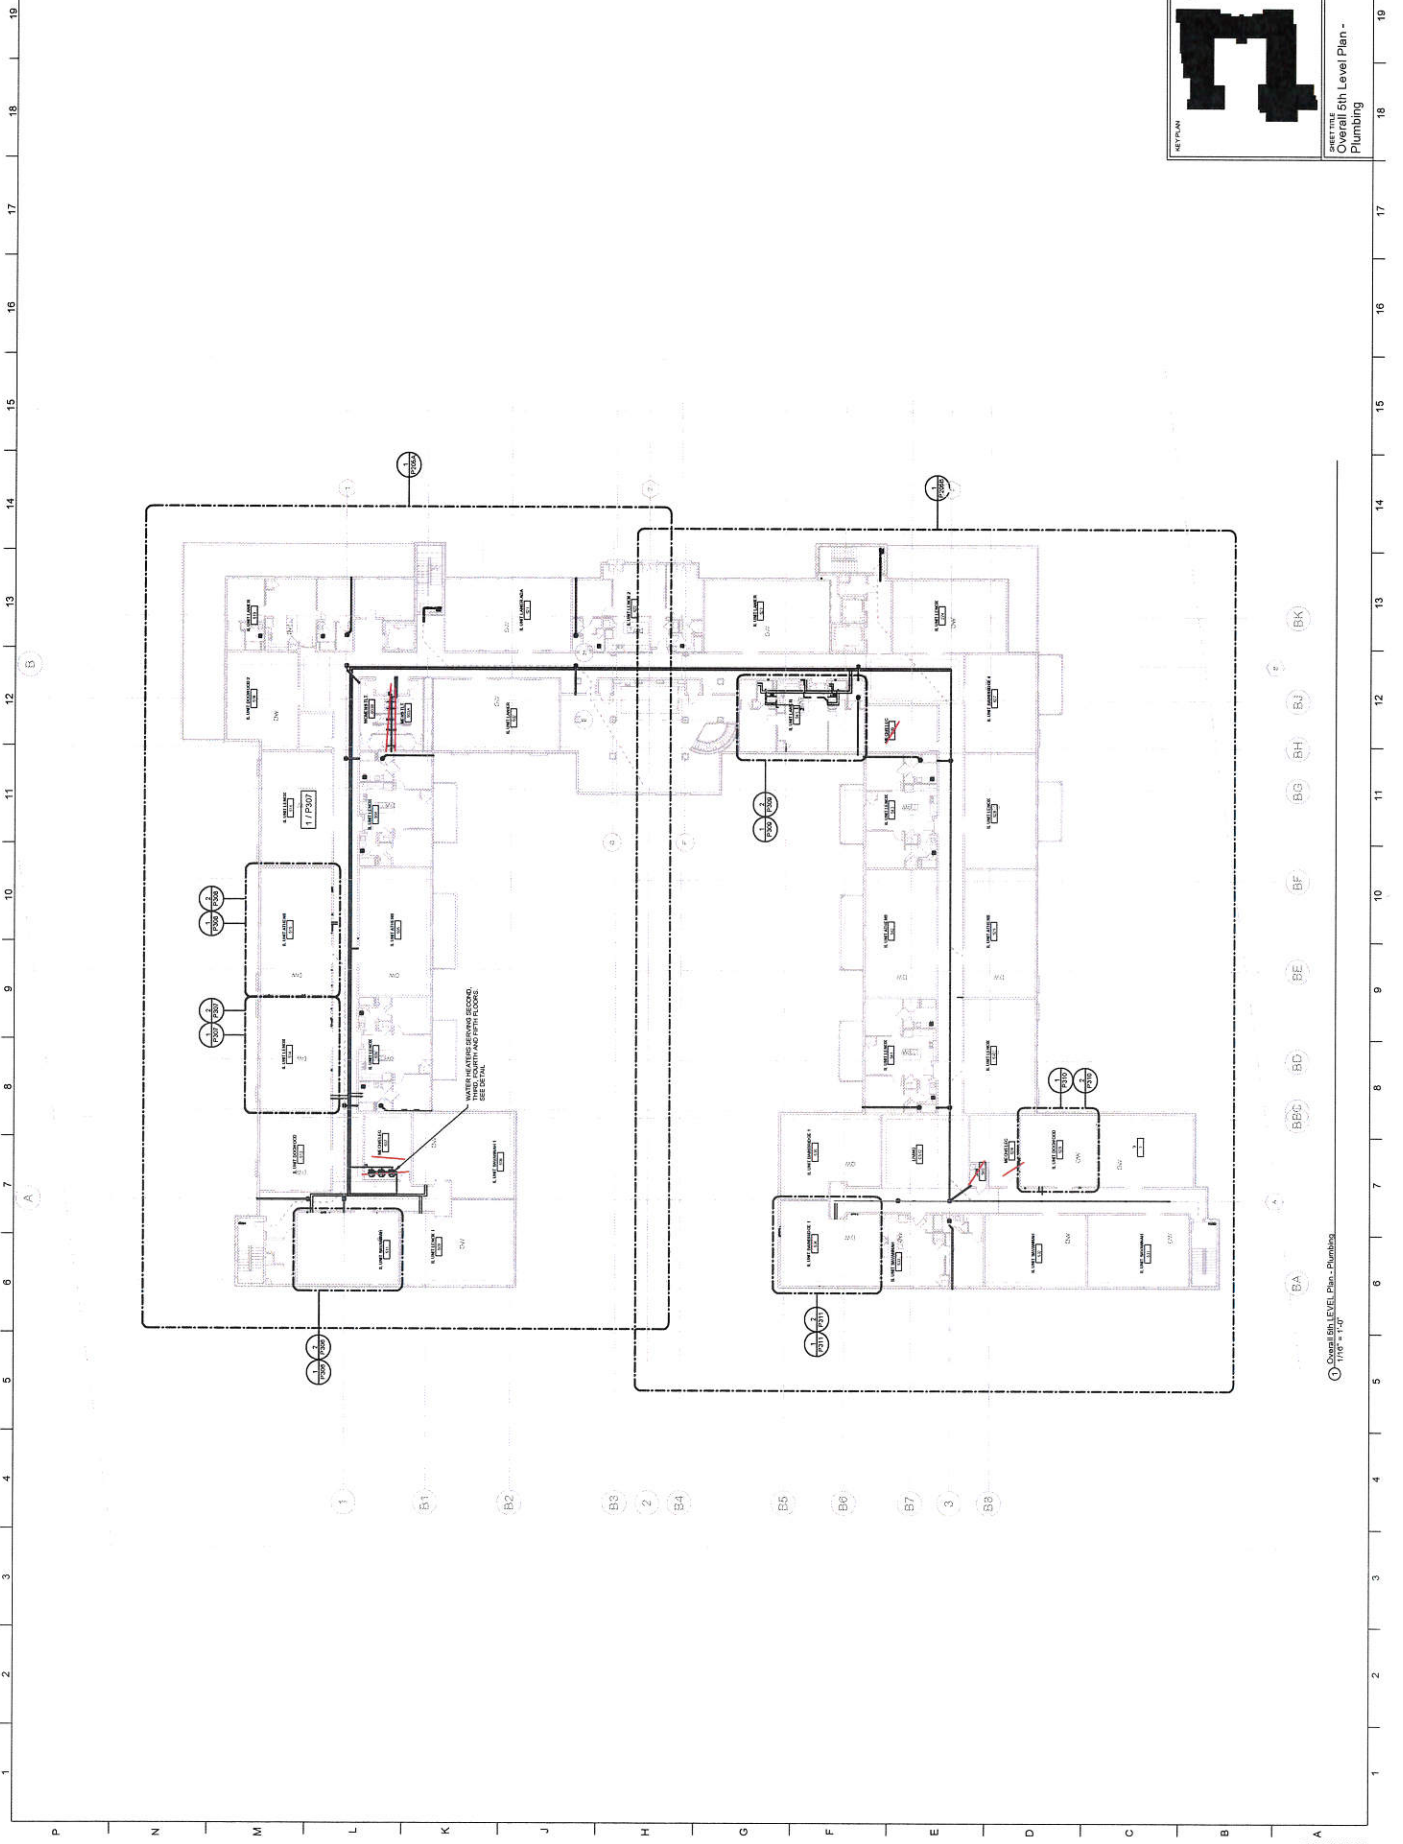


Overall 5th Level Plan - Plumbing
 1/16 - 1/17


NO.	DESCRIPTION	DATE
1	ISSUED FOR PERMIT	10/15/2018
2	REVISION	
3	REVISION	
4	REVISION	
5	REVISION	
6	REVISION	
7	REVISION	
8	REVISION	
9	REVISION	
10	REVISION	

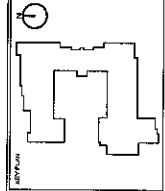


PERMIT
 OVERLAP
 PLUMBING

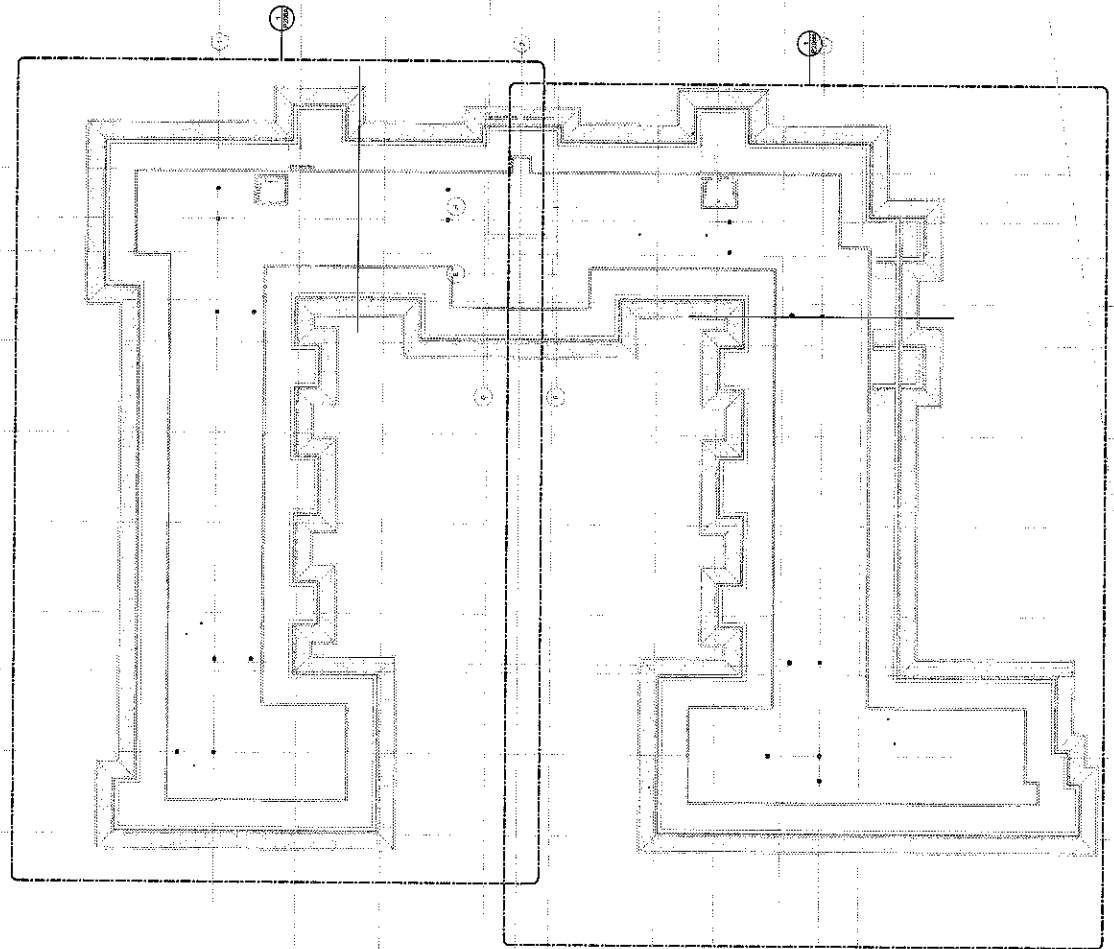


Overall Base Level Elev. - 11.00'

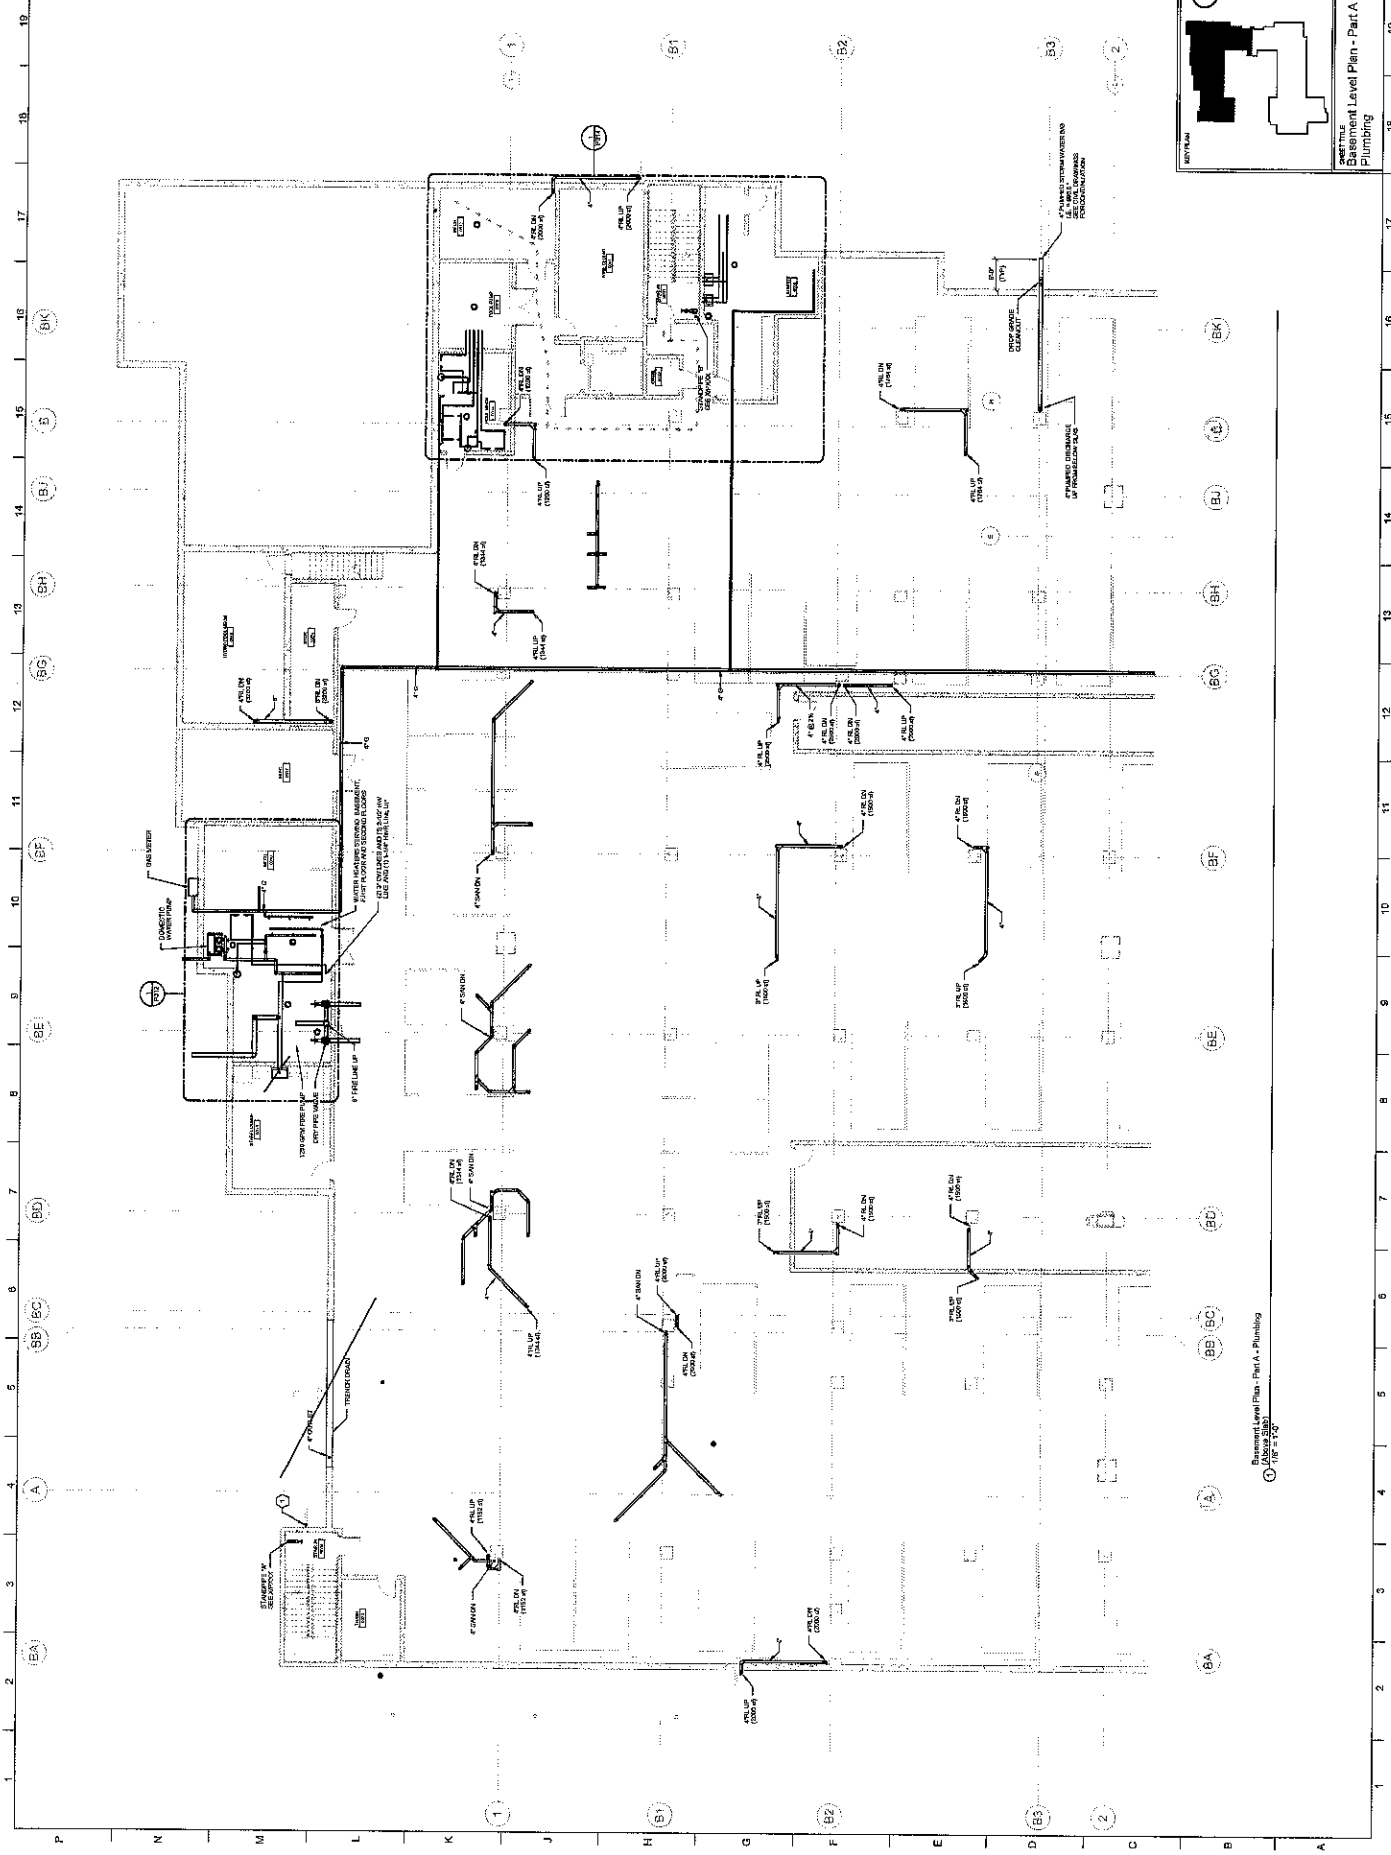


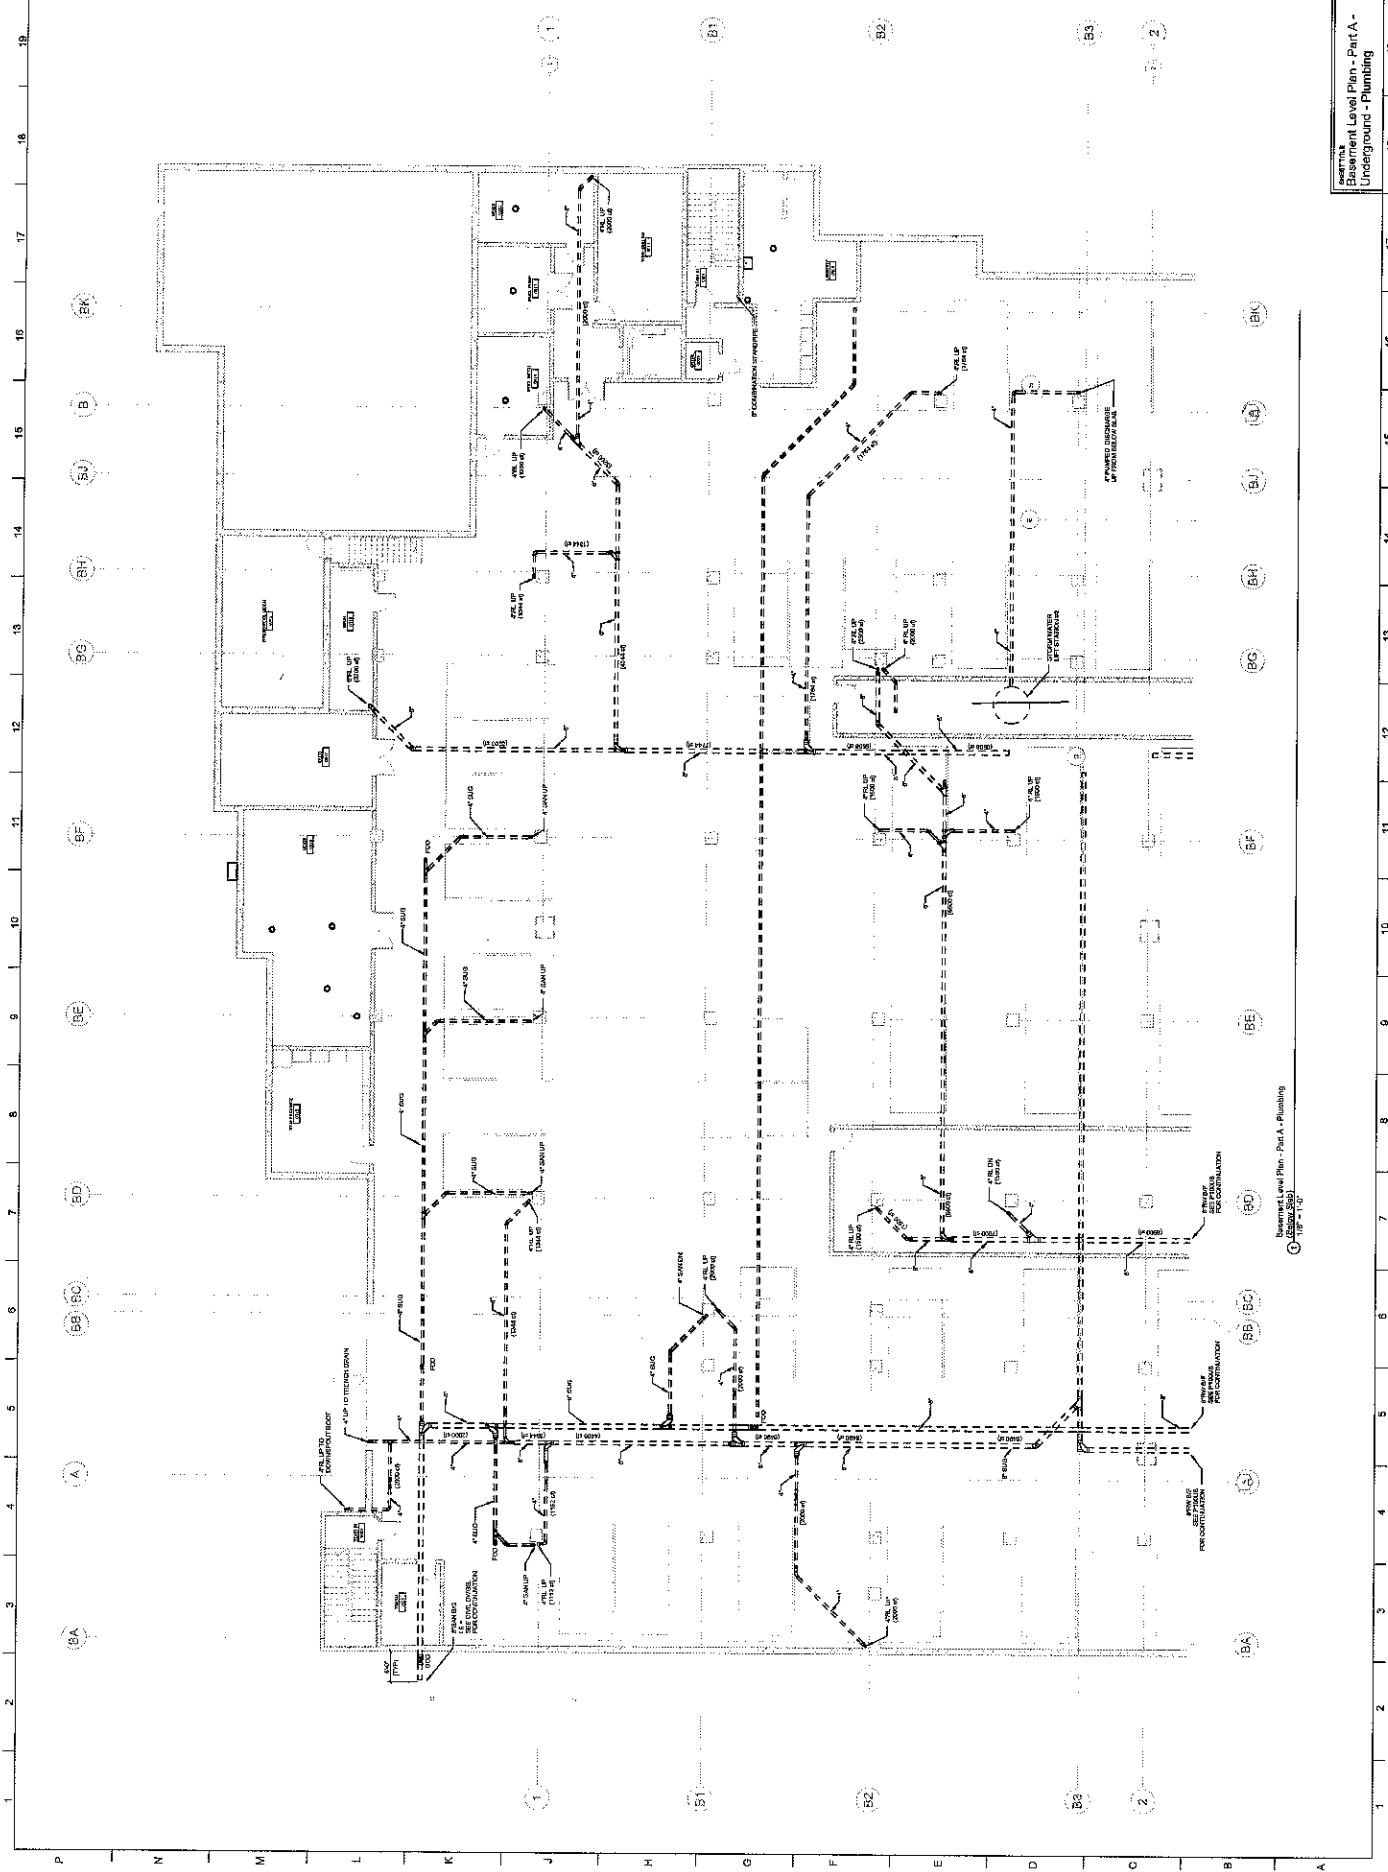

NO.	DESCRIPTION	DATE
1	ISSUED FOR PERMIT	10/15/2019
2	ISSUED FOR CONSTRUCTION	11/01/2019
3	ISSUED FOR AS-BUILT	12/01/2019
4	ISSUED FOR FINAL	01/01/2020
5	ISSUED FOR RECORD	02/01/2020

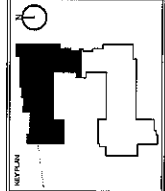

Basement Level Plan - Part B - Plumbing

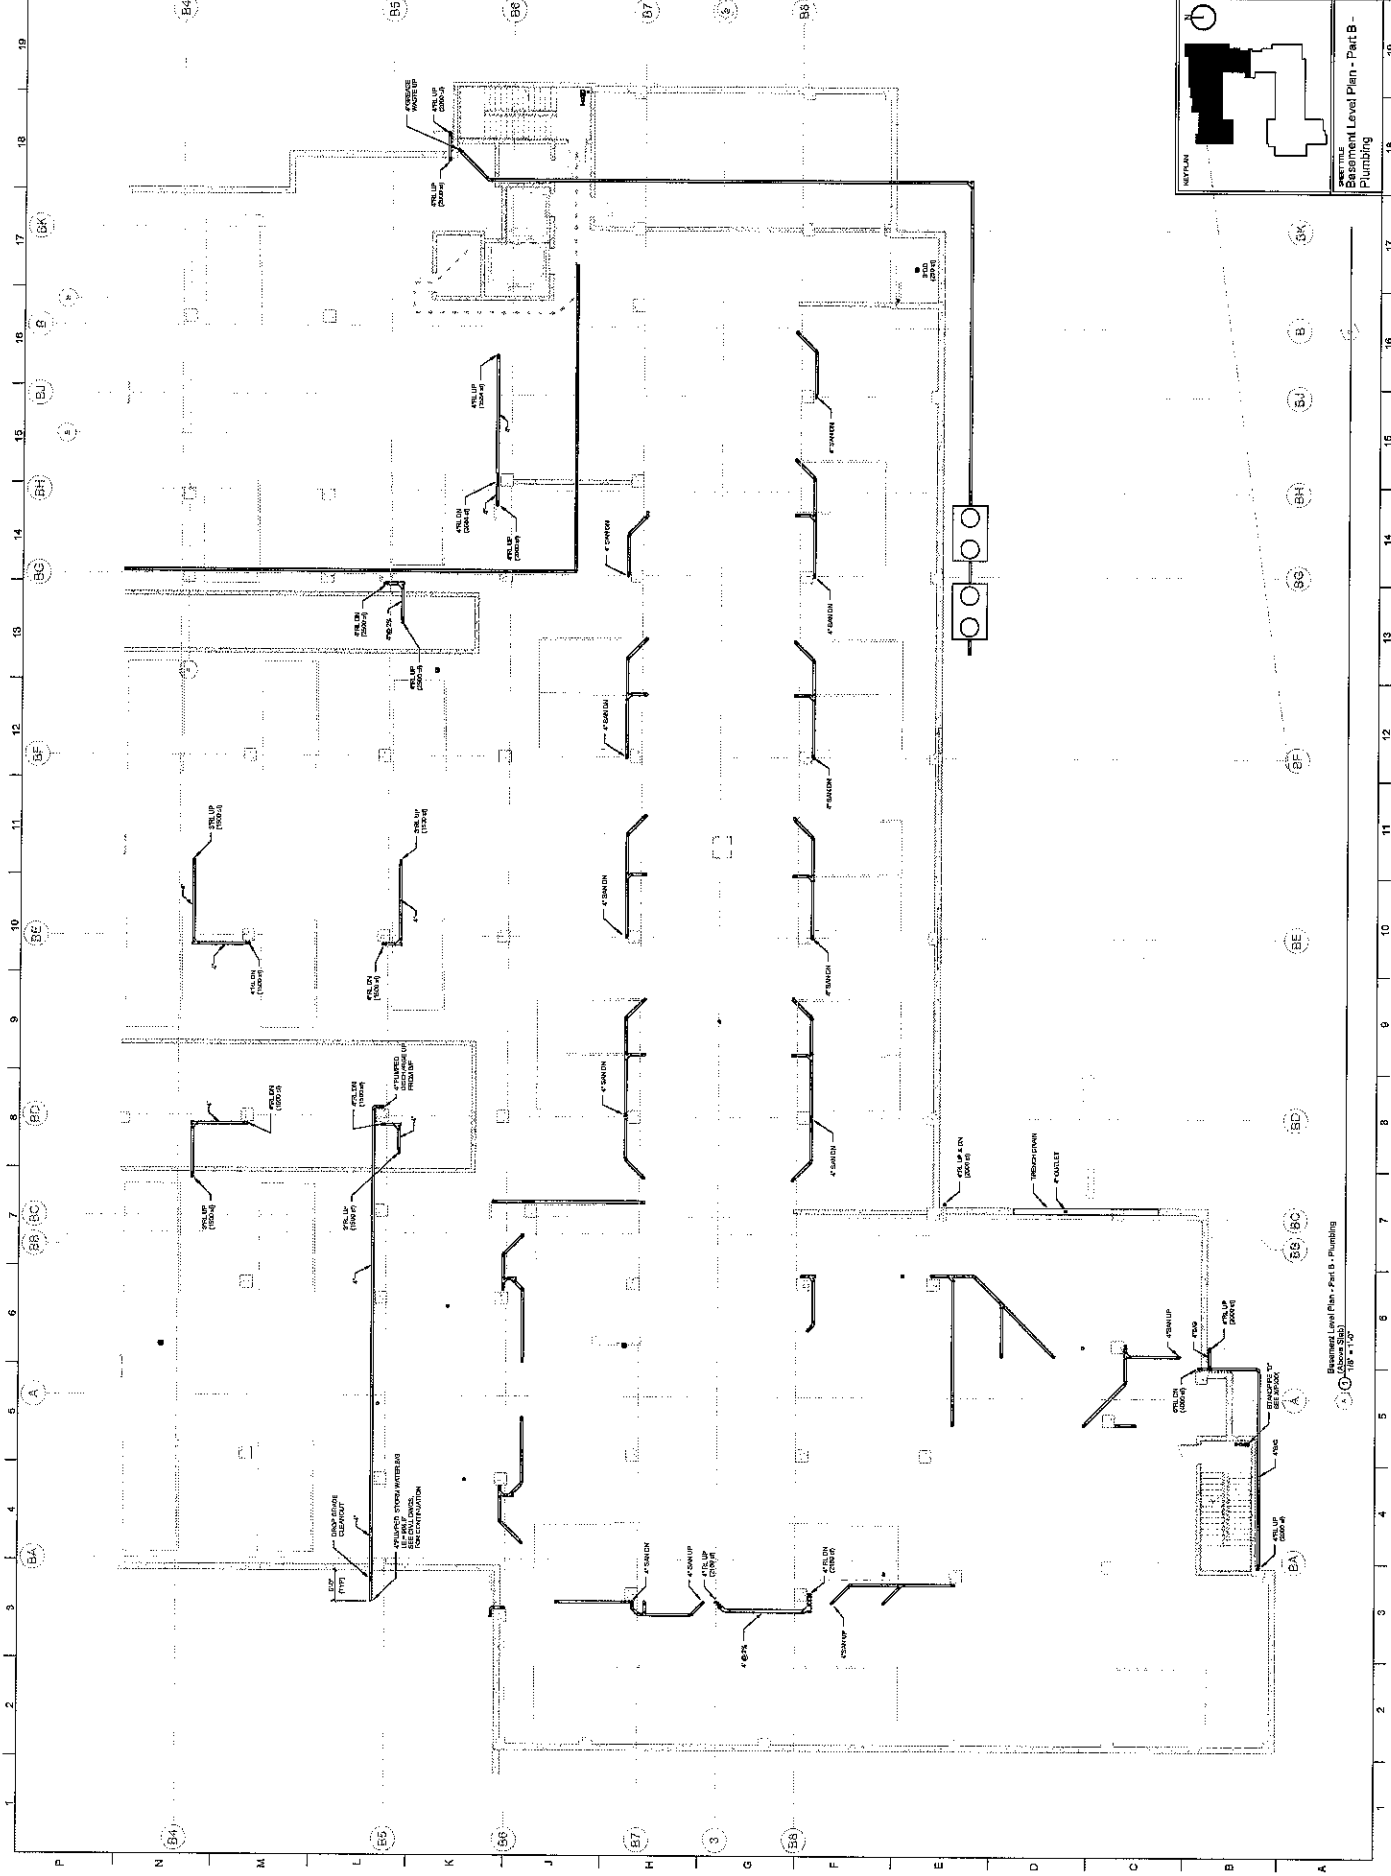

Basement Level Plan - Part B - Plumbing



ARCHITECTURE
ENGINEERING
PLANNING




THE HOLBROOK OF DECATUR

1833 Calhoun Road, Decatur, Georgia
1833 Calhoun Road, Decatur, Georgia



P200BU

Basement Level Plan - Part B - Plumbing
Underground - Plumbing

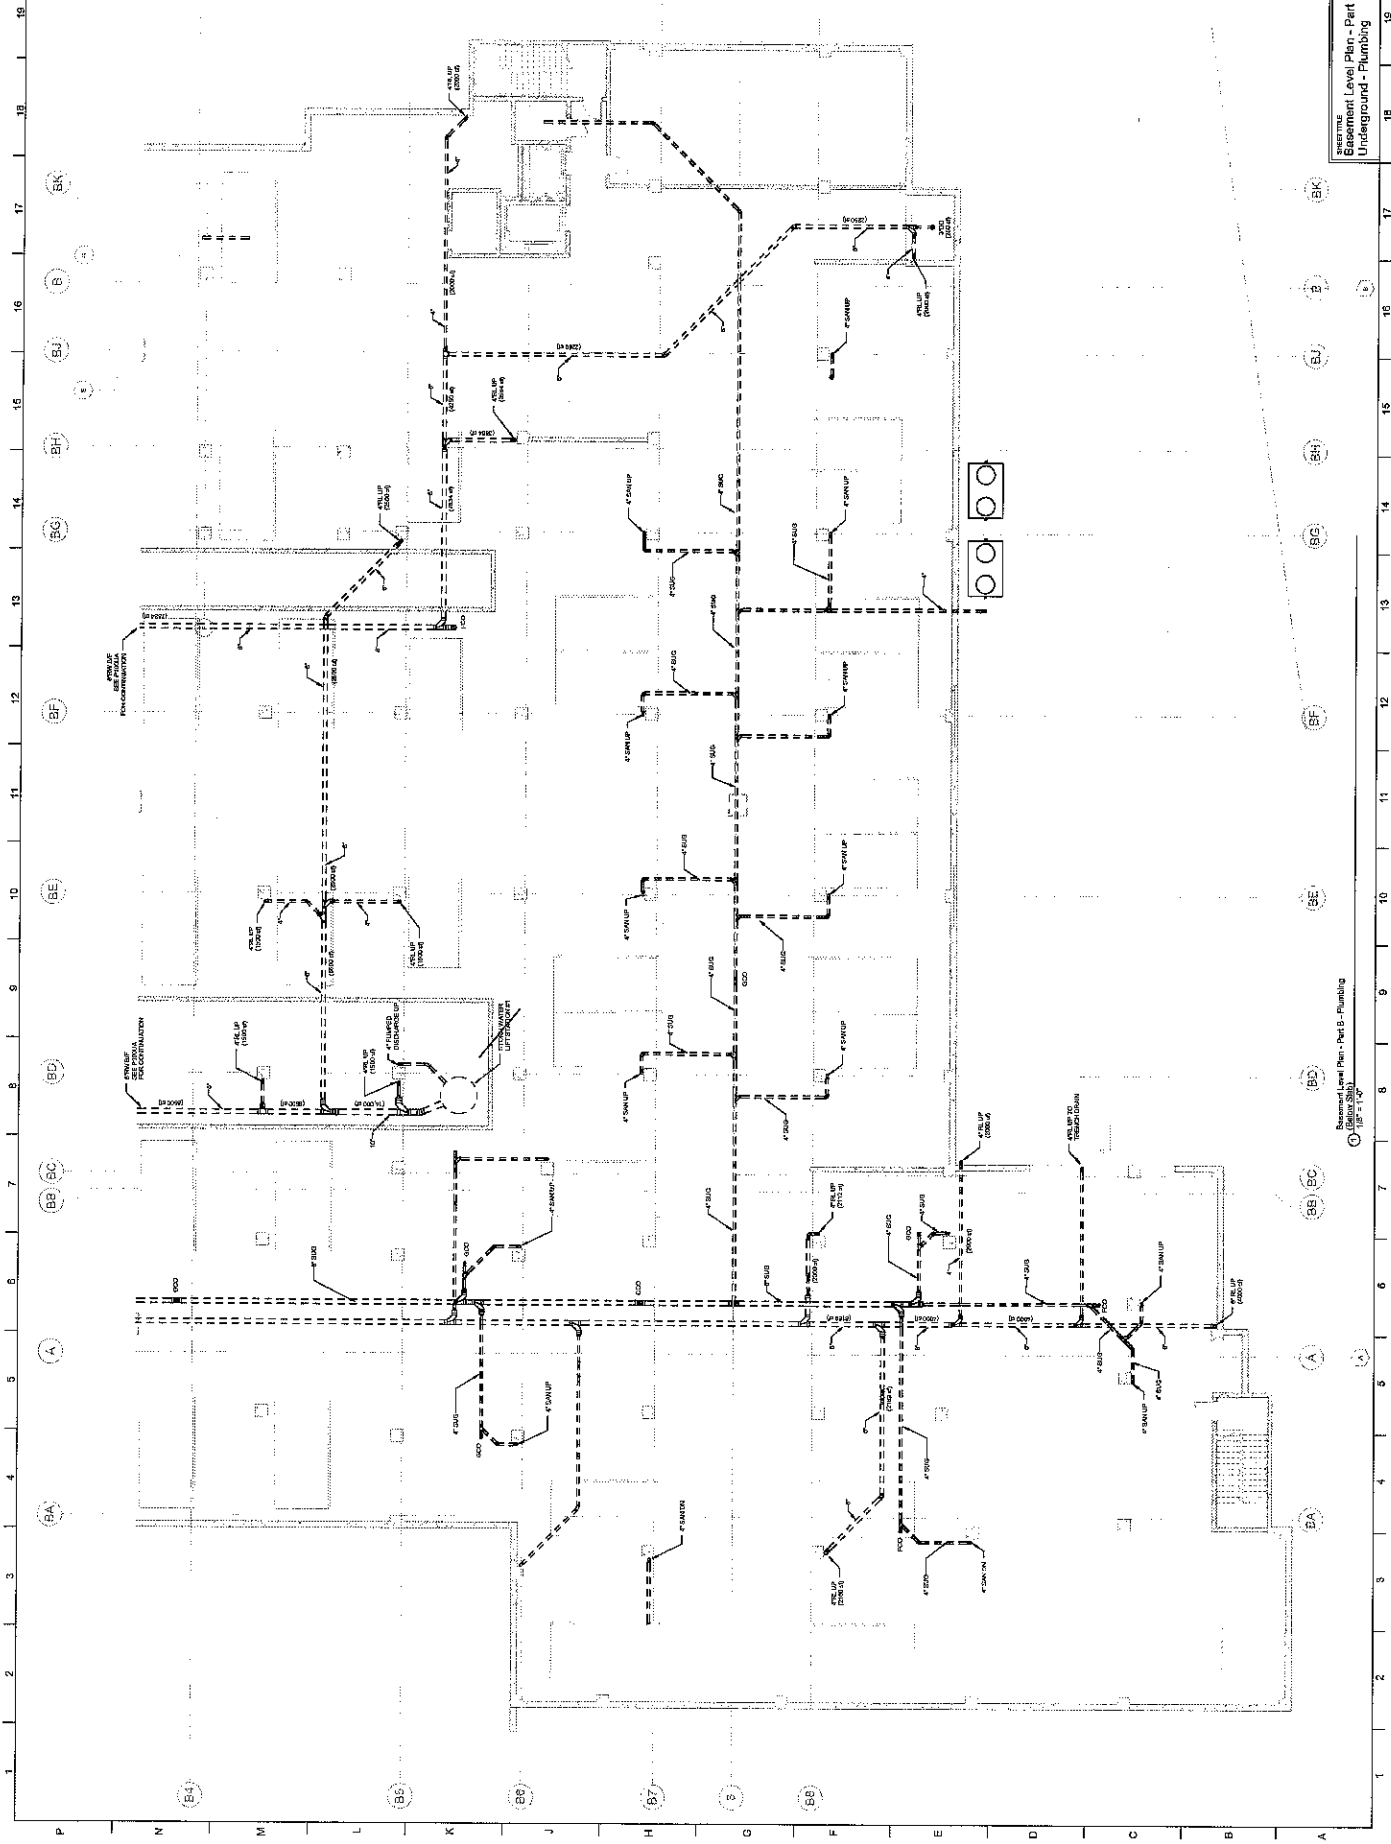



1	2	3	4	5	6	7	8	9	10	11	12	13	14	15	16	17	18	19
A	B	C	D	E	F	G	H	I	J	K	L	M	N	O	P	Q	R	S

SHEET TITLE
1st Level Plan - Part A -
Plumbing

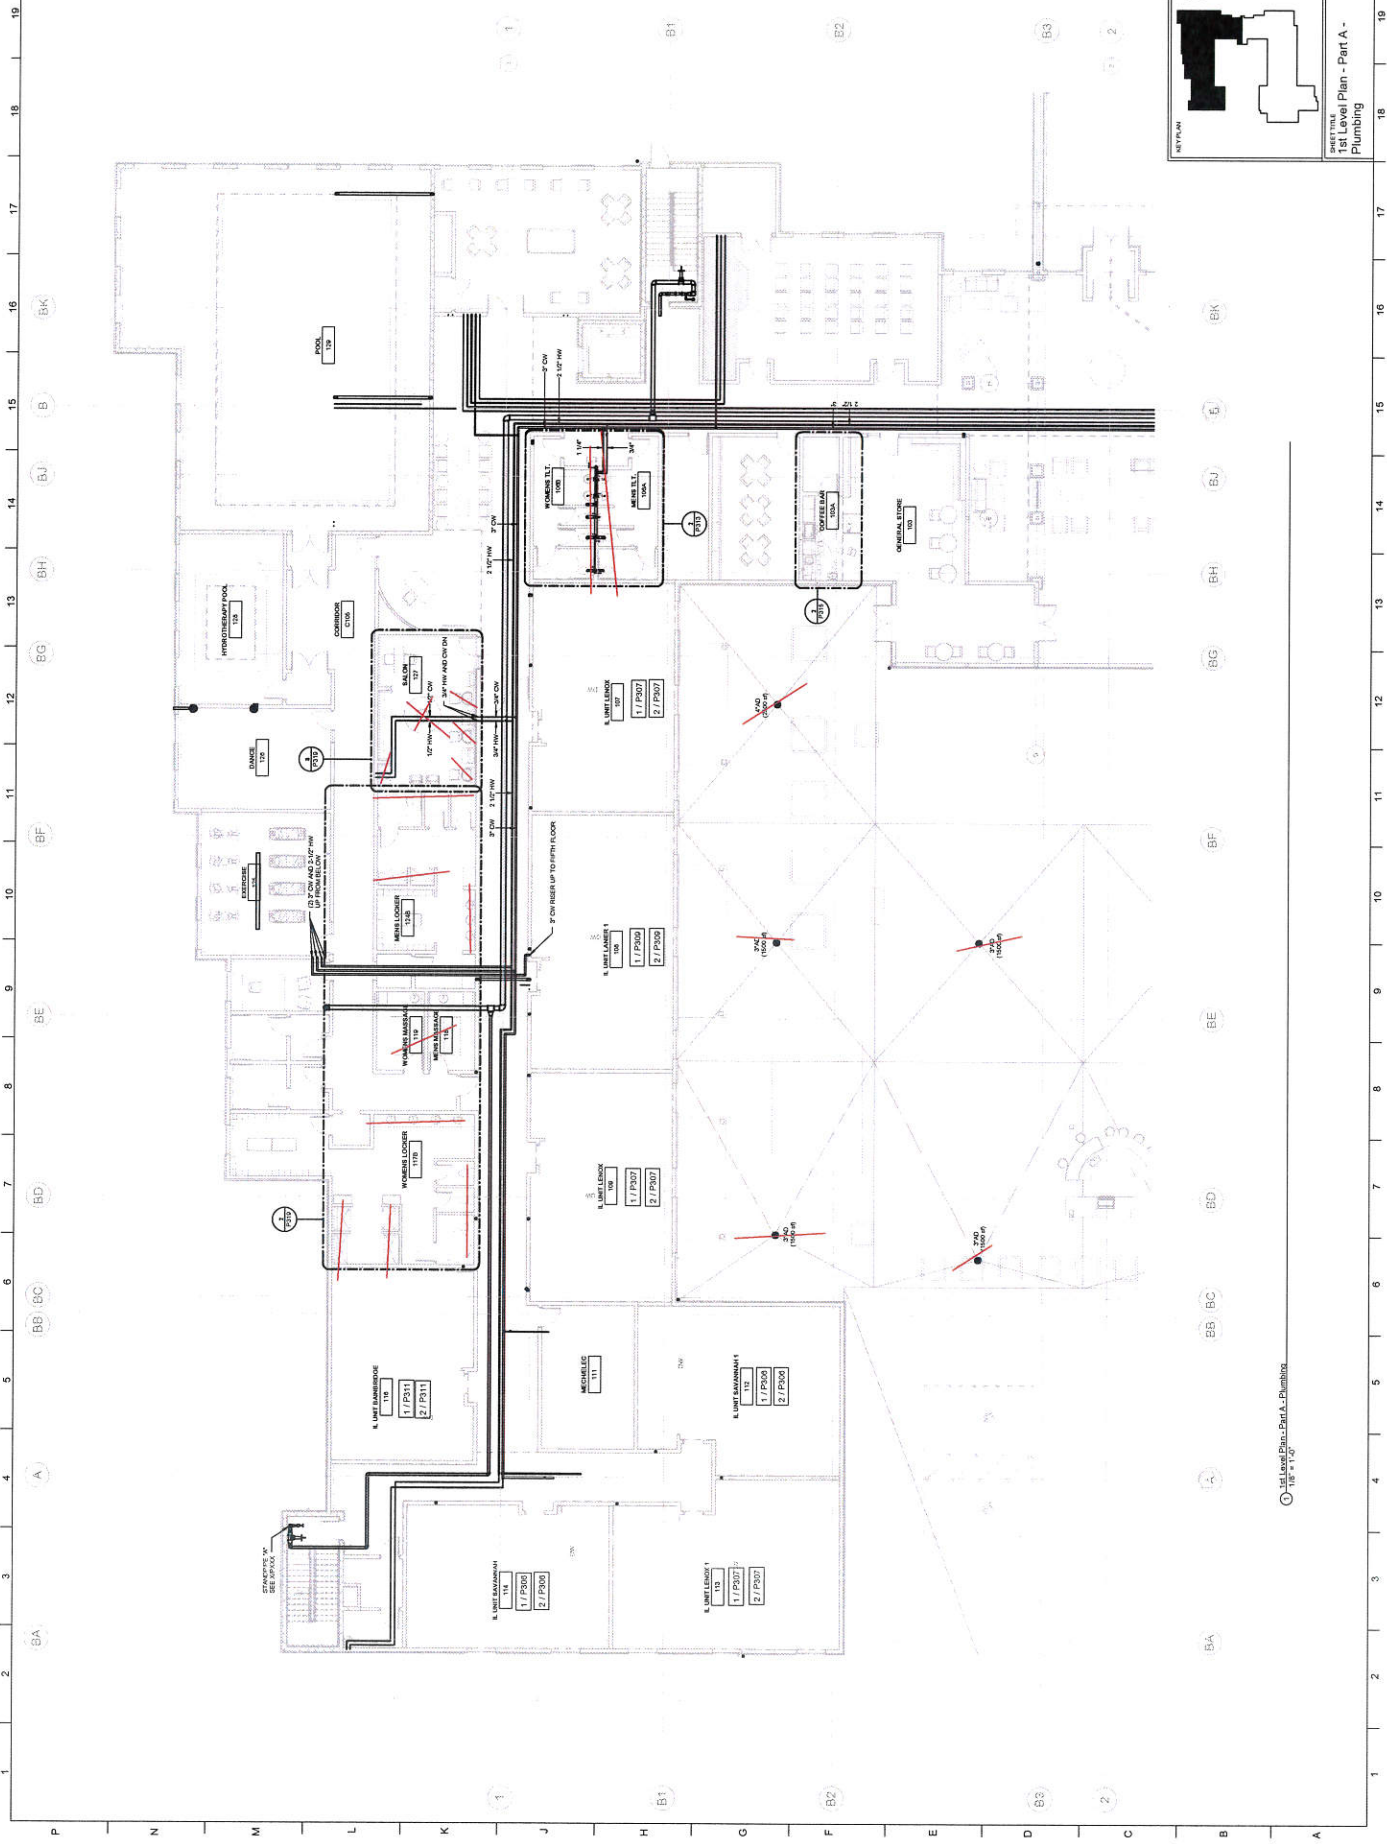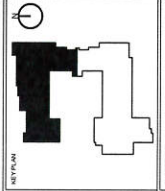

1st Level Plan - Part A - Plumbing
10/11/17



PROJECT NO.	1000000000
DATE	03/20/2018
PROJECT NAME	THE HOLBROOK OF DECATUR
PROJECT LOCATION	1622 Clairmont Road, Decatur, Georgia
PROJECT OWNER	Solomon Development Services, LLC
PROJECT ARCHITECT	CDH PARTNERS
PROJECT ENGINEER	CDH PARTNERS
PROJECT INTERIOR DESIGNER	CDH PARTNERS
PROJECT PLANNER	CDH PARTNERS

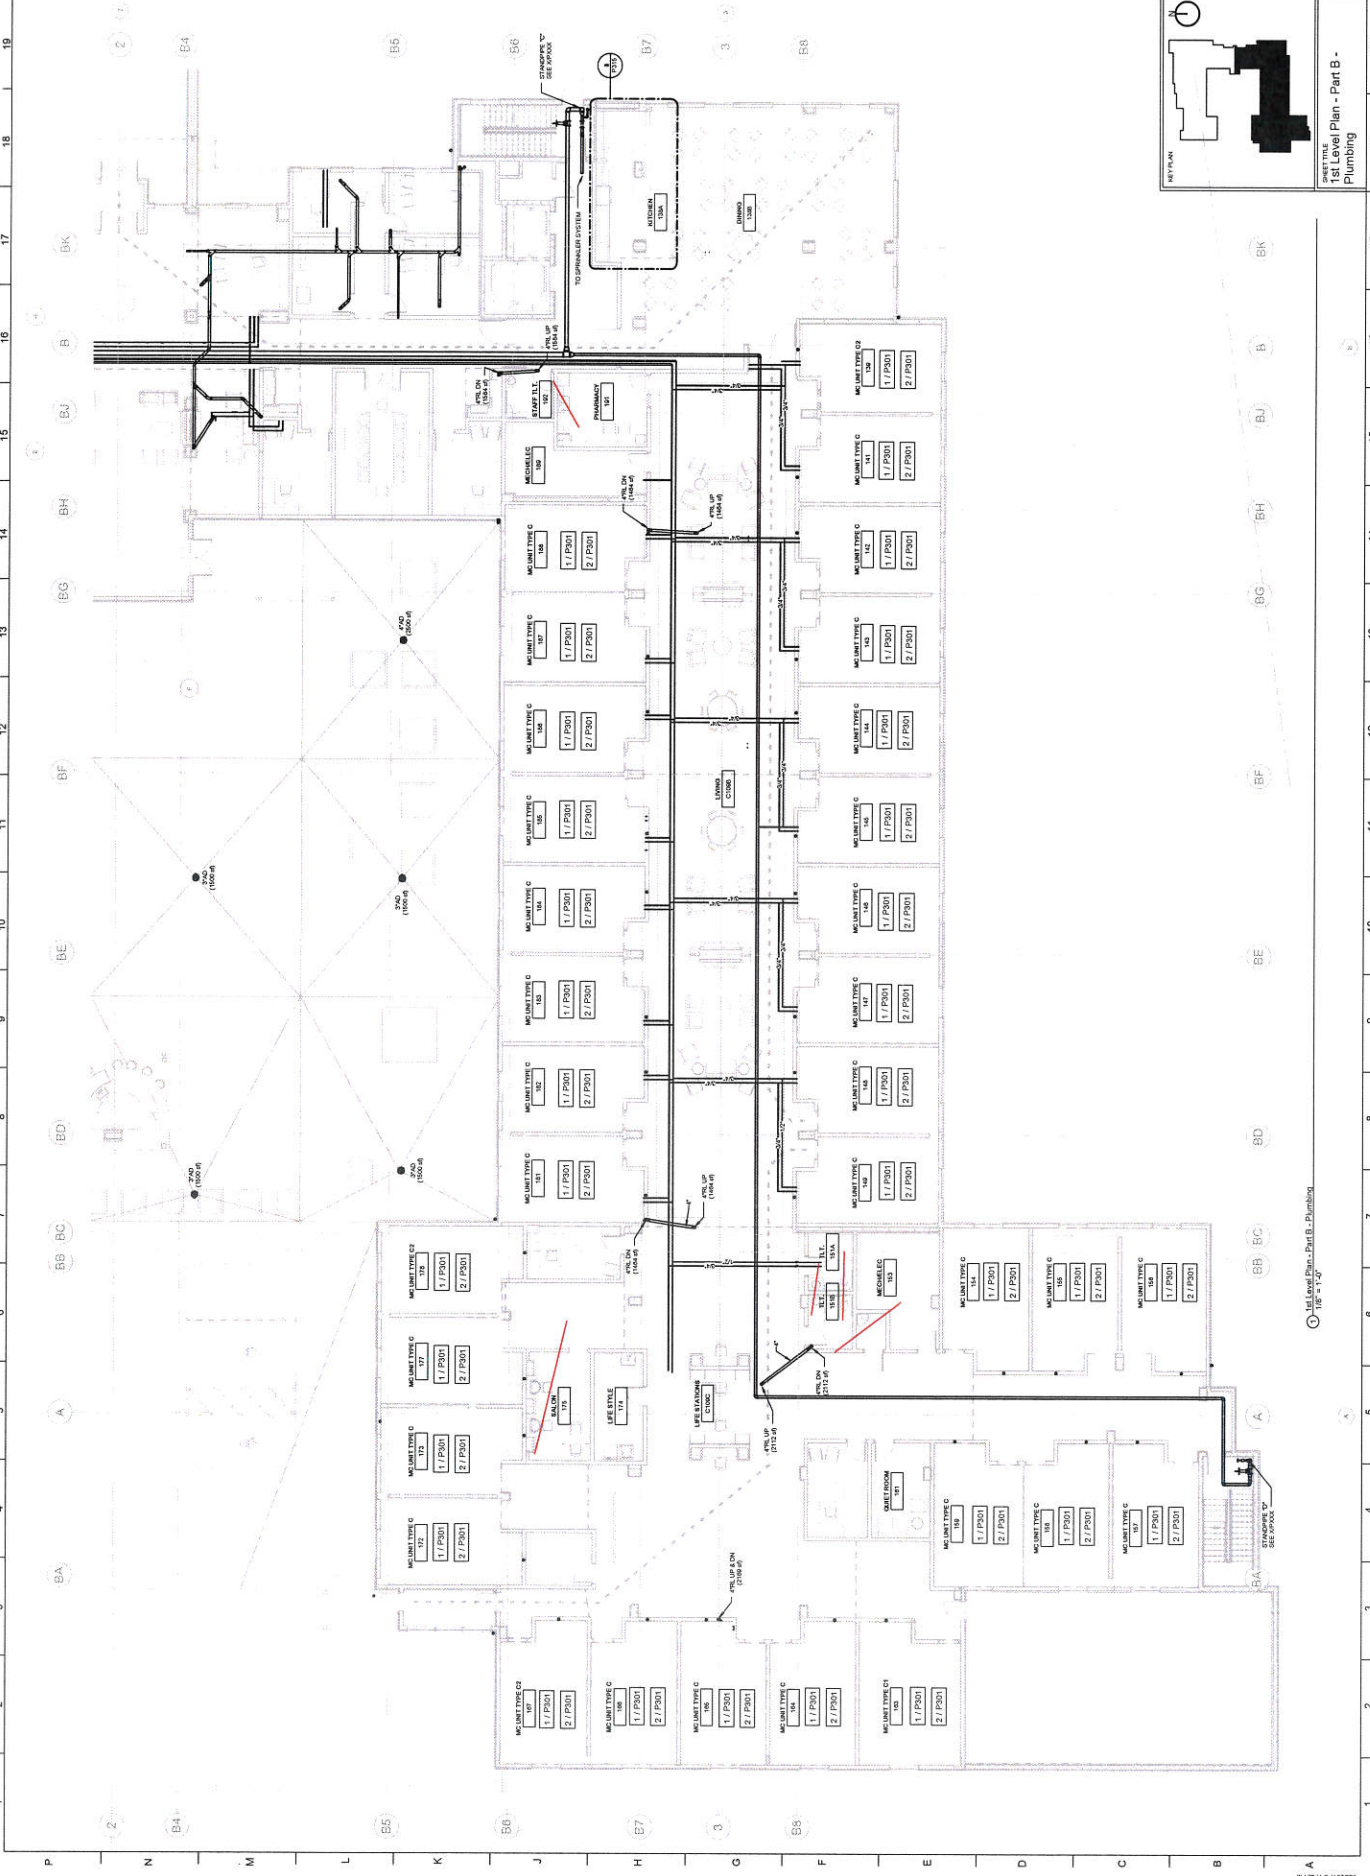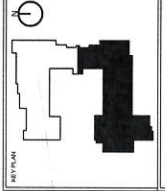

1st Level Plan - Part B - Plumbing
1/8" = 1'-0"



1. SCHED. DESIGN	10/27/2016
2. SCHED. DESIGN	10/27/2016
3. SCHED. DESIGN	10/27/2016
4. SCHED. DESIGN	10/27/2016
5. SCHED. DESIGN	10/27/2016
6. SCHED. DESIGN	10/27/2016
7. SCHED. DESIGN	10/27/2016
8. SCHED. DESIGN	10/27/2016
9. SCHED. DESIGN	10/27/2016
10. SCHED. DESIGN	10/27/2016
11. SCHED. DESIGN	10/27/2016
12. SCHED. DESIGN	10/27/2016
13. SCHED. DESIGN	10/27/2016
14. SCHED. DESIGN	10/27/2016
15. SCHED. DESIGN	10/27/2016
16. SCHED. DESIGN	10/27/2016
17. SCHED. DESIGN	10/27/2016
18. SCHED. DESIGN	10/27/2016
19. SCHED. DESIGN	10/27/2016

PROJECT NO.	1002
DATE	10/27/2016
DESIGNED BY	CDH
CHECKED BY	CDH
APPROVED BY	CDH

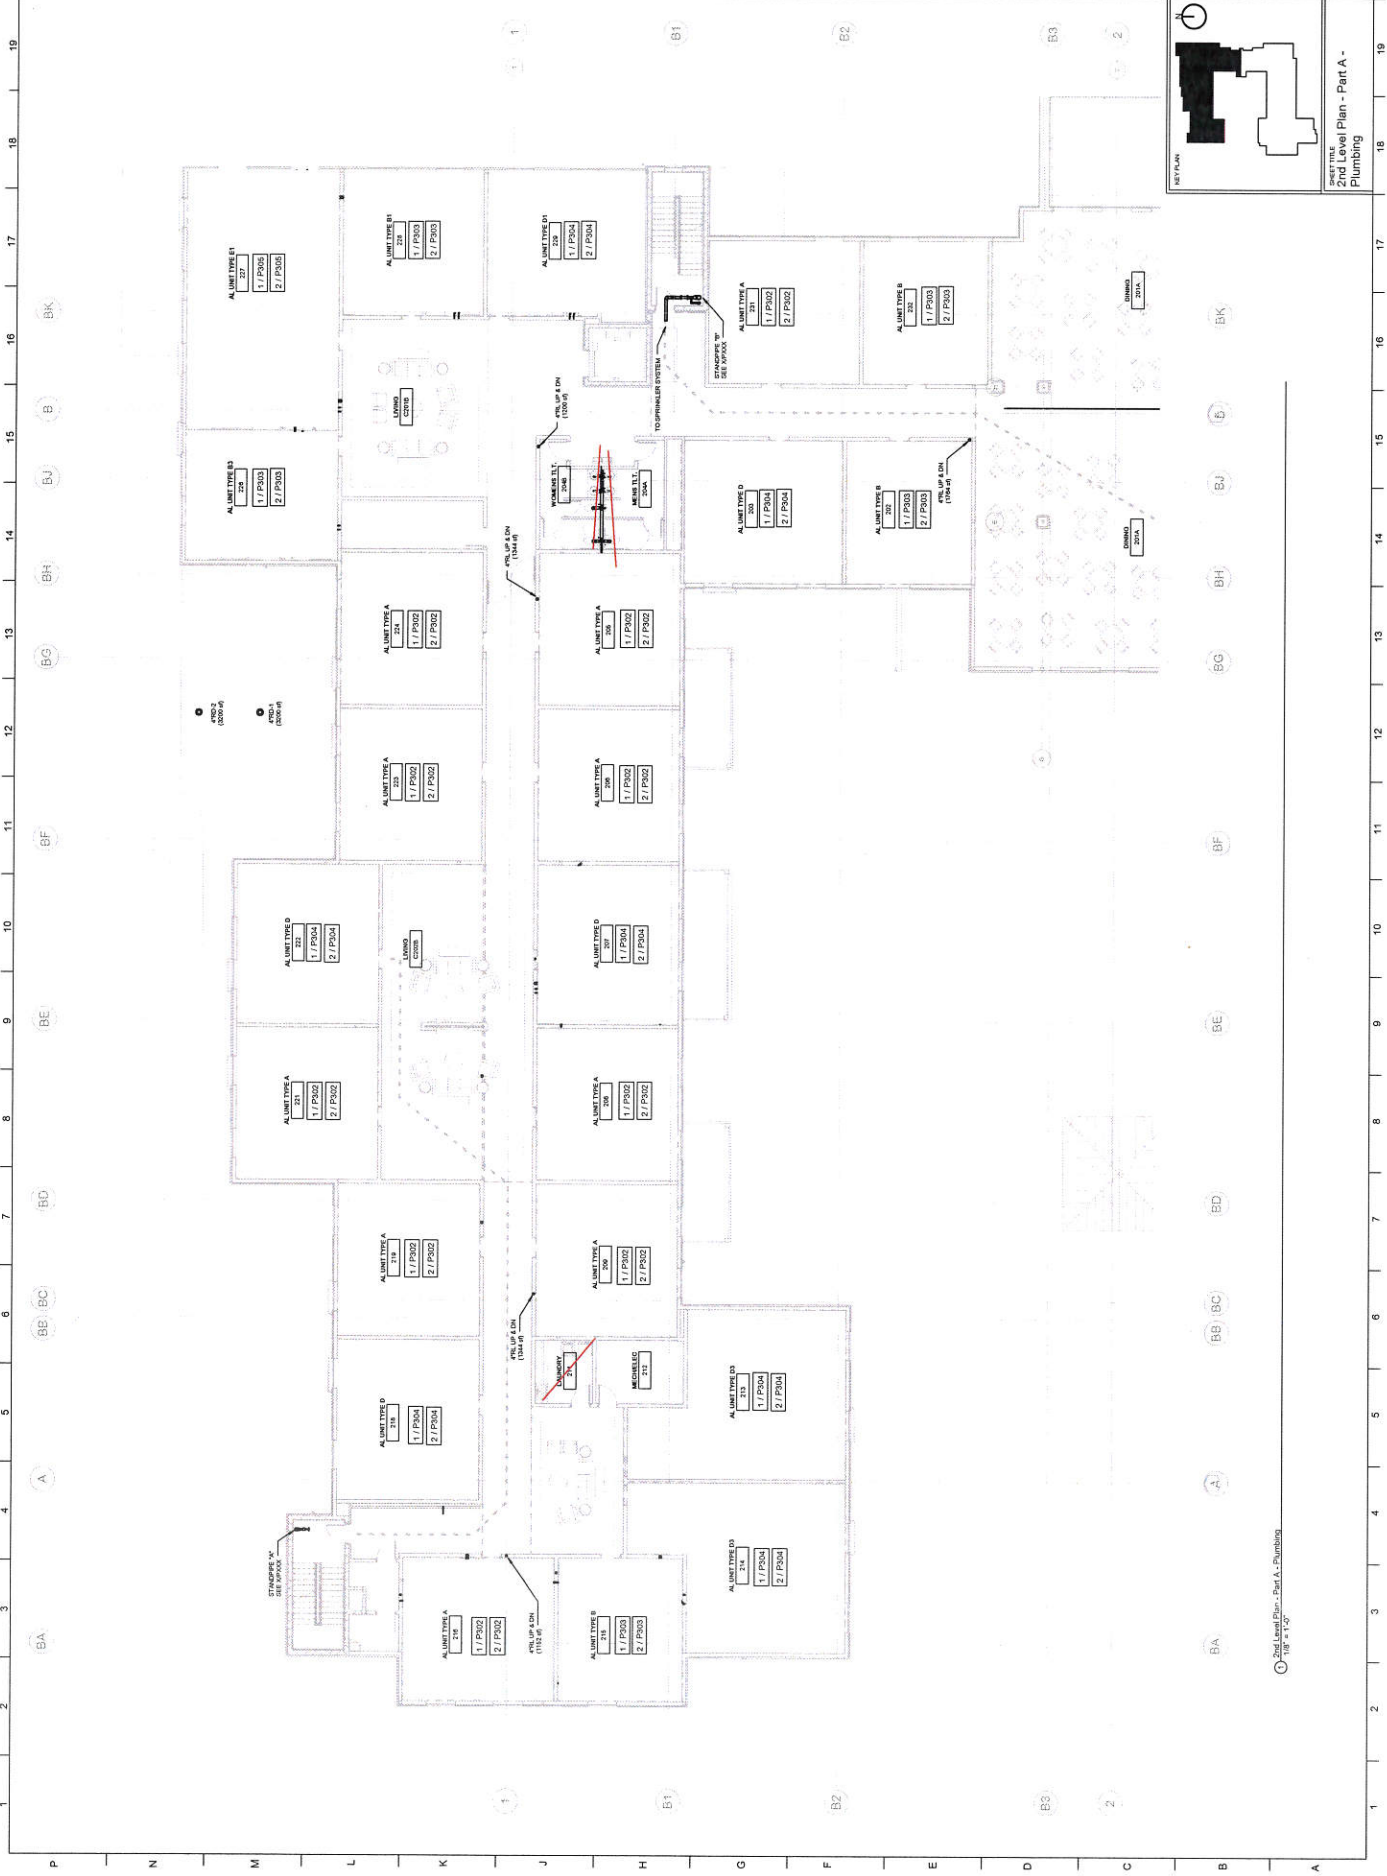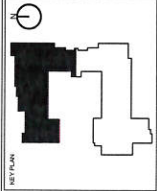


1. 2nd Level Plan - Part A - Plumbing
1/8" = 1'-0"

NO.	DESCRIPTION	DATE
1	ISSUED FOR PERMIT	08/14/2019
2	REVISION	
3	REVISION	
4	REVISION	
5	REVISION	
6	REVISION	
7	REVISION	
8	REVISION	
9	REVISION	
10	REVISION	
11	REVISION	
12	REVISION	
13	REVISION	
14	REVISION	
15	REVISION	
16	REVISION	
17	REVISION	
18	REVISION	
19	REVISION	
20	REVISION	

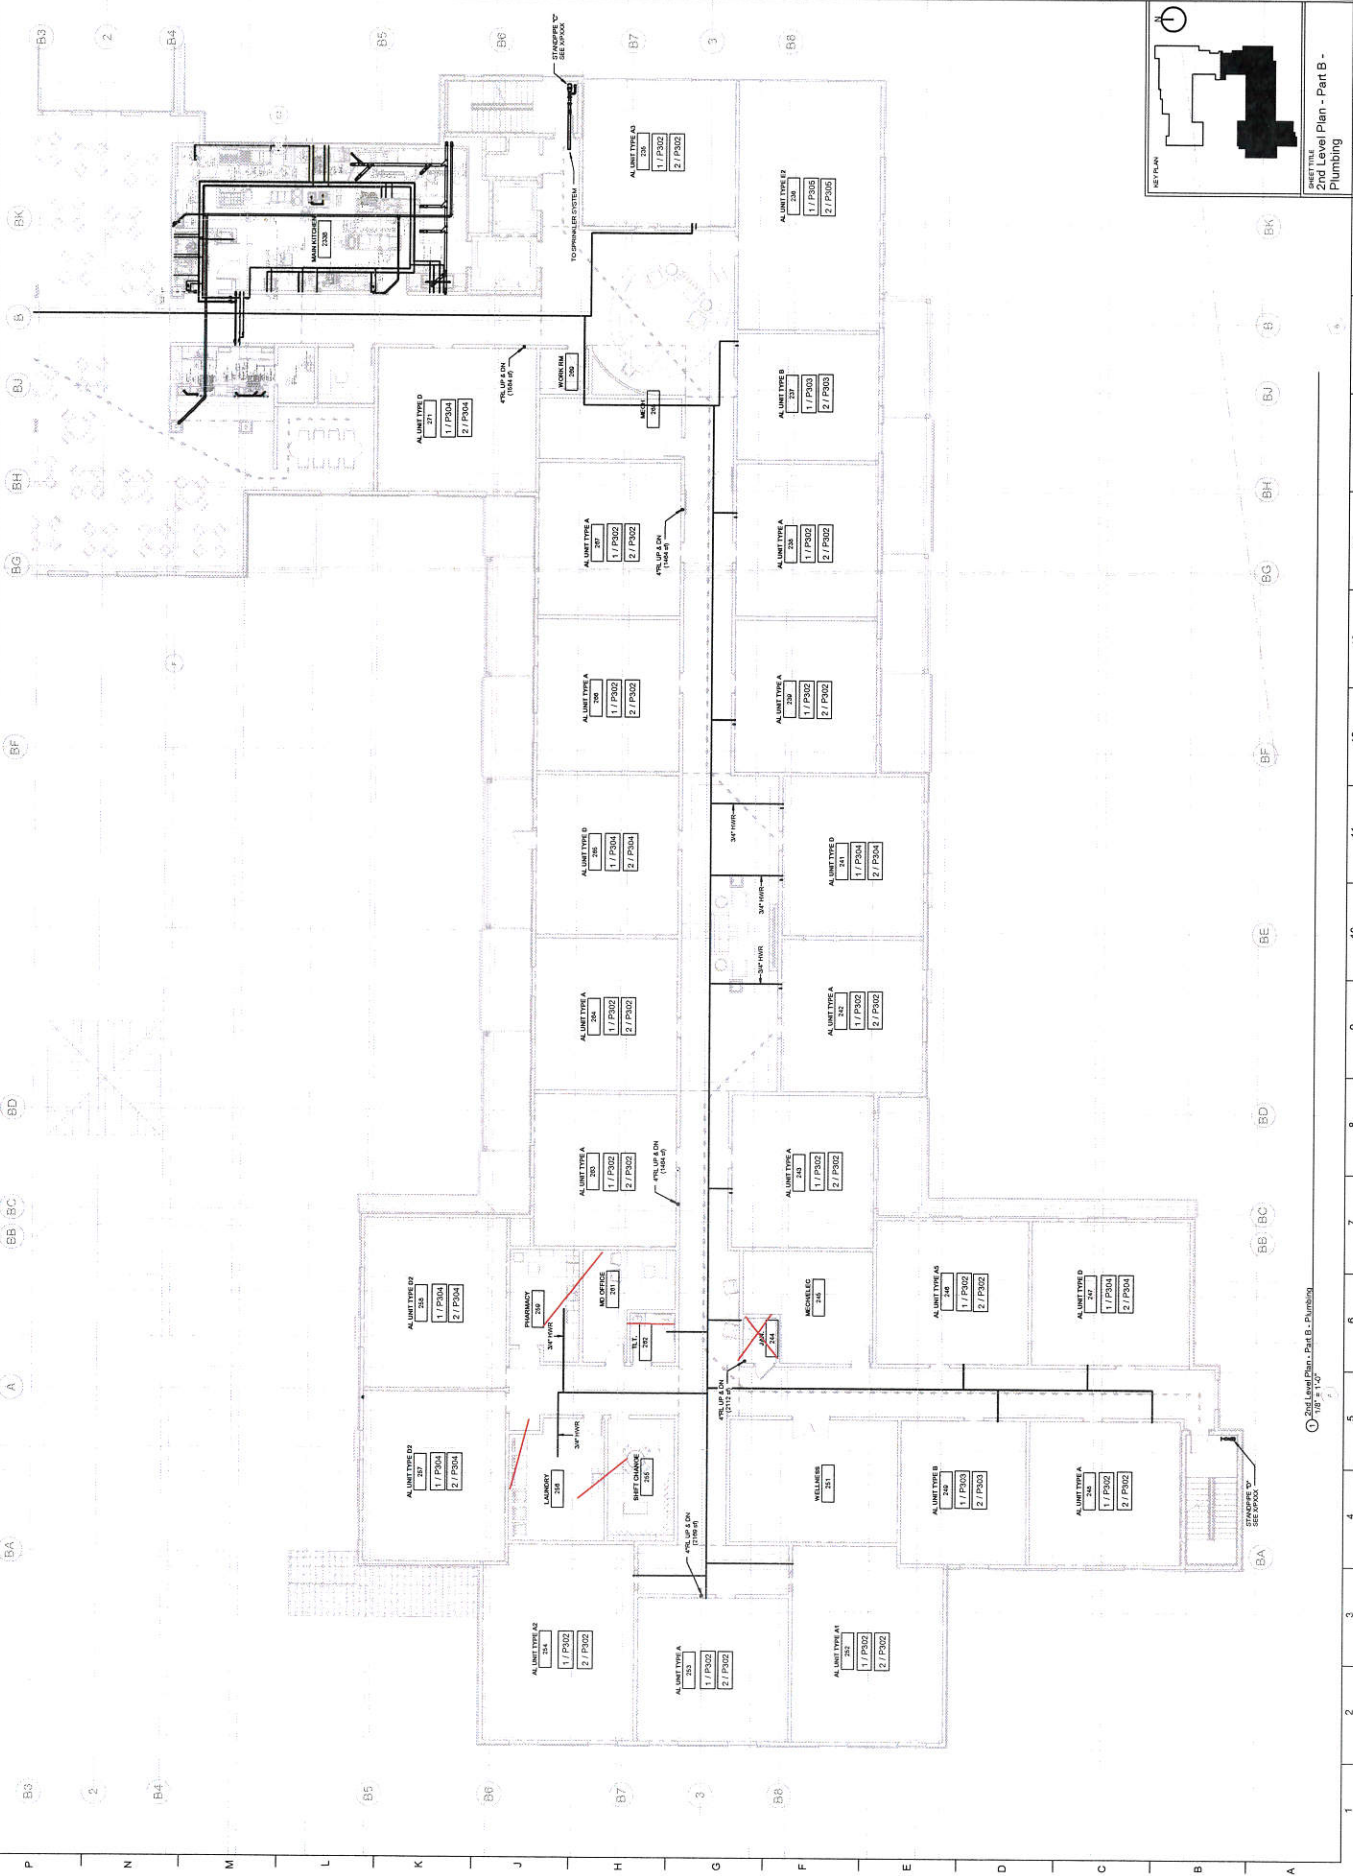
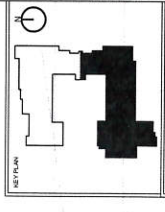




① 2nd Level Plan - Part B - Plumbing
1 of 2

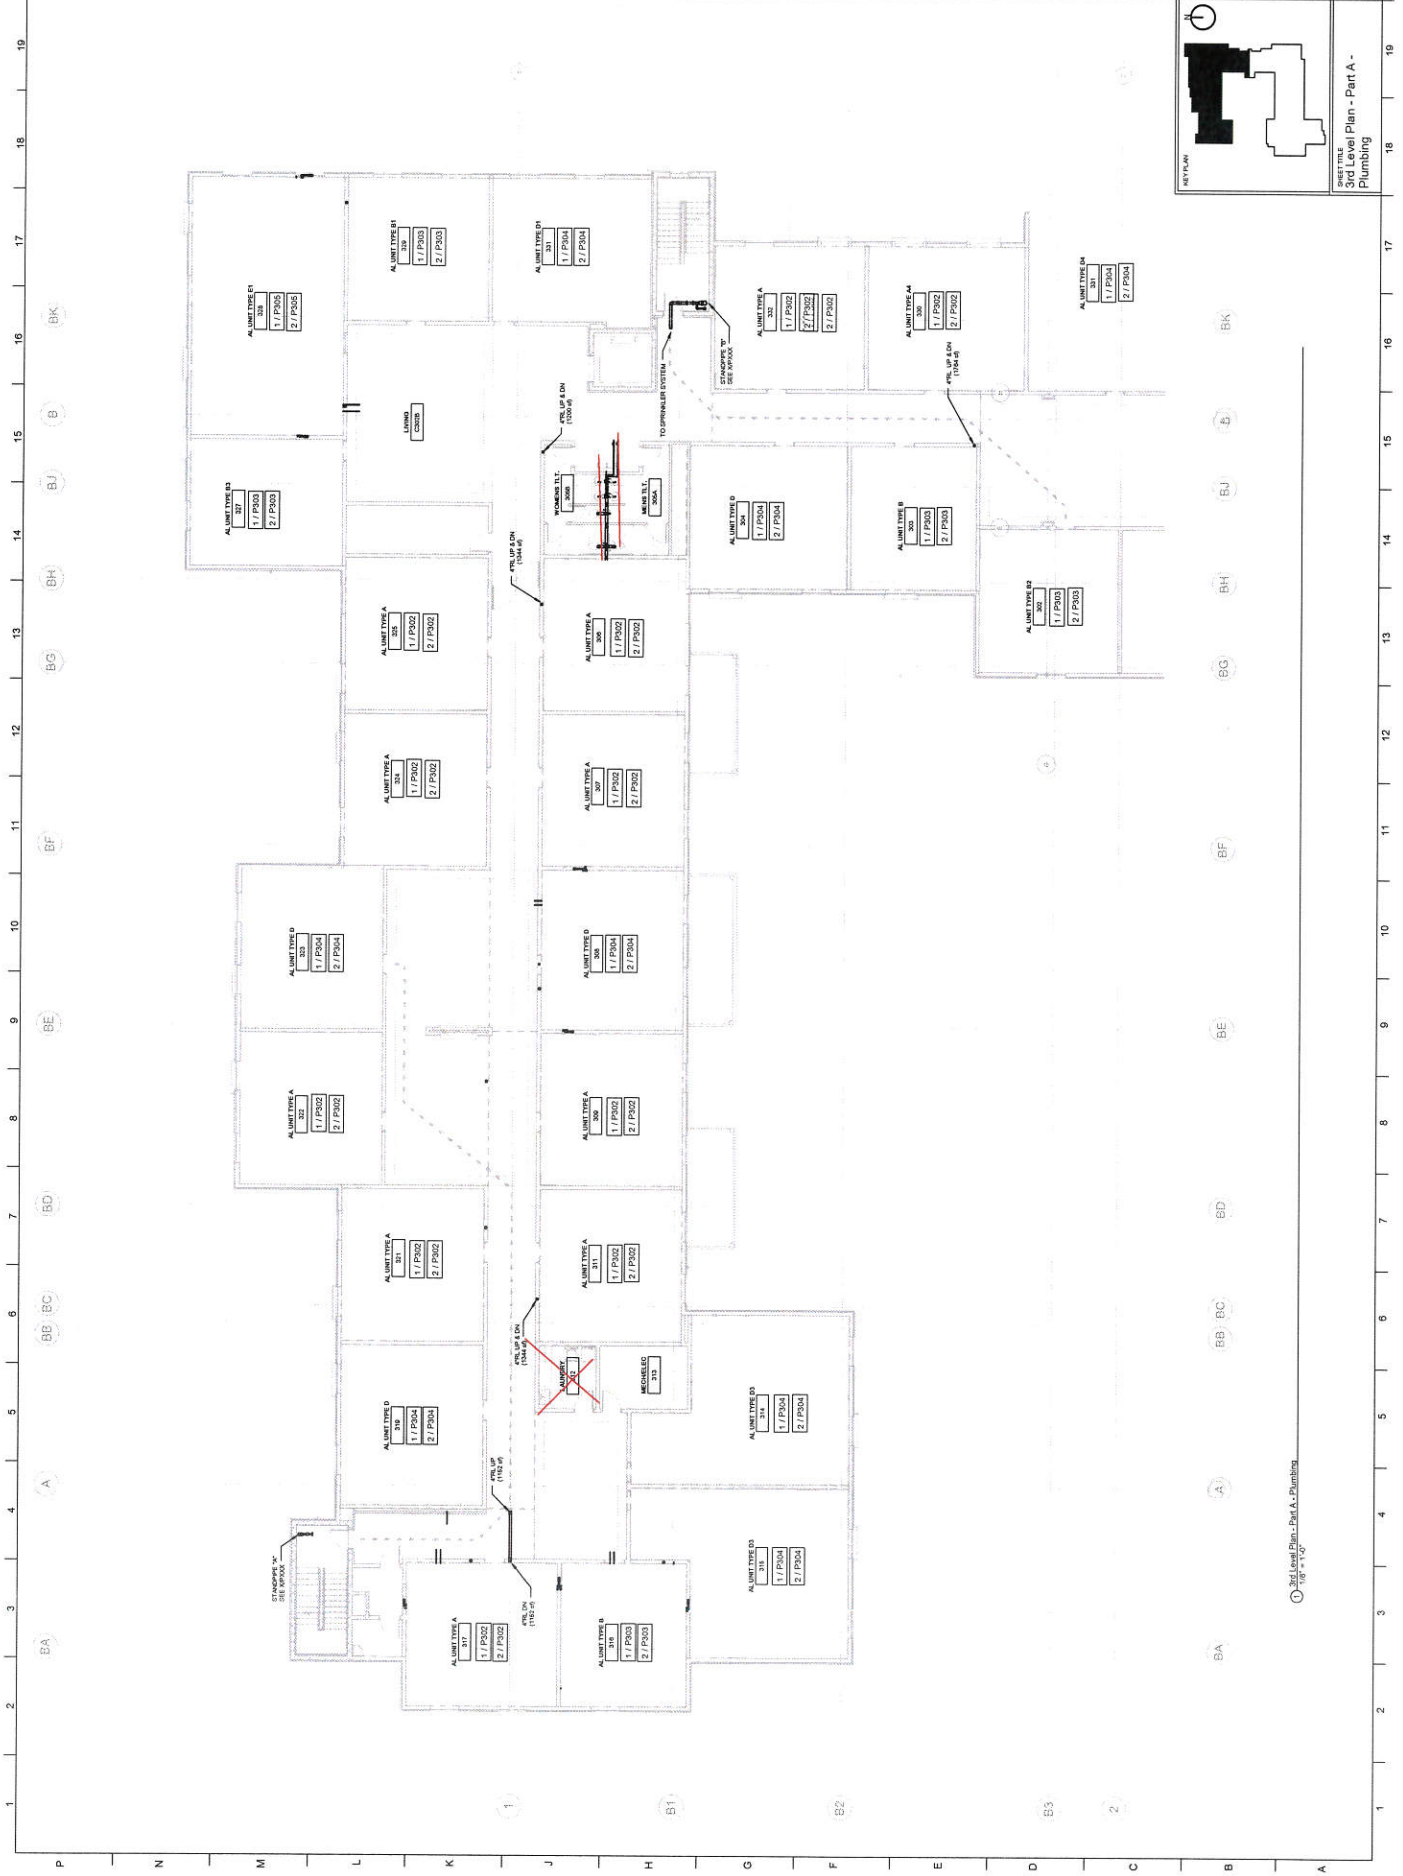





NO.	REVISION	DATE
1	ISSUE FOR PERMIT	08/14/19
2	ISSUE FOR PERMIT	08/14/19
3	ISSUE FOR PERMIT	08/14/19
100	ISSUE FOR PERMIT	08/14/19

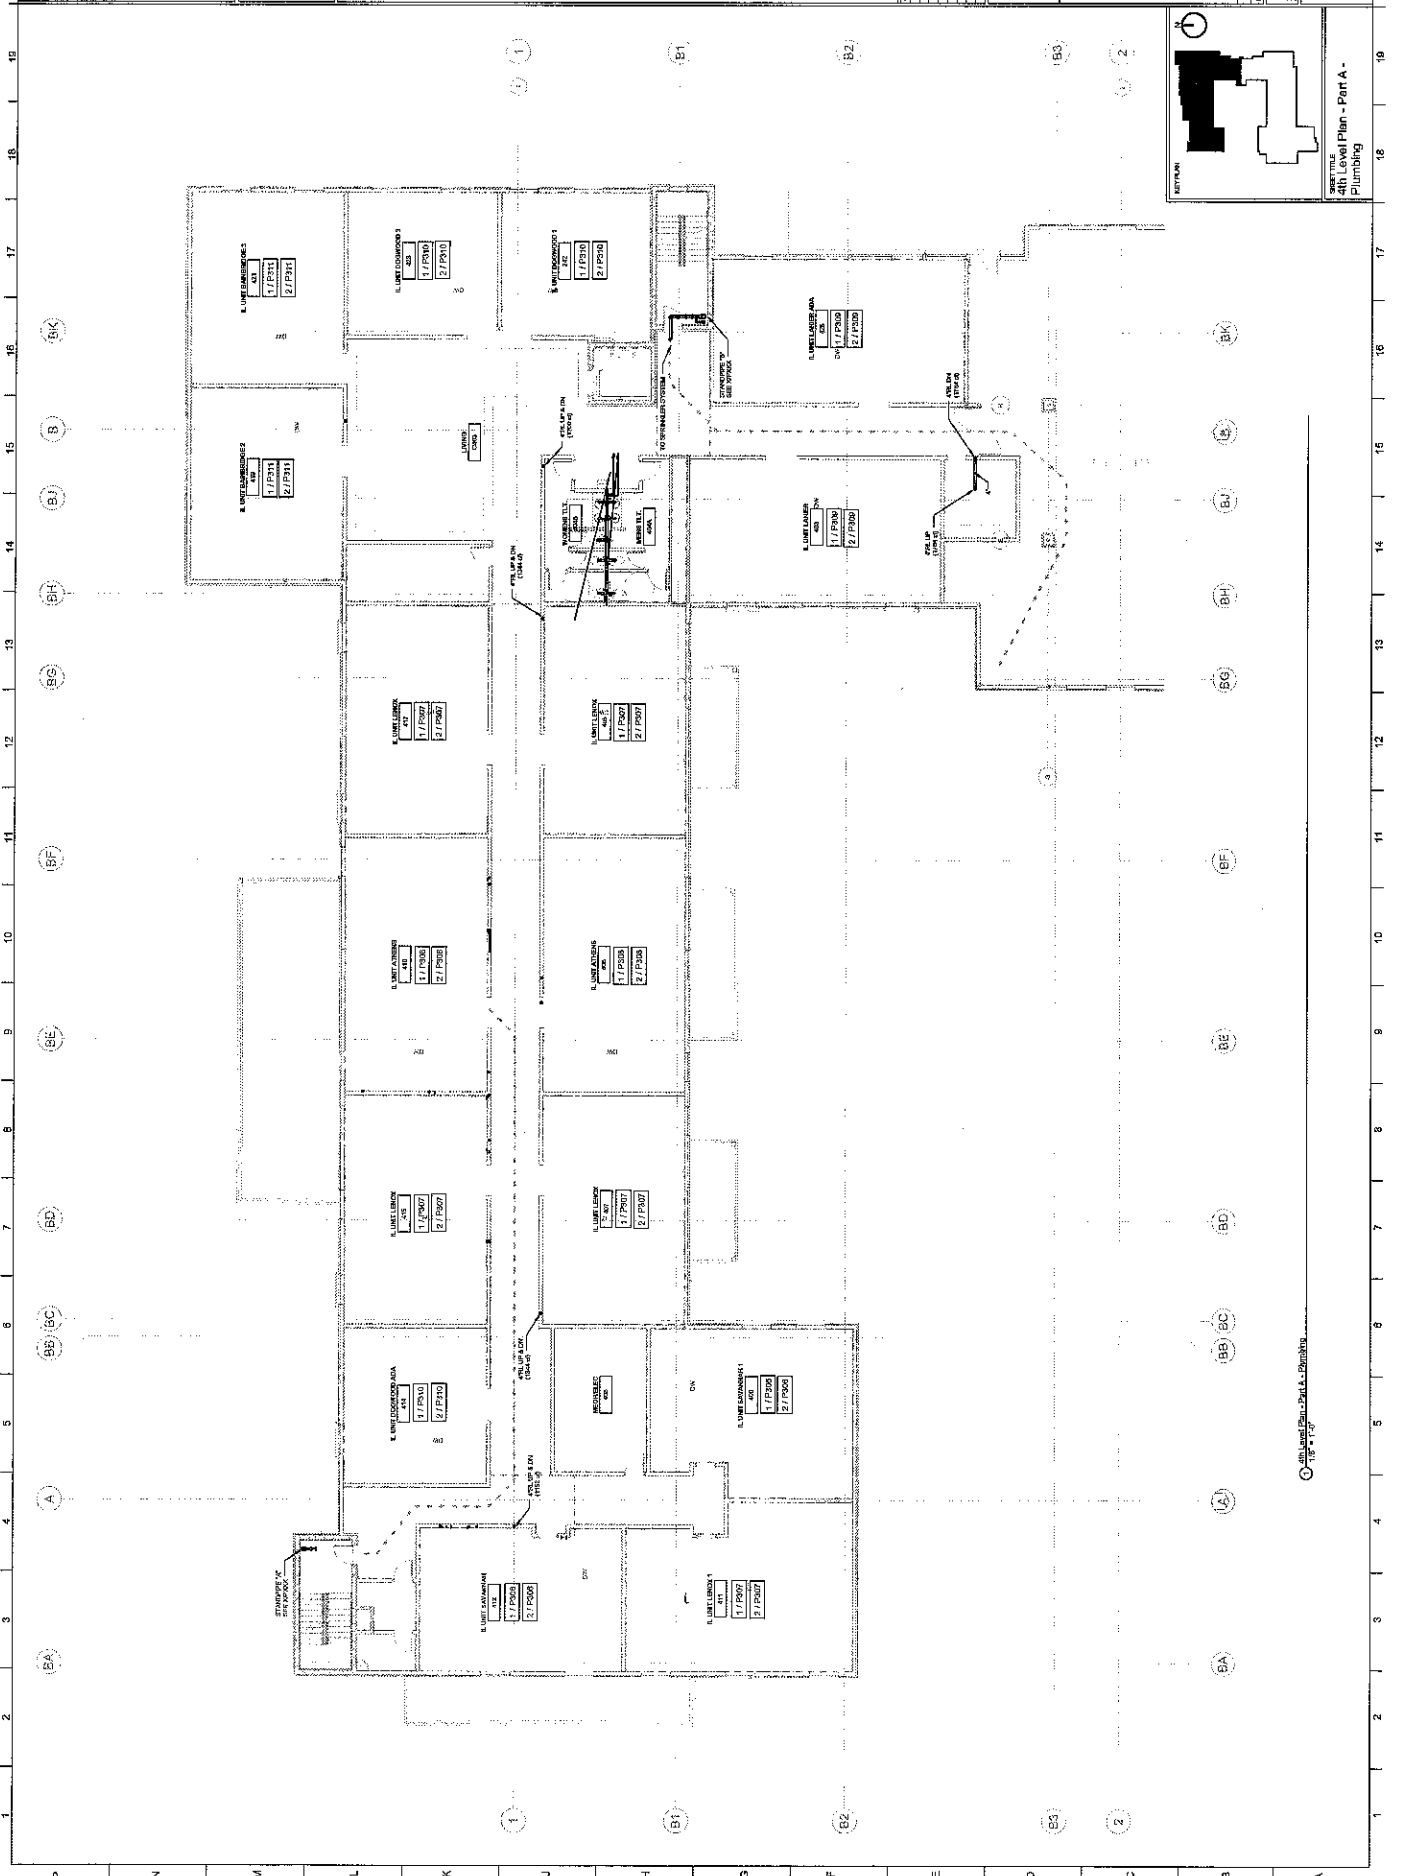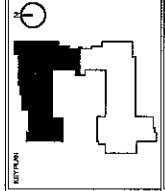

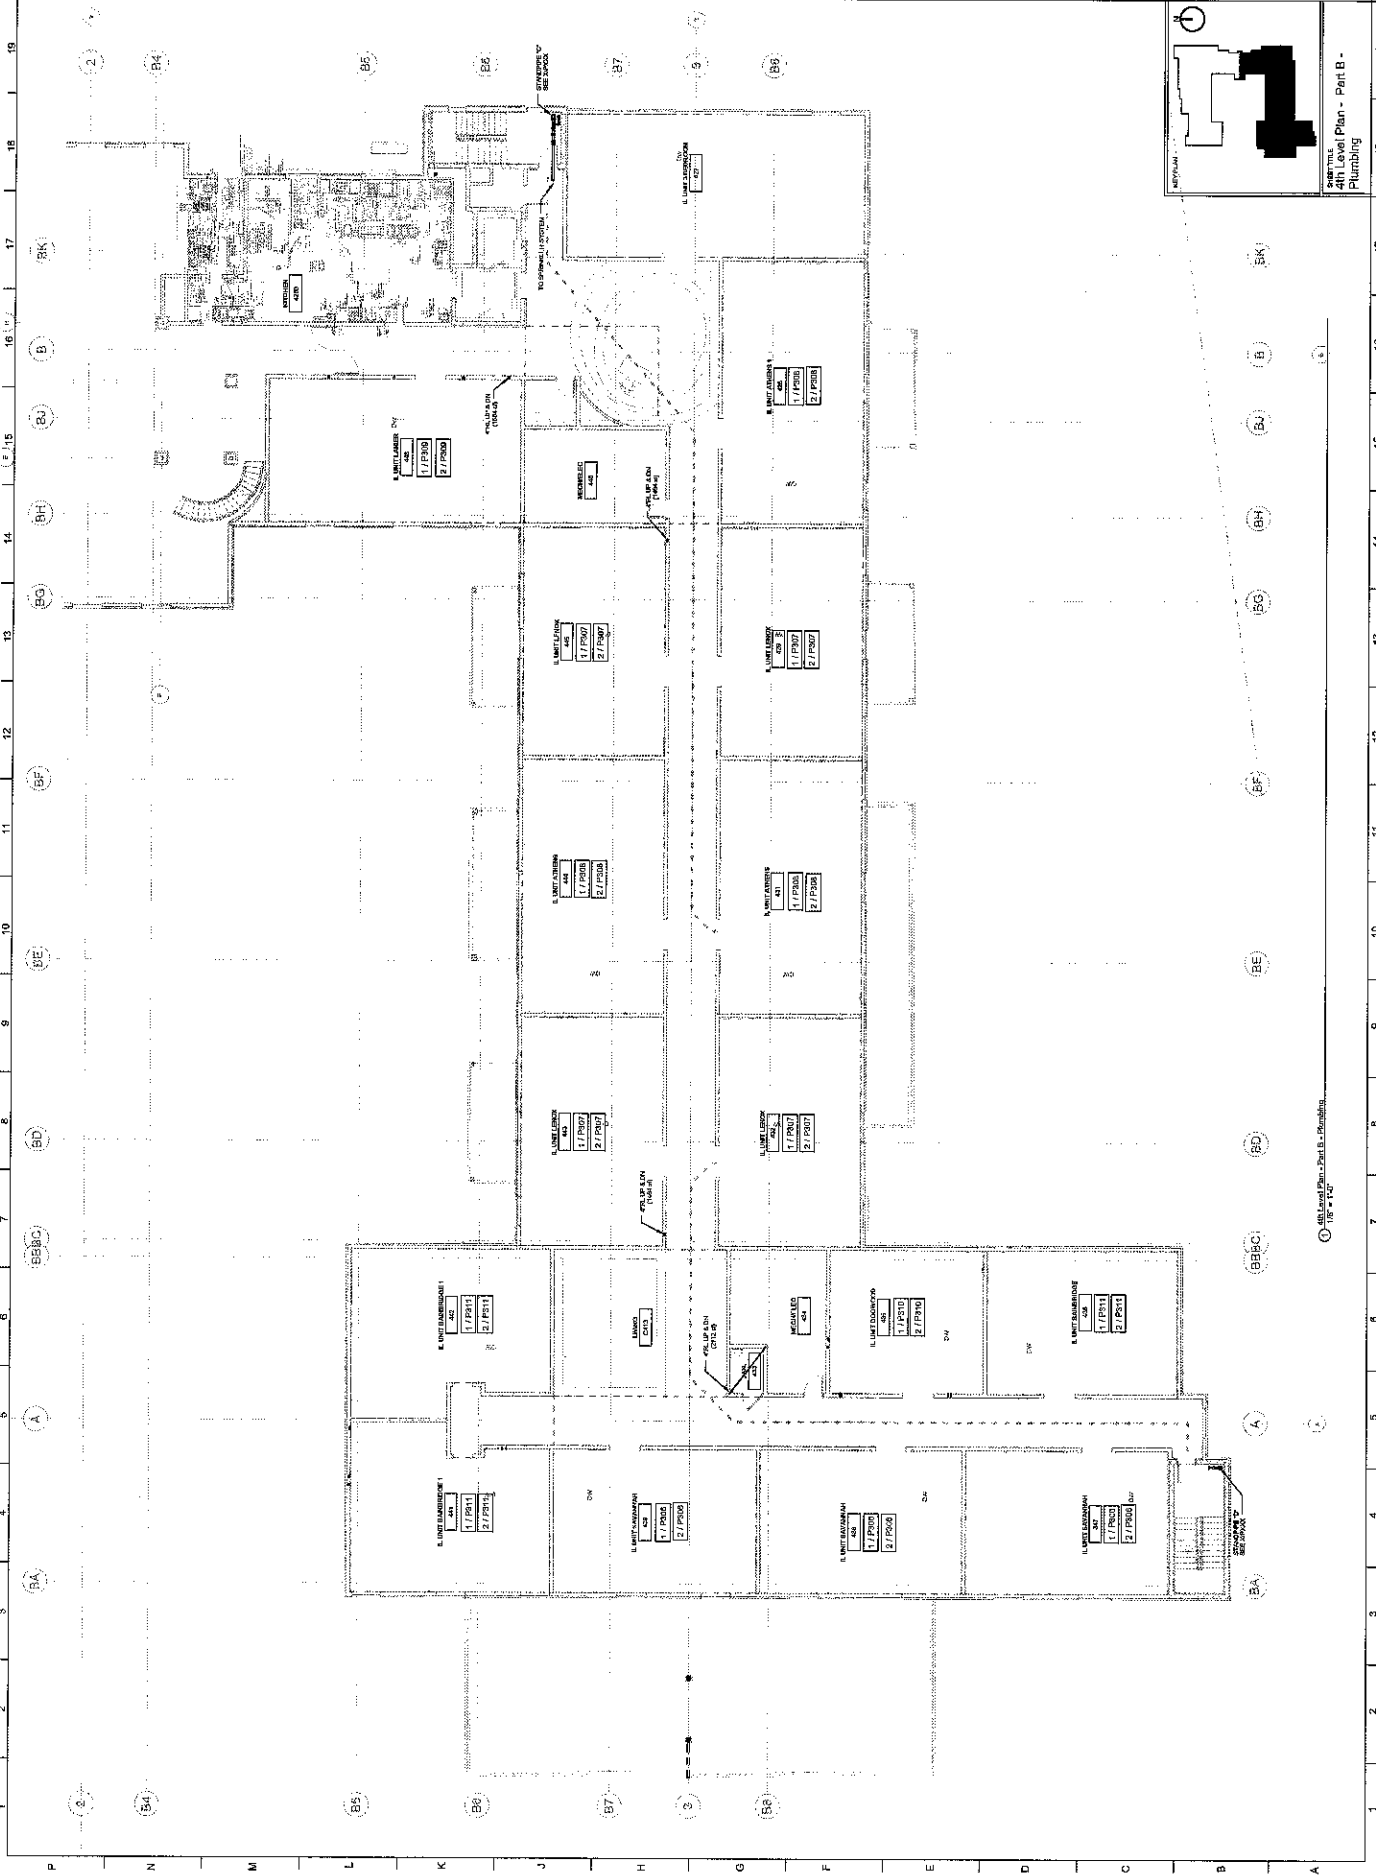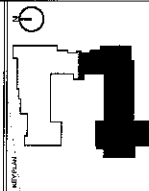


4th Level Plan - Part B - Plumbing

1/8" = 1'-0"

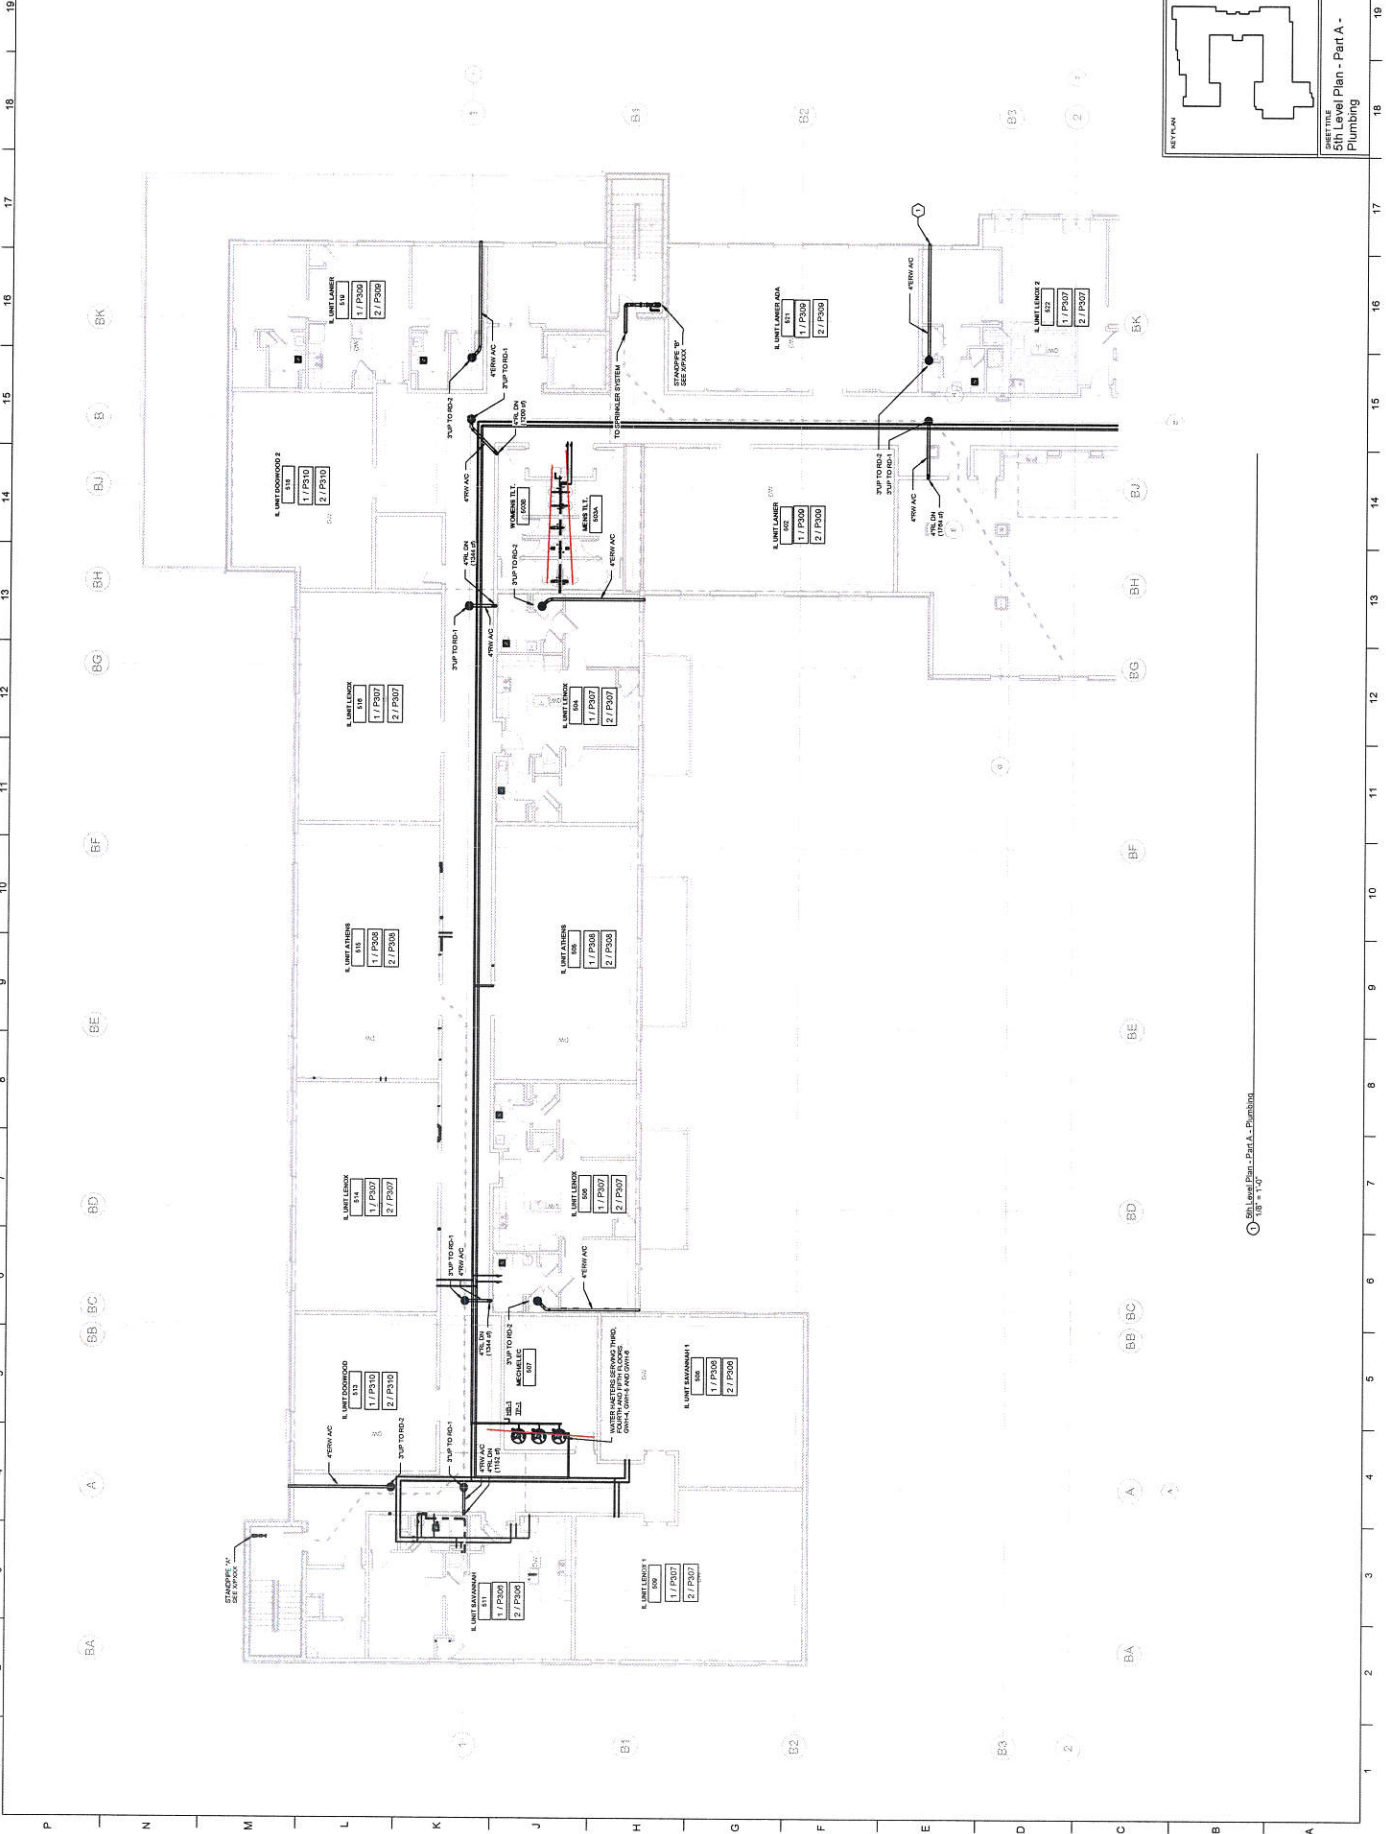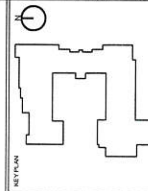


1/8" = 1'-0"


NO.	REVISION	DATE
1	ISSUED FOR PERMIT	01/15/2019
2	REVISED PER COMMENTS	02/01/2019
3	REVISED PER COMMENTS	02/15/2019
4	REVISED PER COMMENTS	03/01/2019
5	REVISED PER COMMENTS	03/15/2019
6	REVISED PER COMMENTS	04/01/2019
7	REVISED PER COMMENTS	04/15/2019
8	REVISED PER COMMENTS	05/01/2019
9	REVISED PER COMMENTS	05/15/2019
10	REVISED PER COMMENTS	06/01/2019
11	REVISED PER COMMENTS	06/15/2019
12	REVISED PER COMMENTS	07/01/2019
13	REVISED PER COMMENTS	07/15/2019
14	REVISED PER COMMENTS	08/01/2019
15	REVISED PER COMMENTS	08/15/2019
16	REVISED PER COMMENTS	09/01/2019
17	REVISED PER COMMENTS	09/15/2019
18	REVISED PER COMMENTS	10/01/2019
19	REVISED PER COMMENTS	10/15/2019

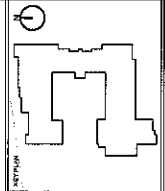


5th Level Plan - Part B -
Plumbing

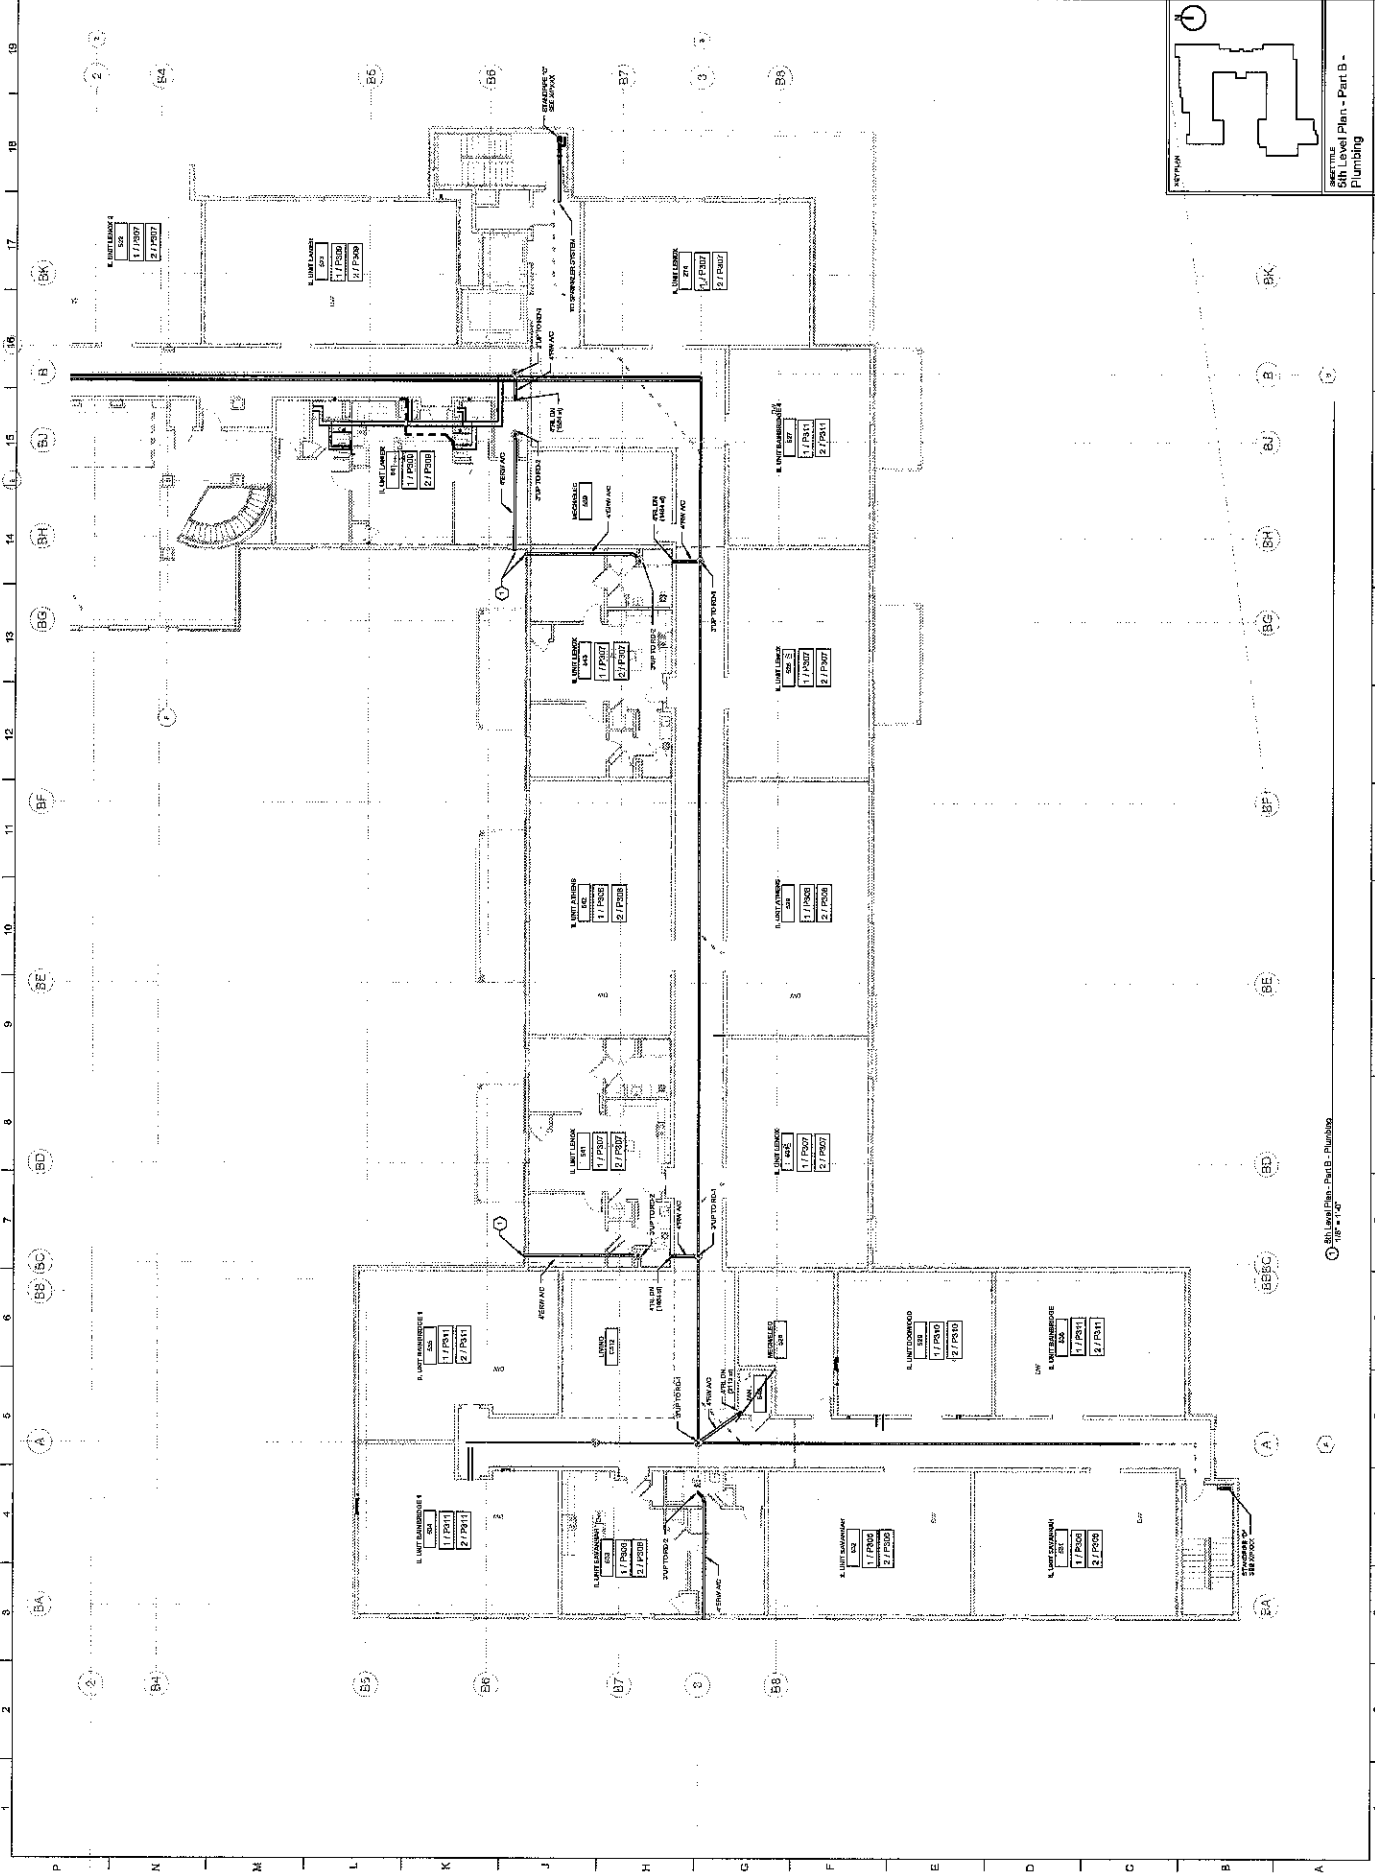


5th Level Plan - Part B - Plumbing
1/8" = 1'-0"

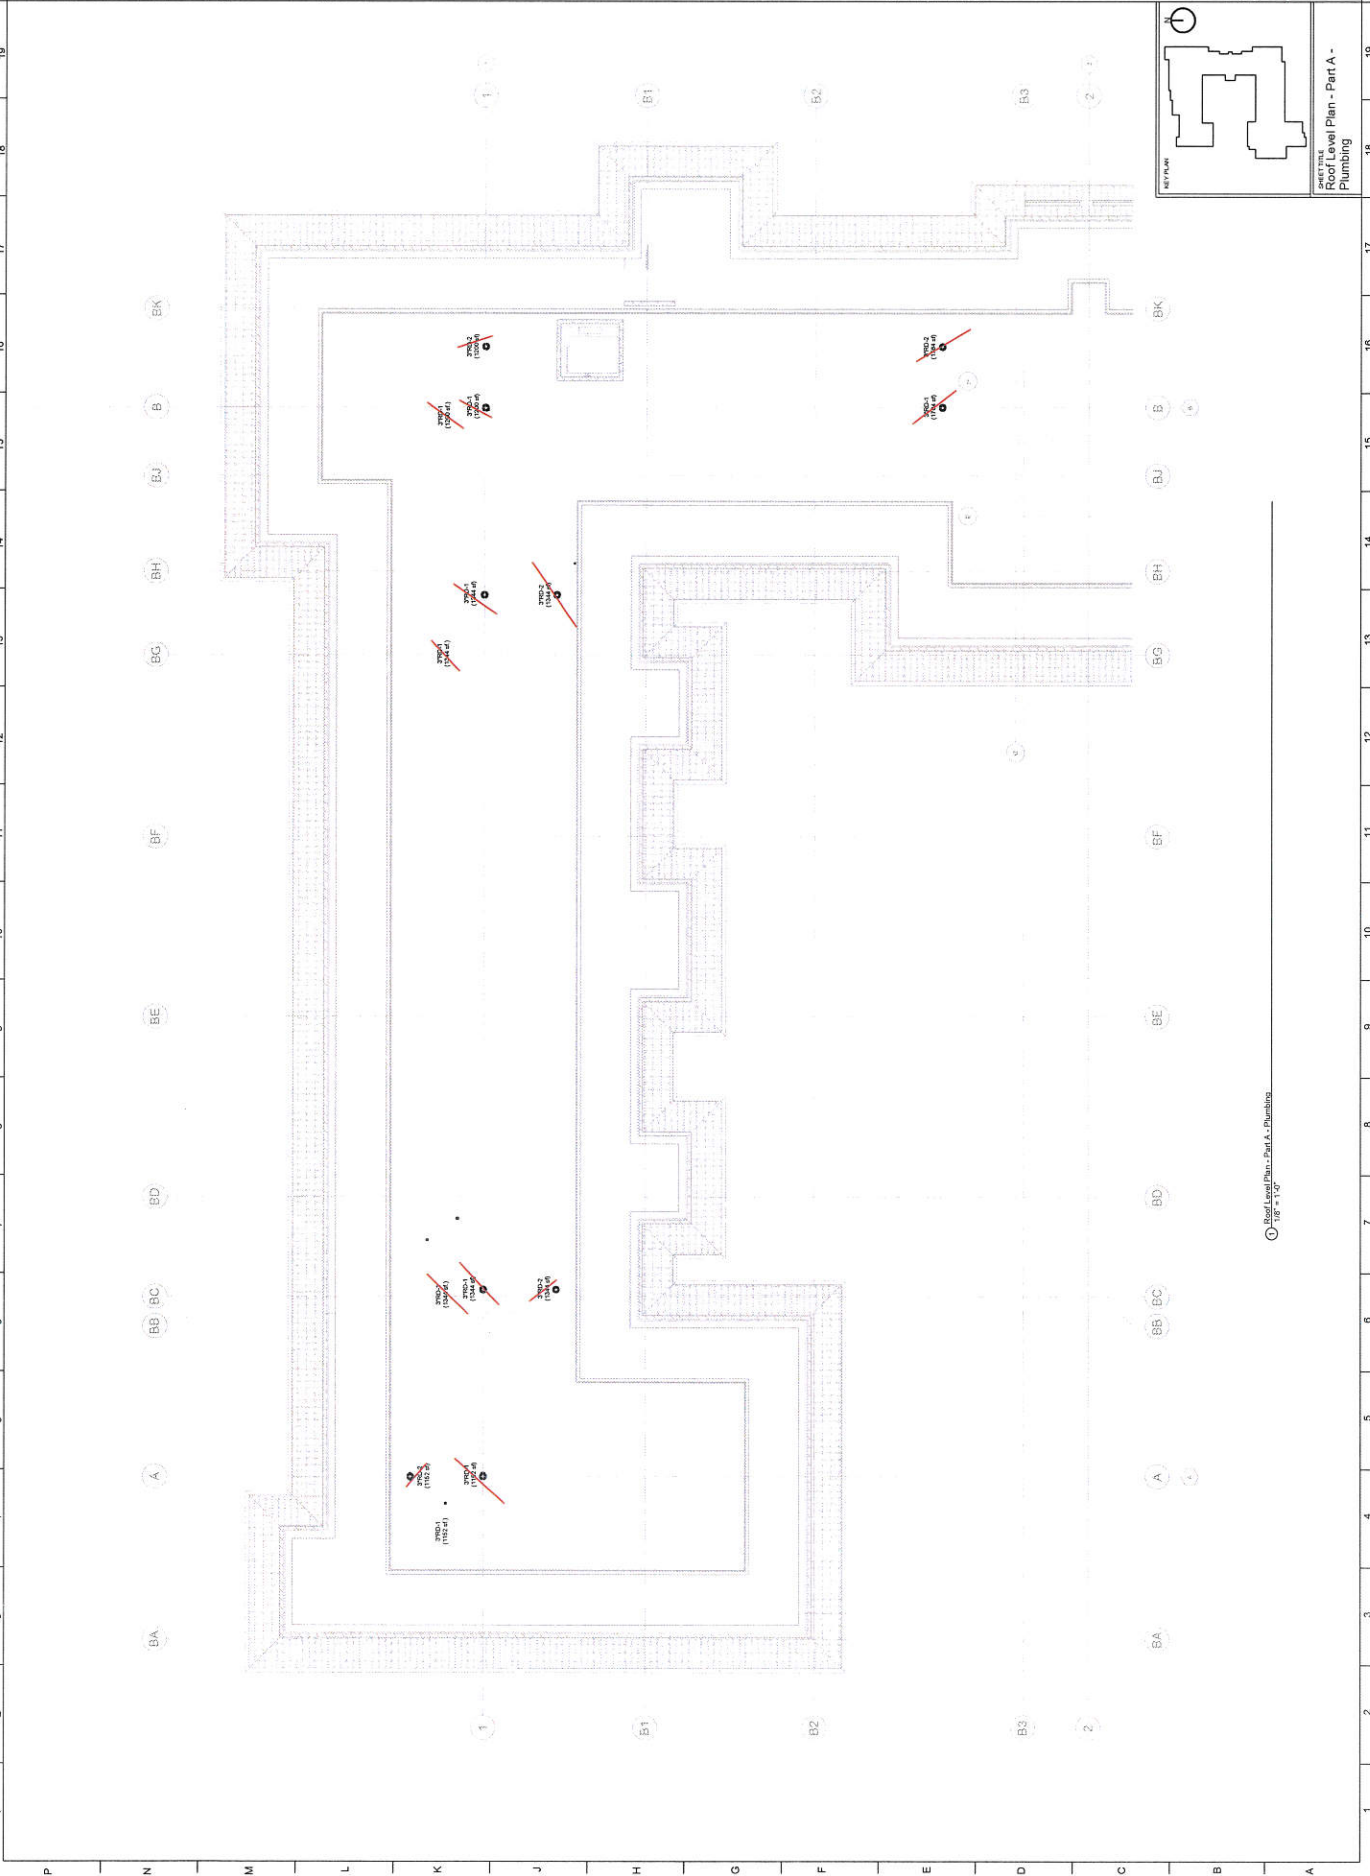

NO.	DESCRIPTION	DATE
1	ISSUED FOR PERMIT	10/1/2019
2	REVISION	
3	REVISION	
4	REVISION	
5	REVISION	
6	REVISION	
7	REVISION	
8	REVISION	
9	REVISION	
10	REVISION	

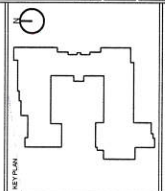


SHEET TITLE
Roof Level Plan - Part B - Plumbing

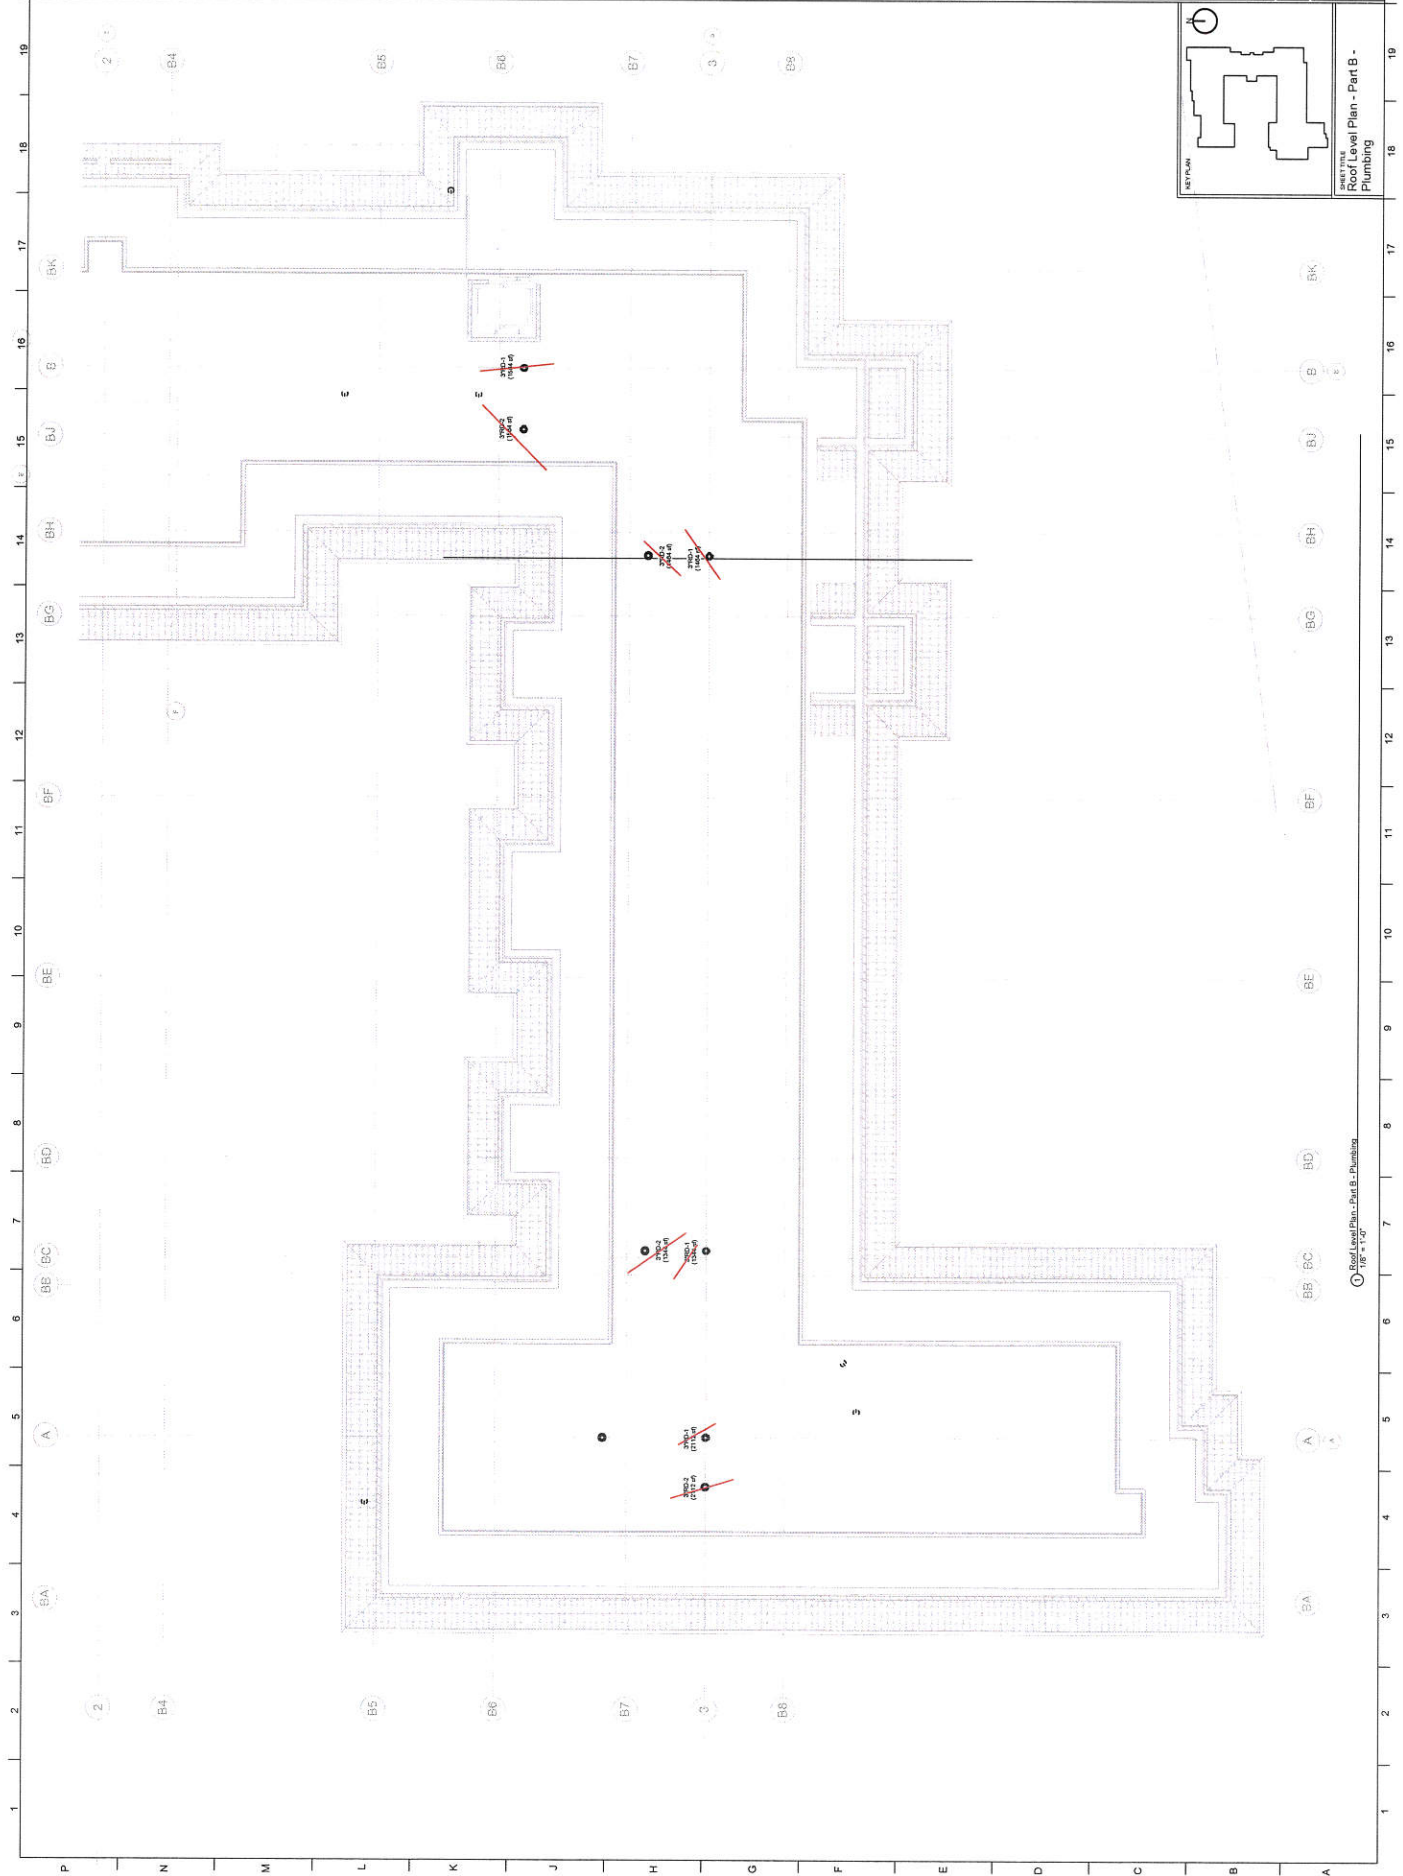


NO.	DESCRIPTION	DATE
1	ISSUED FOR PERMIT	10/1/2019
2	ISSUED FOR PERMIT	10/1/2019
3	ISSUED FOR PERMIT	10/1/2019
4	ISSUED FOR PERMIT	10/1/2019
5	ISSUED FOR PERMIT	10/1/2019
6	ISSUED FOR PERMIT	10/1/2019
7	ISSUED FOR PERMIT	10/1/2019
8	ISSUED FOR PERMIT	10/1/2019
9	ISSUED FOR PERMIT	10/1/2019
10	ISSUED FOR PERMIT	10/1/2019
11	ISSUED FOR PERMIT	10/1/2019
12	ISSUED FOR PERMIT	10/1/2019
13	ISSUED FOR PERMIT	10/1/2019
14	ISSUED FOR PERMIT	10/1/2019
15	ISSUED FOR PERMIT	10/1/2019
16	ISSUED FOR PERMIT	10/1/2019
17	ISSUED FOR PERMIT	10/1/2019
18	ISSUED FOR PERMIT	10/1/2019
19	ISSUED FOR PERMIT	10/1/2019


MECHANICAL
MECHANICAL FLOOR PLAN - TYPICAL
MC Unit Type C - Plumbing

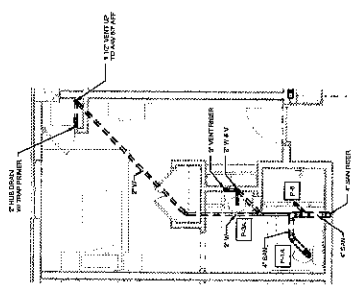


② Mechanical Floor Plan - MC Unit Type C - Plumbing
1/2" = 1'-0"

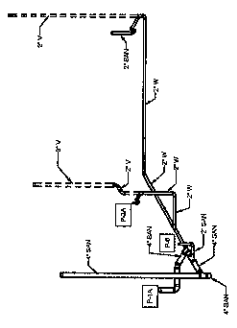



③ Mechanical Floor Plan - MC Unit Type C - Plumbing

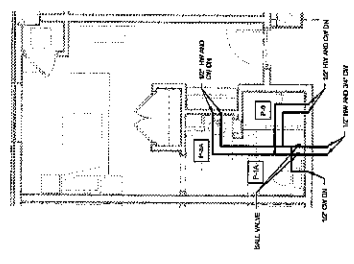


① Mechanical Floor Plan - MC Unit Type C - Plumbing
1/2" = 1'-0"

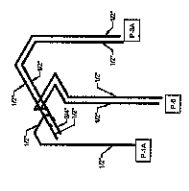

  
④ Mechanical Floor Plan - MC Unit Type C - Plumbing




NO.	DESCRIPTION	DATE
1	ISSUED FOR PERMIT	12/15/2018
2	ISSUED FOR PERMIT	12/15/2018
3	ISSUED FOR PERMIT	12/15/2018
4	ISSUED FOR PERMIT	12/15/2018
5	ISSUED FOR PERMIT	12/15/2018
6	ISSUED FOR PERMIT	12/15/2018
7	ISSUED FOR PERMIT	12/15/2018
8	ISSUED FOR PERMIT	12/15/2018
9	ISSUED FOR PERMIT	12/15/2018
10	ISSUED FOR PERMIT	12/15/2018
11	ISSUED FOR PERMIT	12/15/2018
12	ISSUED FOR PERMIT	12/15/2018
13	ISSUED FOR PERMIT	12/15/2018
14	ISSUED FOR PERMIT	12/15/2018
15	ISSUED FOR PERMIT	12/15/2018
16	ISSUED FOR PERMIT	12/15/2018
17	ISSUED FOR PERMIT	12/15/2018
18	ISSUED FOR PERMIT	12/15/2018
19	ISSUED FOR PERMIT	12/15/2018

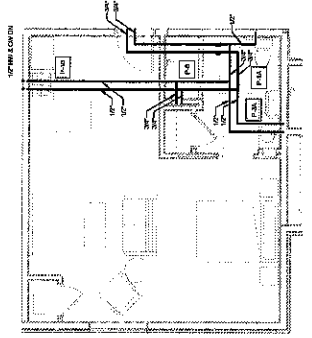


Enlarged Floor Plan - Unit Type B - Plumbing
Enlarged View
1/8" = 1'-0"

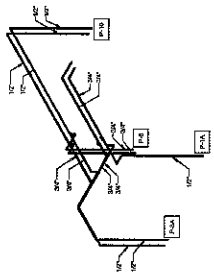





Enlarged View - Unit Type B - Plumbing

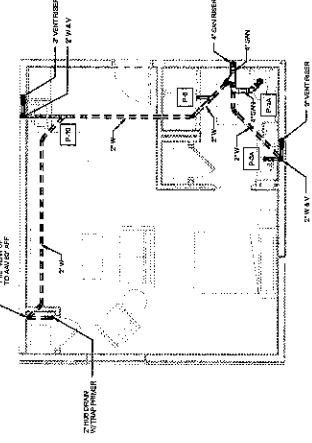

Enlarged Floor Plan - Unit Type B - Plumbing
Enlarged View
1/8" = 1'-0"

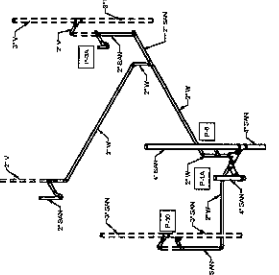


Enlarged View - Unit Type B - Plumbing

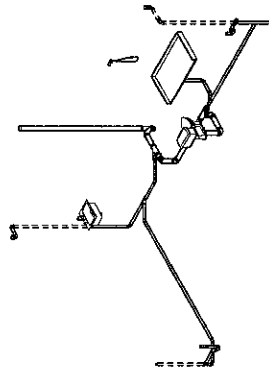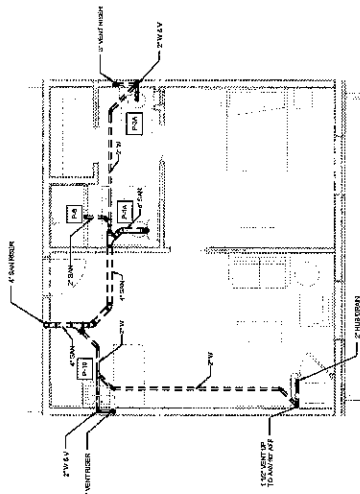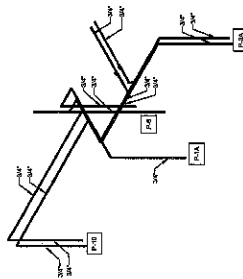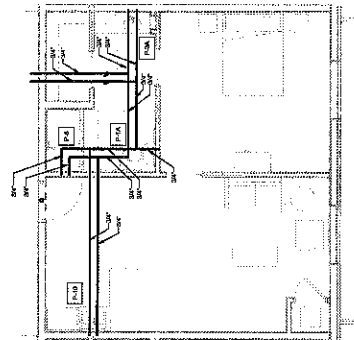


NO.	REVISION	DATE	BY	CHKD.
1	ISSUED FOR PERMIT	08/11/2011	DAVID L. HIGHTOWER	

18 17 16 15 14 13 12 11 10 9 8 7 6 5 4 3 2 1


P N M L X J H G F E D C B A

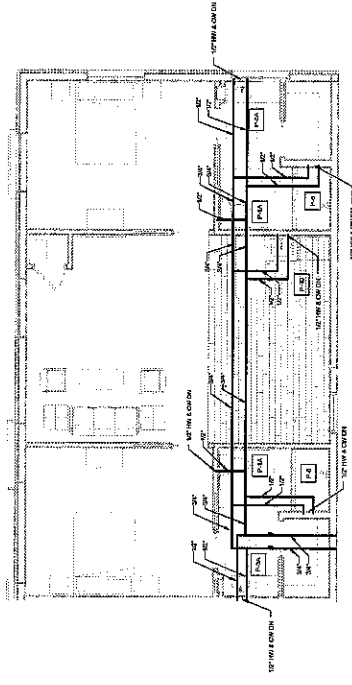


① Enlarged Floor Plan - Unit Type E1 - Plumbing (Commons Water)
 1/4\"/>

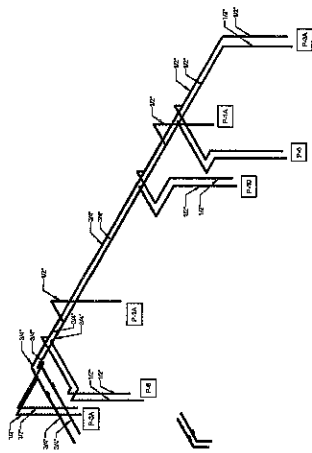




① Isometric - Unit Type E1 - Plumbing Water

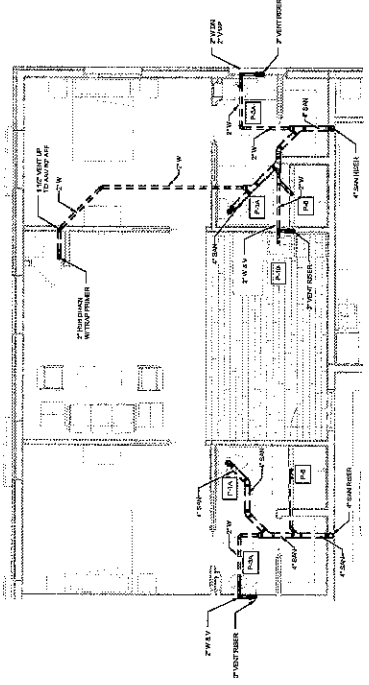



② Enlarged Floor Plan - Plumbing - Unit Type E1 - Commons Sewer & Vent
 1/4\"/>

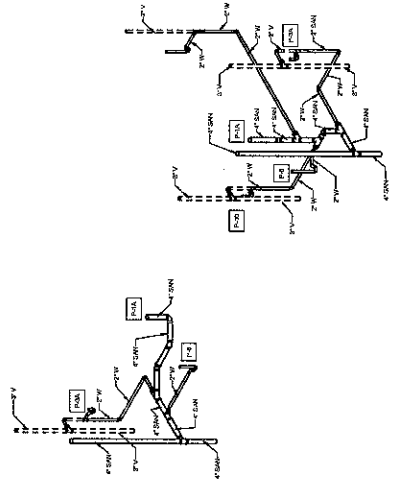

   ② Isometric - Unit Type E1 - Sewer & Vent




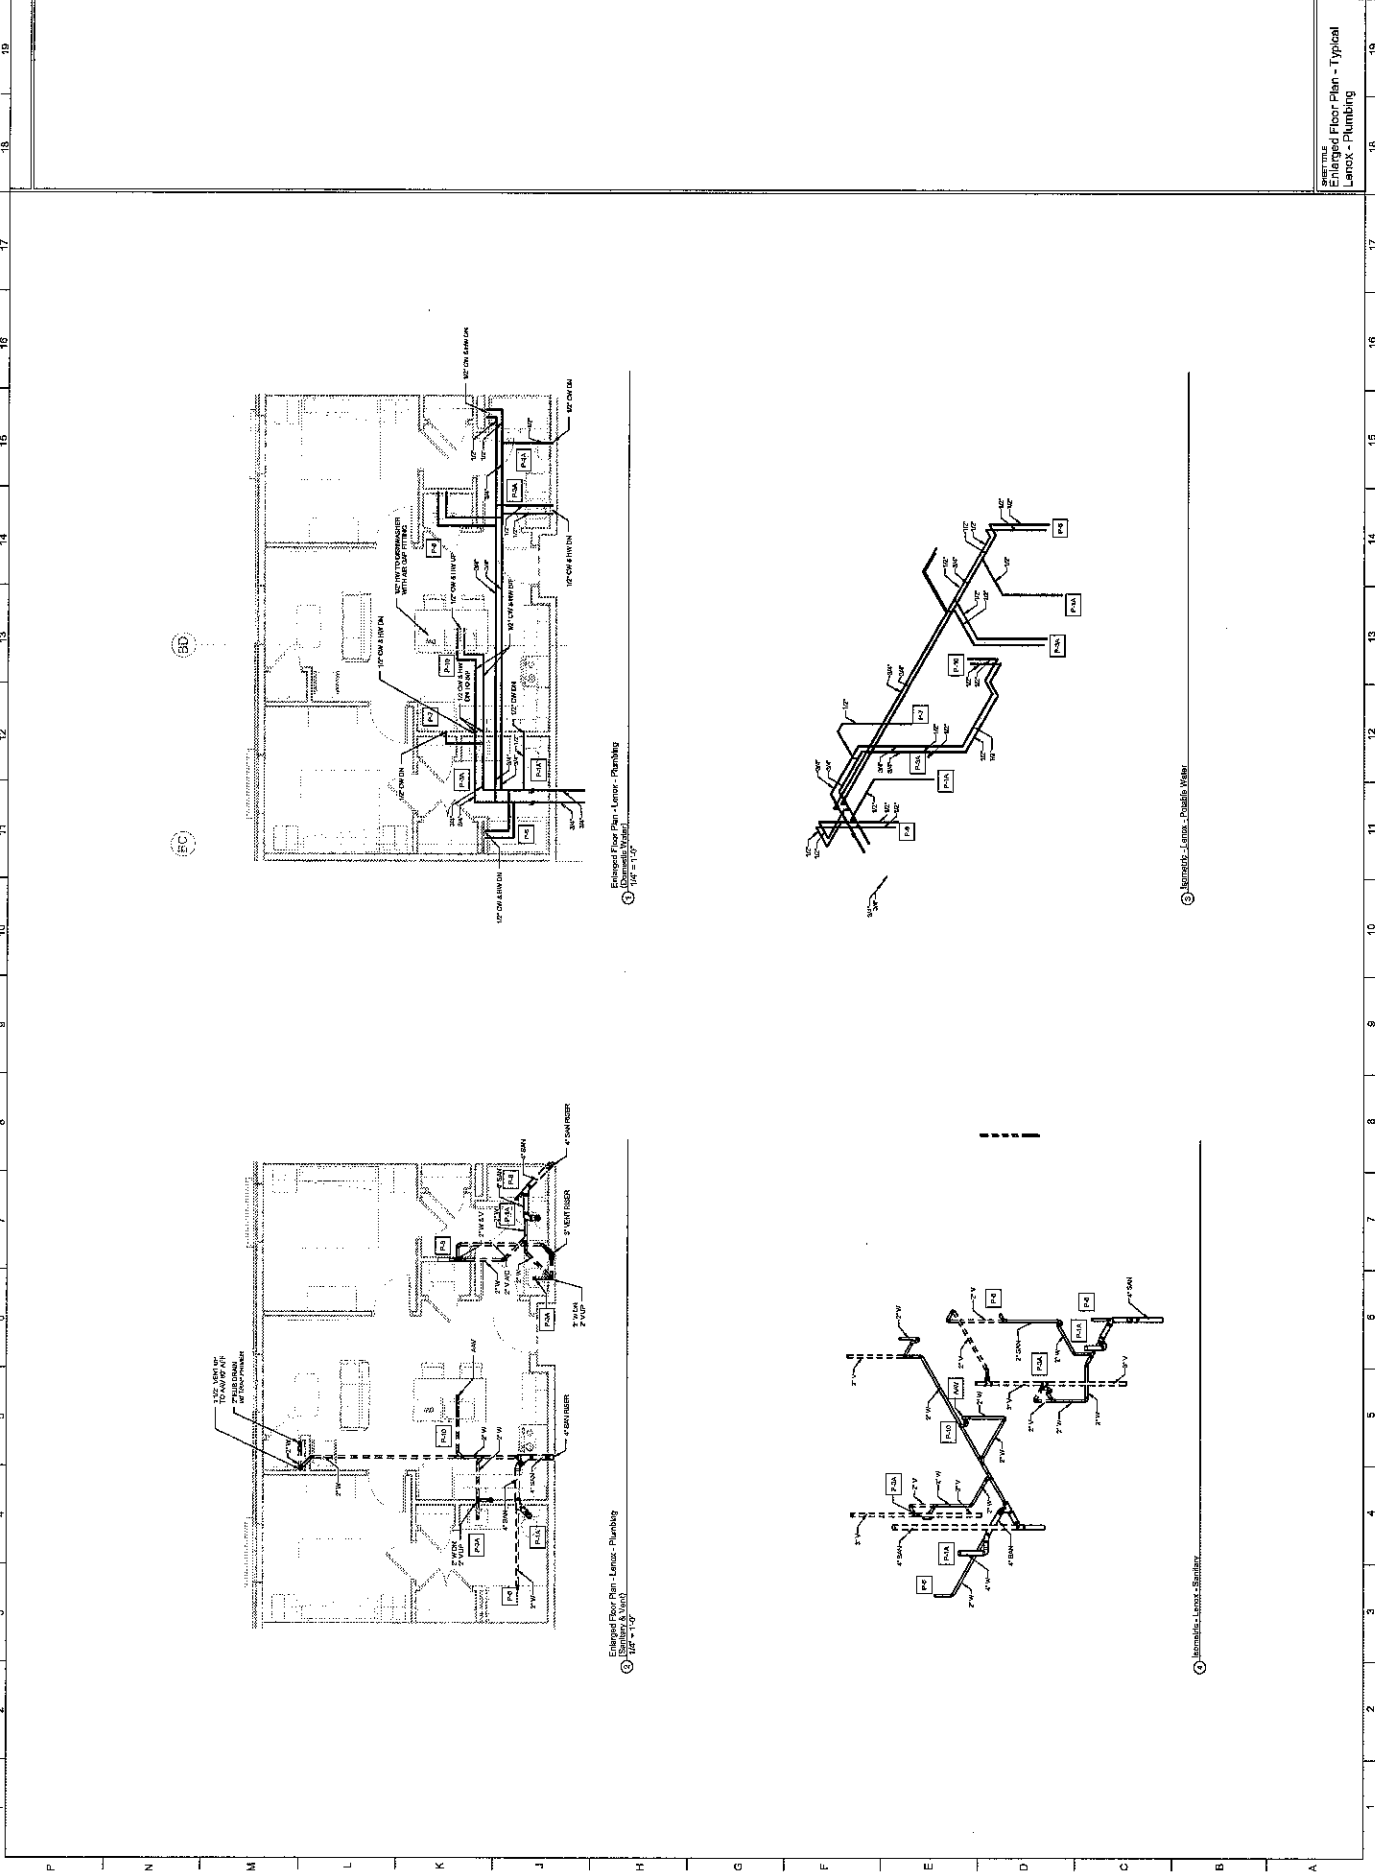

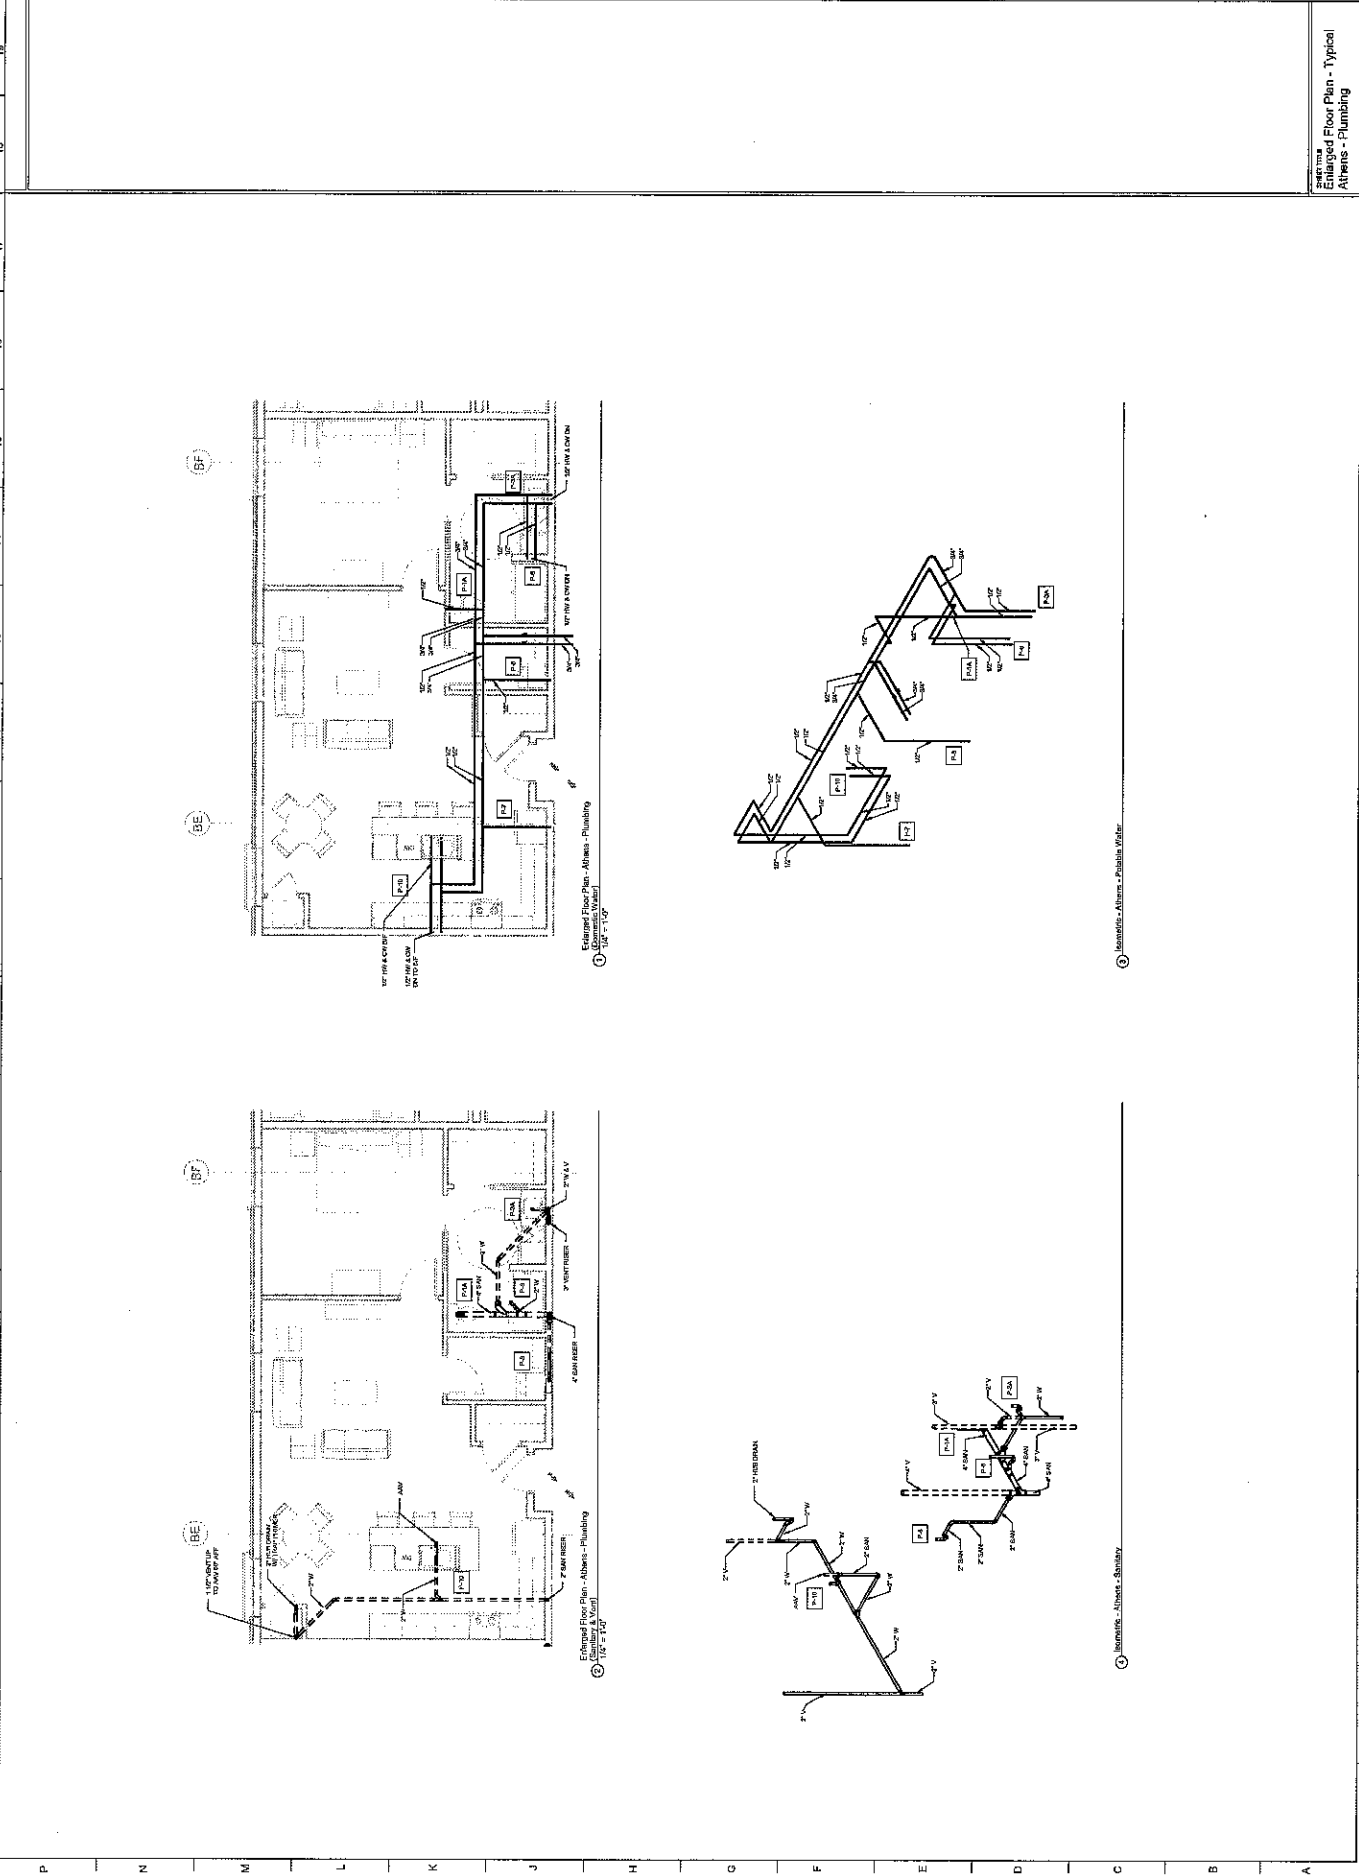


NO.	REVISION	DATE	BY	CHKD.
1	ISSUE FOR PERMIT	08/14/2018	DS	DS


PROJECT NO.	1800079-010-000
DATE	08/14/2018
PROJECT NAME	THE HOLBROOK OF DECATUR
PROJECT ADDRESS	1882 Clairmont Road, Decatur, Georgia 30033
PROJECT OWNER	Solomon Development Services, LLC
PROJECT MANAGER	David L. Smith
PROJECT ENGINEER	David L. Smith

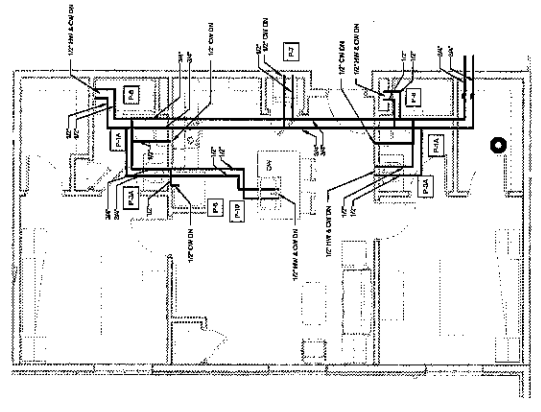


Enlarged Floor Plan - Lender - Plumbing
(Typical View)
180079-010-000

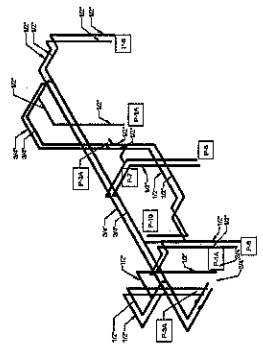


Enlarged Floor Plan - Lender - Drainable Water
180079-010-000


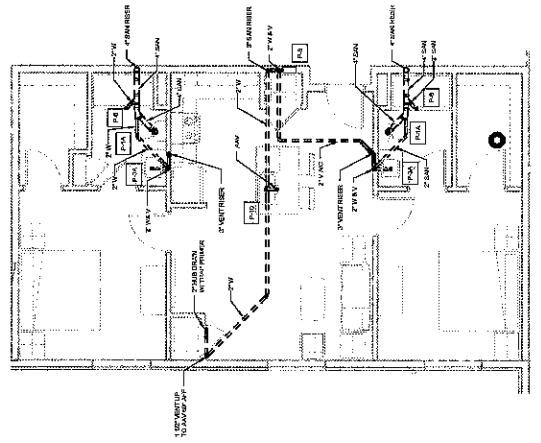


Enlarged Floor Plan - Lender - Plumbing
(Sanitary & Vent)
180079-010-000

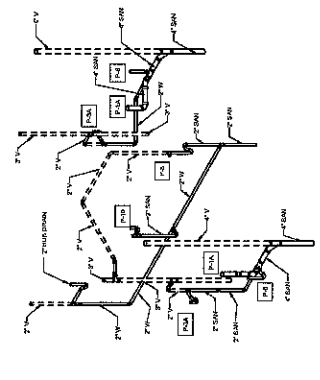

 Enlarged Floor Plan - Lender - Sanitary
180079-010-000




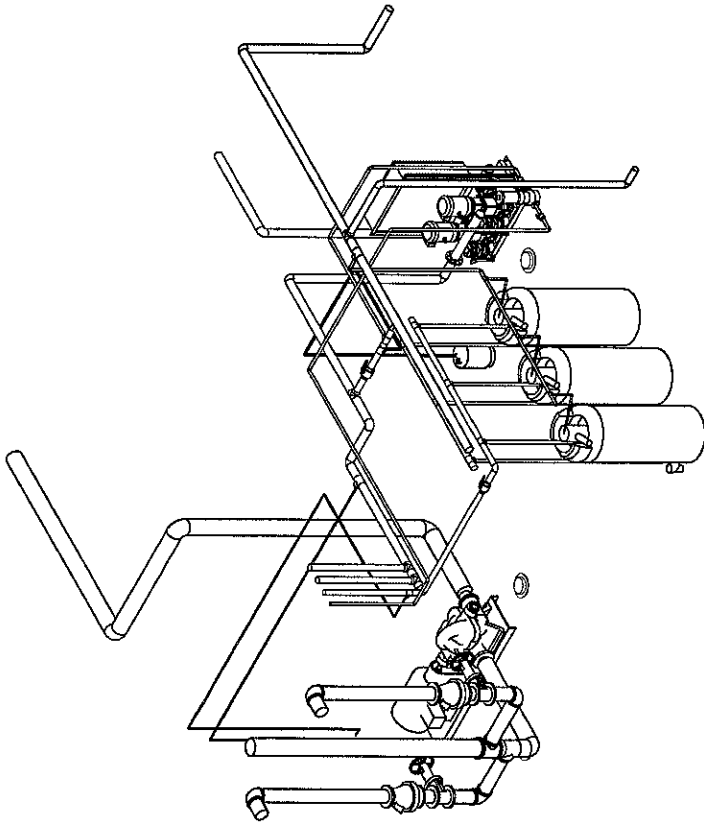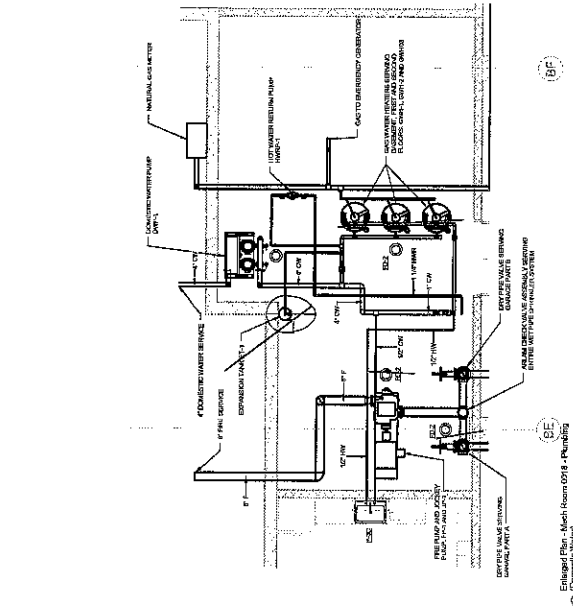


② Music/Mechanical Room

NO.	REVISION	DATE	BY	CHKD.
1	ISSUED FOR PERMIT	08/14/2018	JES	
2	REVISED PER COMMENTS	08/14/2018	JES	
3	REVISED PER COMMENTS	08/14/2018	JES	
4	REVISED PER COMMENTS	08/14/2018	JES	
5	REVISED PER COMMENTS	08/14/2018	JES	
6	REVISED PER COMMENTS	08/14/2018	JES	
7	REVISED PER COMMENTS	08/14/2018	JES	
8	REVISED PER COMMENTS	08/14/2018	JES	
9	REVISED PER COMMENTS	08/14/2018	JES	
10	REVISED PER COMMENTS	08/14/2018	JES	
11	REVISED PER COMMENTS	08/14/2018	JES	
12	REVISED PER COMMENTS	08/14/2018	JES	
13	REVISED PER COMMENTS	08/14/2018	JES	
14	REVISED PER COMMENTS	08/14/2018	JES	
15	REVISED PER COMMENTS	08/14/2018	JES	
16	REVISED PER COMMENTS	08/14/2018	JES	
17	REVISED PER COMMENTS	08/14/2018	JES	
18	REVISED PER COMMENTS	08/14/2018	JES	
19	REVISED PER COMMENTS	08/14/2018	JES	


Blumen Development Services, LLC
1622 Clarendon Road, Decatur, Georgia

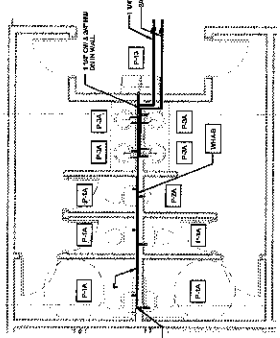


(B) Enlarged Floor Plan - Main Entrance
Main Entrance - (Main Entrance)

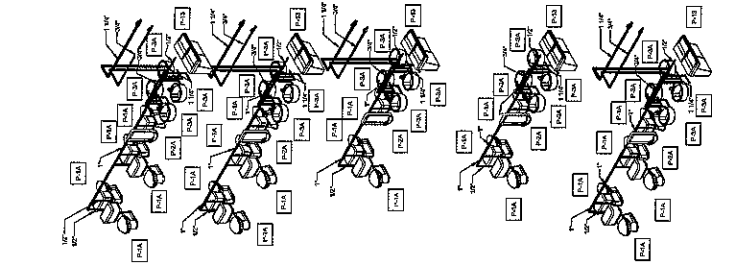

(B) Enlarged Floor Plan - Main Entrance
Main Entrance - (Main Entrance)

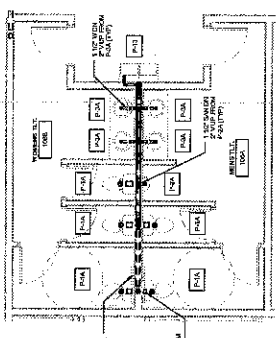

(B) Enlarged Floor Plan - Main Entrance
Main Entrance - (Main Entrance)

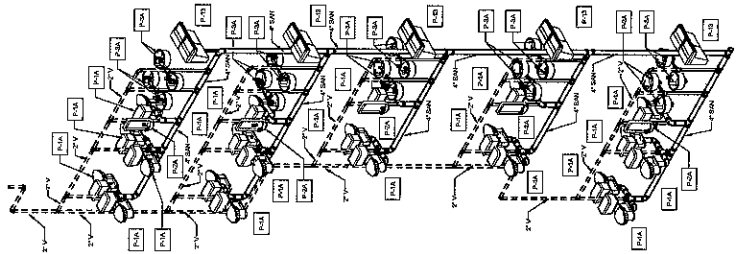


(B) Enlarged Floor Plan - Main Entrance
Main Entrance - (Main Entrance)




NO.	DESCRIPTION	DATE
1	ISSUED FOR PERMIT	08/20/2018
2	REVISION	
3	REVISION	
4	REVISION	
5	REVISION	
6	REVISION	
7	REVISION	
8	REVISION	
9	REVISION	
10	REVISION	
11	REVISION	
12	REVISION	
13	REVISION	
14	REVISION	
15	REVISION	
16	REVISION	
17	REVISION	
18	REVISION	
19	REVISION	


PROJECT NO. 18-0000000000000000
SHEET NO. 18-0000000000000000
DATE: 08/20/2018
DRAWN BY: [Name]
CHECKED BY: [Name]
APPROVED BY: [Name]

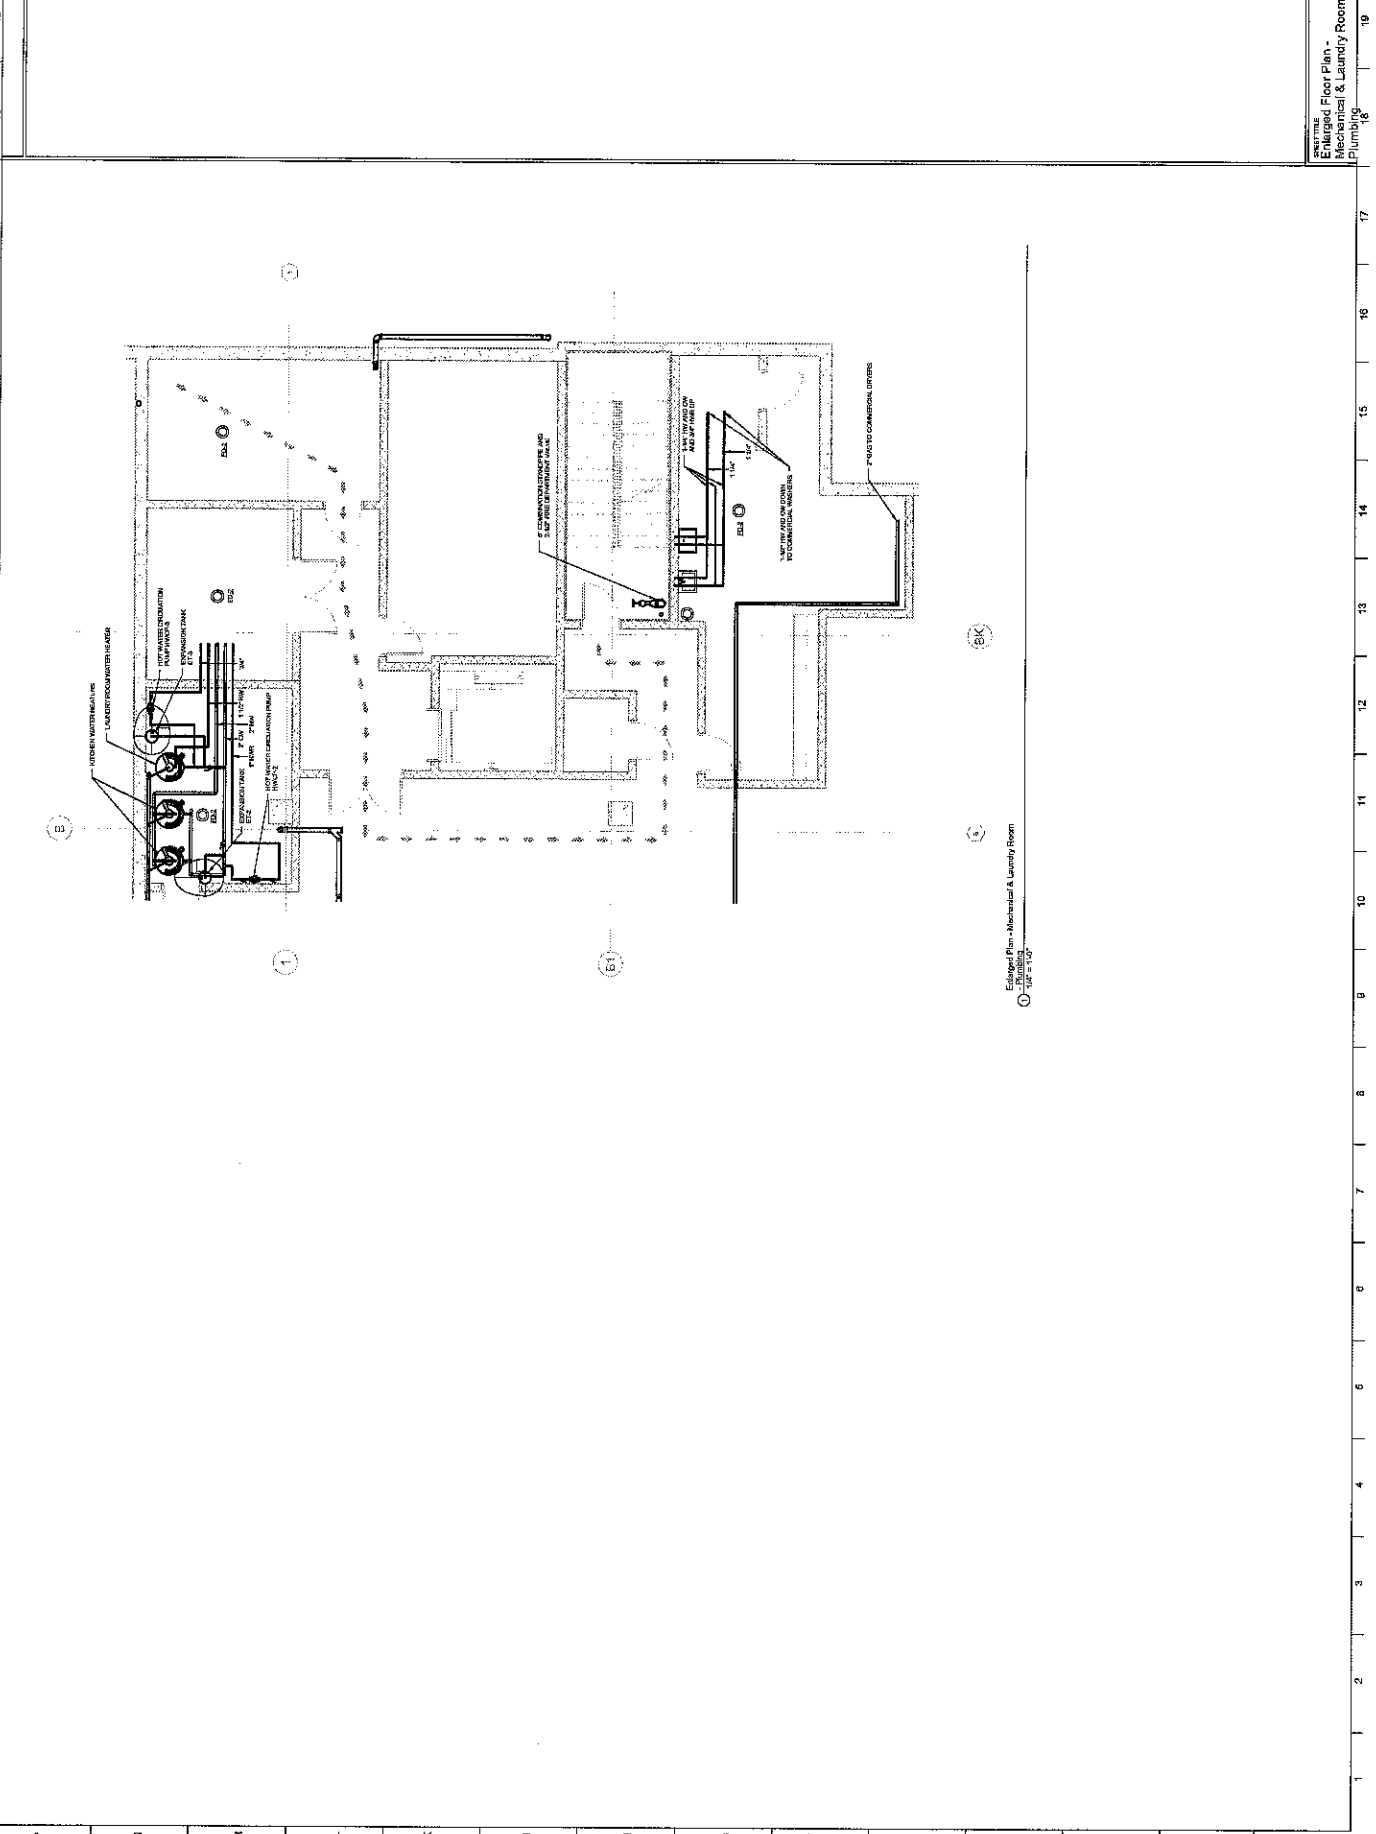


Enlarged Floor Plan - Mechanical & Laundry Room - Plumbing

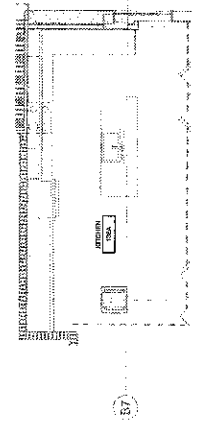


BK1
Kitchen - 1st Level
Plumbing

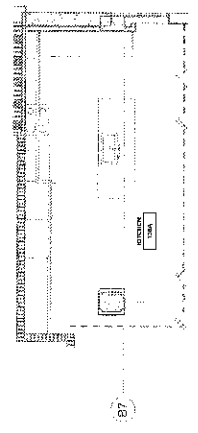

BK2
Kitchen - 1st Level
Plumbing

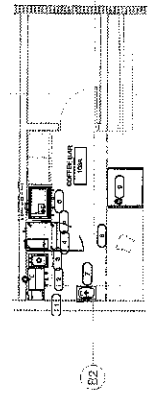

BH1
Coffee Bar - 1st Level
Plumbing

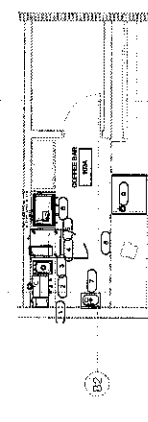


BH2
Coffee Bar - 1st Level
Plumbing

NO.	DESCRIPTION	DATE
1	ISSUED FOR PERMIT	10/10/2020
2	REVISION	
3	REVISION	
4	REVISION	
5	REVISION	
6	REVISION	
7	REVISION	
8	REVISION	
9	REVISION	
10	REVISION	

NO.	DESCRIPTION
1	ISSUED FOR PERMIT
2	REVISION
3	REVISION
4	REVISION
5	REVISION
6	REVISION
7	REVISION
8	REVISION
9	REVISION
10	REVISION

Enlarged Plan - 2nd Level Kitchen -
Plumbing
1/4" = 1'-0"

Enlarged Plan - 2nd Level Kitchen - Sanitary
Plumbing
1/4" = 1'-0"

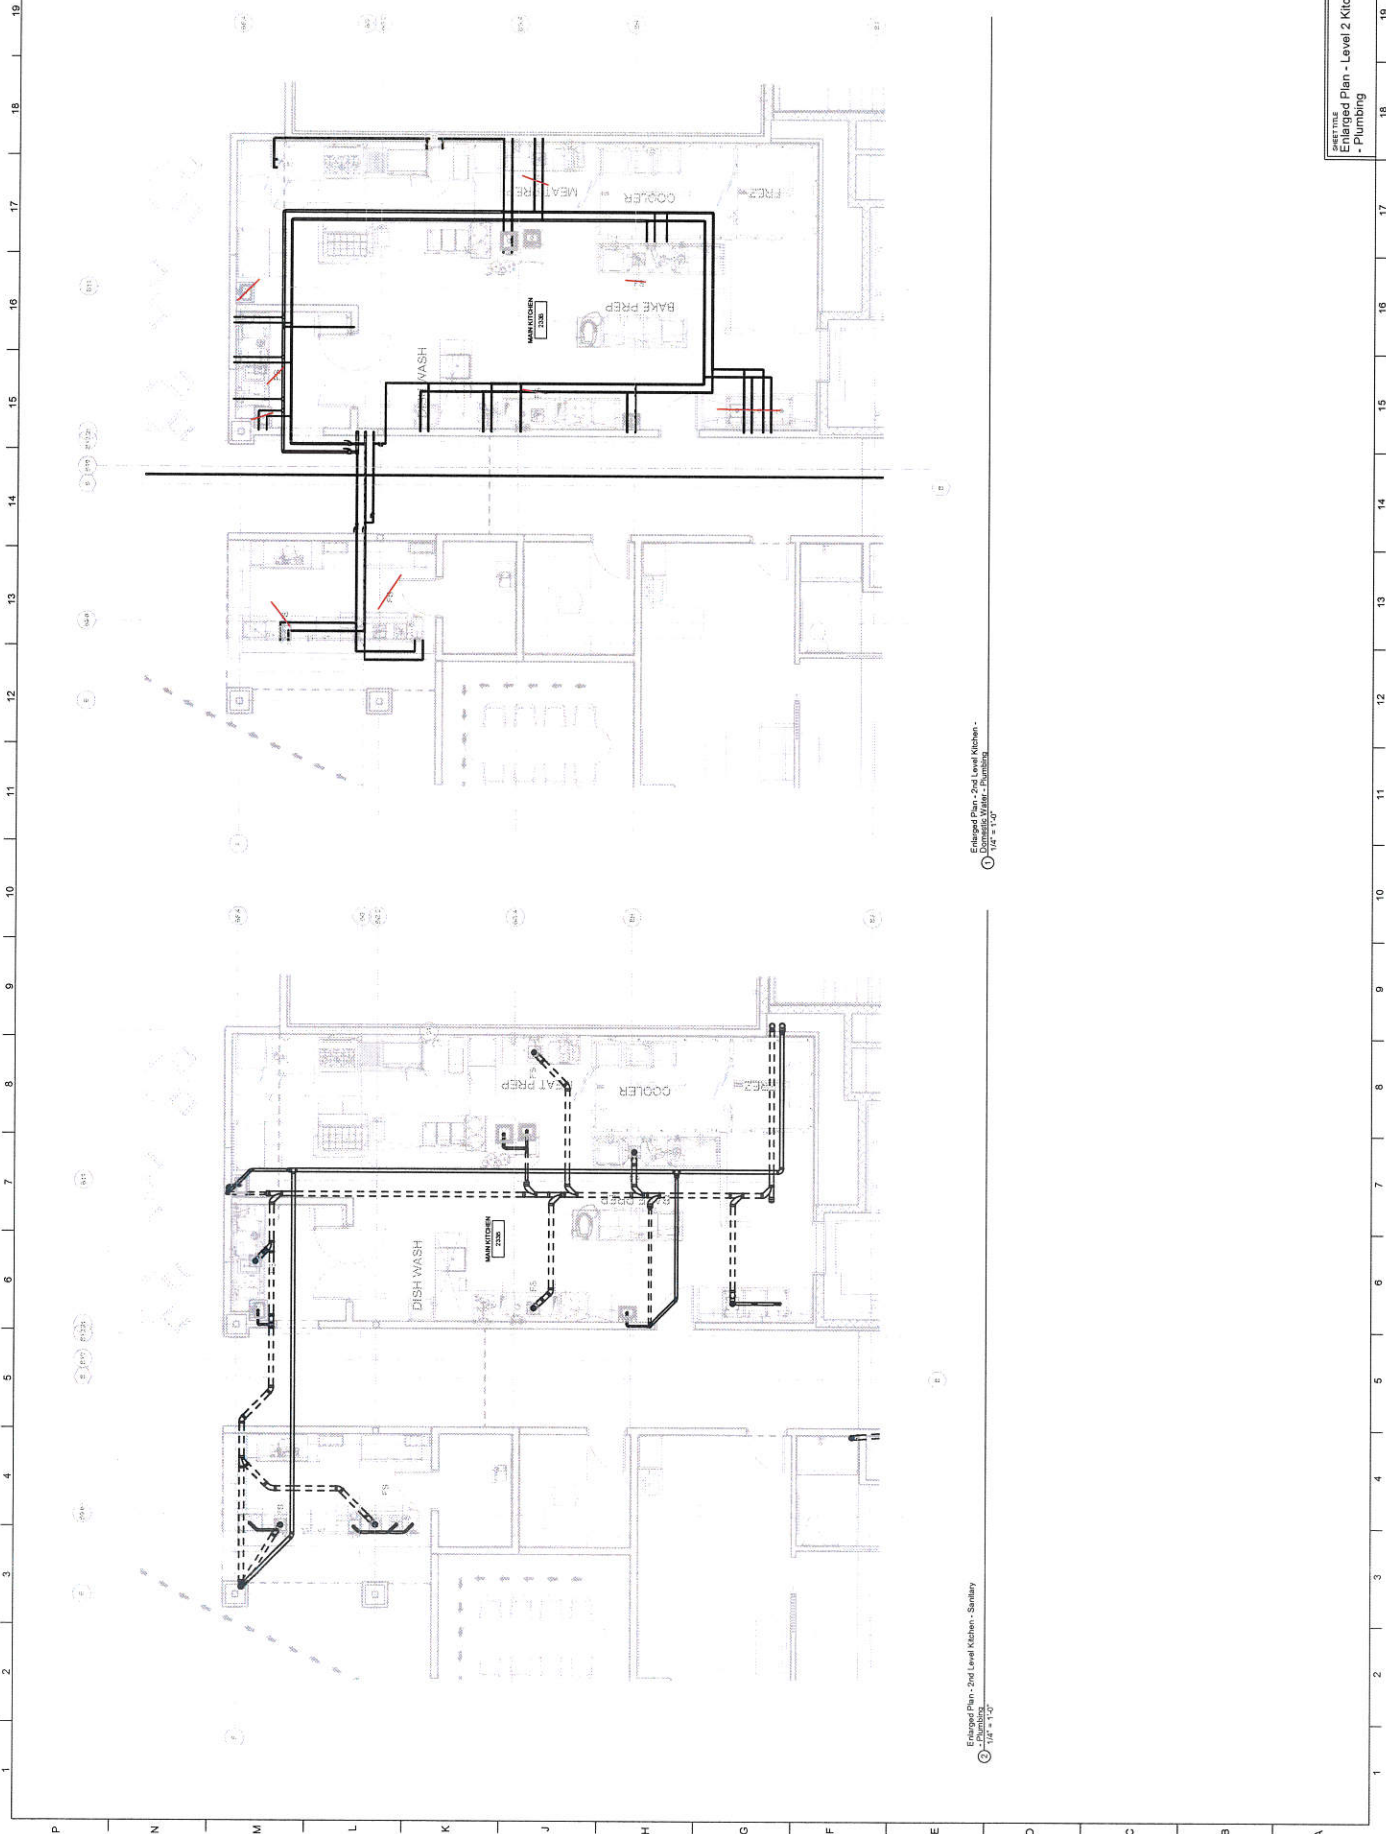


NO.	DESCRIPTION	DATE
1	1.00	12/31/2024
2	2.00	12/31/2024
3	3.00	12/31/2024
4	4.00	12/31/2024
5	5.00	12/31/2024
6	6.00	12/31/2024
7	7.00	12/31/2024
8	8.00	12/31/2024
9	9.00	12/31/2024
10	10.00	12/31/2024
11	11.00	12/31/2024
12	12.00	12/31/2024
13	13.00	12/31/2024
14	14.00	12/31/2024
15	15.00	12/31/2024
16	16.00	12/31/2024
17	17.00	12/31/2024
18	18.00	12/31/2024
19	19.00	12/31/2024

PROJECT NO. 1855
 SHEET NO. 1855-1855
 DATE 12/31/2024

P317

Enlarged Plan - 3rd Level Balcony
 Kitchen - Plumbing


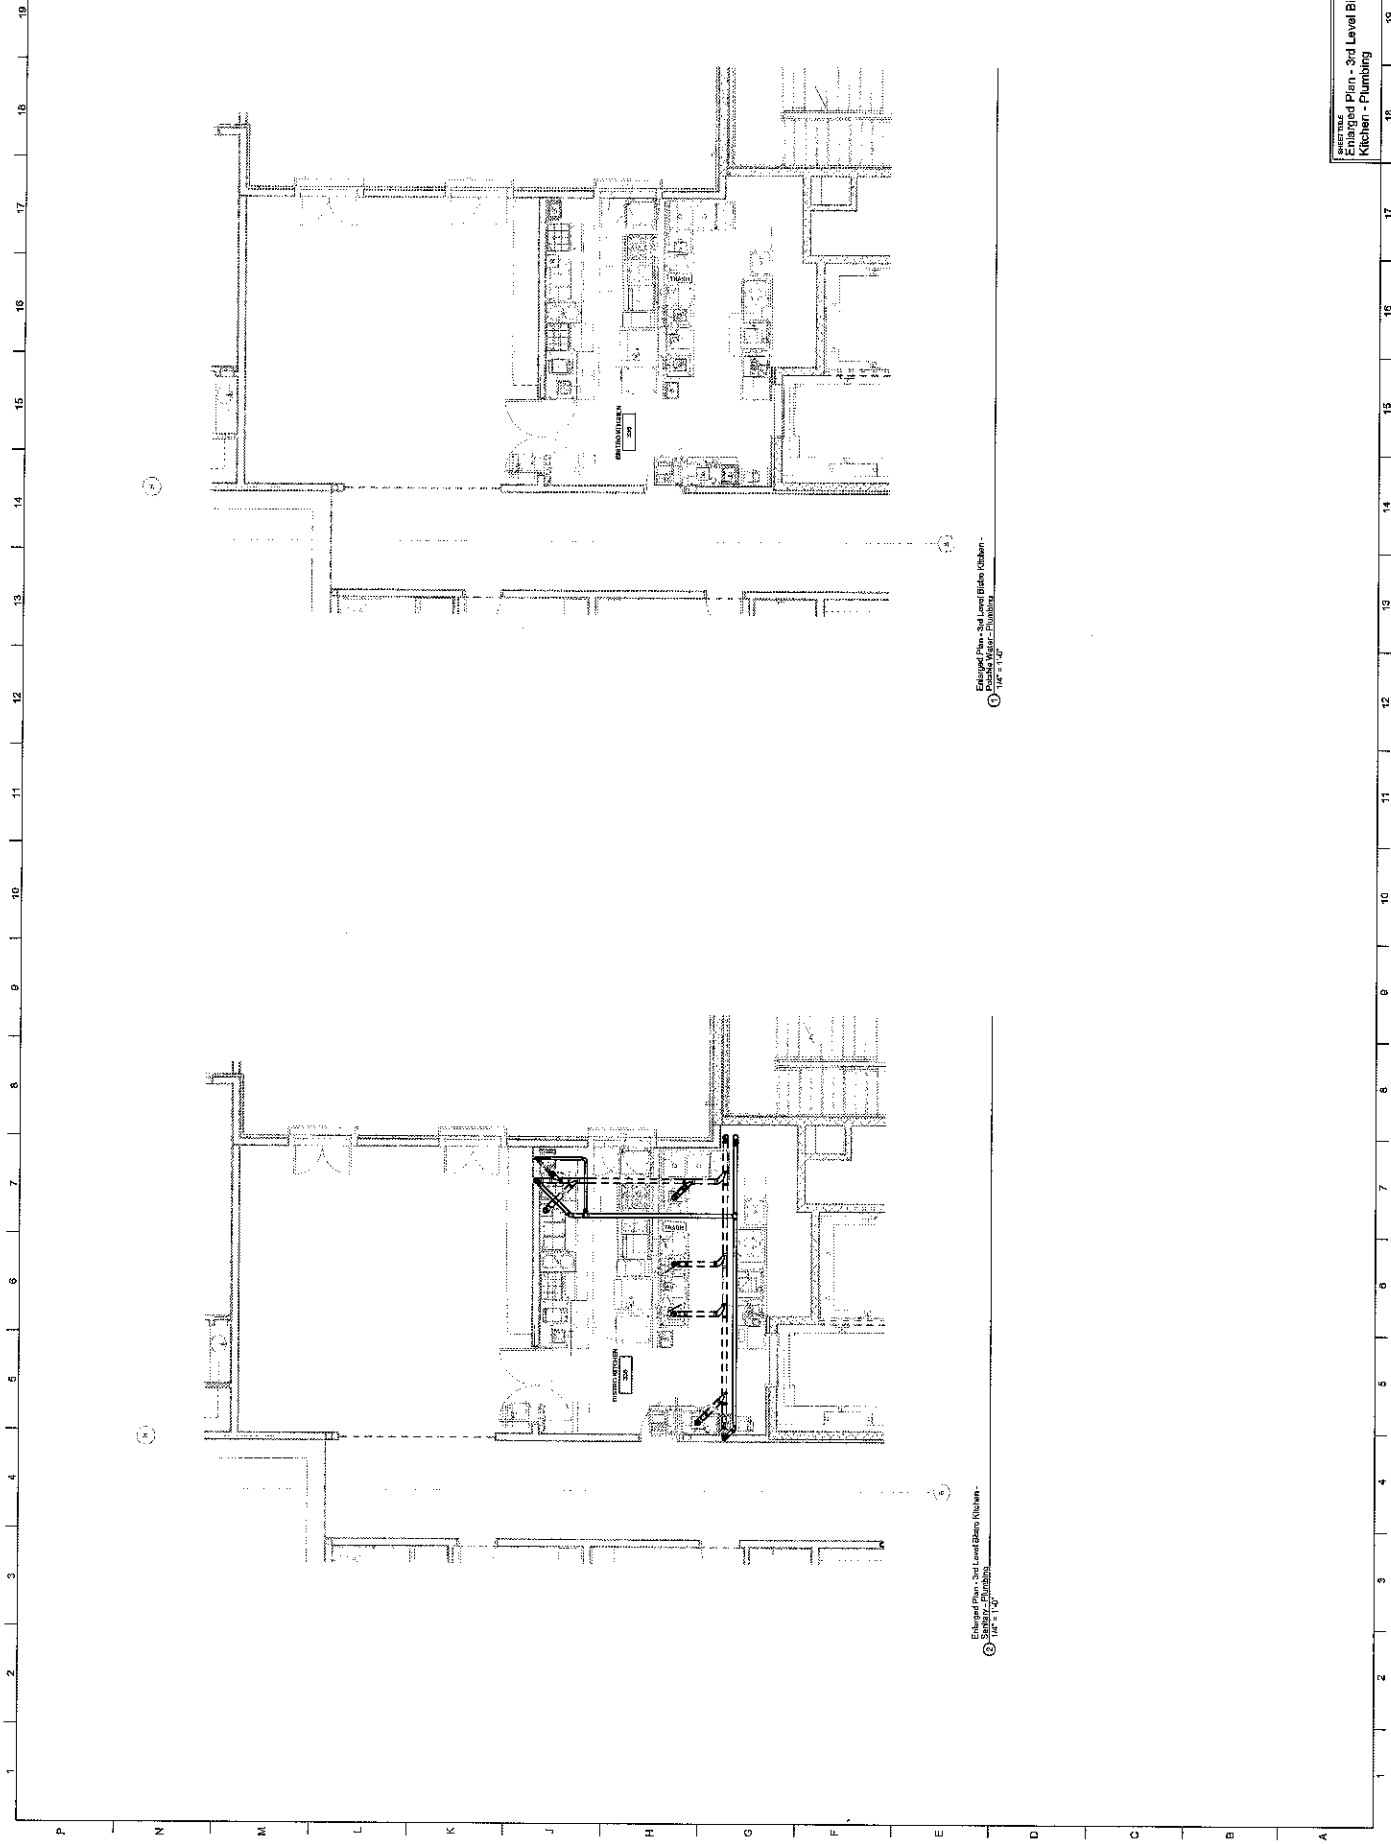



NO.	DESCRIPTION	DATE
1	ISSUED FOR PERMIT	10/12/17
2	ISSUED FOR PERMIT	10/12/17
3	ISSUED FOR PERMIT	10/12/17
4	ISSUED FOR PERMIT	10/12/17
5	ISSUED FOR PERMIT	10/12/17
6	ISSUED FOR PERMIT	10/12/17
7	ISSUED FOR PERMIT	10/12/17
8	ISSUED FOR PERMIT	10/12/17
9	ISSUED FOR PERMIT	10/12/17
10	ISSUED FOR PERMIT	10/12/17
11	ISSUED FOR PERMIT	10/12/17
12	ISSUED FOR PERMIT	10/12/17
13	ISSUED FOR PERMIT	10/12/17
14	ISSUED FOR PERMIT	10/12/17
15	ISSUED FOR PERMIT	10/12/17
16	ISSUED FOR PERMIT	10/12/17
17	ISSUED FOR PERMIT	10/12/17
18	ISSUED FOR PERMIT	10/12/17
19	ISSUED FOR PERMIT	10/12/17

PROJECT NO: 15562
 DRAWN BY: DHH
 CHECKED BY: DHH
 DATE: 10/12/17

P318

Enlarged Plan - 4th Level
 Kitchen - Plumbing

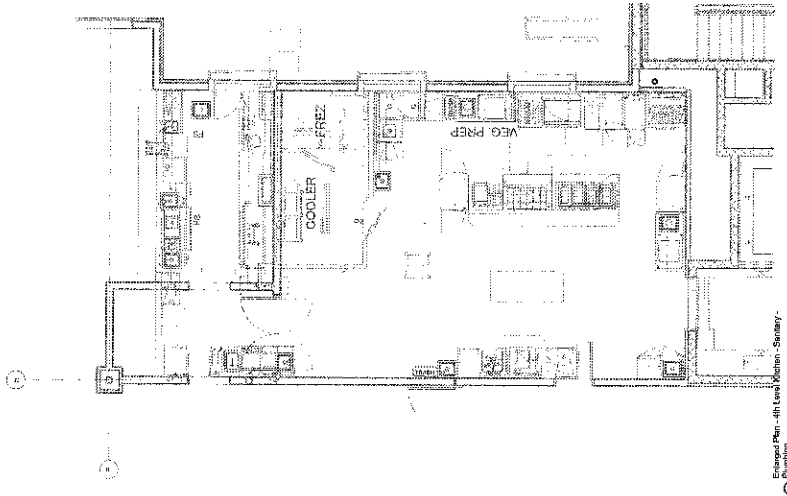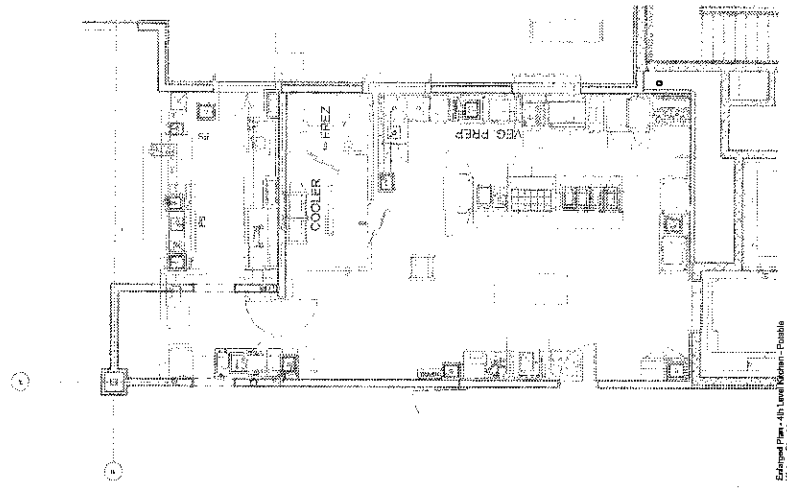

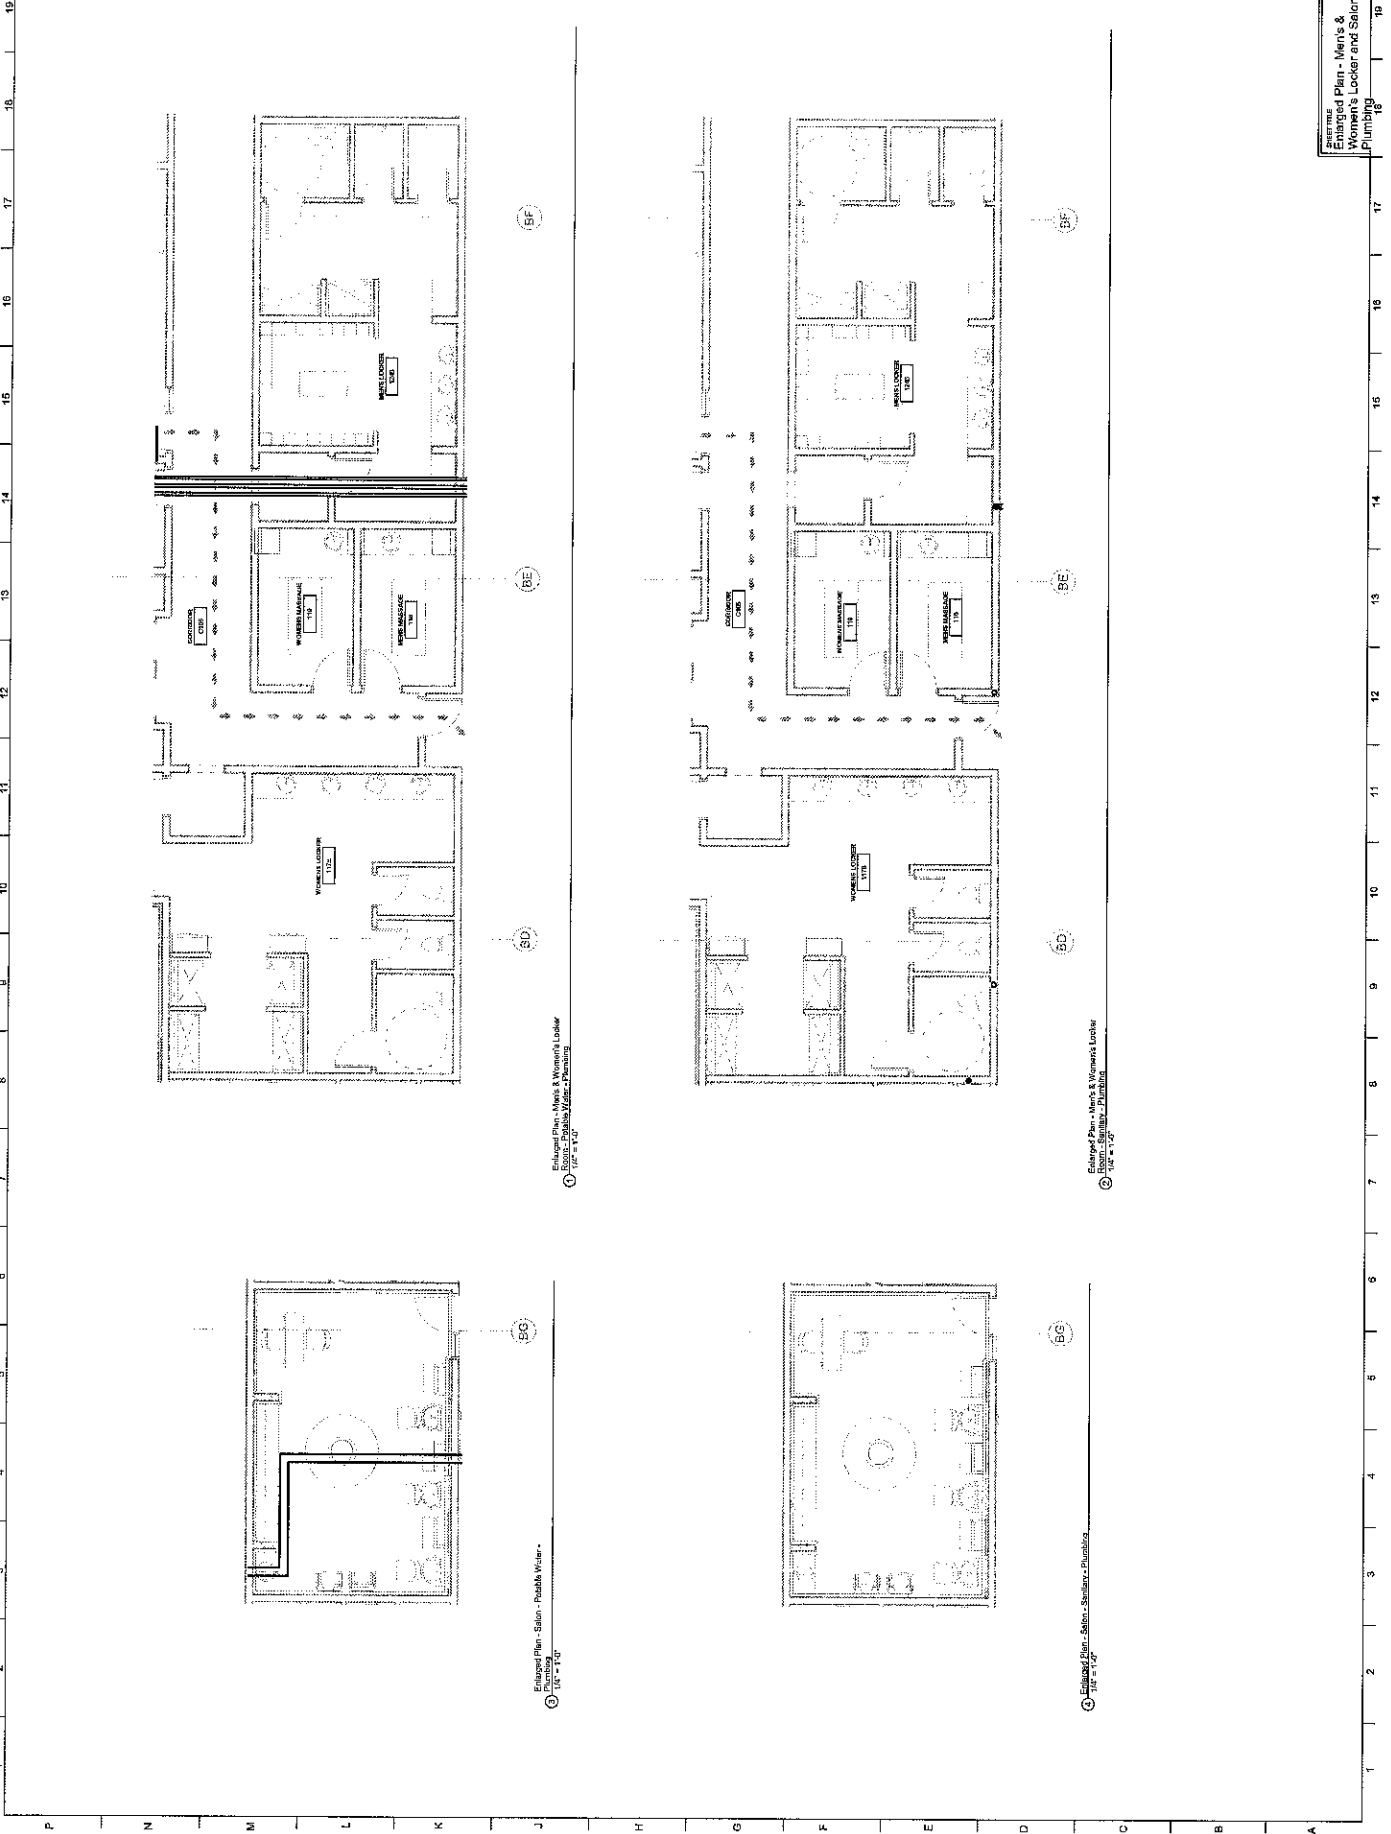

1 METALLIC PIPING & CONDUIT FIRE BARRIER PENETRATION DETAIL
P401 SCALE: NONE

NOTES:
1. All penetrations shall be sealed with fire-rated material (minimum 2-hour rating) and shall be tested in accordance with NFPA 285.
2. Penetrations shall be sealed with fire-rated material (minimum 2-hour rating) and shall be tested in accordance with NFPA 285.
3. Penetrations shall be sealed with fire-rated material (minimum 2-hour rating) and shall be tested in accordance with NFPA 285.

2 TYPICAL HANDICAP FIXTURES
P401 SCALE: NONE

NOTES:
1. SEE APPROPRIATE CODES FOR HANDICAP FIXTURES.
2. PROVIDE OFFSET RAMP FOR HANDICAP FIXTURES.
3. PROVIDE OFFSET RAMP FOR HANDICAP FIXTURES.

3 GREASE TRAP DETAIL
P401 SCALE: NONE

NOTES:
1. PROVIDE GREASE TRAP FOR ALL GREASE TRAP APPLICATIONS.
2. PROVIDE GREASE TRAP FOR ALL GREASE TRAP APPLICATIONS.

4 TYP. IN-LINE PUMP DETAIL
P401 SCALE: NONE


NOTES:
1. PROVIDE IN-LINE PUMP FOR ALL IN-LINE PUMP APPLICATIONS.
2. PROVIDE IN-LINE PUMP FOR ALL IN-LINE PUMP APPLICATIONS.

5 SUMP PUMP DETAIL
P401 SCALE: NONE

NOTES:
1. PROVIDE SUMP PUMP FOR ALL SUMP PUMP APPLICATIONS.
2. PROVIDE SUMP PUMP FOR ALL SUMP PUMP APPLICATIONS.

6 METALLIC PIPING & CONDUIT FIRE BARRIER PENETRATION DETAIL
P401 SCALE: NONE

NOTES:
1. All penetrations shall be sealed with fire-rated material (minimum 2-hour rating) and shall be tested in accordance with NFPA 285.
2. Penetrations shall be sealed with fire-rated material (minimum 2-hour rating) and shall be tested in accordance with NFPA 285.
3. Penetrations shall be sealed with fire-rated material (minimum 2-hour rating) and shall be tested in accordance with NFPA 285.

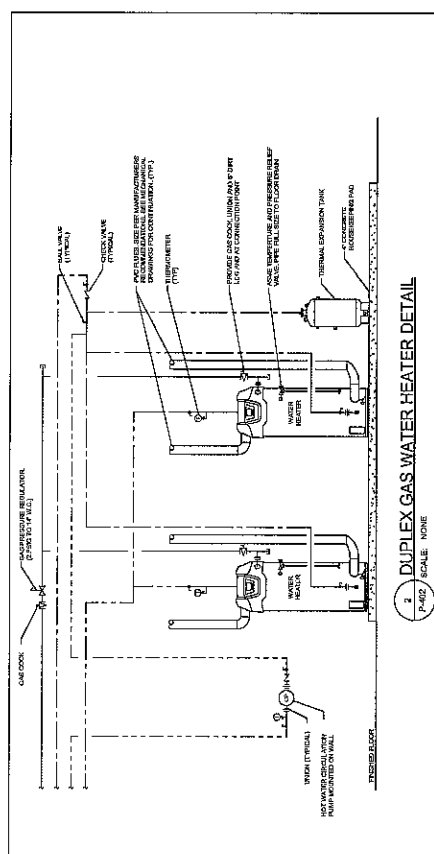




1	101	102	103	500
---	-----	-----	
CONTRACT NO. 15002717-01314 PM

P500

Riser Diagrams

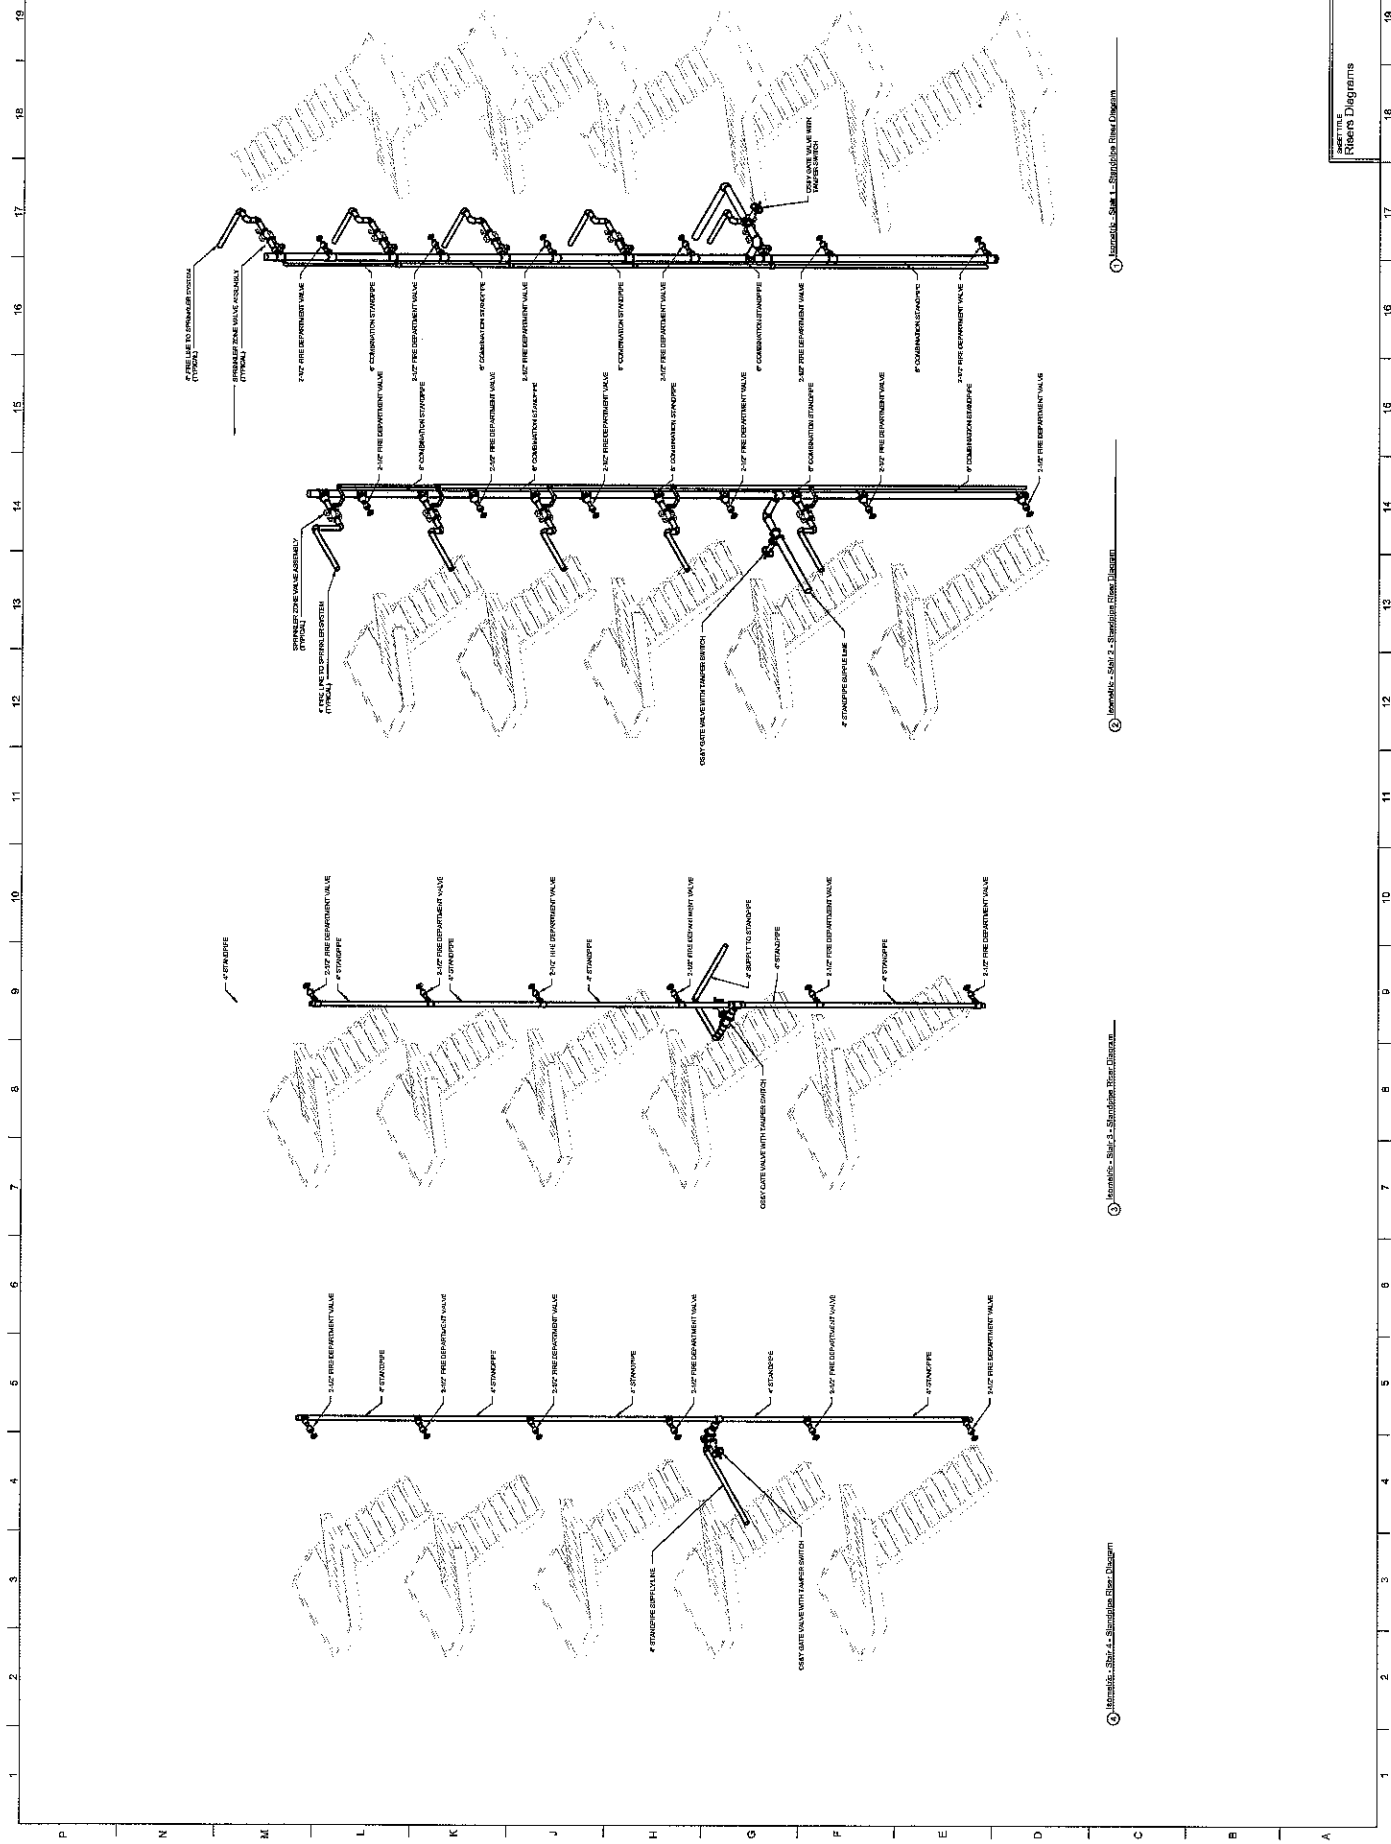

① Intermediate - Shaft 1 - Standpipe Riser Diagram

② Intermediate - Shaft 2 - Standpipe Riser Diagram

③ Intermediate - Shaft 3 - Standpipe Riser Diagram