




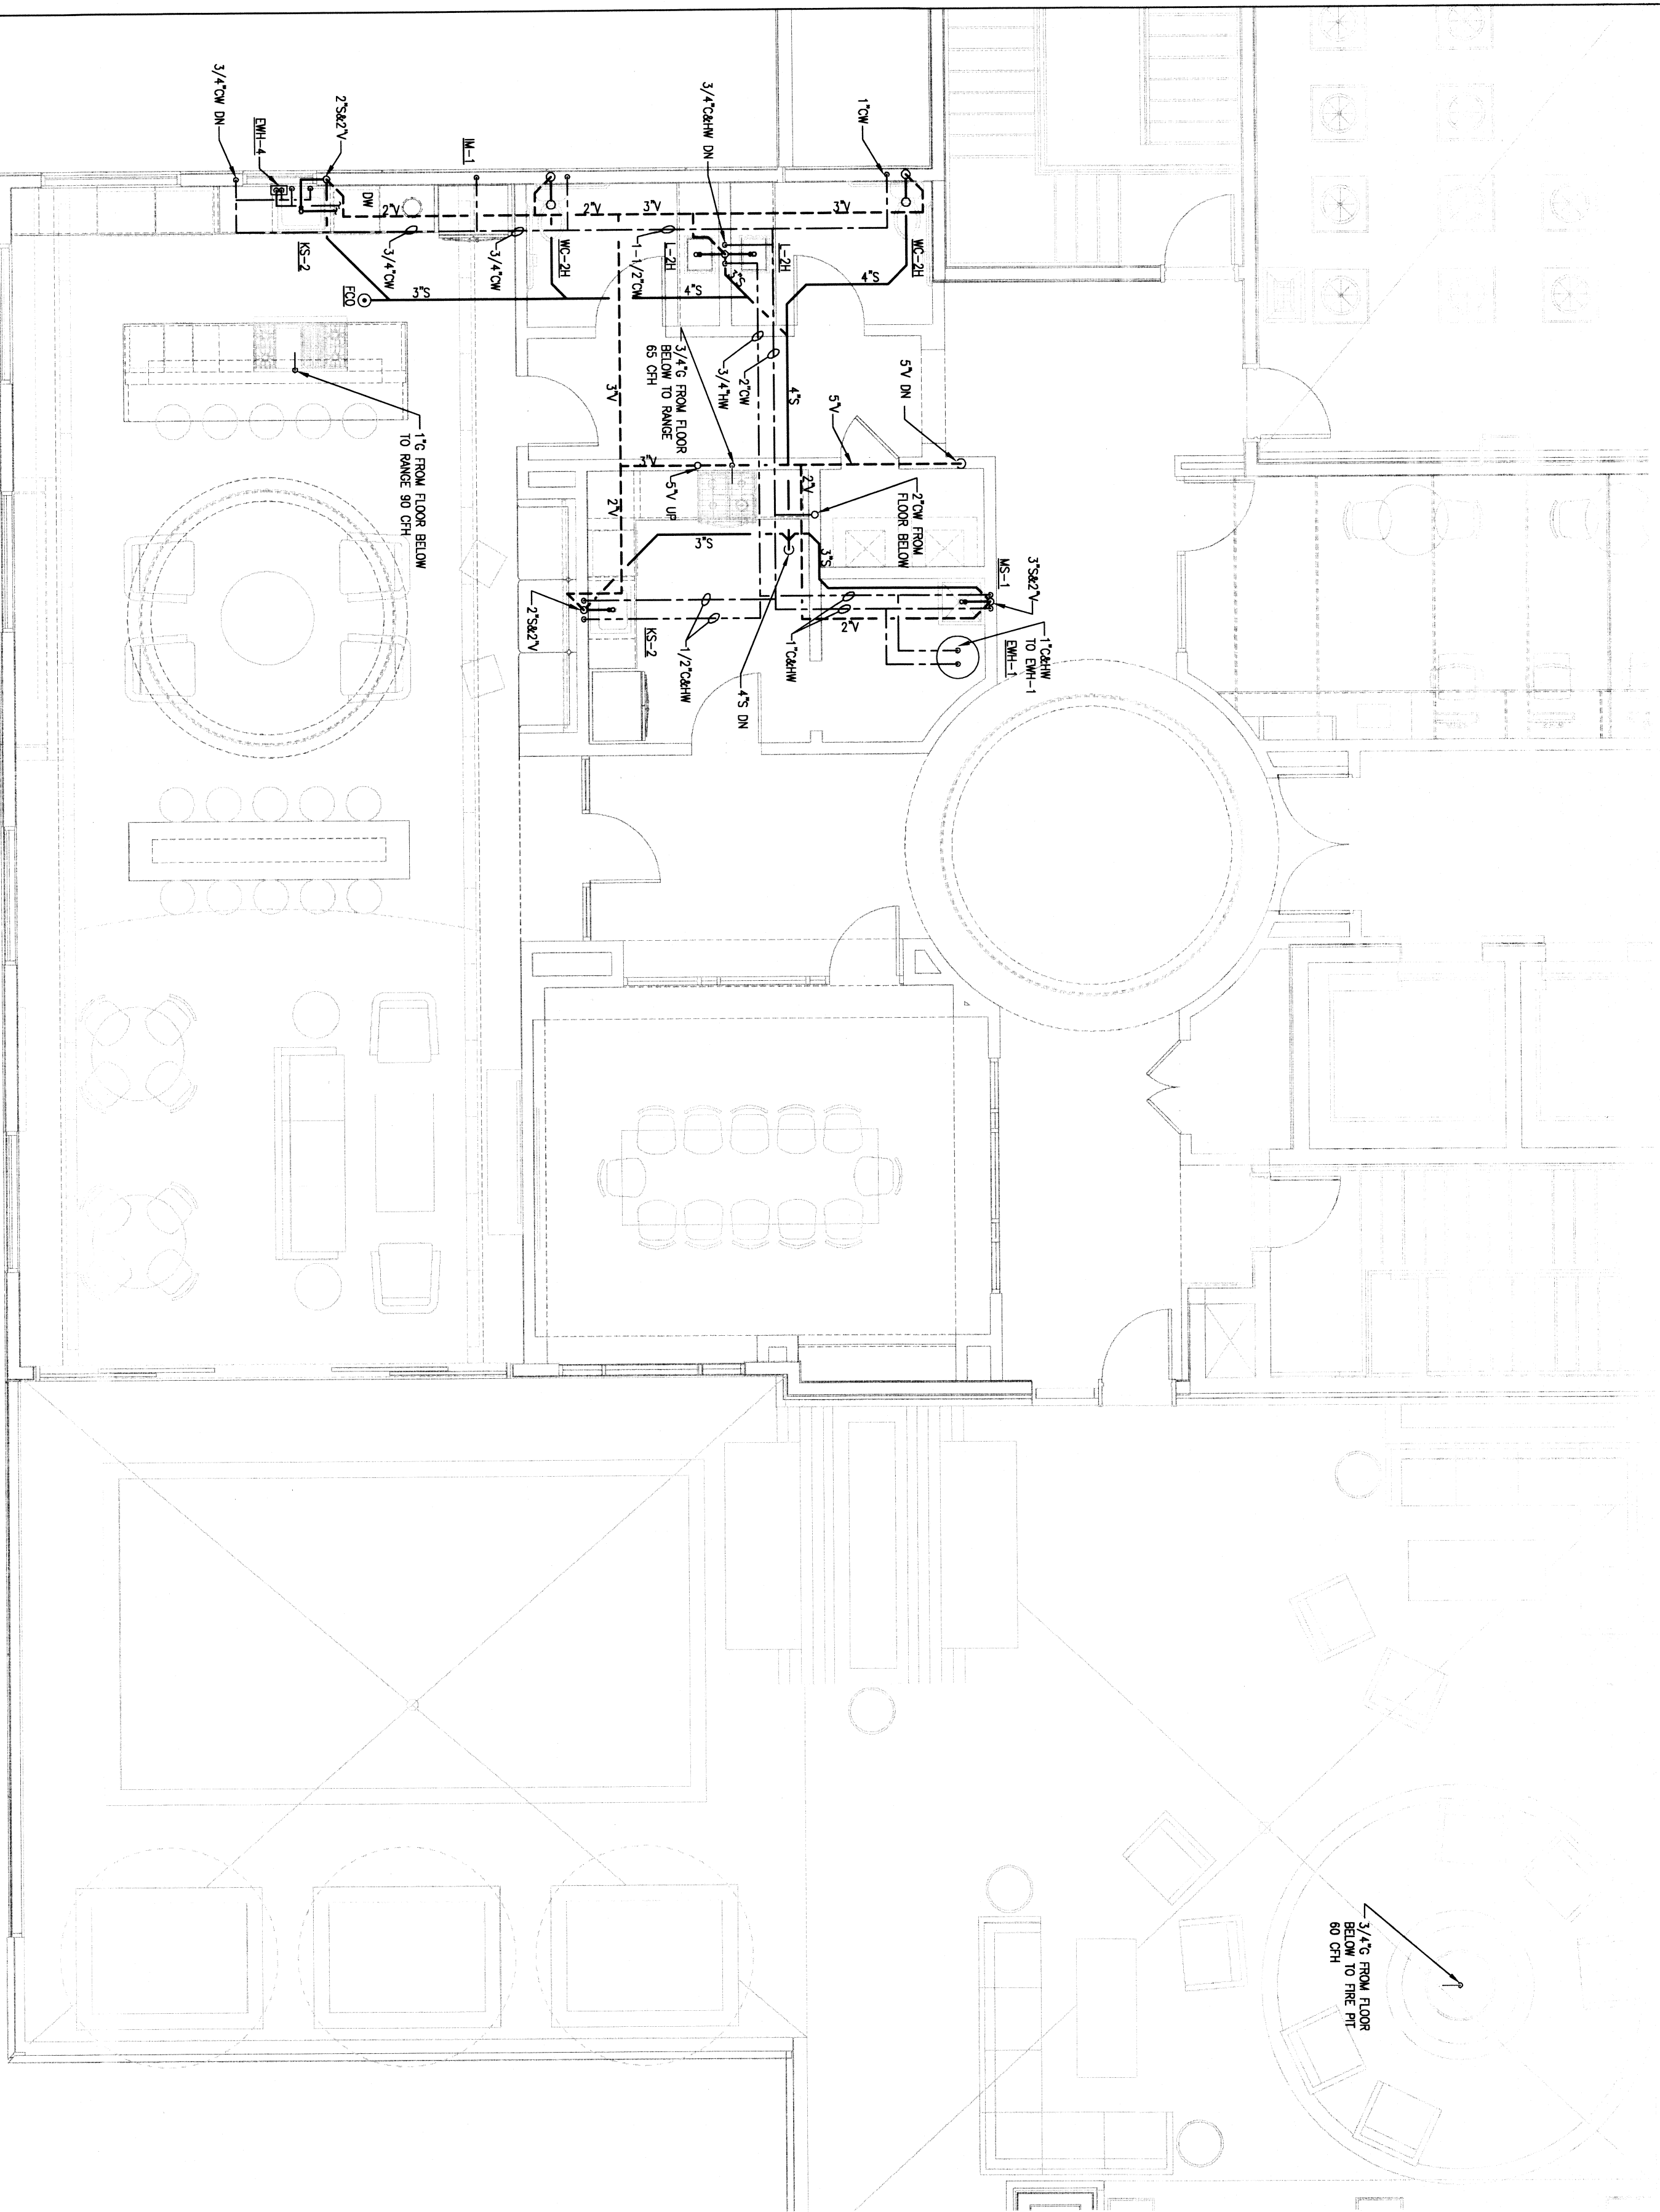


3 LEVEL 12 CLUB, PLUMBING PLAN
P.L.O.T. 1/4\"/>

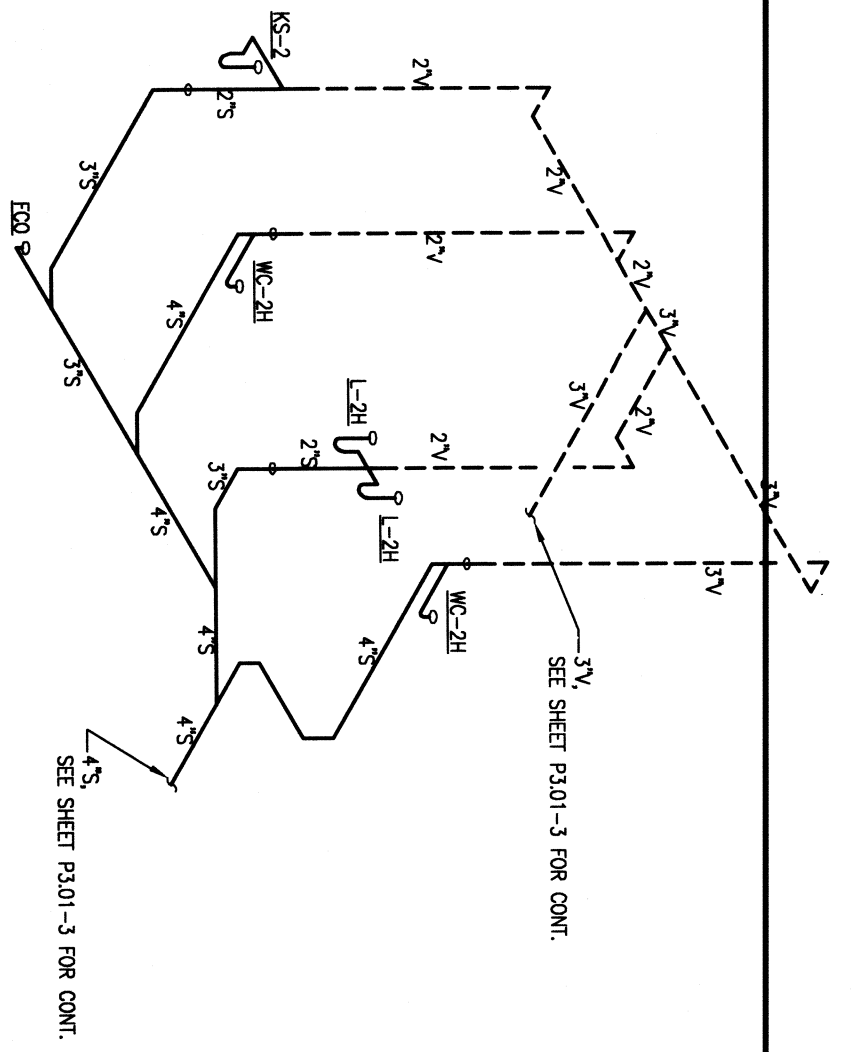


4 LEVEL 12 CLUB, RESTROOM SANITARY RISER
P.L.O.T. 1/4\"/>

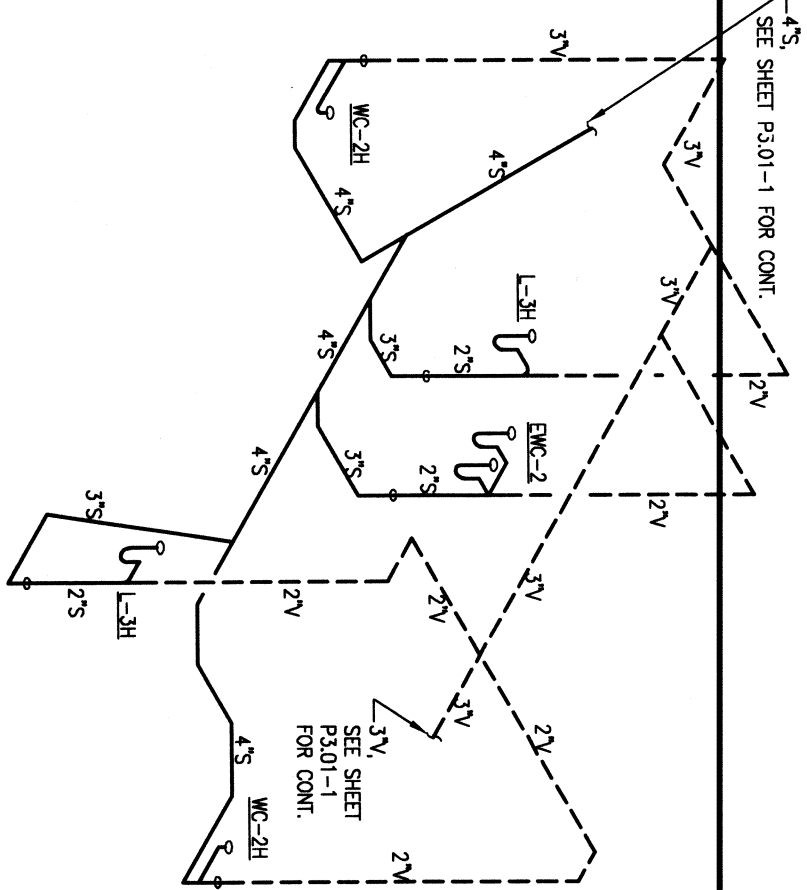


5 LEVEL 3, LEASING, RESTROOM SANITARY RISER
P.L.O.T. 1/4\"/>

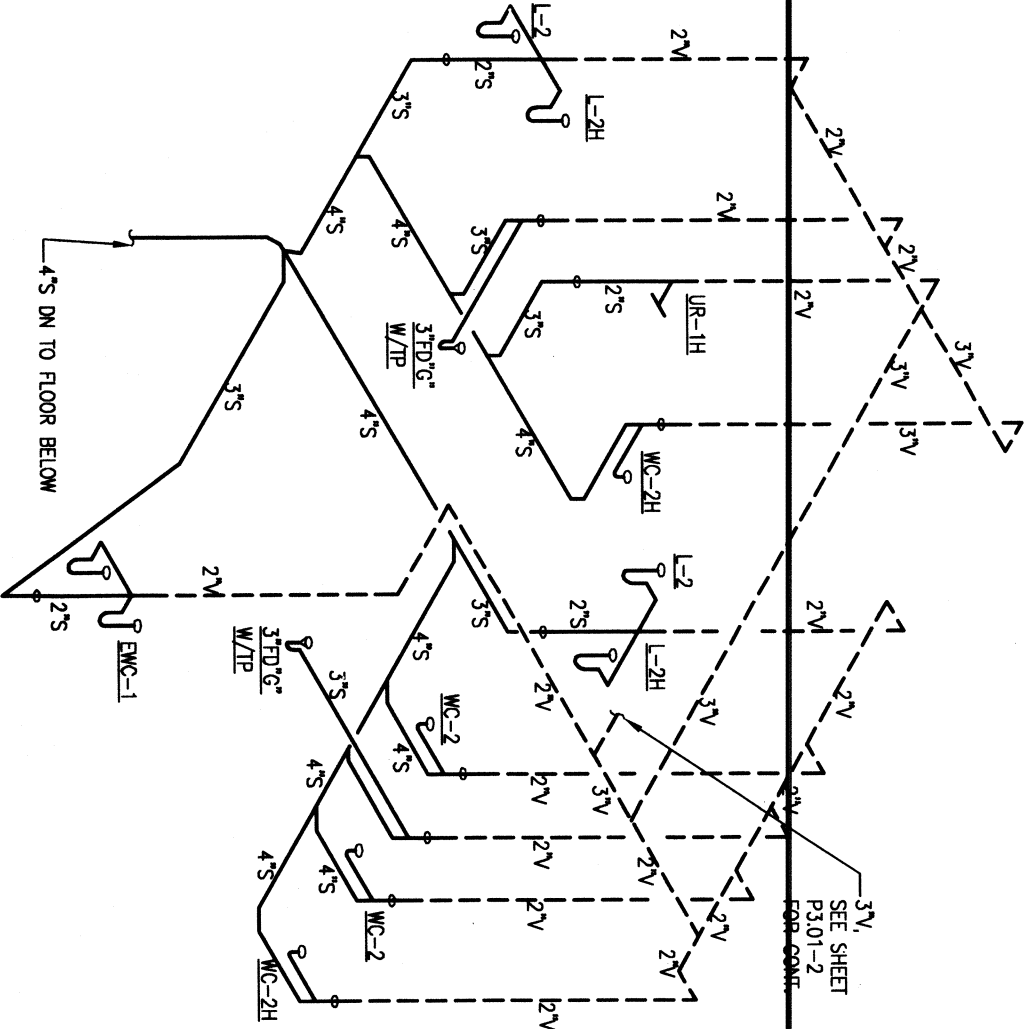


6 LEVEL 4, FITNESS, RESTROOM SANITARY RISER
P.L.O.T. 1/4\"/>

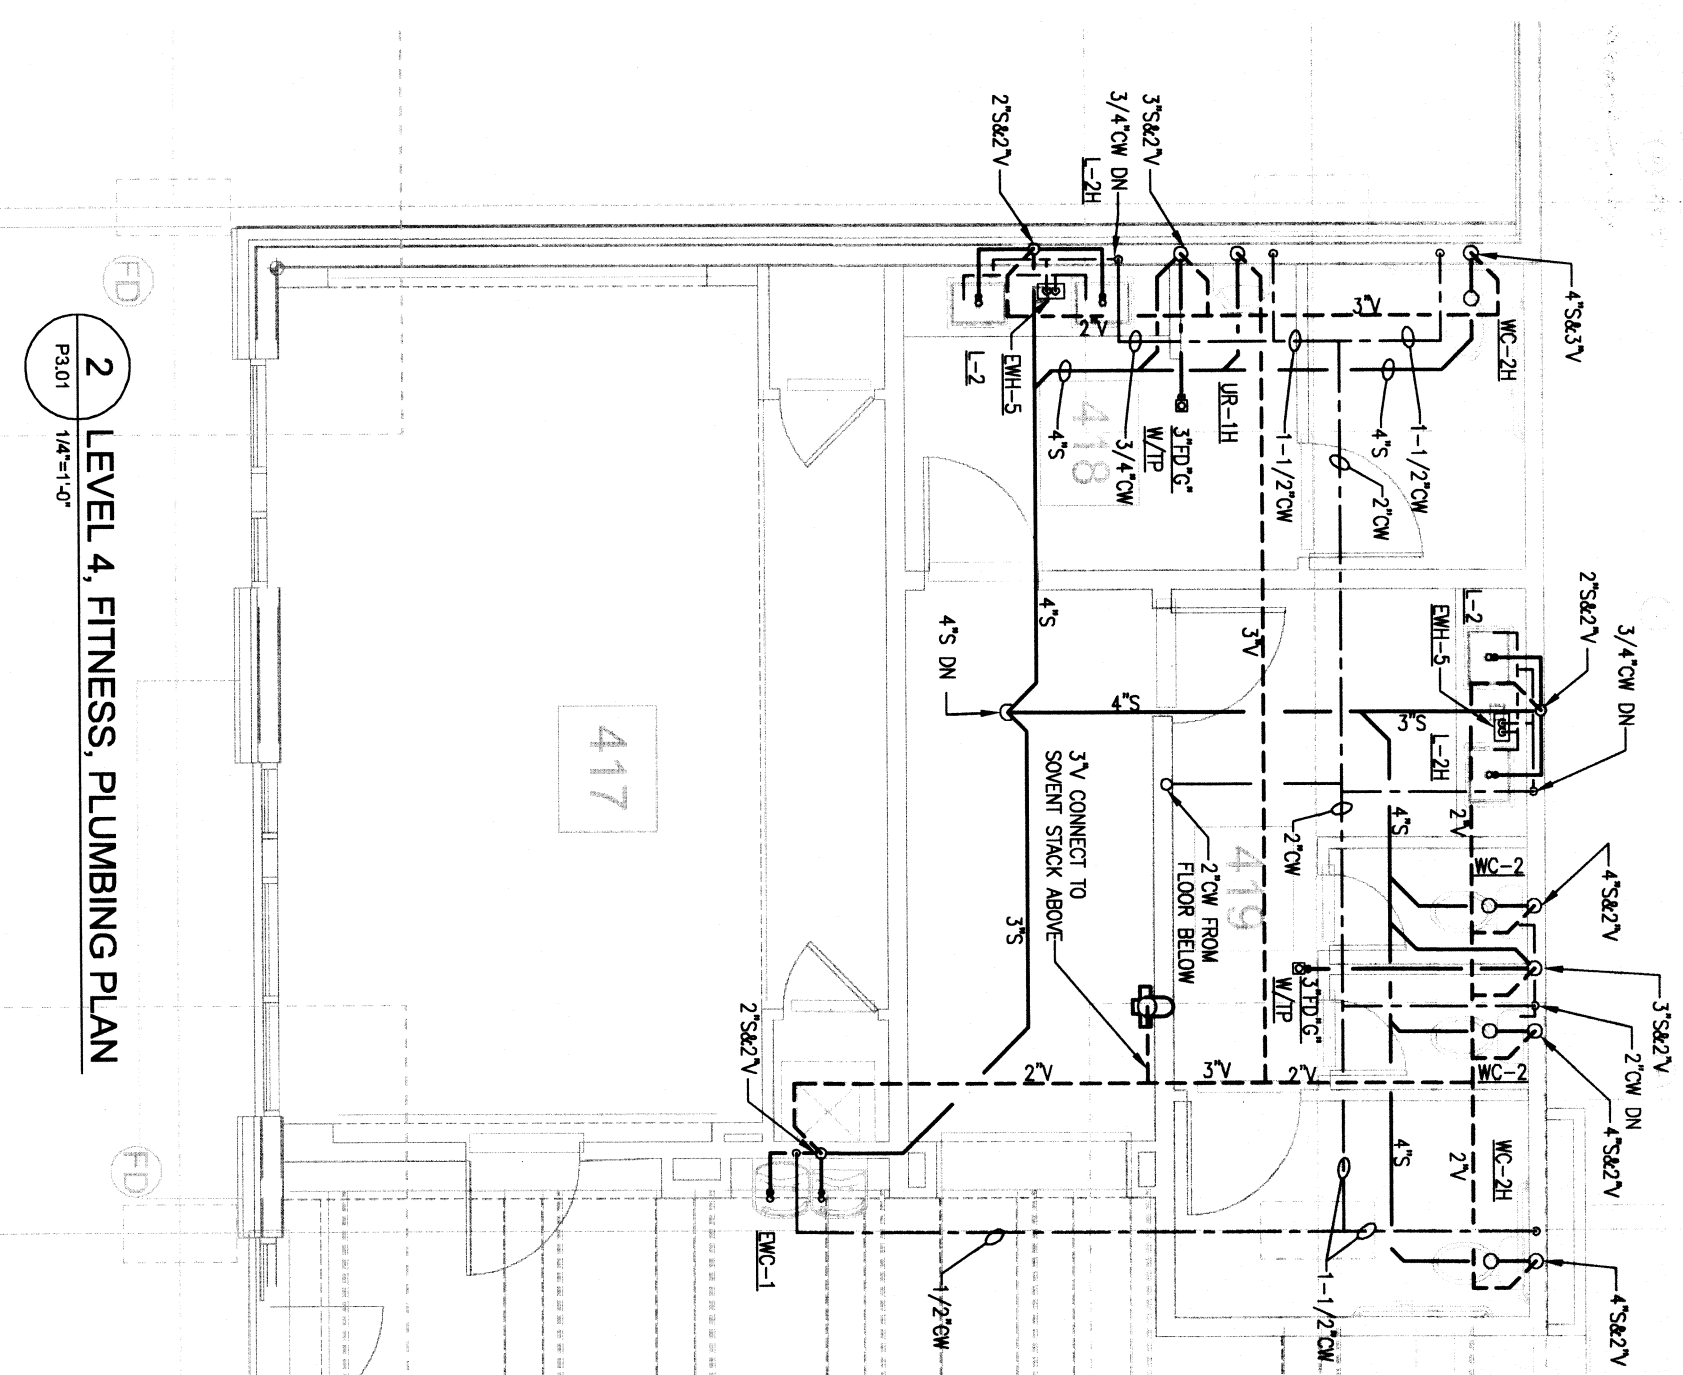

2 LEVEL 4, FITNESS, PLUMBING PLAN
P.L.O.T. 1/4\"/>

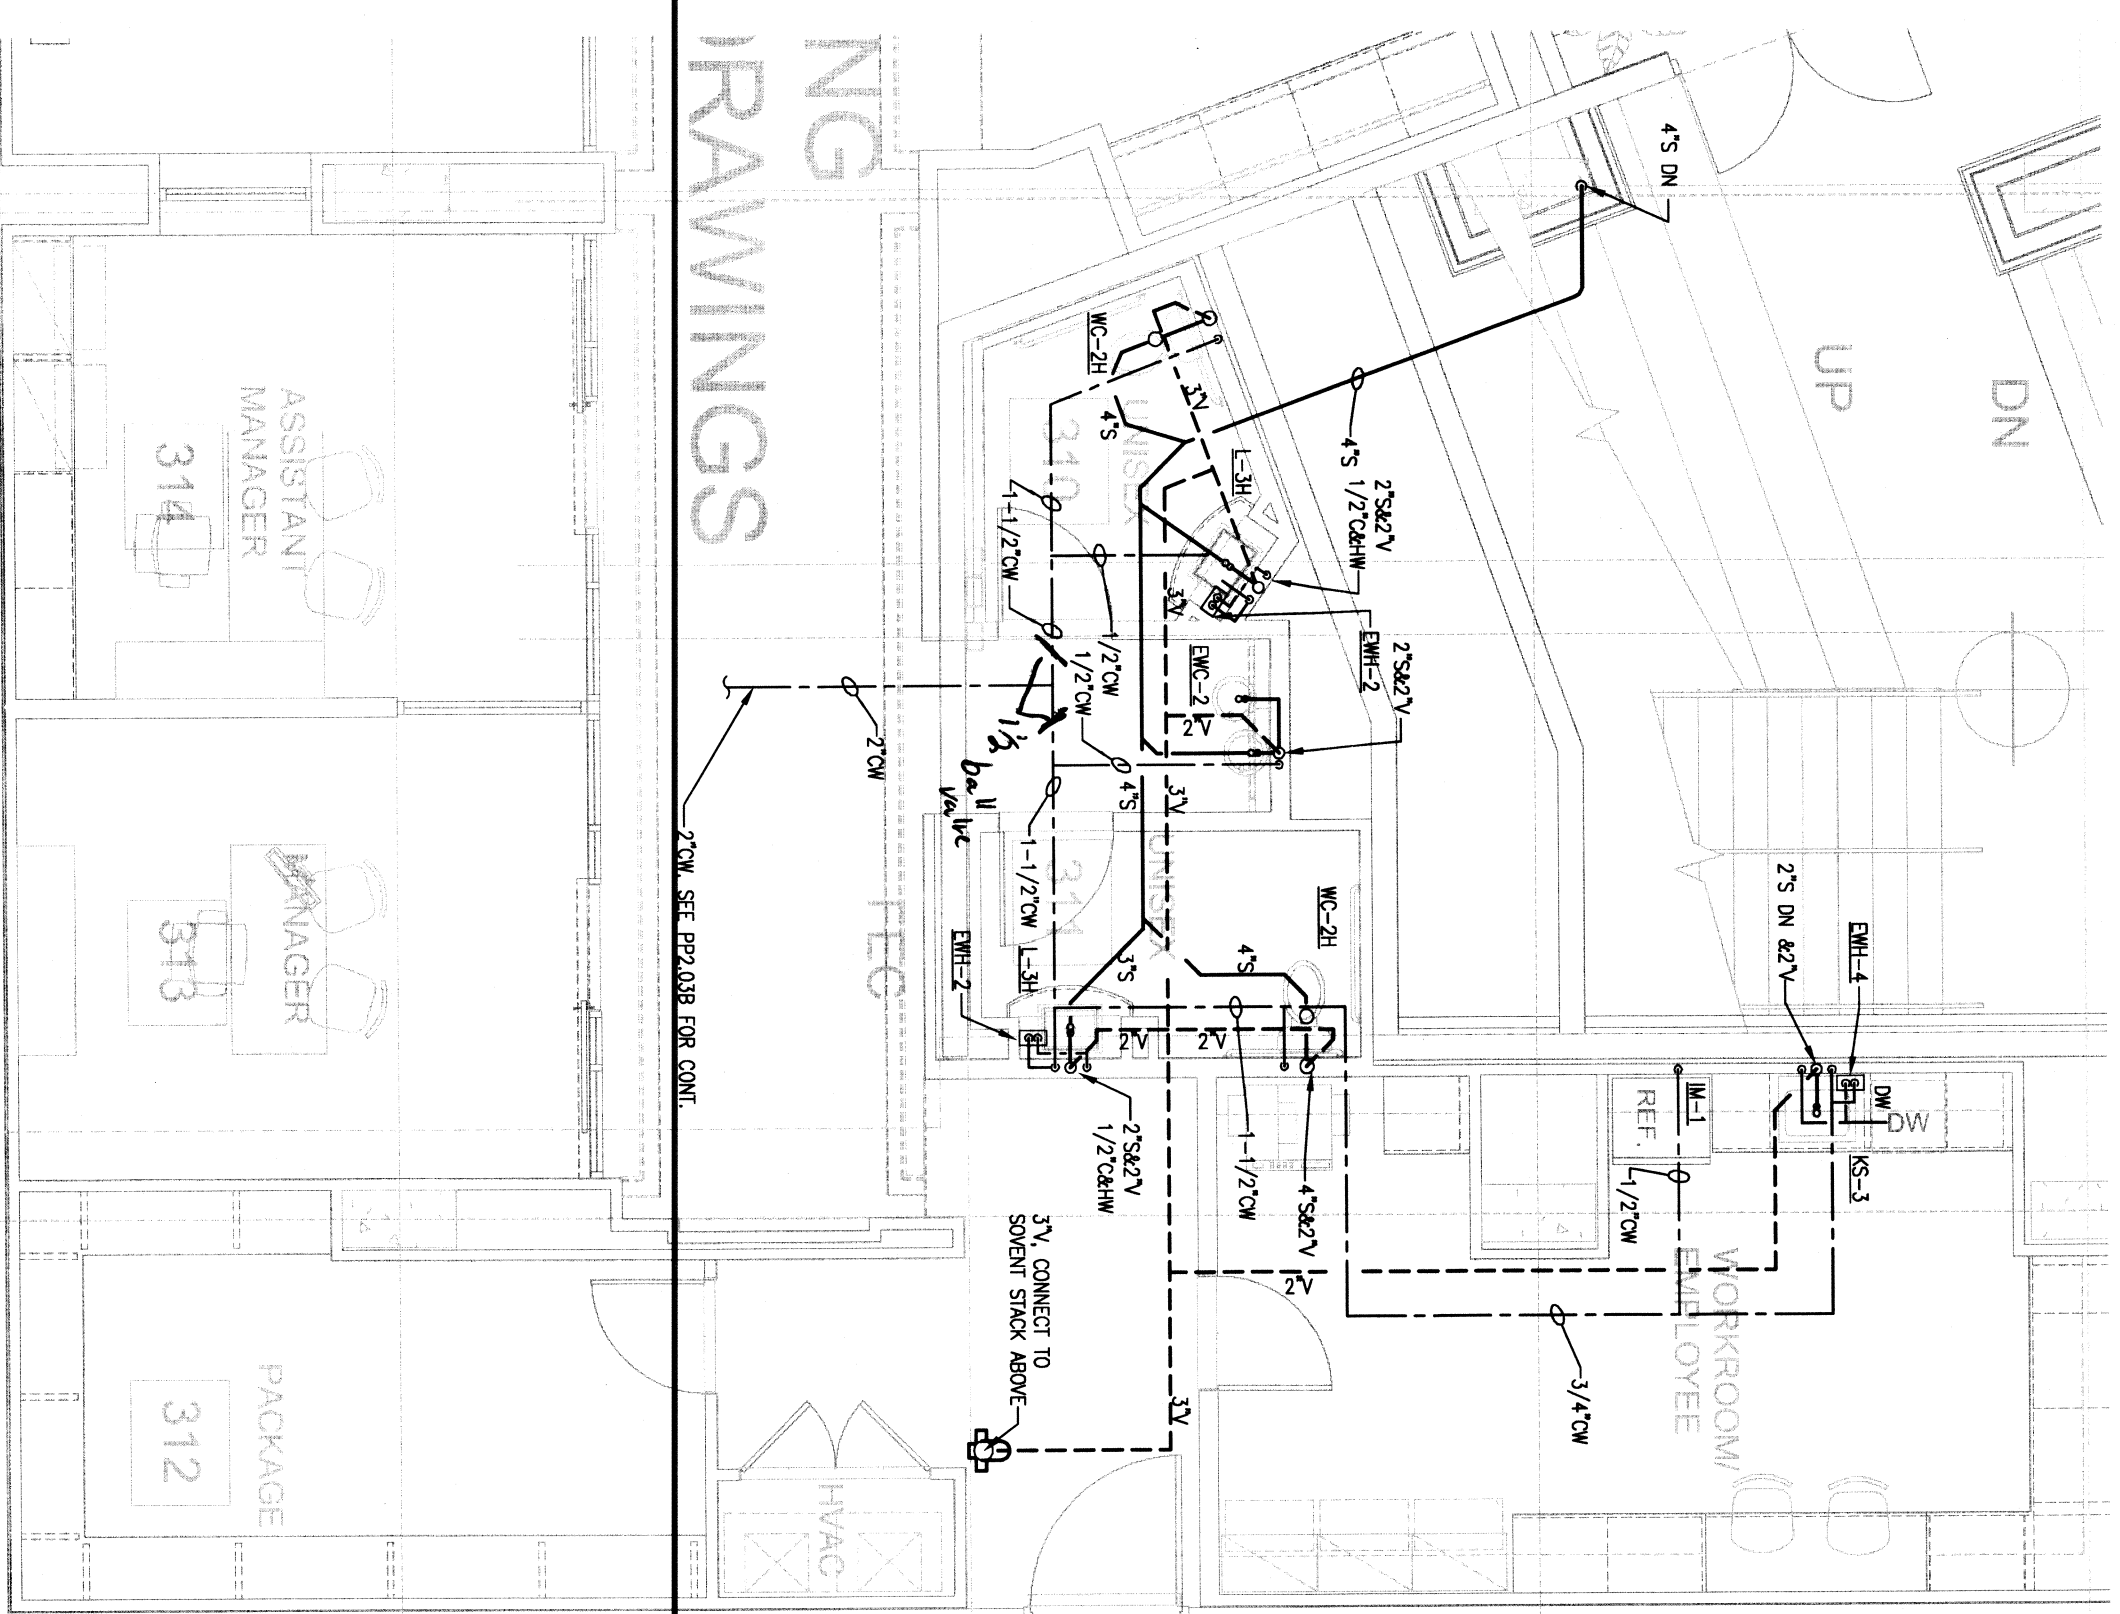

1 LEVEL 3, LEASING, PLUMBING PLAN
P.L.O.T. 1/4\"/>

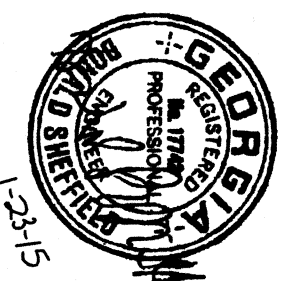

PROJECT #: 113044.00
DRAWN BY:
CHECKED BY:

NILES BOLTON
ASSOCIATES


3060 Peachtree Rd. N.W.
Suite 600
Atlanta, GA 30305
T 404 365 7600
F 404 365 7610
www.nilesbolton.com

No.	Description	Date
1	DESIGN DEVELOP 25%	06/01/14
2	DESIGN DEVELOP 50%	06/20/14
3	DESIGN DEVELOP 75%	06/20/14
4	DESIGN DEVELOP 100%	06/20/14
5	ISSUED FOR SET	06/20/14
6	REVISION 1	06/20/14
7	REVISION 2	06/20/14
8	REVISION 3	06/20/14
9	REVISION 4	06/20/14

BROOKWOOD SQUARE
RESIDENTIAL
ATLANTA, GEORGIA

ENLARGED FLOOR PLANS
- PLUMBING

P3.01

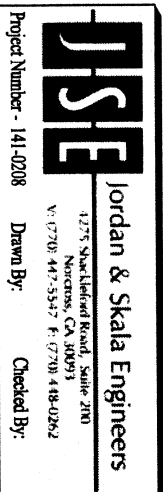

06/18/2014