

	1	2	3	4	5	6	7	
	PLUMBING SPECIALTY SCHEDULE							
K	SYMBOL	FIXTURE TYPE	MANUFACTURER MODEL NUMBER	PIPE SIZES		DESCRIPTION	NOTES:	
				SOIL OR WASTE	VENT			
	FD1	FLOOR DRAIN, GENERAL PURPOSE TYPE	MIFAB F1100-C-5-1-7	2",3",4"	2"	DUCO CAST IRON BODY AND FLASHING COLLAR, ADJUSTABLE NICKEL-BRONZE STRAINER HEAD, ROUND TOP, CAULK OUTLET. PROVIDE WITH 1/2" TRAP PRIMER CONNECTION.	1, 2	
	FD2	FLOOR DRAIN, HEAVY DUTY TYPE	MIFAB F1100-C-N7-1-5-7	2",3",4"	2"	DUCO CAST IRON BODY AND FLASHING COLLAR WITH BAR GRATE, ROUND TOP, CAULK OUTLET. PROVIDE WITH 1/2" TRAP PRIMER CONNECTION.	1	
	HD	HUB DRAIN	JAY R SMITH 3821	---	---	P-TRAP DRAIN WITH FUNNEL ATTACHMENT	1, 2	
	TD	TRENCH DRAIN	MIFAB T1330-FL-FAB-TH	4"	2"	PRE-SLOPED TRENCH DRAIN WITH 10 GAUGE STEEL BODY, DUCTILE IRON GRATES WITH A SAFE LIVE LOAD OF 10,000 LBS OR MORE. PROVIDE WITH ½" TRAP PRIMER CONNECTION WHERE REQUIRED BY CODE.	1	
	AD1	AREA DRAIN, PARKING DECK	MIFAB F1510	3",4",6"	---	EPOXY COATED CAST IRON PARKING STRUCTURE DRAIN WITH ANTI-PONDING TOP, MEMBRANE CLAMPING FLANGE, HEAVY DUTY SELF-CLOSING HINGED GRATE, SEDIMENT BUCKET AND NO HUB OUTLET.	1	
	AD2	AREA DRAIN, ELEVATED DECK	ZURN Z158-85-DT	3",4"	---	EPOXY COATED CAST IRON DRAIN WITH ANTI-PONDING TOP, BODY FLANGE, FLASHING COLLAR, NICKEL BRONZE TOP, AND NO HUB OUTLET.	1, 2	
	PD	PLANTER DRAIN	J.R. SMITH 1905 SERIES	3",4"	---	SECURED DOME WITH MESH SCREEN, PERFORATED STANDPIPE, LOWER BODY WITH CAST IRON DOME AND MESH SCREEN, FLASHING CLAMP AND GRAVEL STOP.	1, 2	
	RD	ROOF DRAIN	MIFAB R1100 SERIES	4"	---	DUCO CAST IRON BODY WITH COMBINED FLASHING CLAMP AND GRAVEL STOP WITH POLYETHYLENE DOME.	1	
	WHYD	NON-FREEZE WALL HYDRANT	MIFAB MHY-20 SERIES	---	---	NON-FREEZE WALL HYDRANT WITH INTEGRAL VACUUM BREAKER, ¼ TURN KEY ASSEMBLY, AND STAINLESS STEEL LOCKING BOX.	1	
	HB	HOSE BIBB	MIFAB MHY-10 SERIES	---	---	HOSE BIBB WITH INTEGRAL VACUUM BREAKER, ¼ TURN KEY ASSEMBLY, AND EXPOSED HOSE CONNECTION.	1	
	RHYD	NON-FREEZE ROOF HYDRANT	WOODFOOD SRH-MS	---	---	NON-FREEZE DRAINLESS ROOF HYDRANT WITH BACKFLOW PREVENTER AND CAST IRON MOUNT.	1	
	FS	INDIRECT WASTE DRAIN	MIFAB FS1730-FL-1-6-7	2",3",4"	2"	DUCO CAST IRON BODY AND FLASHING COLLAR WITH NICKEL BRONZE ADJUSTABLE STRAINER HEAD W/ SECURED SQUARE HOLE 12" X 12" GRATE. PROVIDE VANDAL PROOF SCREWS. PROVIDE WITH ½" TRAP PRIMER CONNECTION WHERE REQUIRED BY CODE.	1	
	FCO	FLOOR CLEAN OUT	MIFAB C1100-XR-1	2",4"	---	TWIST TO FLOOR ADJUSTMENT ROUND TOP.	1, 2	
	WCO	WALL PLATE CLEAN OUT	MIFAB C1430-RD	2",4"	---	CAST BRONZE TAPER THREAD PLUG WITH STAINLESS STEEL ROUND COVER AND SCREW.	1, 2	
	TP	TRAP PRIMER VALVE	PRECISION PLUMBING PR-500	---	---	TRAP PRIMER WITH INTERNAL VACUUM BREAKER AND INTEGRAL BACKFLOW PREVENTOR. SUPPLY WITH DISTRIBUTION UNIT. MAX 4 FLOOR DRAINS/FLOOR SINKS PER TRAP PRIMER. COORDINATE WITH MECHANICAL PLUMBING DRAWINGS FOR QUANTITY OF FLOOR DRAINS/FLOOR SINKS TO ENSURE ALL FLOOR DRAINS AND FLOOR SINKS ARE EQUIPPED WITH TRAP PRIMER.	1	
	NOTES:							
	1. APPROVED ALTERNATE MANUFACTURERS FOR PLUMBING FIXTURES AND EQUIPMENT ARE MIFAB, J.R. SMITH, JOSAM, WADE, WATTS, ZURN OR APPROVED OTHER.							
	2. PVC BODIED PRODUCTS BY OATEY OR SIOUX CHIEF MAY BE SUBSTITUTED WHEN DRAIN IS CONNECTED TO A PVC PIPING SYSTEM.							
J	ELECTRIC WATER HEATER SCHEDULE							
	MARK	LOCATION	TYPE	KW	RECOVERY (90°F TEMP. RISE)	NOMINAL STORAGE GALLONS	ENERGY FACTOR	
	WH1	CONDO UNITS	TANK TYPE	6.0	28	47	0.95	
	WH2	AMENITIES	TANK TYPE	4.5	21	38	0.95	
	WH3	FIRST FLOOR JANITORS CLOSET	TANK TYPE	4.5	21	19.5	—	
	WH4	EXERCISE	TANK TYPE	4.5	21	38	0.95	
	WH5	DOG WASH	TANK TYPE	4.5	21	38	0.95	
	(1) SEE ELECTRICAL DRAWINGS FOR VOLTAGE AND PHASE REQUIREMENTS. COORDINATE ELECTRICAL REQUIREMENTS WITH ELECTRICAL CONTRACTOR PRIOR TO ORDERING EQUIPMENT.							
	(2) PROVIDE MULTIPLE WATER HEATERS PER APARTMENT UNIT PER PLANS.							
	(3) ACCEPTABLE EQUAL MANUFACTURERS ARE A.O.SMITH, BRADFORD WHITE, LOCKINVAR, PVI, RHEEM OR STATE.							
	H	ELECTRIC WATER HEATER SCHEDULE						
		MARK	LOCATION	TYPE	KW	RECOVERY (90°F TEMP. RISE)	NOMINAL STORAGE GALLONS	ENERGY FACTOR
		WH1	CONDO UNITS	TANK TYPE	6.0	28	47	0.95
		WH2	AMENITIES	TANK TYPE	4.5	21	38	0.95
		WH3	FIRST FLOOR JANITORS CLOSET	TANK TYPE	4.5	21	19.5	—
		WH4	EXERCISE	TANK TYPE	4.5	21	38	0.95
		WH5	DOG WASH	TANK TYPE	4.5	21	38	0.95
(1) SEE ELECTRICAL DRAWINGS FOR VOLTAGE AND PHASE REQUIREMENTS. COORDINATE ELECTRICAL REQUIREMENTS WITH ELECTRICAL CONTRACTOR PRIOR TO ORDERING EQUIPMENT.								
(2) PROVIDE MULTIPLE WATER HEATERS PER APARTMENT UNIT PER PLANS.								
(3) ACCEPTABLE EQUAL MANUFACTURERS ARE A.O.SMITH, BRADFORD WHITE, LOCKINVAR, PVI, RHEEM OR STATE.								
G		ELECTRIC WATER HEATER SCHEDULE						
		MARK	LOCATION	TYPE	KW	RECOVERY (90°F TEMP. RISE)	NOMINAL STORAGE GALLONS	ENERGY FACTOR
		WH1	CONDO UNITS	TANK TYPE	6.0	28	47	0.95
		WH2	AMENITIES	TANK TYPE	4.5	21	38	0.95
		WH3	FIRST FLOOR JANITORS CLOSET	TANK TYPE	4.5	21	19.5	—
		WH4	EXERCISE	TANK TYPE	4.5	21	38	0.95
		WH5	DOG WASH	TANK TYPE	4.5	21	38	0.95
	(1) SEE ELECTRICAL DRAWINGS FOR VOLTAGE AND PHASE REQUIREMENTS. COORDINATE ELECTRICAL REQUIREMENTS WITH ELECTRICAL CONTRACTOR PRIOR TO ORDERING EQUIPMENT.							
	(2) PROVIDE MULTIPLE WATER HEATERS PER APARTMENT UNIT PER PLANS.							
	(3) ACCEPTABLE EQUAL MANUFACTURERS ARE A.O.SMITH, BRADFORD WHITE, LOCKINVAR, PVI, RHEEM OR STATE.							
	F	ELECTRIC WATER HEATER SCHEDULE						
		MARK	LOCATION	TYPE	KW	RECOVERY (90°F TEMP. RISE)	NOMINAL STORAGE GALLONS	ENERGY FACTOR
		WH1	CONDO UNITS	TANK TYPE	6.0	28	47	0.95
		WH2	AMENITIES	TANK TYPE	4.5	21	38	0.95
		WH3	FIRST FLOOR JANITORS CLOSET	TANK TYPE	4.5	21	19.5	—
		WH4	EXERCISE	TANK TYPE	4.5	21	38	0.95
		WH5	DOG WASH	TANK TYPE	4.5	21	38	0.95
(1) SEE ELECTRICAL DRAWINGS FOR VOLTAGE AND PHASE REQUIREMENTS. COORDINATE ELECTRICAL REQUIREMENTS WITH ELECTRICAL CONTRACTOR PRIOR TO ORDERING EQUIPMENT.								
(2) PROVIDE MULTIPLE WATER HEATERS PER APARTMENT UNIT PER PLANS.								
(3) ACCEPTABLE EQUAL MANUFACTURERS ARE A.O.SMITH, BRADFORD WHITE, LOCKINVAR, PVI, RHEEM OR STATE.								

PLUMBING LEGEND		
SYMBOL	MARK	DESCRIPTION
=====	S OR W	SOIL OR WASTE PIPE BELOW SLAB
=====	RW	RAINWATER
-----	V	VENT PIPE
-----	CW	COLD WATER PIPE
-----	HW	HOT WATER PIPE
-----	HWR	HOT WATER RECIRCULATING PIPE
-----	G	GAS PIPE
+++++		PIPING TO BE HEAT TRACED
⊖	FD	FLOOR DRAIN
⊖	FS	FLOOR SINK
⊖	CO	CLEANOUT
	WCO	WALL CLEANOUT
●	BV	BALL VALVE
⚙	BV	BALANCING VALVE
⚡	WHA	WATER HAMMER ARRESTOR
⚡	CKV	CHECK VALVE
⚡	STR	STRAINER
⚡	WHYD OR HB	WALL HYDRANT OR HOSE BIBB
⊙	AAV	AIR ADMITTANCE VALVE
	AFF	ABOVE FINISH FLOOR
	A/C	ABOVE CEILING
	B/F	BELOW FLOOR
	B/G	BELOW GROUND
	CONT.	CONTINUED
	N.C.	NORMALLY CLOSED
	SQ.	SQUARE
	FT.	FEET
	VTR	VENT THRU ROOF


PIPING TYPES & REQUIREMENTS			
SERVICE	LOCATION	MATERIAL	NOTES
SANITARY, WASTE & VENT	ALL	CAST IRON	(1)(2)
RAINWATER	ALL	CAST IRON	(1)(2)(3)
DOMESTIC WATER	ALL	CPVC	(4)
GAS	ALL	SCH. 40 BLACK STEEL	(3)
(1) AT TIME OF DESIGN APARTMENT MECHANICAL CLOSETS ARE AIR PLENUMS. PIPING WITHIN AIR PLENUMS SHALL BE CPVC OR CAST IRON.			
(2) VERTICAL PIPING EXPOSED IN PARKING GARAGE SHALL BE PROTECTED FROM DAMAGE BY VEHICLES.			
(3) CAST IRON RAINWATER PIPE SHALL BE INSULATED.			
(4) ALL RECIRCULATED HOT WATER SYSTEMS SHALL HAVE THE PUMPED LOOP INSULATED.			

	1	2	3	4	5	6	7	8	9	10	11	12	13	14	15
K															
	PLUMBING FIXTURE SCHEDULE														
J															
H															
G															
F															
E															
D															
C															
B															
A															

LORD
AECK
SARGENT

© 2015 Lord Aeck Sargent
LordAeckSargent.com
Unless otherwise agreed to in writing, this document is the sole property of Lord Aeck Sargent and is to be returned upon demand. The information herein is confidential and may not be used nor divulged without the written permission of Lord Aeck Sargent

REVISION:
#1 PERMIT REVISIONS 4/11/2017

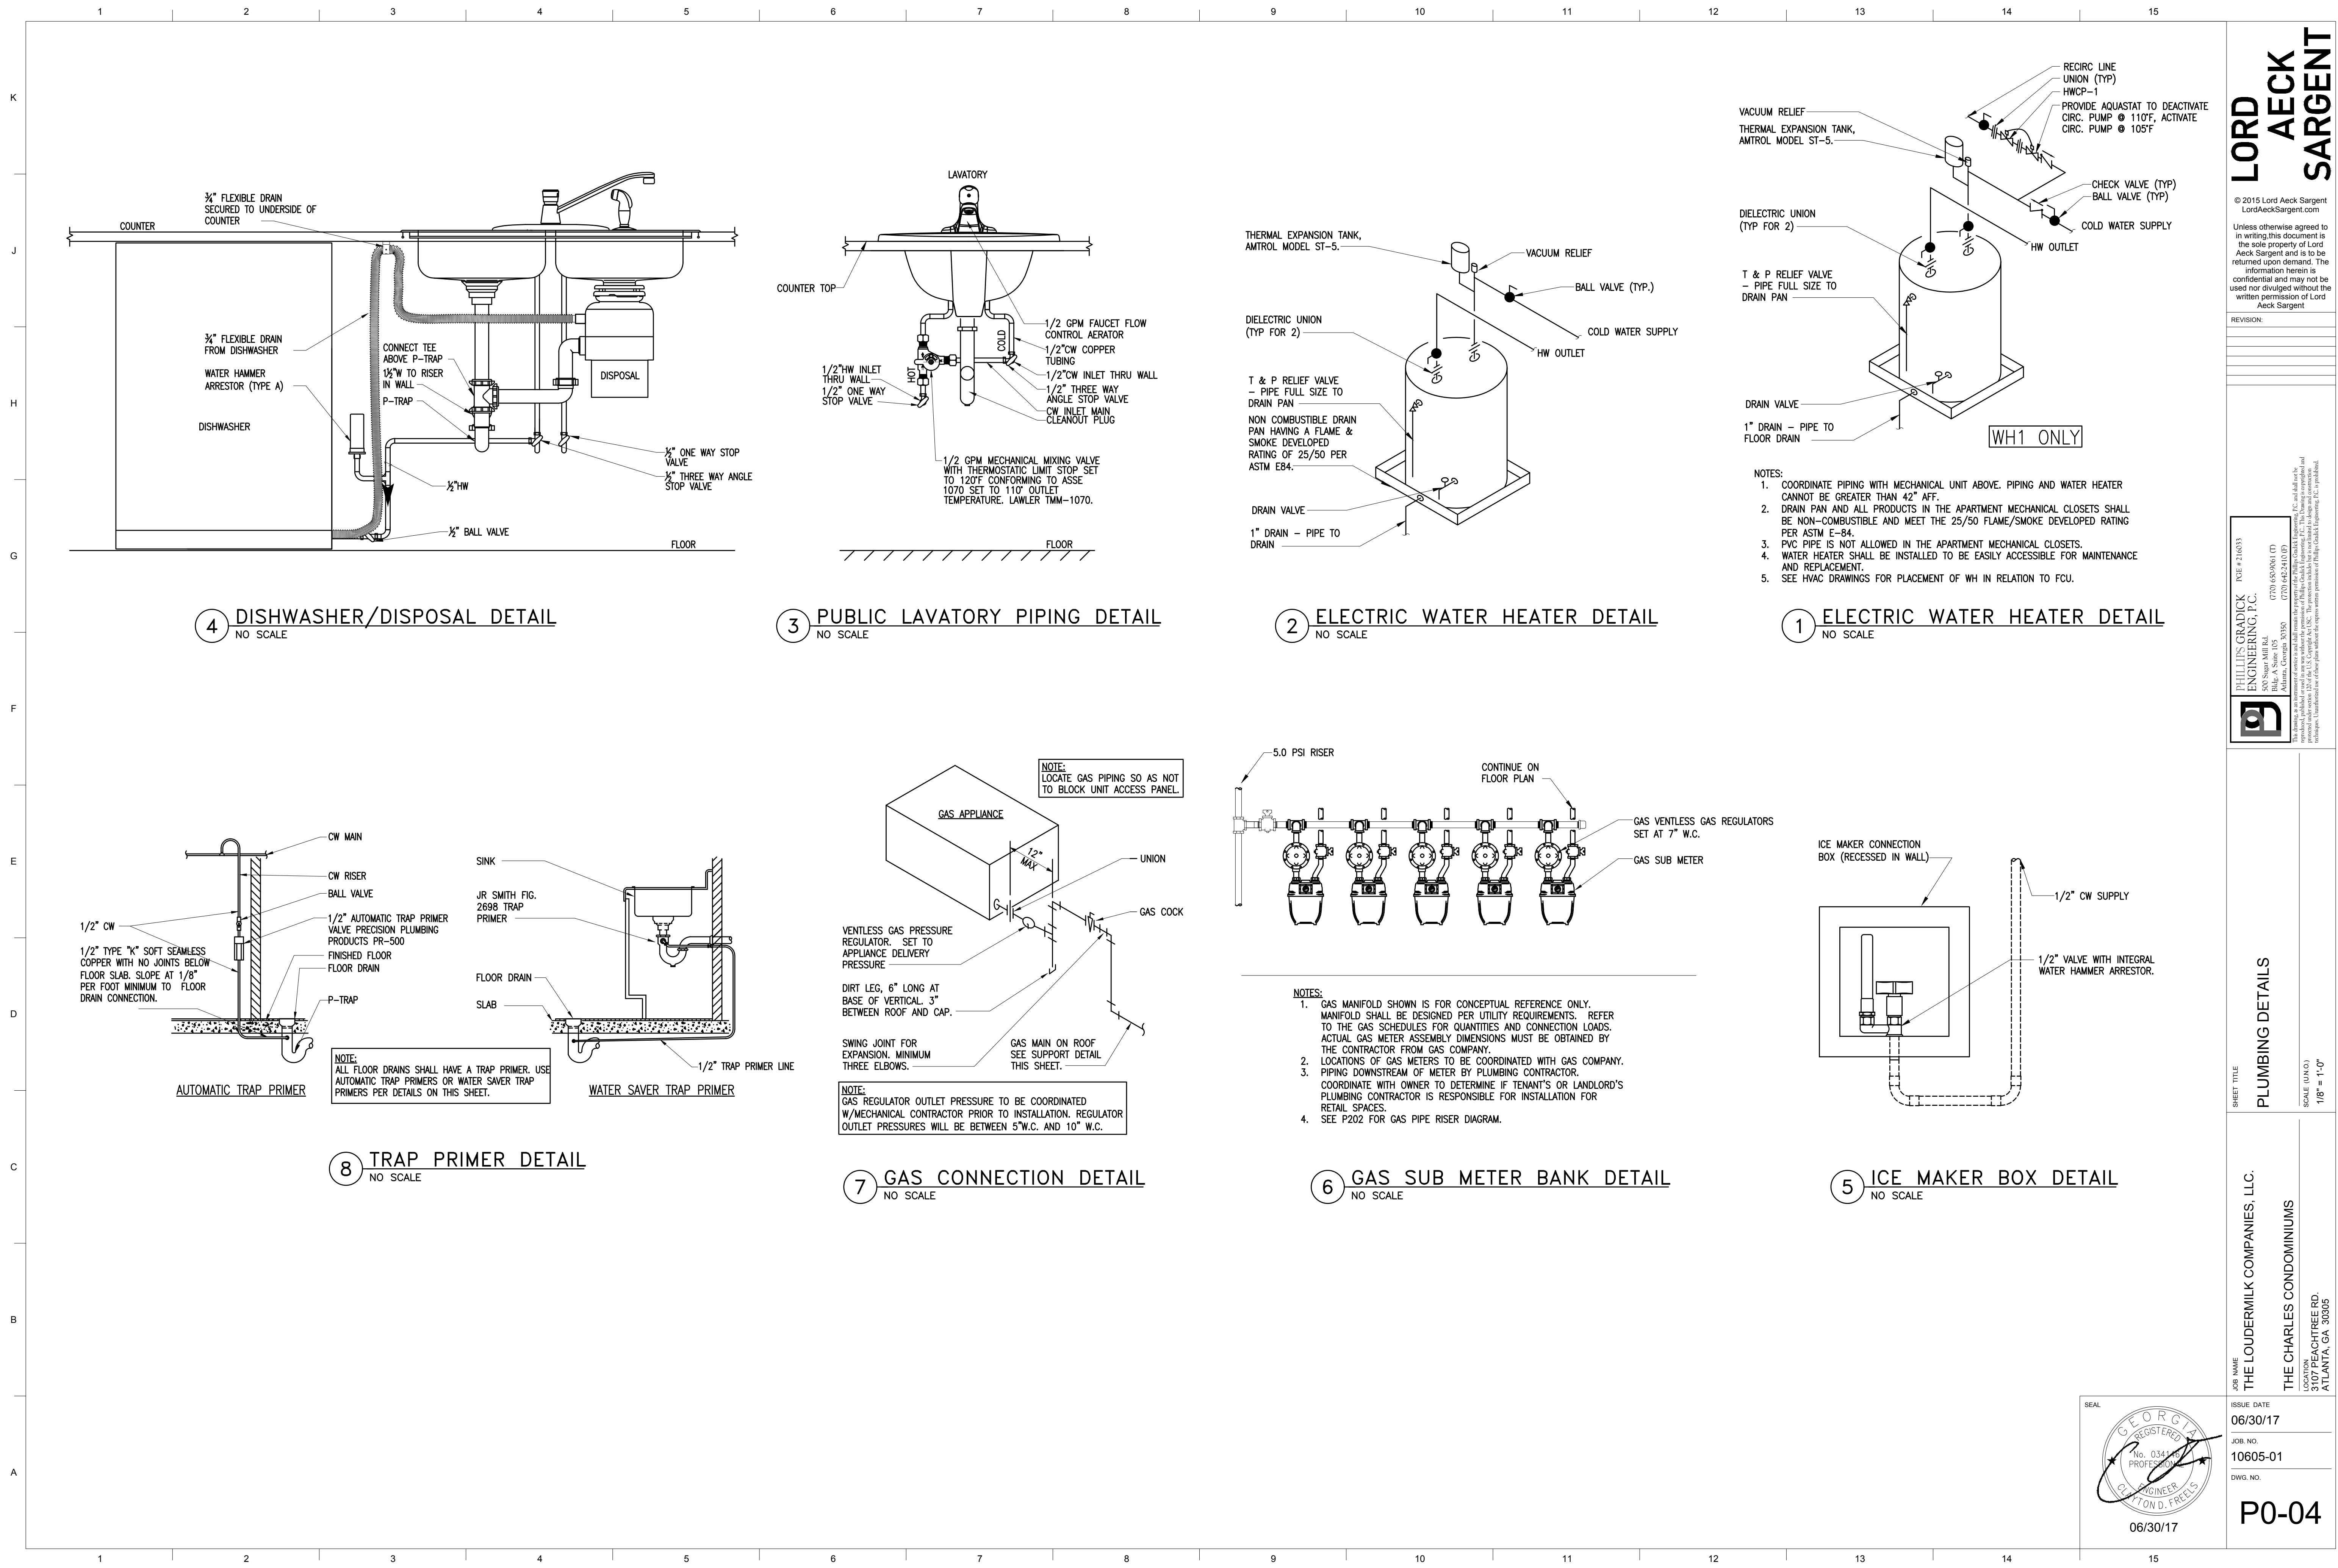

LORD AECK SARGENT

© 2015 Lord Aeck Sargent
LordAeckSargent.com

Unless otherwise agreed to in writing, this document is the sole property of Lord Aeck Sargent and is to be returned upon demand. The information herein is confidential and may not be used nor divulged without the written permission of Lord Aeck Sargent

REVISION:

PHILLIPS GRADICK ENGINEERING, P.C.
500 Super Hill Rd.
Bldg. A Suite 105
Atlanta, GA 30305
(770) 455-9816 (F)
(770) 455-9816 (H)
www.phillipsgradick.com

This drawing is an addendum to the original drawing and shall remain the property of Phillips Gradiack Engineering, P.C. and shall not be reproduced, copied, or used in any way without the written permission of Phillips Gradiack Engineering, P.C. This drawing is copyrighted and shall remain the property of Phillips Gradiack Engineering, P.C. and shall not be reproduced, copied, or used in any way without the written permission of Phillips Gradiack Engineering, P.C. is prohibited.

SHEET TITLE
PLUMBING DETAILS

SCALE (IN/FT)
1/8" = 1'-0"

JOB NAME
THE LOUDERMILK COMPANIES, LLC.

LOCATION
THE CHARLES CONDOMINIUMS
3107 PEACHTREE RD.
ATLANTA, GA 30305


ISSUE DATE
06/30/17

JOB NO.
10605-01

DWG. NO.
P0-04



ISSUED FOR CONSTRUCTION

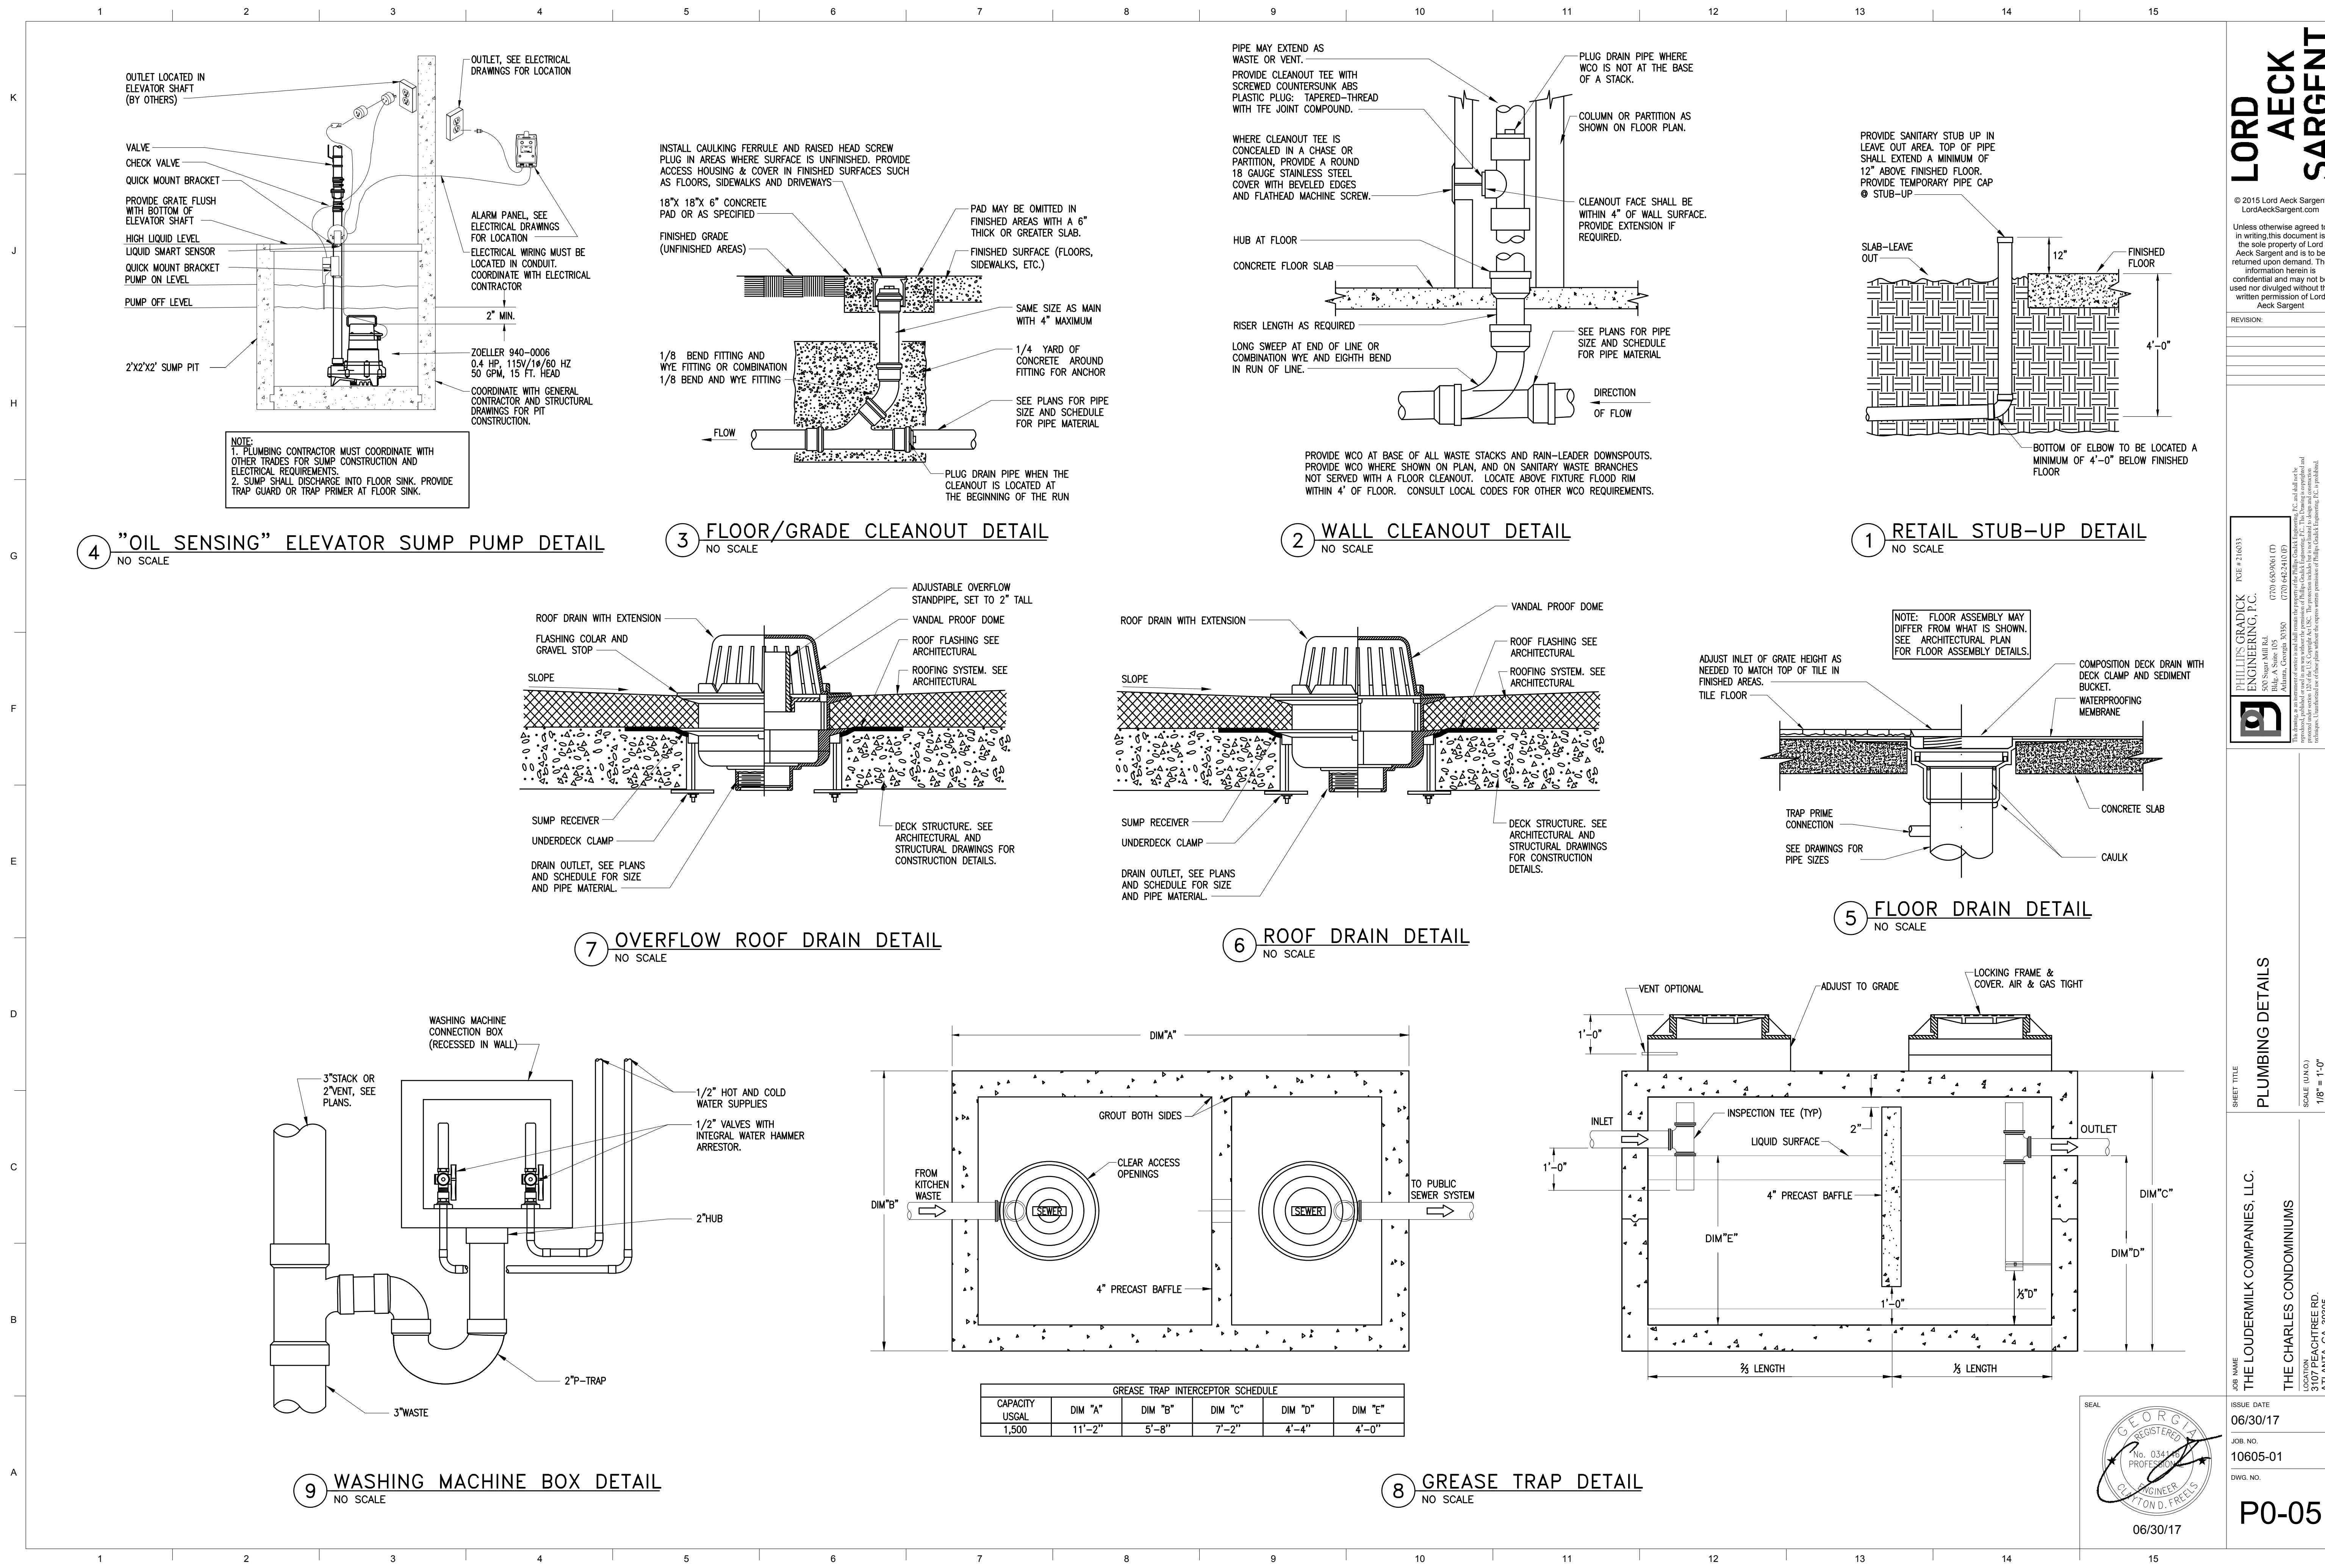

LORD AECK SARGENT

© 2015 Lord Aeck Sargent
LordAeckSargent.com
Unless otherwise agreed to in writing, this document is the sole property of Lord Aeck Sargent and is to be returned upon demand. The information herein is confidential and may not be used nor divulged without the written permission of Lord Aeck Sargent


REVISION:

PHILLIPS GRADICK ENGINEERING, P.C.
PCE # 2106133
7700 655 081, 07
500 Super Hill Rd.
Billerica, MA 01821
PHILLIPS GRADICK ENGINEERING, P.C. and shall not be responsible for any errors or omissions in this document. The information herein is confidential and may not be used nor divulged without the written permission of Phillips Grackick Engineering, P.C. is published.

PLUMBING DETAILS
SHEET TITLE
THE LOUDERMILK COMPANIES, LLC.
THE CHARLES CONDOMINIUMS
3107 PEACHTREE RD.
ATLANTA, GA 30305
SCALE (UNITS)
1/8" = 1'-0"

ISSUE DATE
06/30/17
JOB NO.
10605-01
DWG. NO.
P0-05

ISSUED FOR CONSTRUCTION

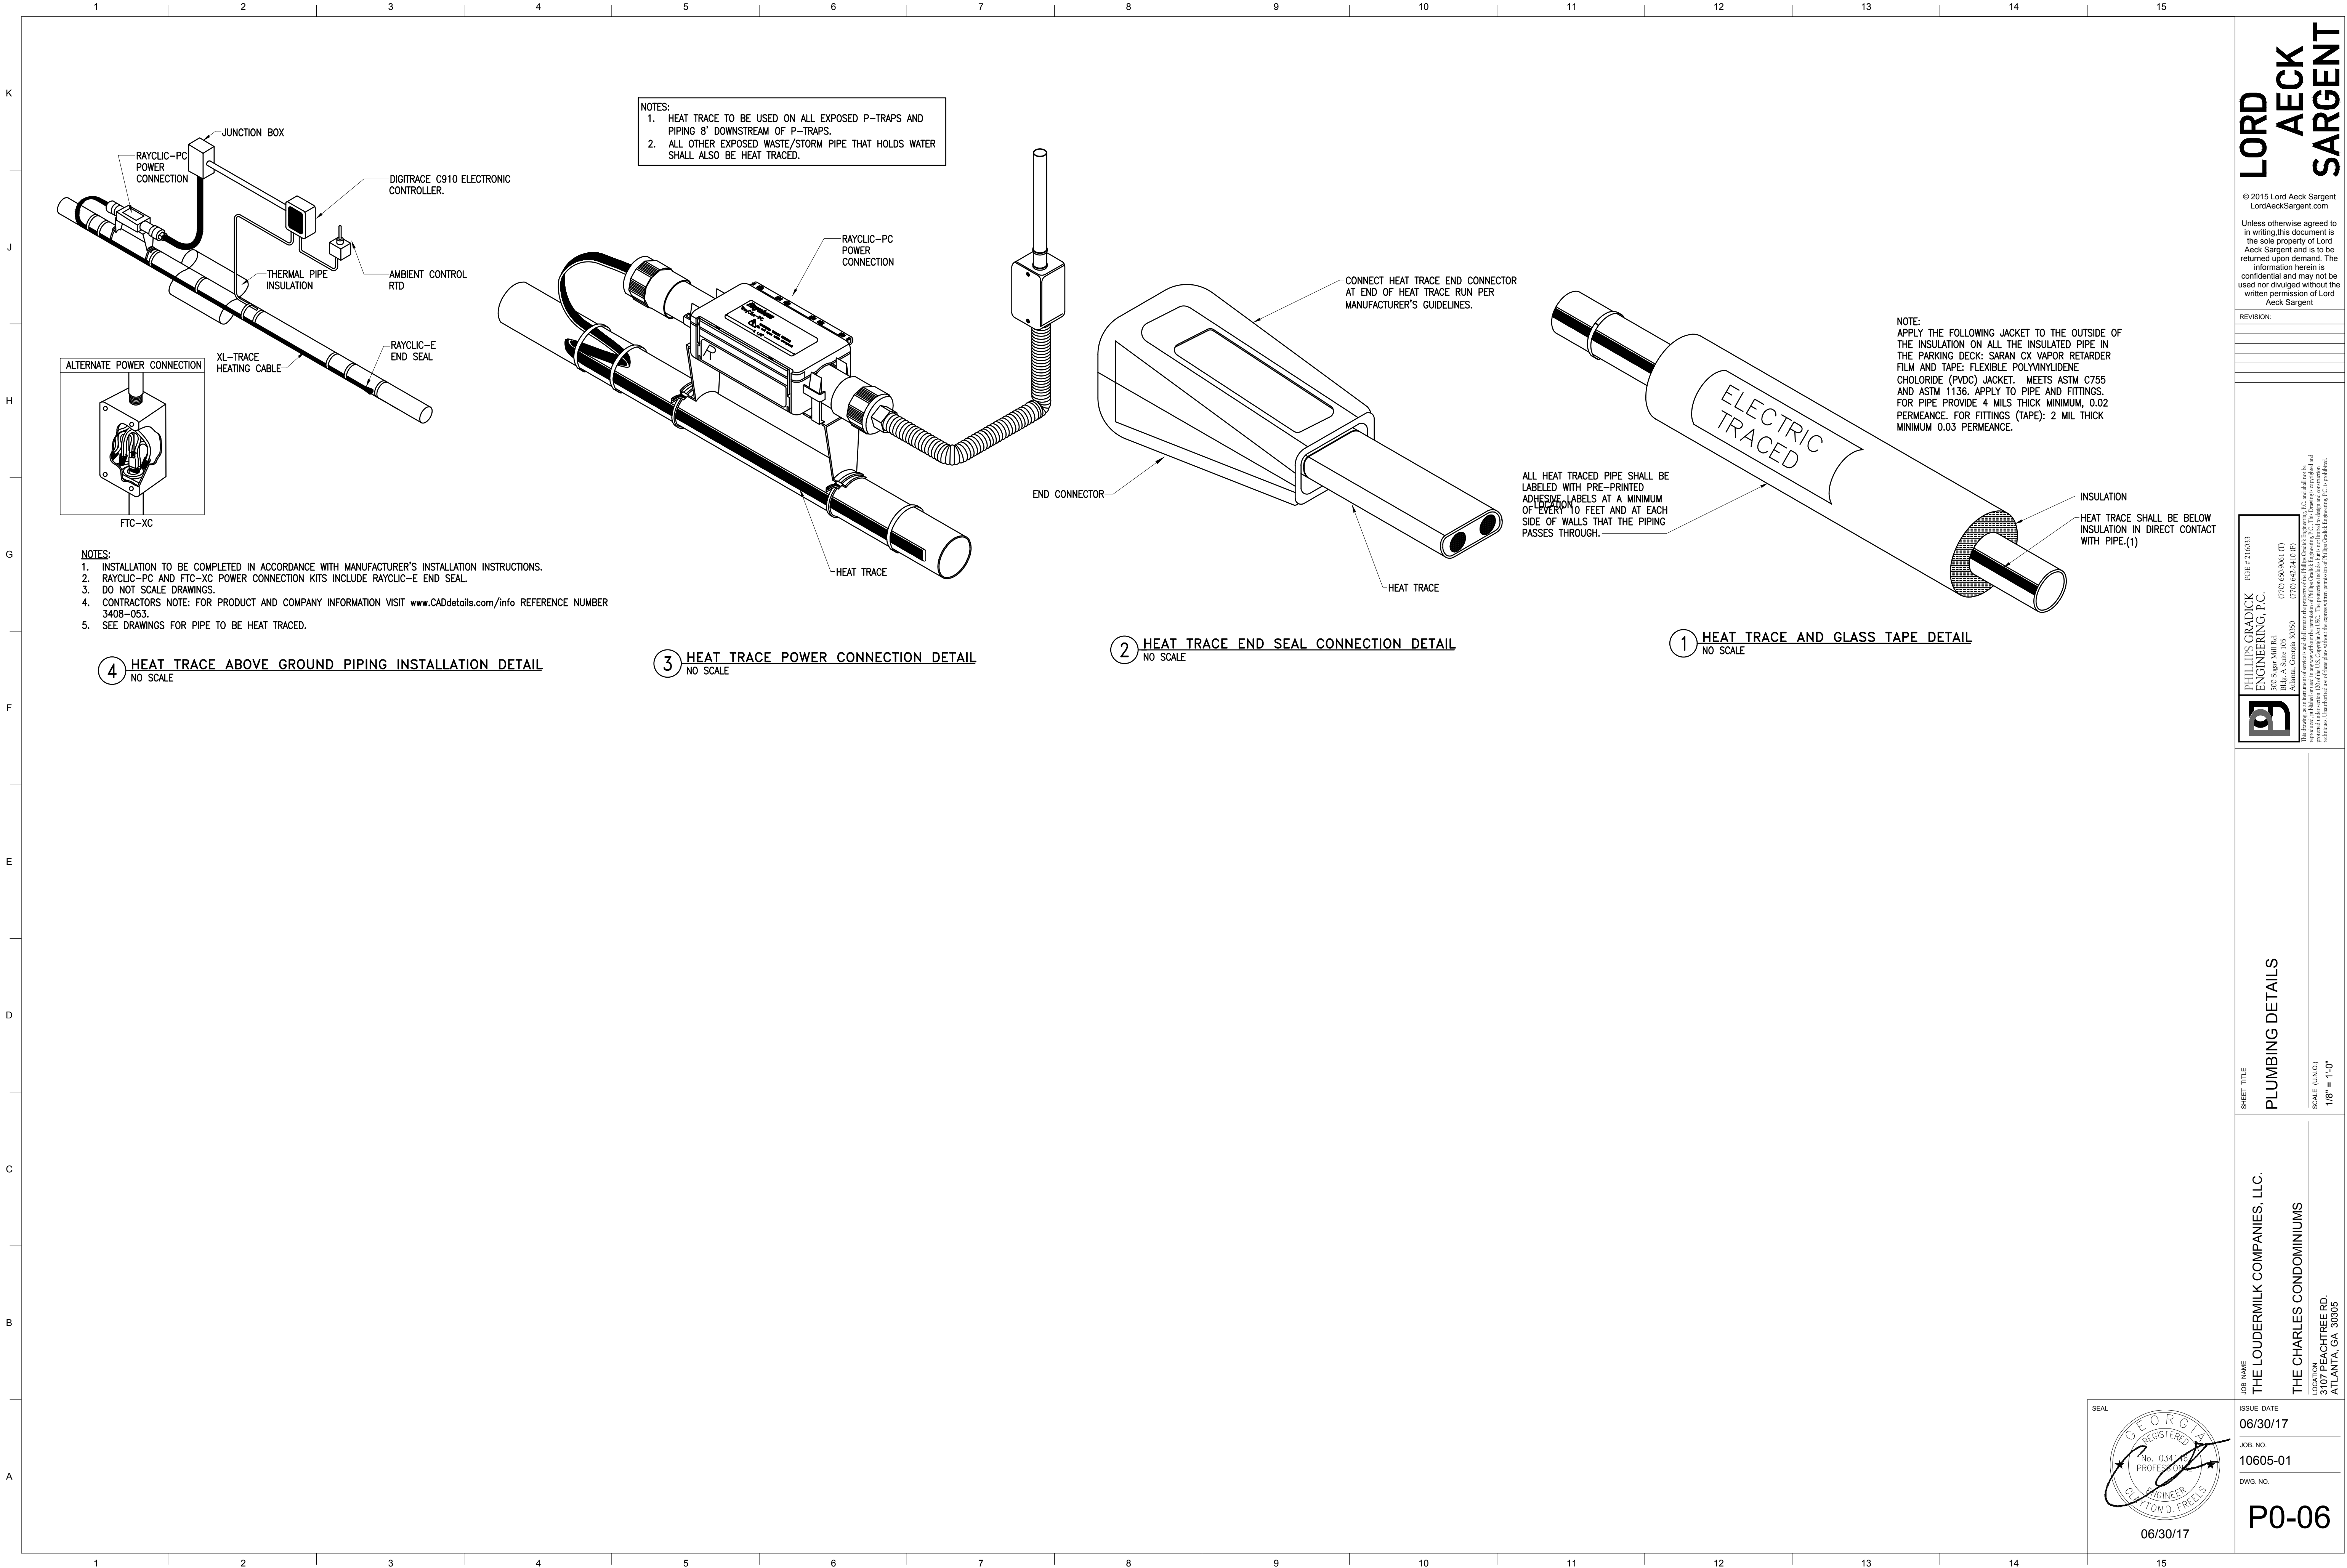

**LORD
AECK
SARGENT**

© 2015 Lord Aeck Sargent
LordAeckSargent.com

Unless otherwise agreed to in writing, this document is the sole property of Lord Aeck Sargent and is to be returned upon demand. The information herein is confidential and may not be used nor divulged without the written permission of Lord Aeck Sargent.

REVISION:



**PHILLIPS GRADICK
ENGINEERING, P.C.**
500 Super Hill Rd.
Bldg. A Suite 105
Atlanta, Georgia 30328
(770) 435-9816 (F)
(770) 435-9817 (O)
www.phillipsgradick.com

PHILLIPS GRADICK ENGINEERING, P.C. and its affiliates are not responsible for the accuracy or completeness of the information contained herein. The information is provided for informational purposes only and should not be used for any other purpose. The information is provided as a service to our clients and is not intended to constitute an offer of any financial product or service. The information is provided as a service to our clients and is not intended to constitute an offer of any financial product or service. The information is provided as a service to our clients and is not intended to constitute an offer of any financial product or service.

SHEET TITLE

PLUMBING DETAILS

SCALE (UNITS)

1/8" = 1'-0"

JOB NAME

THE LOUDERMILK COMPANIES, LLC.

ISSUE DATE

06/30/17

JOB NO.

10605-01

DWG. NO.


P0-06

THE CHARLES CONDOMINIUMS

LOCATION


3107 PEACHTREE RD.
ATLANTA, GA 30305

SEAL

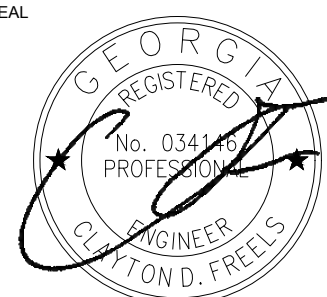

06/30/17

ISSUED FOR CONSTRUCTION

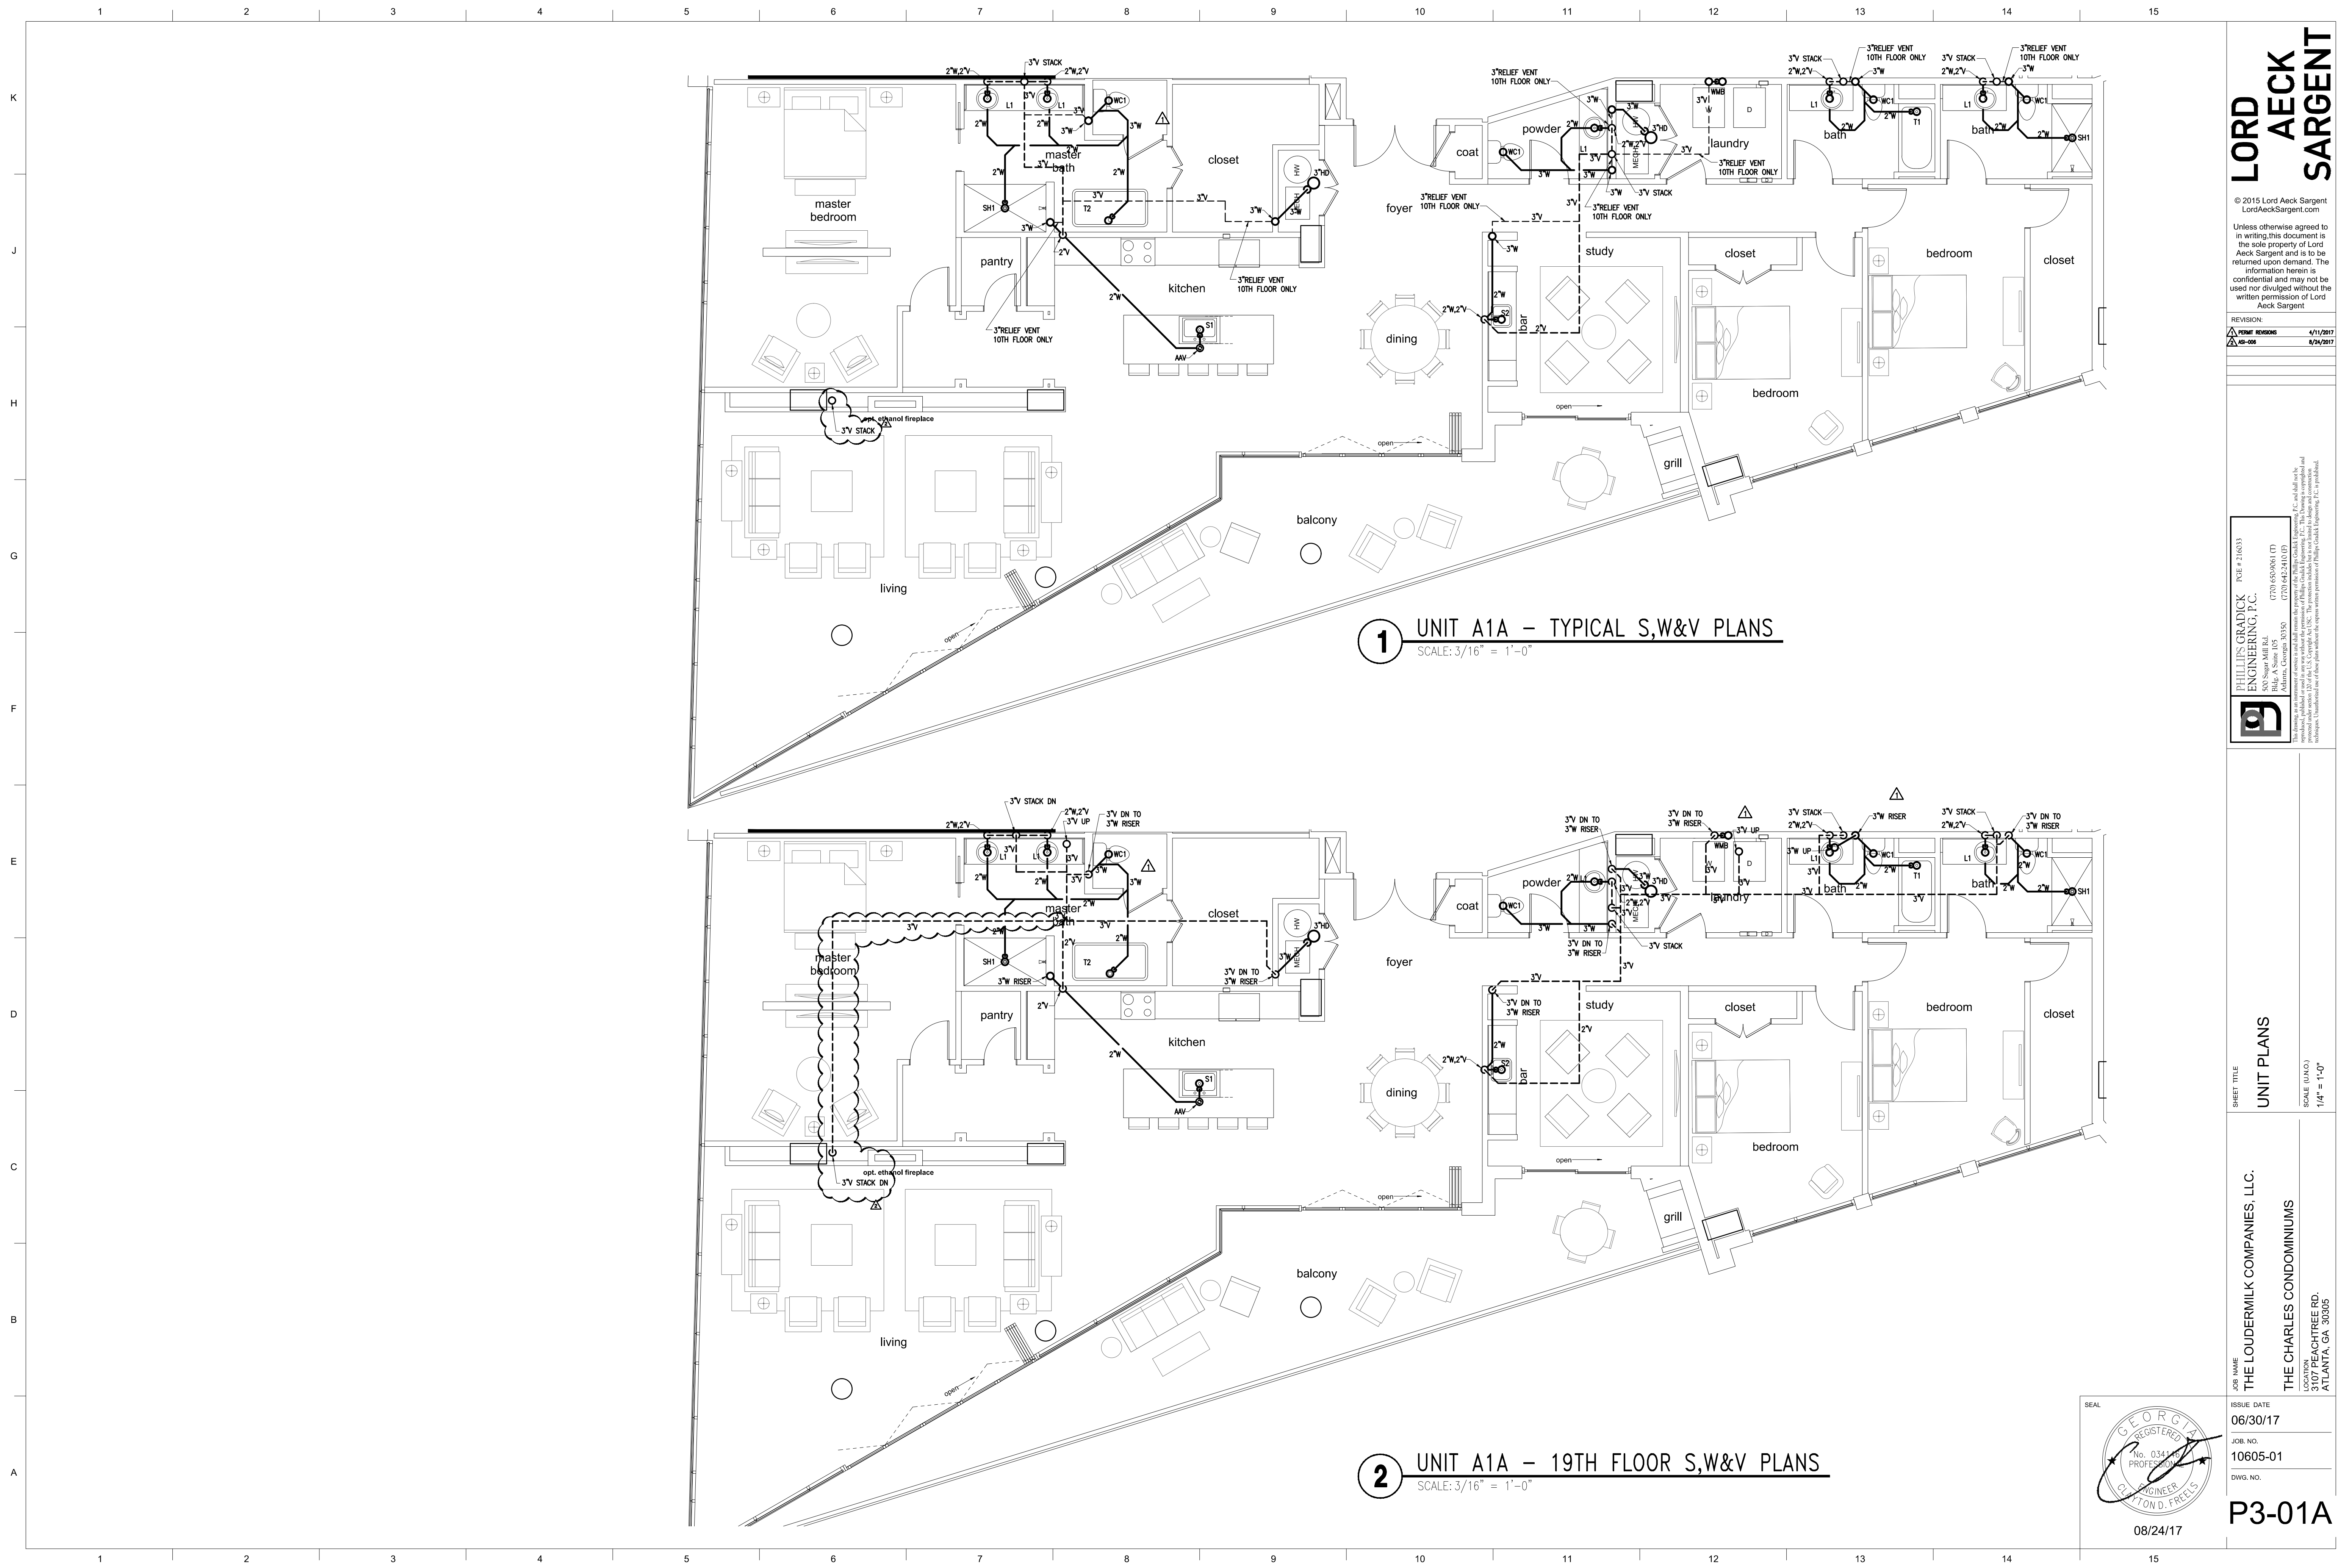

1 UNIT A1A – TYPICAL S,W&V PLANS
SCALE: 3/16" = 1'-0"

2 UNIT A1A – 19TH FLOOR S,W&V PLANS
SCALE: 3/16" = 1'-0"

**LORD
AECK
SARGENT**

© 2015 Lord Aeck Sargent
LordAeckSargent.com
Unless otherwise agreed to in writing, this document is the sole property of Lord Aeck Sargent and is to be returned upon demand. The information herein is confidential and may not be used nor divulged without the written permission of Lord Aeck Sargent.

REVISION:	
PERMIT REVISIONS	4/1/2017
2/48-008	8/24/2017



**PHILLIPS GRADICK
ENGINEERING, P.C.**
500 Sugar Mill Rd.
Raleigh, NC 27605
(770) 655-5811 (T)
(770) 655-5812 (F)
www.phillipsgradick.com


PG# 2 210633

This drawing is an advisory document only and does not constitute a contract. It is the responsibility of the client to verify the accuracy of the information provided. The drawings are not to be used for construction without the express written permission of Phillips Gradick Engineering, P.C. or its authorized representative. Unintended use of these plans without the express written permission of Phillips Gradick Engineering, P.C. is prohibited.

SHEET TITLE
UNIT PLANS
SCALE (UNITS)
1/4" = 1'-0"


JOB NAME
THE LOUDERMILK COMPANIES, LLC.
LOCATION
THE CHARLES CONDOMINIUMS
3107 PEACHTREE RD.
ATLANTA, GA 30305

ISSUE DATE
06/30/17
JOB NO.
10605-01
DWG. NO.

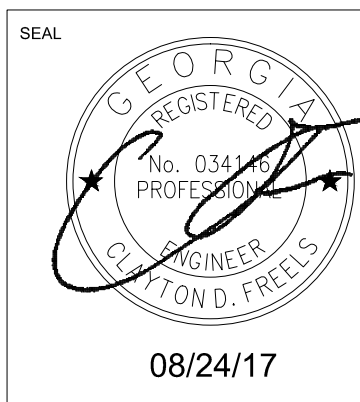

P3-01A

ISSUED FOR CONSTRUCTION

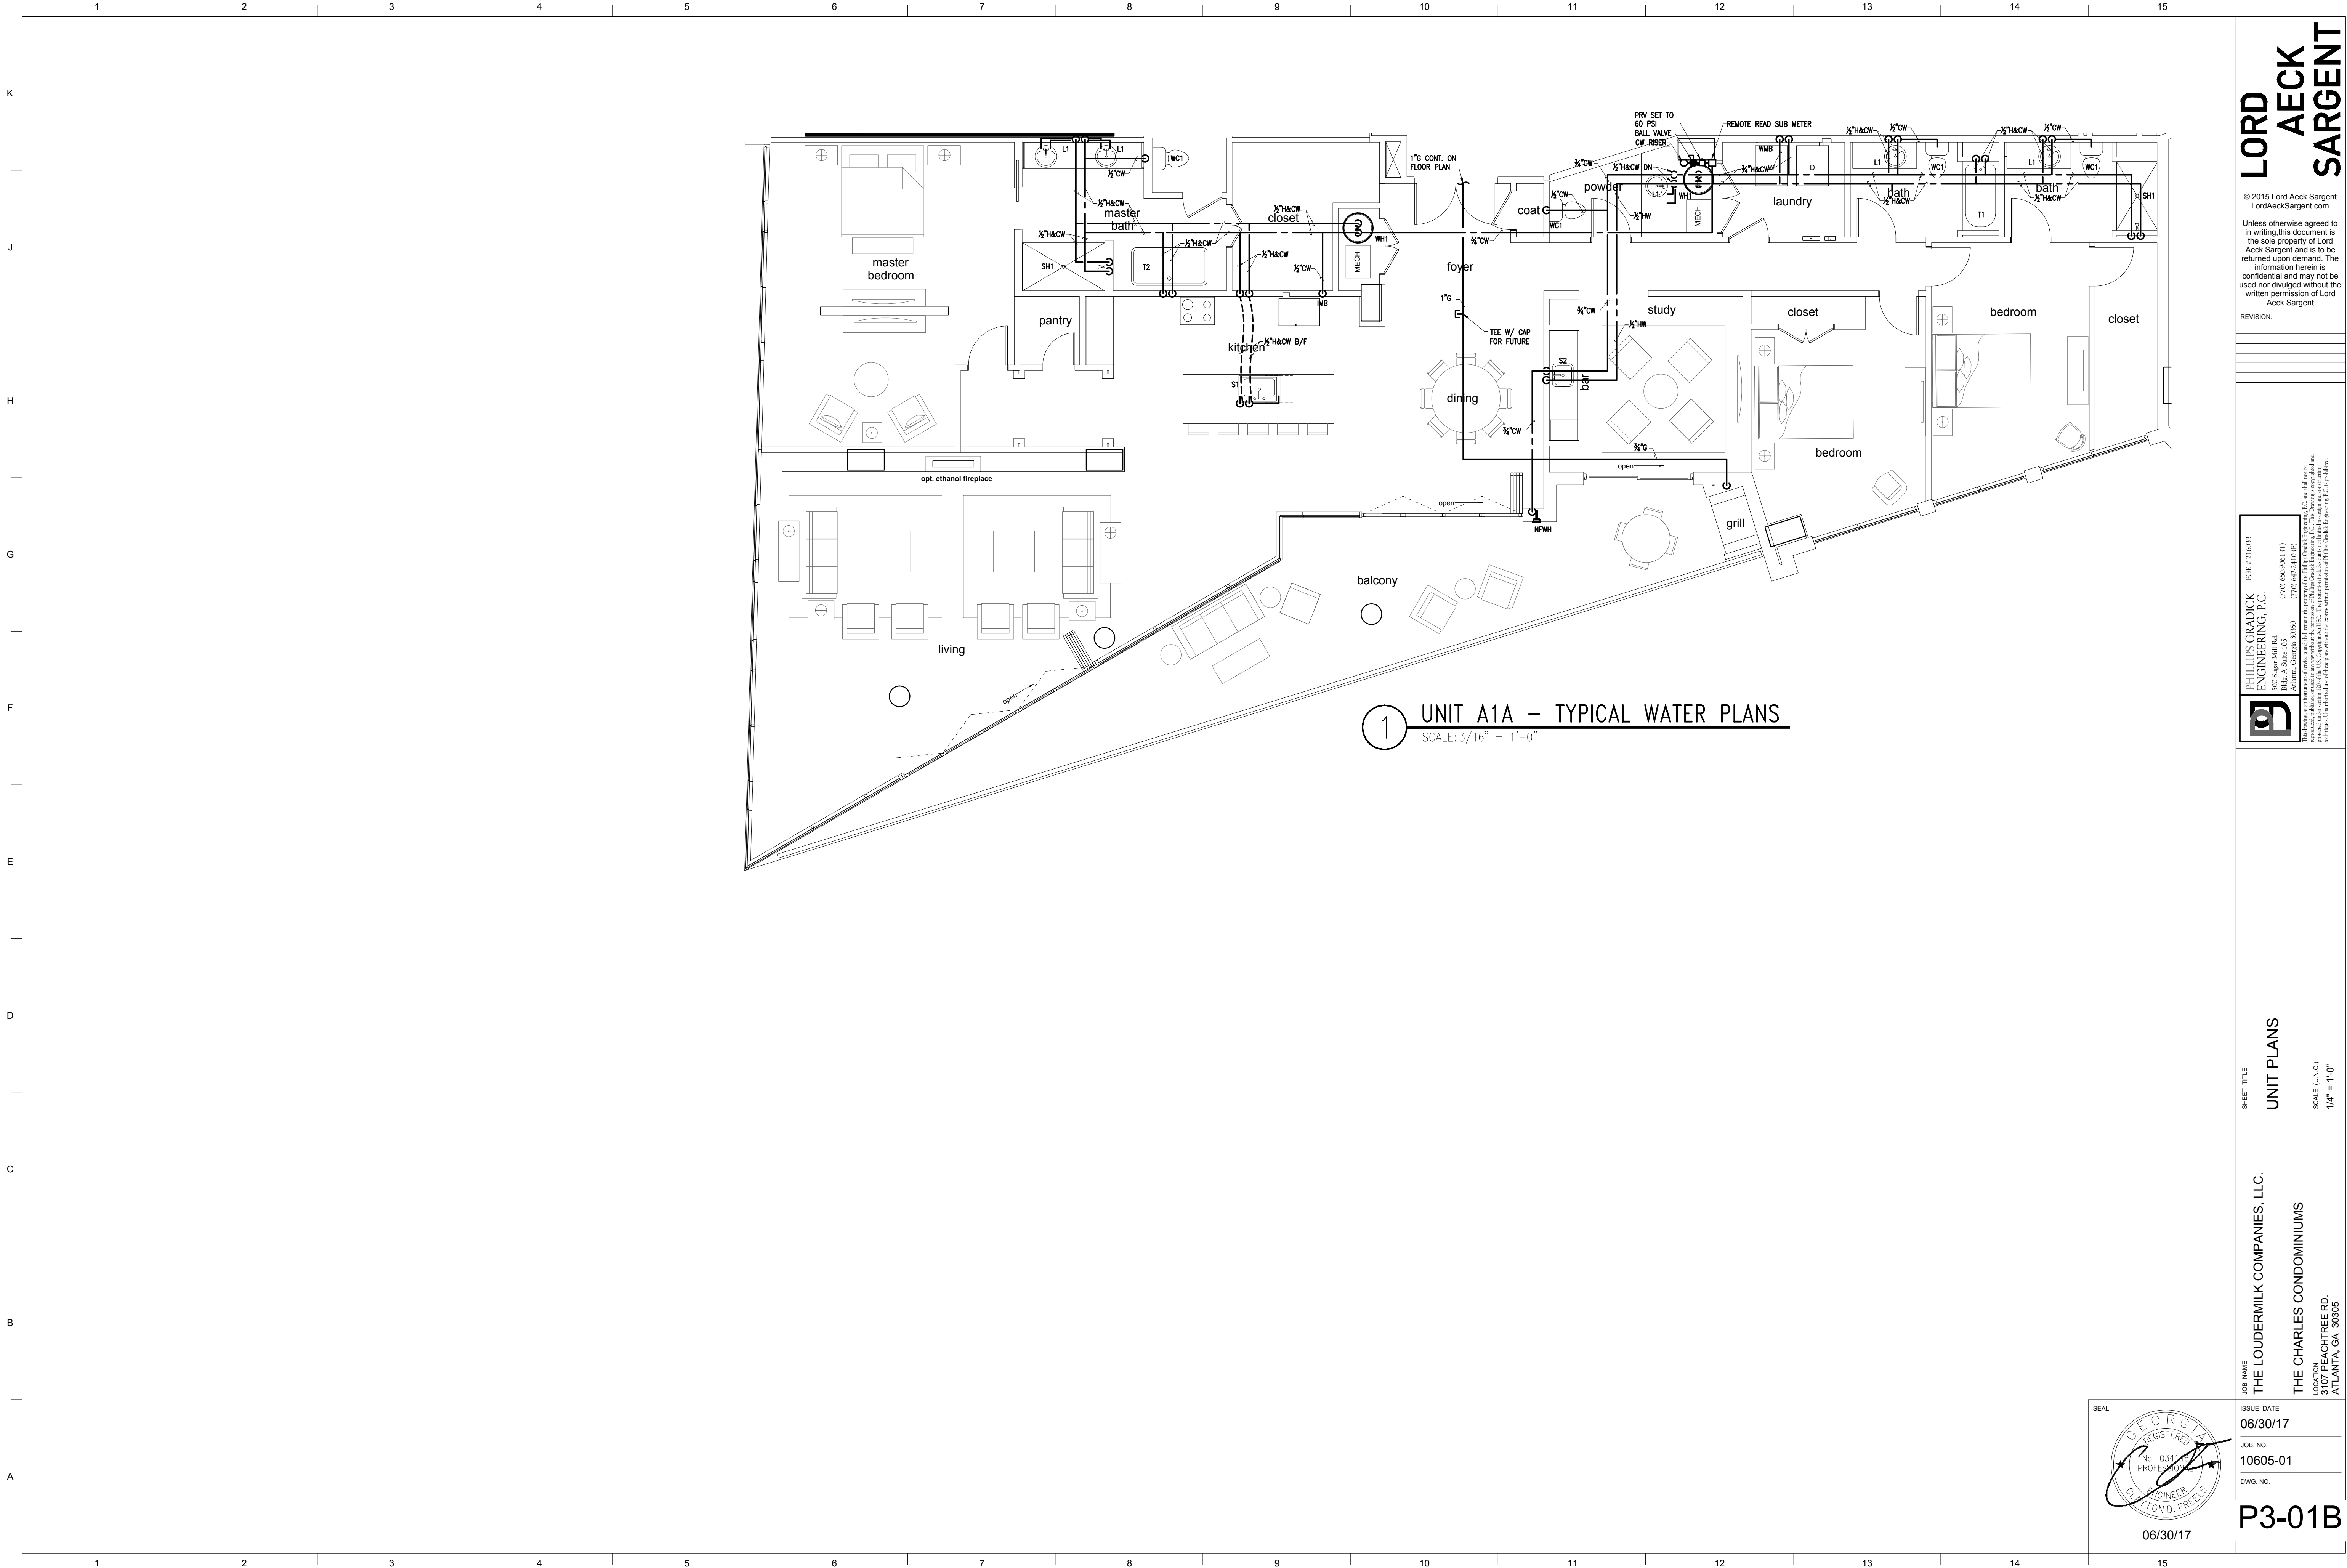

**LORD
AECK
SARGENT**

© 2015 Lord Aeck Sargent
LordAeckSargent.com
Unless otherwise agreed to in writing, this document is the sole property of Lord Aeck Sargent and is to be returned upon demand. The information herein is confidential and may not be used nor divulged without the written permission of Lord Aeck Sargent

REVISION:


PHILLIPS GRADICK
ENGINEERING, P.C.
500 Sugar Mill Rd.
Bldg. A Suite 105
Atlanta, Georgia 30350
(770) 535-5661 (F)
(770) 535-5441 (T)
www.phillipsgradick.com
This drawing is the property of Phillips Gradick Engineering, P.C. and shall not be reproduced, published or used in any way without the permission of Phillips Gradick Engineering, P.C. This drawing is confidential and its disclosure to any third party without the express written permission of Phillips Gradick Engineering, P.C. is prohibited.


**PHILLIPS GRADICK
ENGINEERING, P.C.**
500 Sugar Mill Rd.
Bldg. A Suite 105
Atlanta, Georgia 30350
(770) 535-5661 (F)
(770) 535-5441 (T)
www.phillipsgradick.com
This drawing is the property of Phillips Gradick Engineering, P.C. and shall not be reproduced, published or used in any way without the permission of Phillips Gradick Engineering, P.C. This drawing is confidential and its disclosure to any third party without the express written permission of Phillips Gradick Engineering, P.C. is prohibited.


UNIT PLANS
SCALE (UNITS)
1/4" = 1'-0"

THE LOUDERMILK COMPANIES, LLC.
THE CHARLES CONDOMINIUMS
LOCATION
3107 PEACHTREE RD.
ATLANTA, GA 30305

ISSUE DATE
06/30/17
JOB NO.
10605-01
DWG. NO.
P3-01B

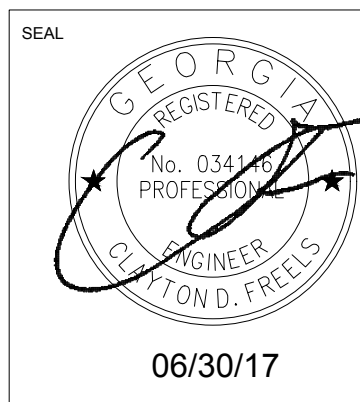

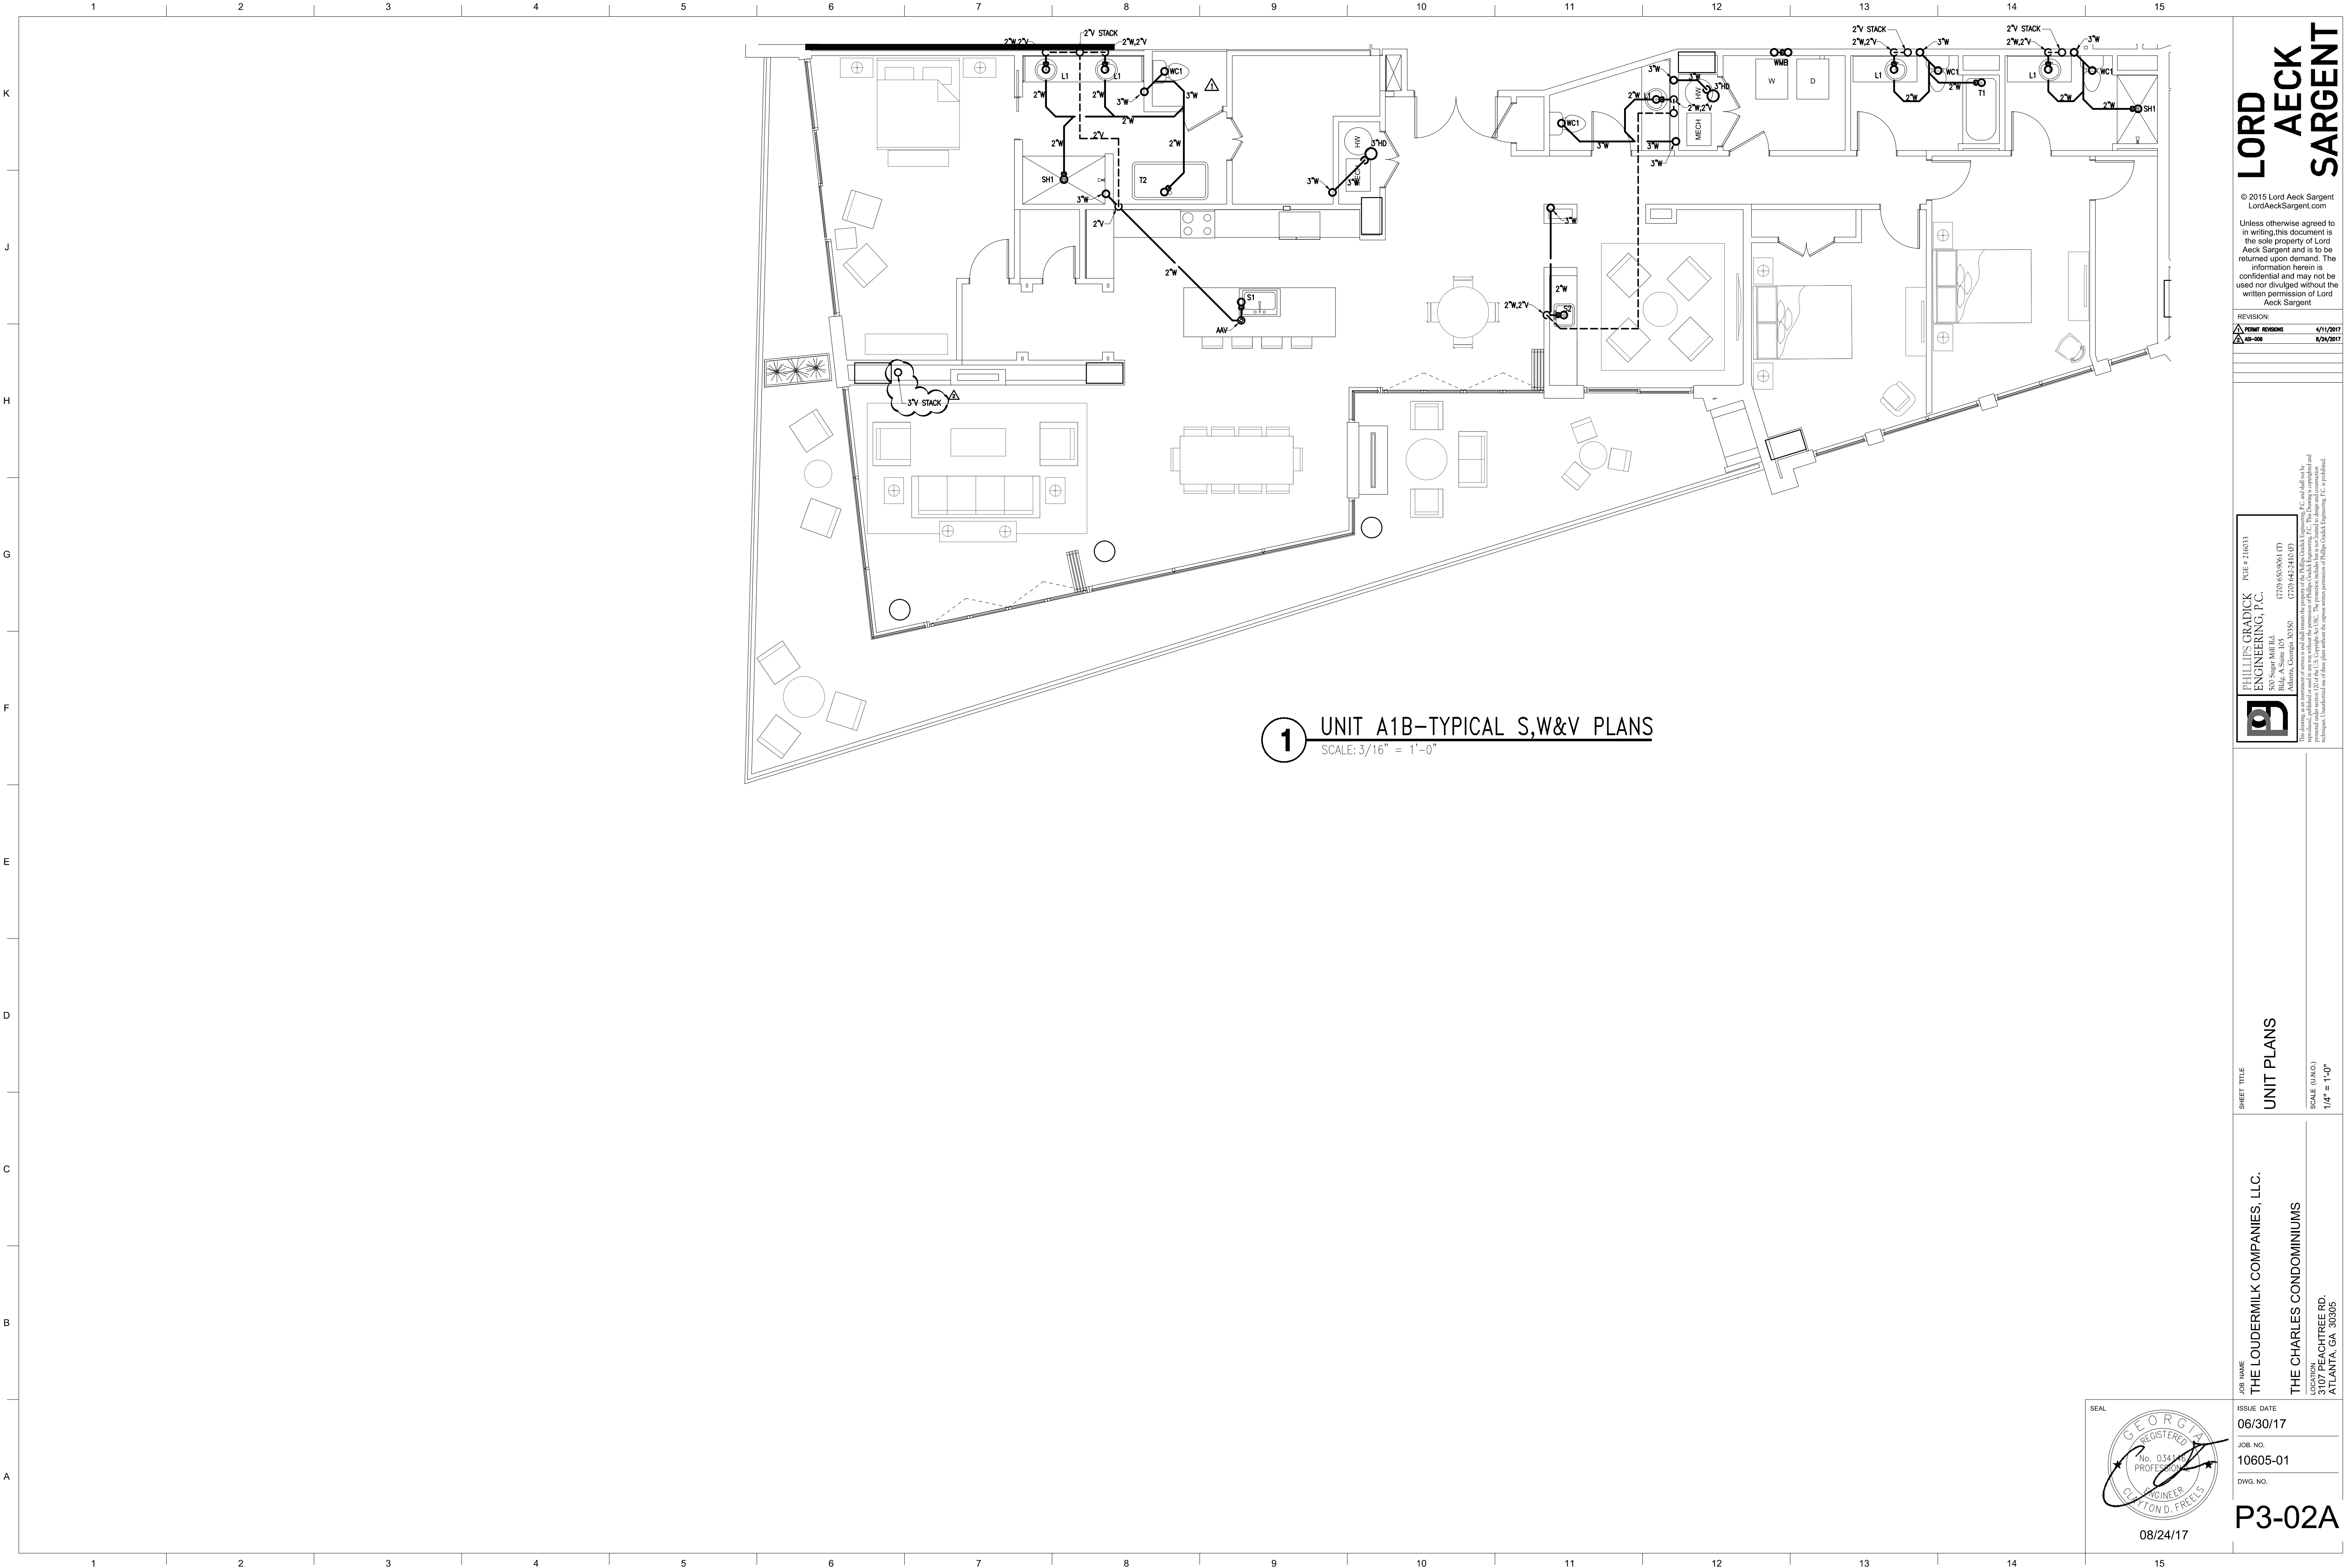

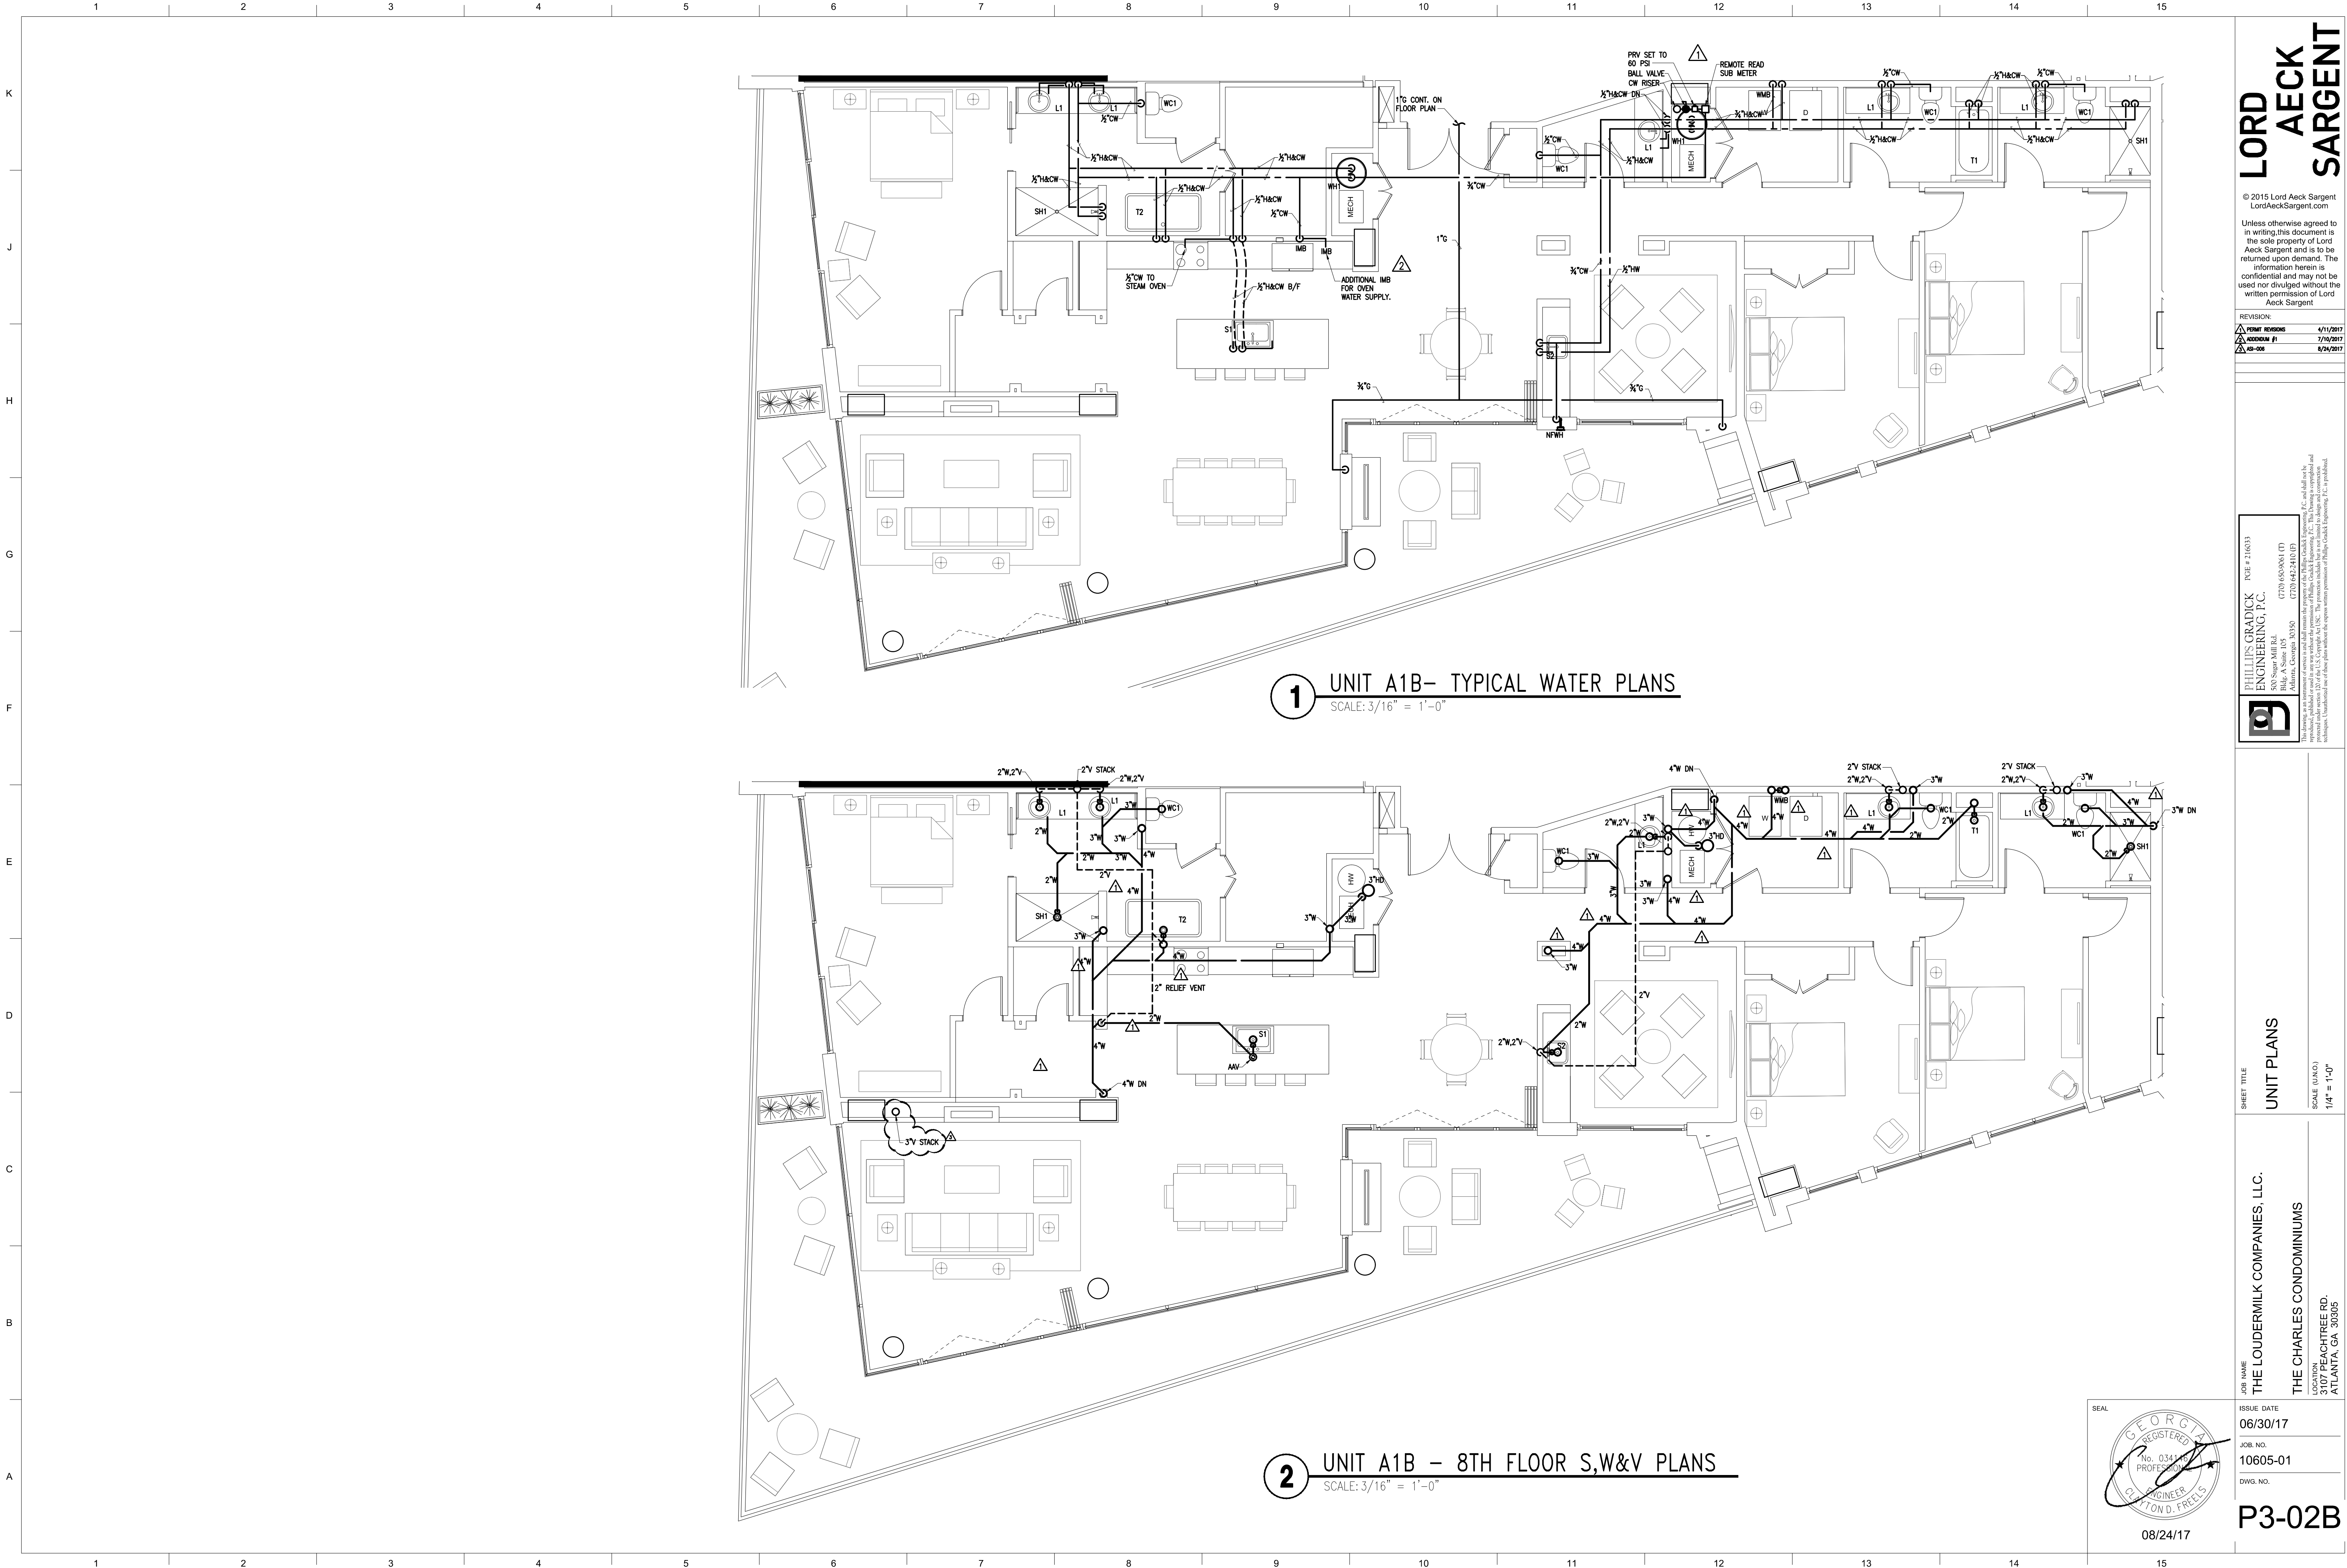

1 UNIT A1B- TYPICAL WATER PLANS
SCALE: 3/16" = 1'-0"

2 UNIT A1B - 8TH FLOOR S,W&V PLANS
SCALE: 3/16" = 1'-0"

LORD AECK SARGENT

© 2015 Lord Aeck Sargent
LordAeckSargent.com
Unless otherwise agreed to in writing, this document is the sole property of Lord Aeck Sargent and is to be returned upon demand. The information herein is confidential and may not be used or divulged without the written permission of Lord Aeck Sargent.

REVISION:	
PERMIT REVISIONS	4/11/2017
ADDENDUM #1	7/19/2017
45-008	8/24/2017




**PHILLIPS GRADICK
ENGINEERING, P.C.**
500 Sugar Mill Rd.
Raleigh, NC 27605
(770) 655-5811 (T)
(770) 655-5811 (F)
www.phillipsgradiack.com

PG# 2 210633
This drawing is the property of Phillips Gradiack Engineering, P.C. and shall not be reproduced, stored in a retrieval system, or transmitted in any form or by any means, electronic, mechanical, photocopying, recording, or by any information storage and retrieval system, without the prior written permission of Phillips Gradiack Engineering, P.C. Any unauthorized use of this drawing without the express written permission of Phillips Gradiack Engineering, P.C. is prohibited.

SHEET TITLE
UNIT PLANS
SCALE (UNITS)
1/4" = 1'-0"


JOB NAME
THE LOUDERMILK COMPANIES, LLC.
LOCATION
THE CHARLES CONDOMINIUMS
3107 PEACHTREE RD.
ATLANTA, GA 30305

ISSUE DATE
06/30/17
JOB NO.
10605-01
DWG. NO.

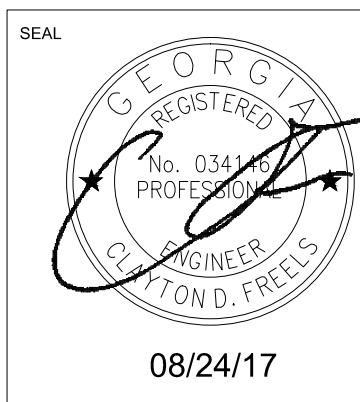

P3-02B

ISSUED FOR CONSTRUCTION

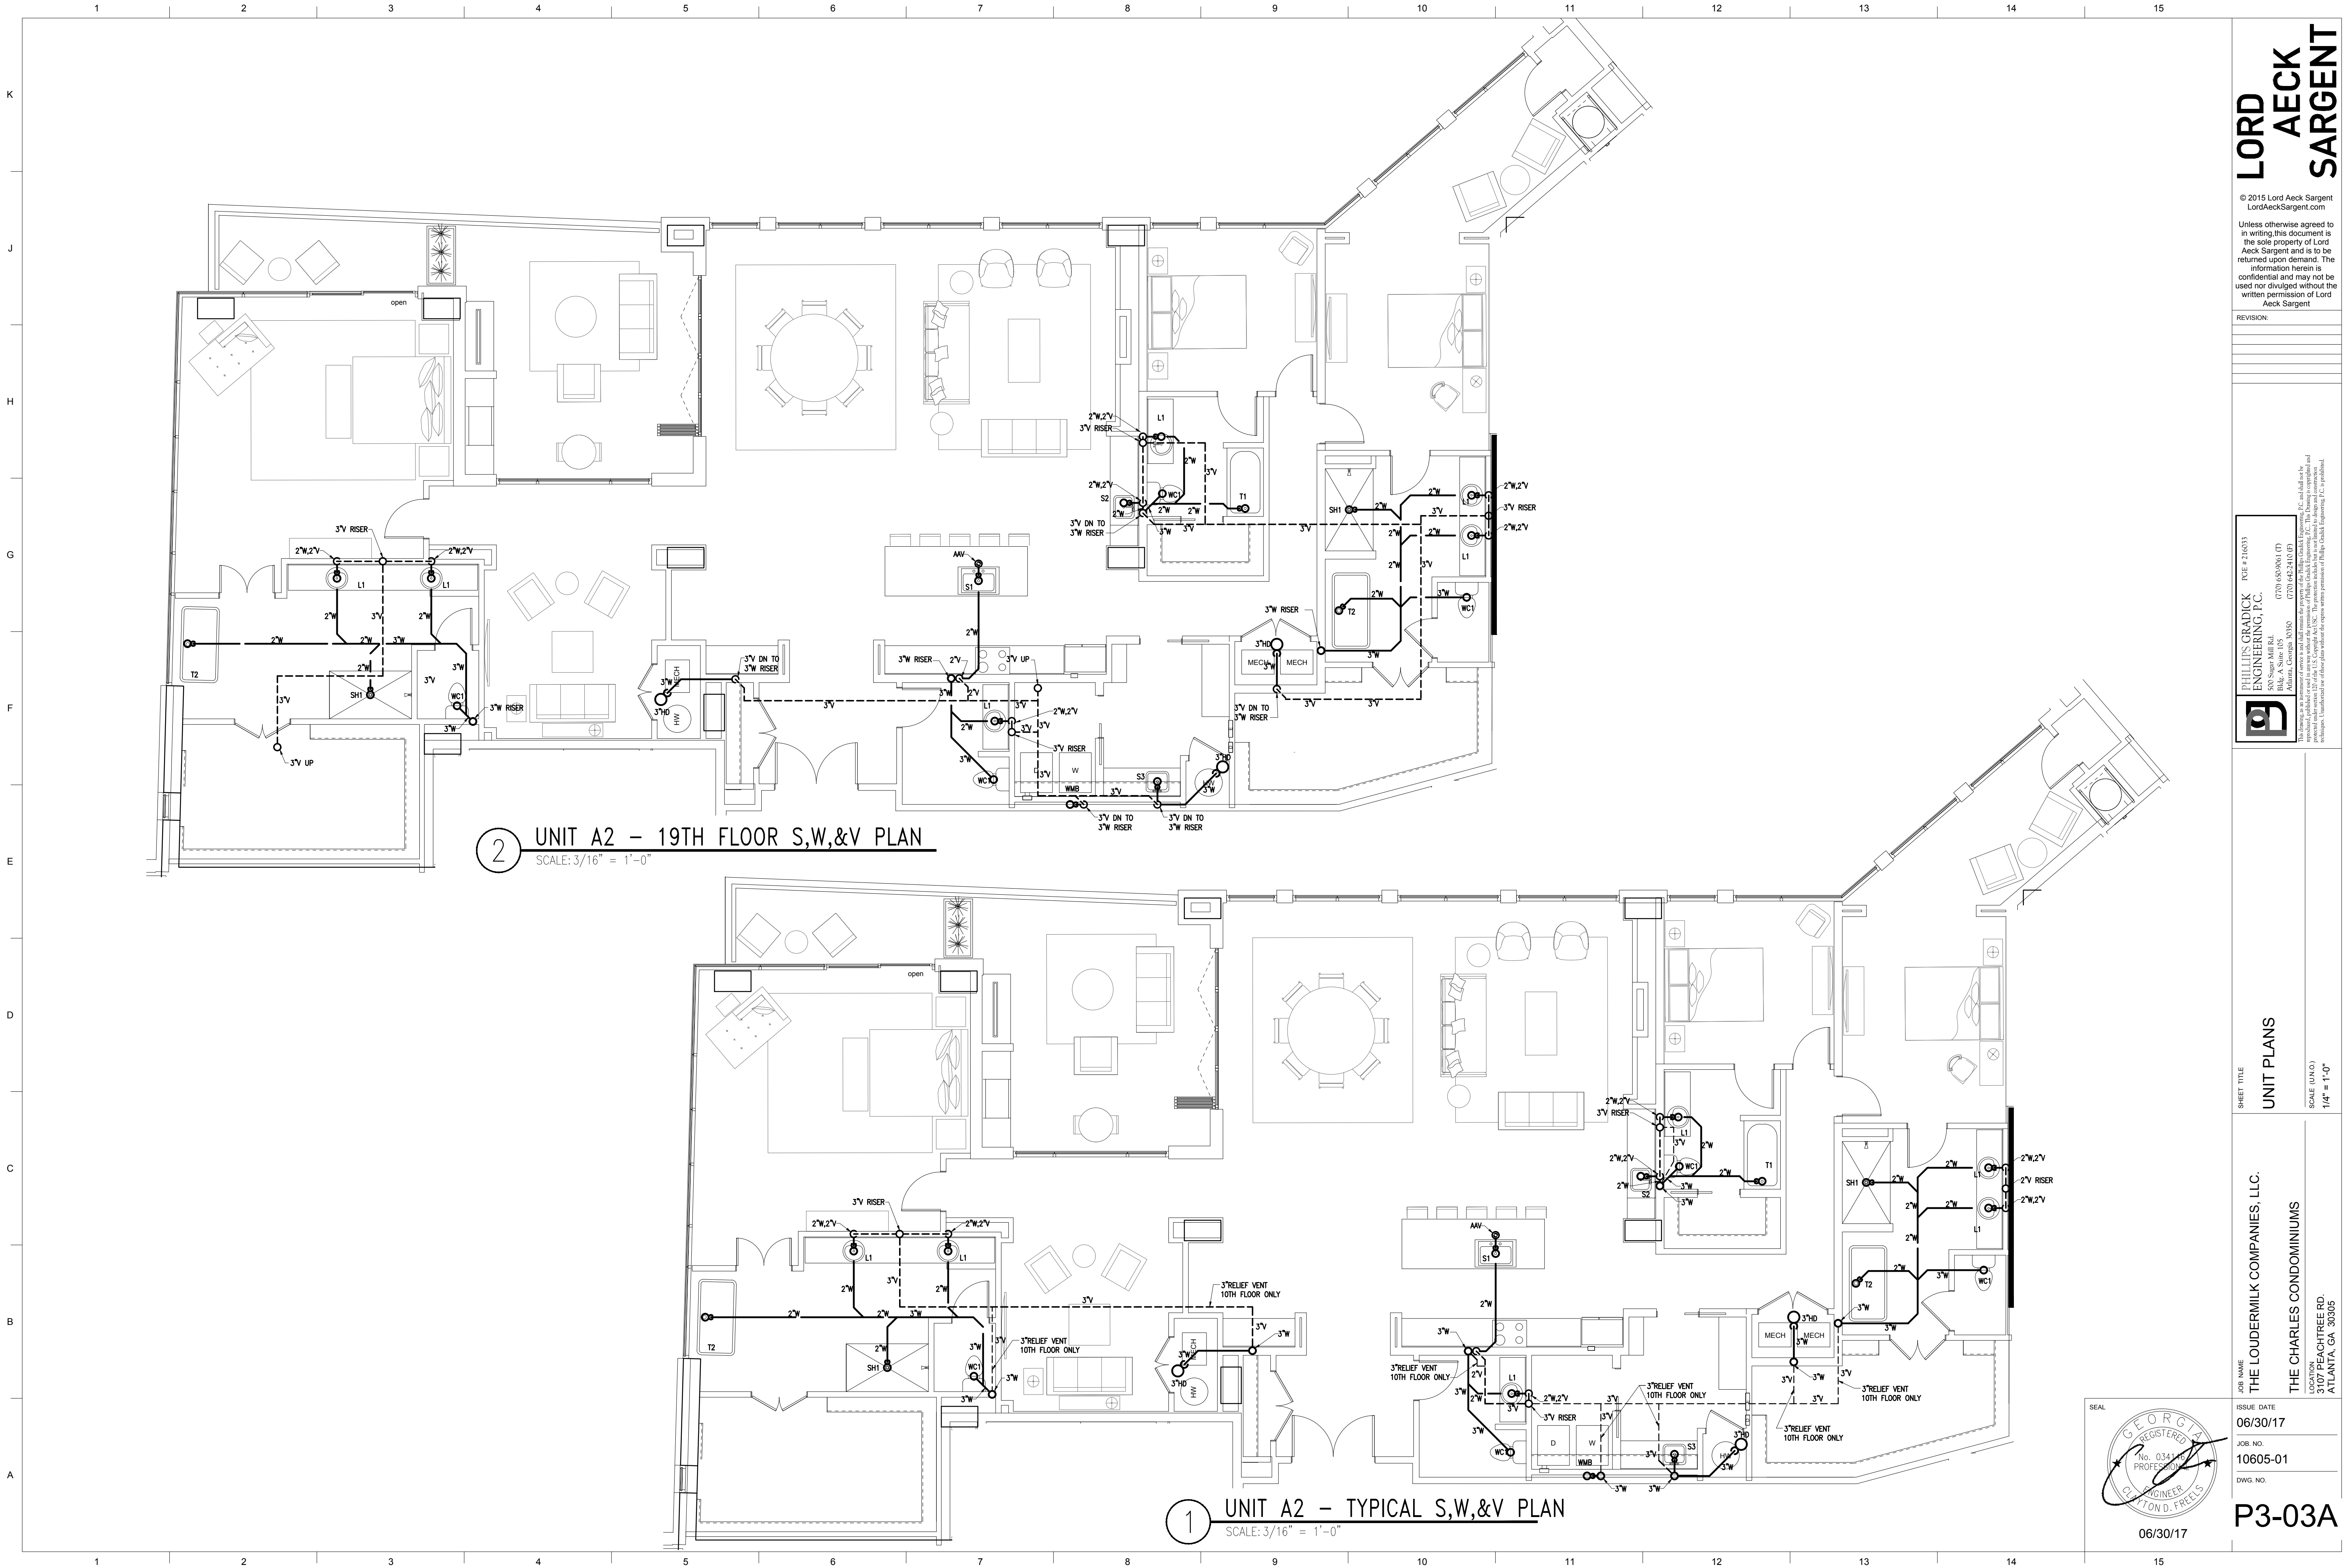

**LORD
AECK
SARGENT**

© 2015 Lord Aeck Sargent
LordAeckSargent.com
Unless otherwise agreed to
in writing, this document is
the sole property of Lord
Aeck Sargent and is to be
returned upon demand. The
information herein is
confidential and may not be
used nor divulged without the
written permission of Lord
Aeck Sargent

REVISION:




**PHILLIPS GRADIAK
ENGINEERING, P.C.**
500 Sugar Mill Rd.
Bldg. A Suite 105
Atlanta, Georgia 30305
(770) 442-2411 (F)
(770) 442-2411 (T)
phillips@gradiak-engineering.com
www.gradiak-engineering.com

PCE # 210033

SHEET TITLE
UNIT PLANS
SCALE (UNOS)
1/4" = 1'-0"


JOB NAME
THE LOUDERMILK COMPANIES, LLC.
LOCATION
THE CHARLES CONDOMINIUMS
3107 PEACHTREE RD.
ATLANTA, GA 30305

ISSUE DATE
06/30/17
JOB NO.
10605-01
DWG. NO.

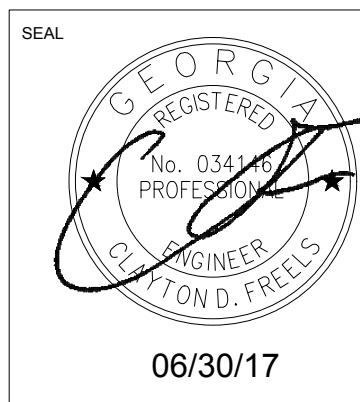

P3-03A

K
J
H
G
F
E
D
C
B
A

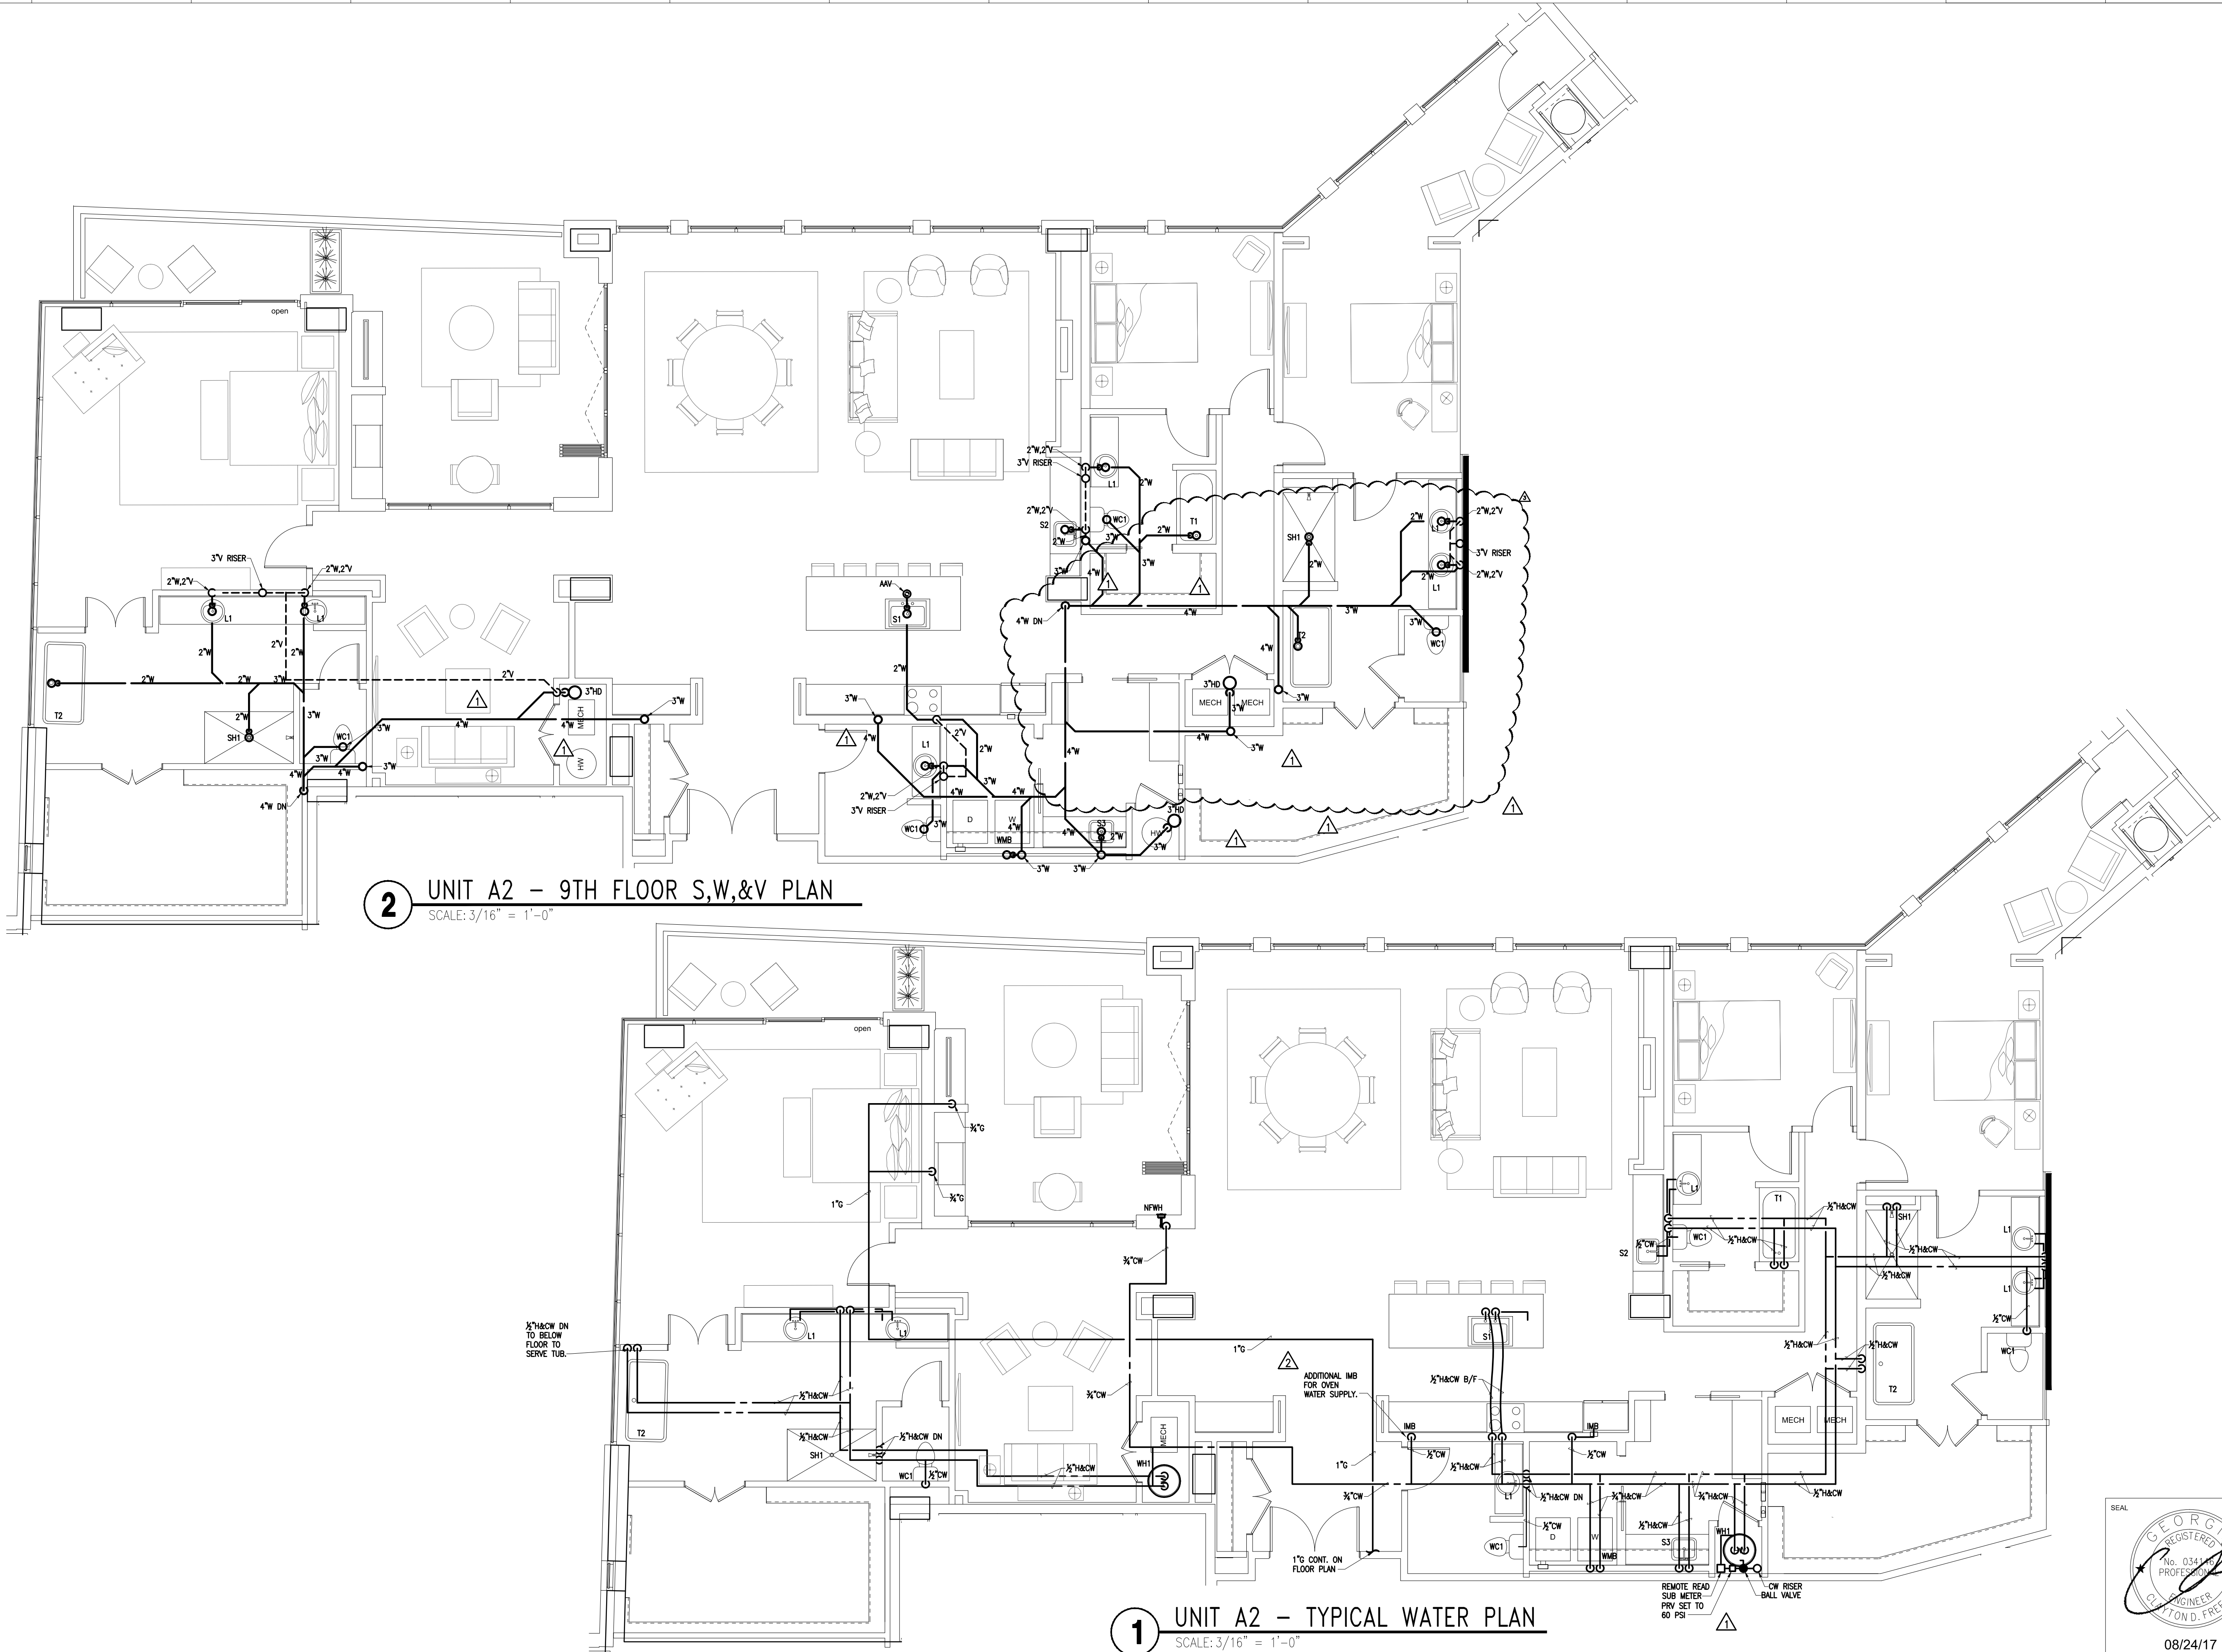

2 UNIT A2 – 9TH FLOOR S,W,&V PLAN
SCALE: 3/16" = 1'-0"

1 UNIT A2 – TYPICAL WATER PLAN
SCALE: 3/16" = 1'-0"



LORD AECK SARGENT

© 2015 Lord Aeck Sargent
LordAeckSargent.com

Unless otherwise agreed to in writing, this document is the sole property of Lord Aeck Sargent and is to be returned upon demand. The information herein is confidential and may not be used nor divulged without the written permission of Lord Aeck Sargent.

REVISION:	
PERMIT REVISIONS	4/1/2017
REVISION #1	7/10/2017
AS-005	5/24/2017

PHILLIPS GRADICK ENGINEERING, P.C.

1000 Peachtree Road, Suite 1050
Atlanta, Georgia 30309

PHILLIPS GRADICK ENGINEERING, P.C. is a professional engineering firm registered in the State of Georgia. The firm is a member of the Georgia Council on Professional Engineering (GCPE) and the Georgia Society of Professional Engineers (GSPE). The firm is also a member of the Georgia Institute of Technology (GT) and the Georgia Institute of Science and Technology (GIS&T).

SHEET TITLE
UNIT PLANS

SCALE (UNITS)
1/4" = 1'-0"

JOB NAME
THE LOUDERMILK COMPANIES, LLC.

ISSUE DATE
06/30/17

JOB NO.
10605-01

DWG. NO.

P3-03B

ISSUED FOR CONSTRUCTION



**LORD
AECK
SARGENT**

© 2015 Lord Aeck Sargent
LordAeckSargent.com

Unless otherwise agreed to in writing, this document is the sole property of Lord Aeck Sargent and is to be returned upon demand. The information herein is confidential and may not be used nor divulged without the written permission of Lord Aeck Sargent

REVISION:	

**PHILLIPS GRADICK
ENGINEERING, P.C.**

PHG # 210033
500 Super Mill Rd.
Bldg. A Suite 105
Atlanta, Georgia 30305
(770) 638-5861 (F)
(770) 642-8410 (T)
phg@phg.com
www.phg.com

This drawing is the property of Phillips Gradiack Engineering, P.C. and shall not be reproduced, stored in a retrieval system, or transmitted in any form or by any means, electronic, mechanical, photocopying, recording, or by any information storage and retrieval system, without the prior written permission of Phillips Gradiack Engineering, P.C.

SHEET TITLE
UNIT PLANS

SCALE (UNITS)
1/4" = 1'-0"


JOB NAME
THE LOUDERMILK COMPANIES, LLC.

ISSUE DATE
06/30/17

JOB NO.
10605-01

DWG. NO.
P3-04A

LOCATION
**THE CHARLES CONDOMINIUMS
3107 PEACHTREE RD.
ATLANTA, GA 30305**

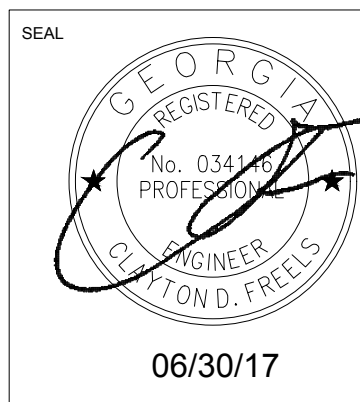



**LORD
AECK
SARGENT**

© 2015 Lord Aeck Sargent
LordAeckSargent.com

Unless otherwise agreed to in writing, this document is the sole property of Lord Aeck Sargent and is to be returned upon demand. The information herein is confidential and may not be used nor divulged without the written permission of Lord Aeck Sargent

REVISION:



**PHILLIPS GRADICK
ENGINEERING, P.C.**
Atlanta, Georgia 30305
500 Super Mill Rd.
Bldg. A Suite 105
Atlanta, Georgia 30305
(770) 442-2410
Fax: (770) 442-2411

PCE # 210033

This drawing is the property of Phillips Gradiack Engineering, P.C. and shall not be reproduced, stored in a retrieval system, or transmitted in any form or by any means, electronic, mechanical, photocopying, recording, or by any information storage and retrieval system, without the prior written permission of Phillips Gradiack Engineering, P.C. is prohibited.

SHEET TITLE
UNIT PLANS

SCALE (UNITS)
1/4" = 1'-0"

JOB NAME
THE LOUDERMILK COMPANIES, LLC.


ISSUE DATE
06/30/17



JOB NO.
10605-01

DWG. NO.

THE CHARLES CONDOMINIUMS
3107 PEACHTREE RD.
ATLANTA, GA 30305

P3-04B

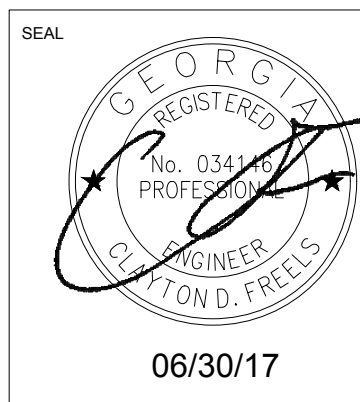

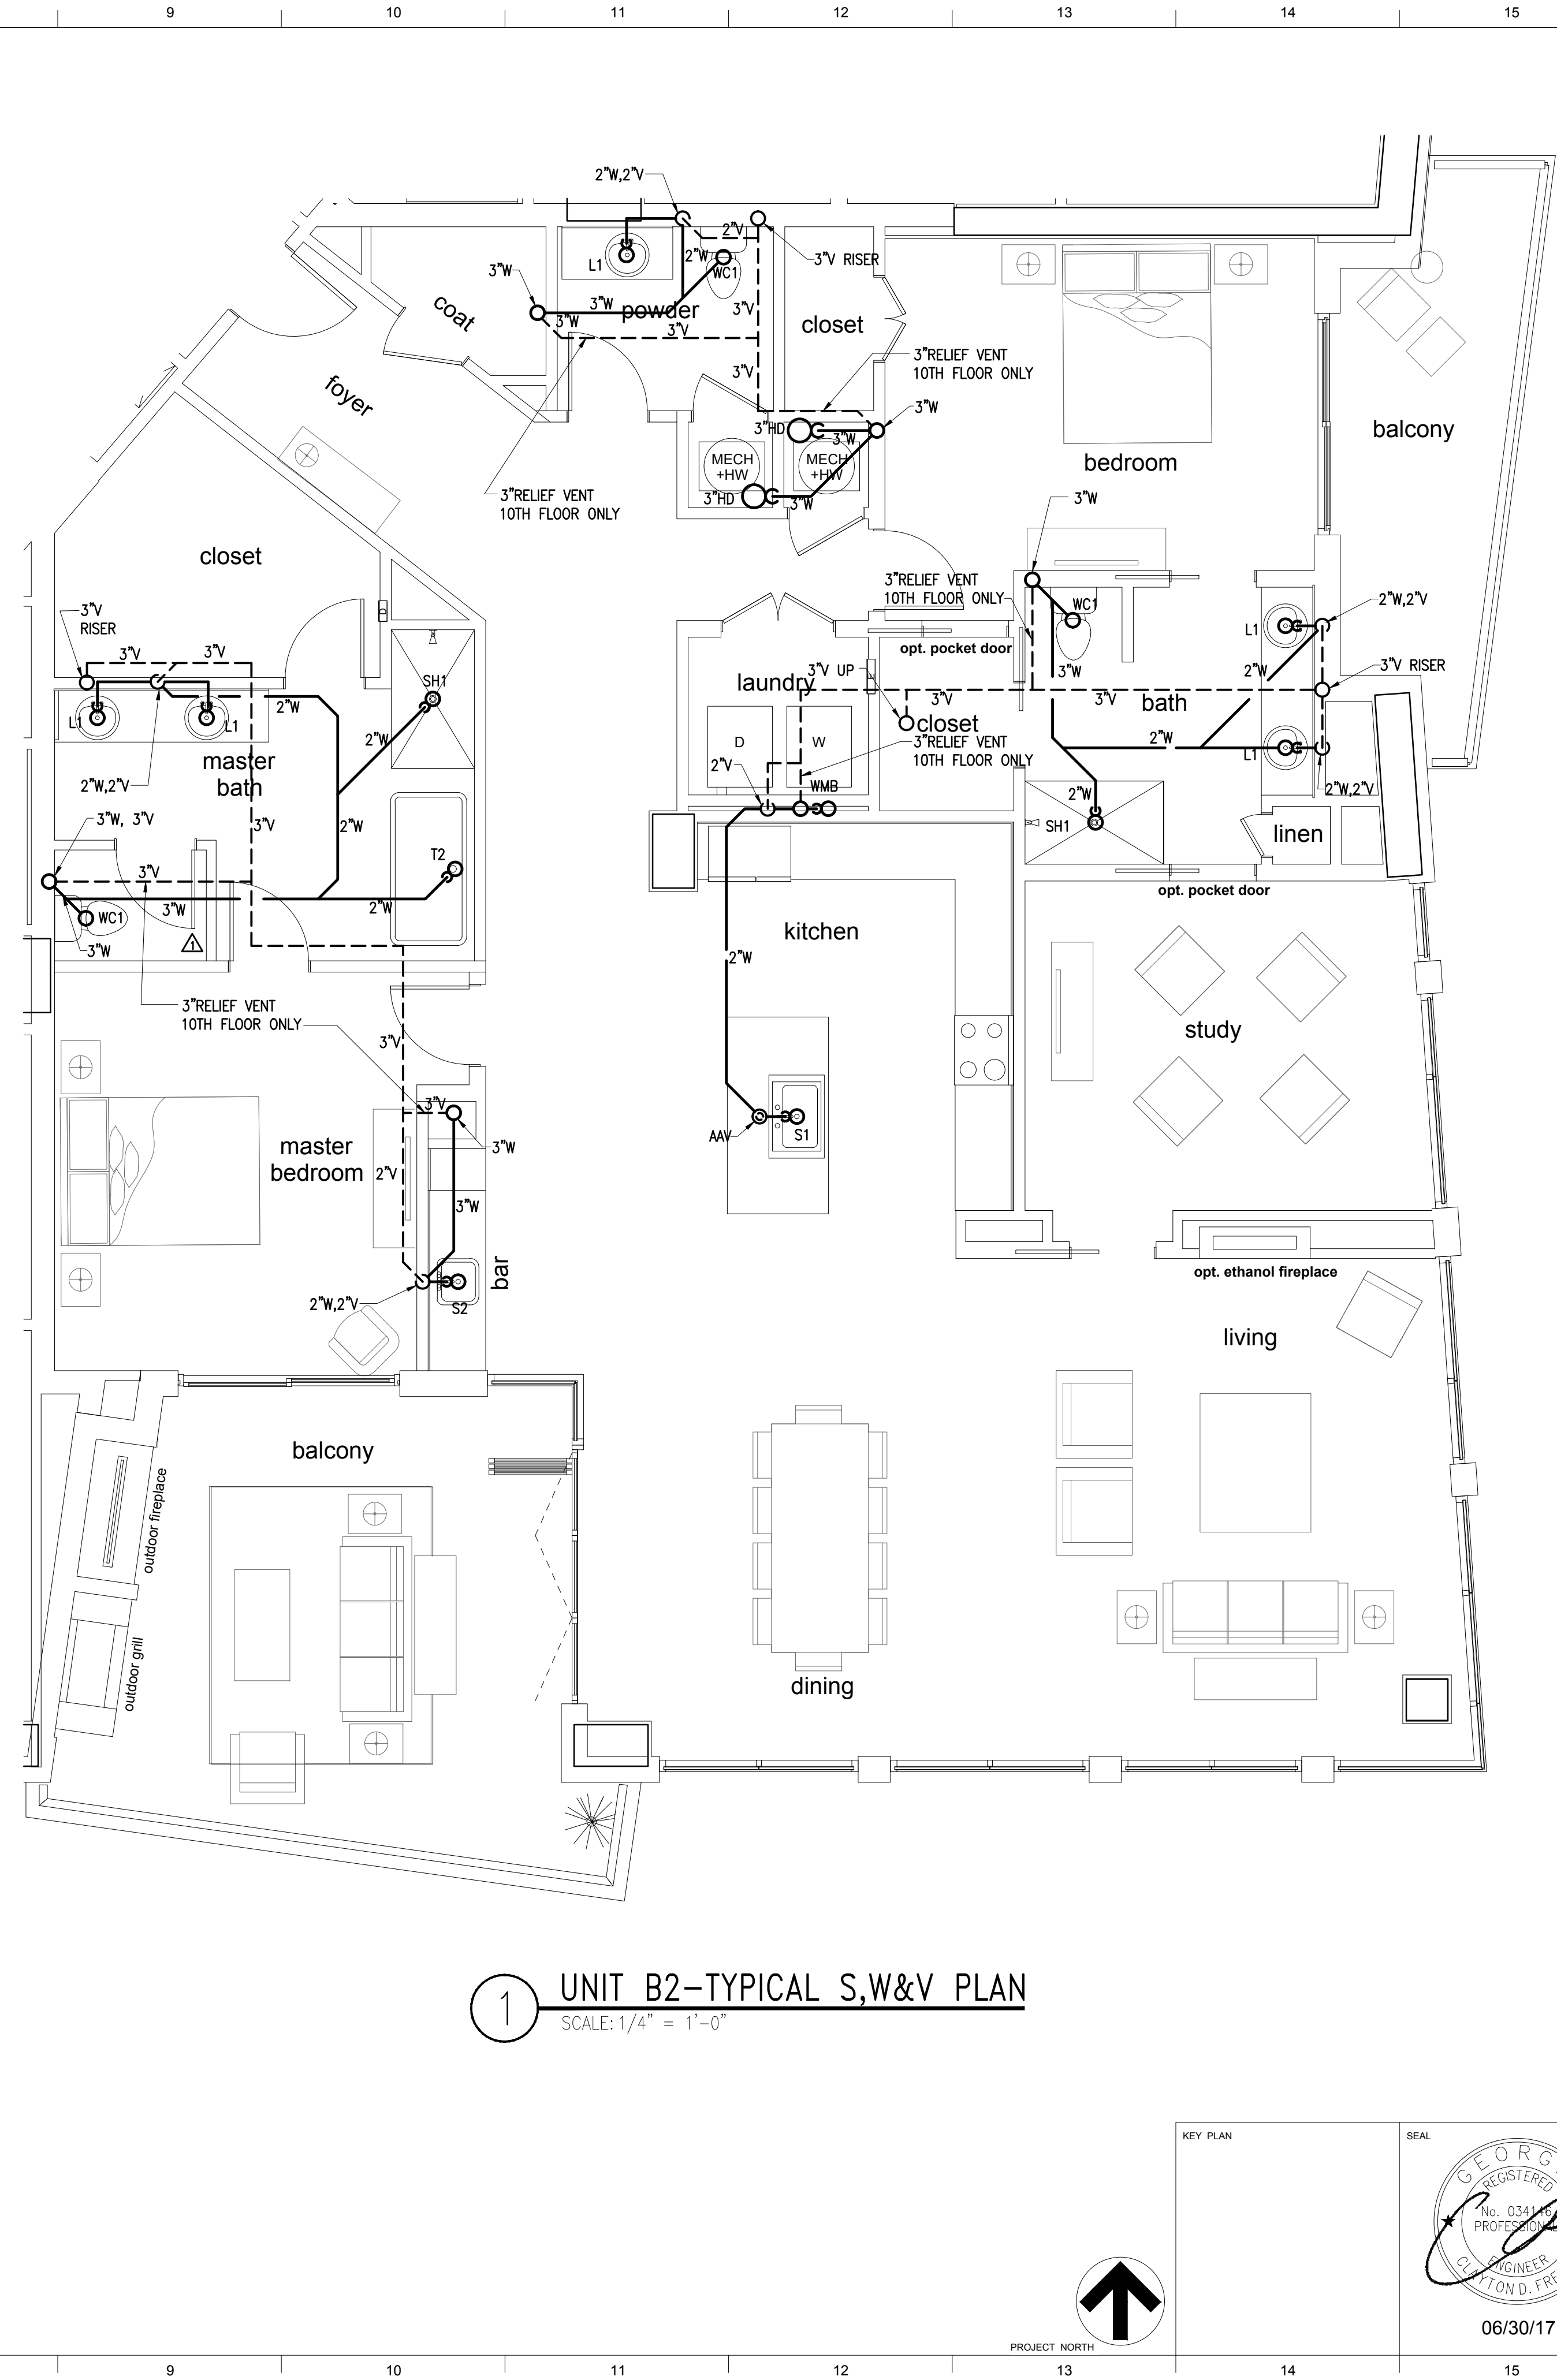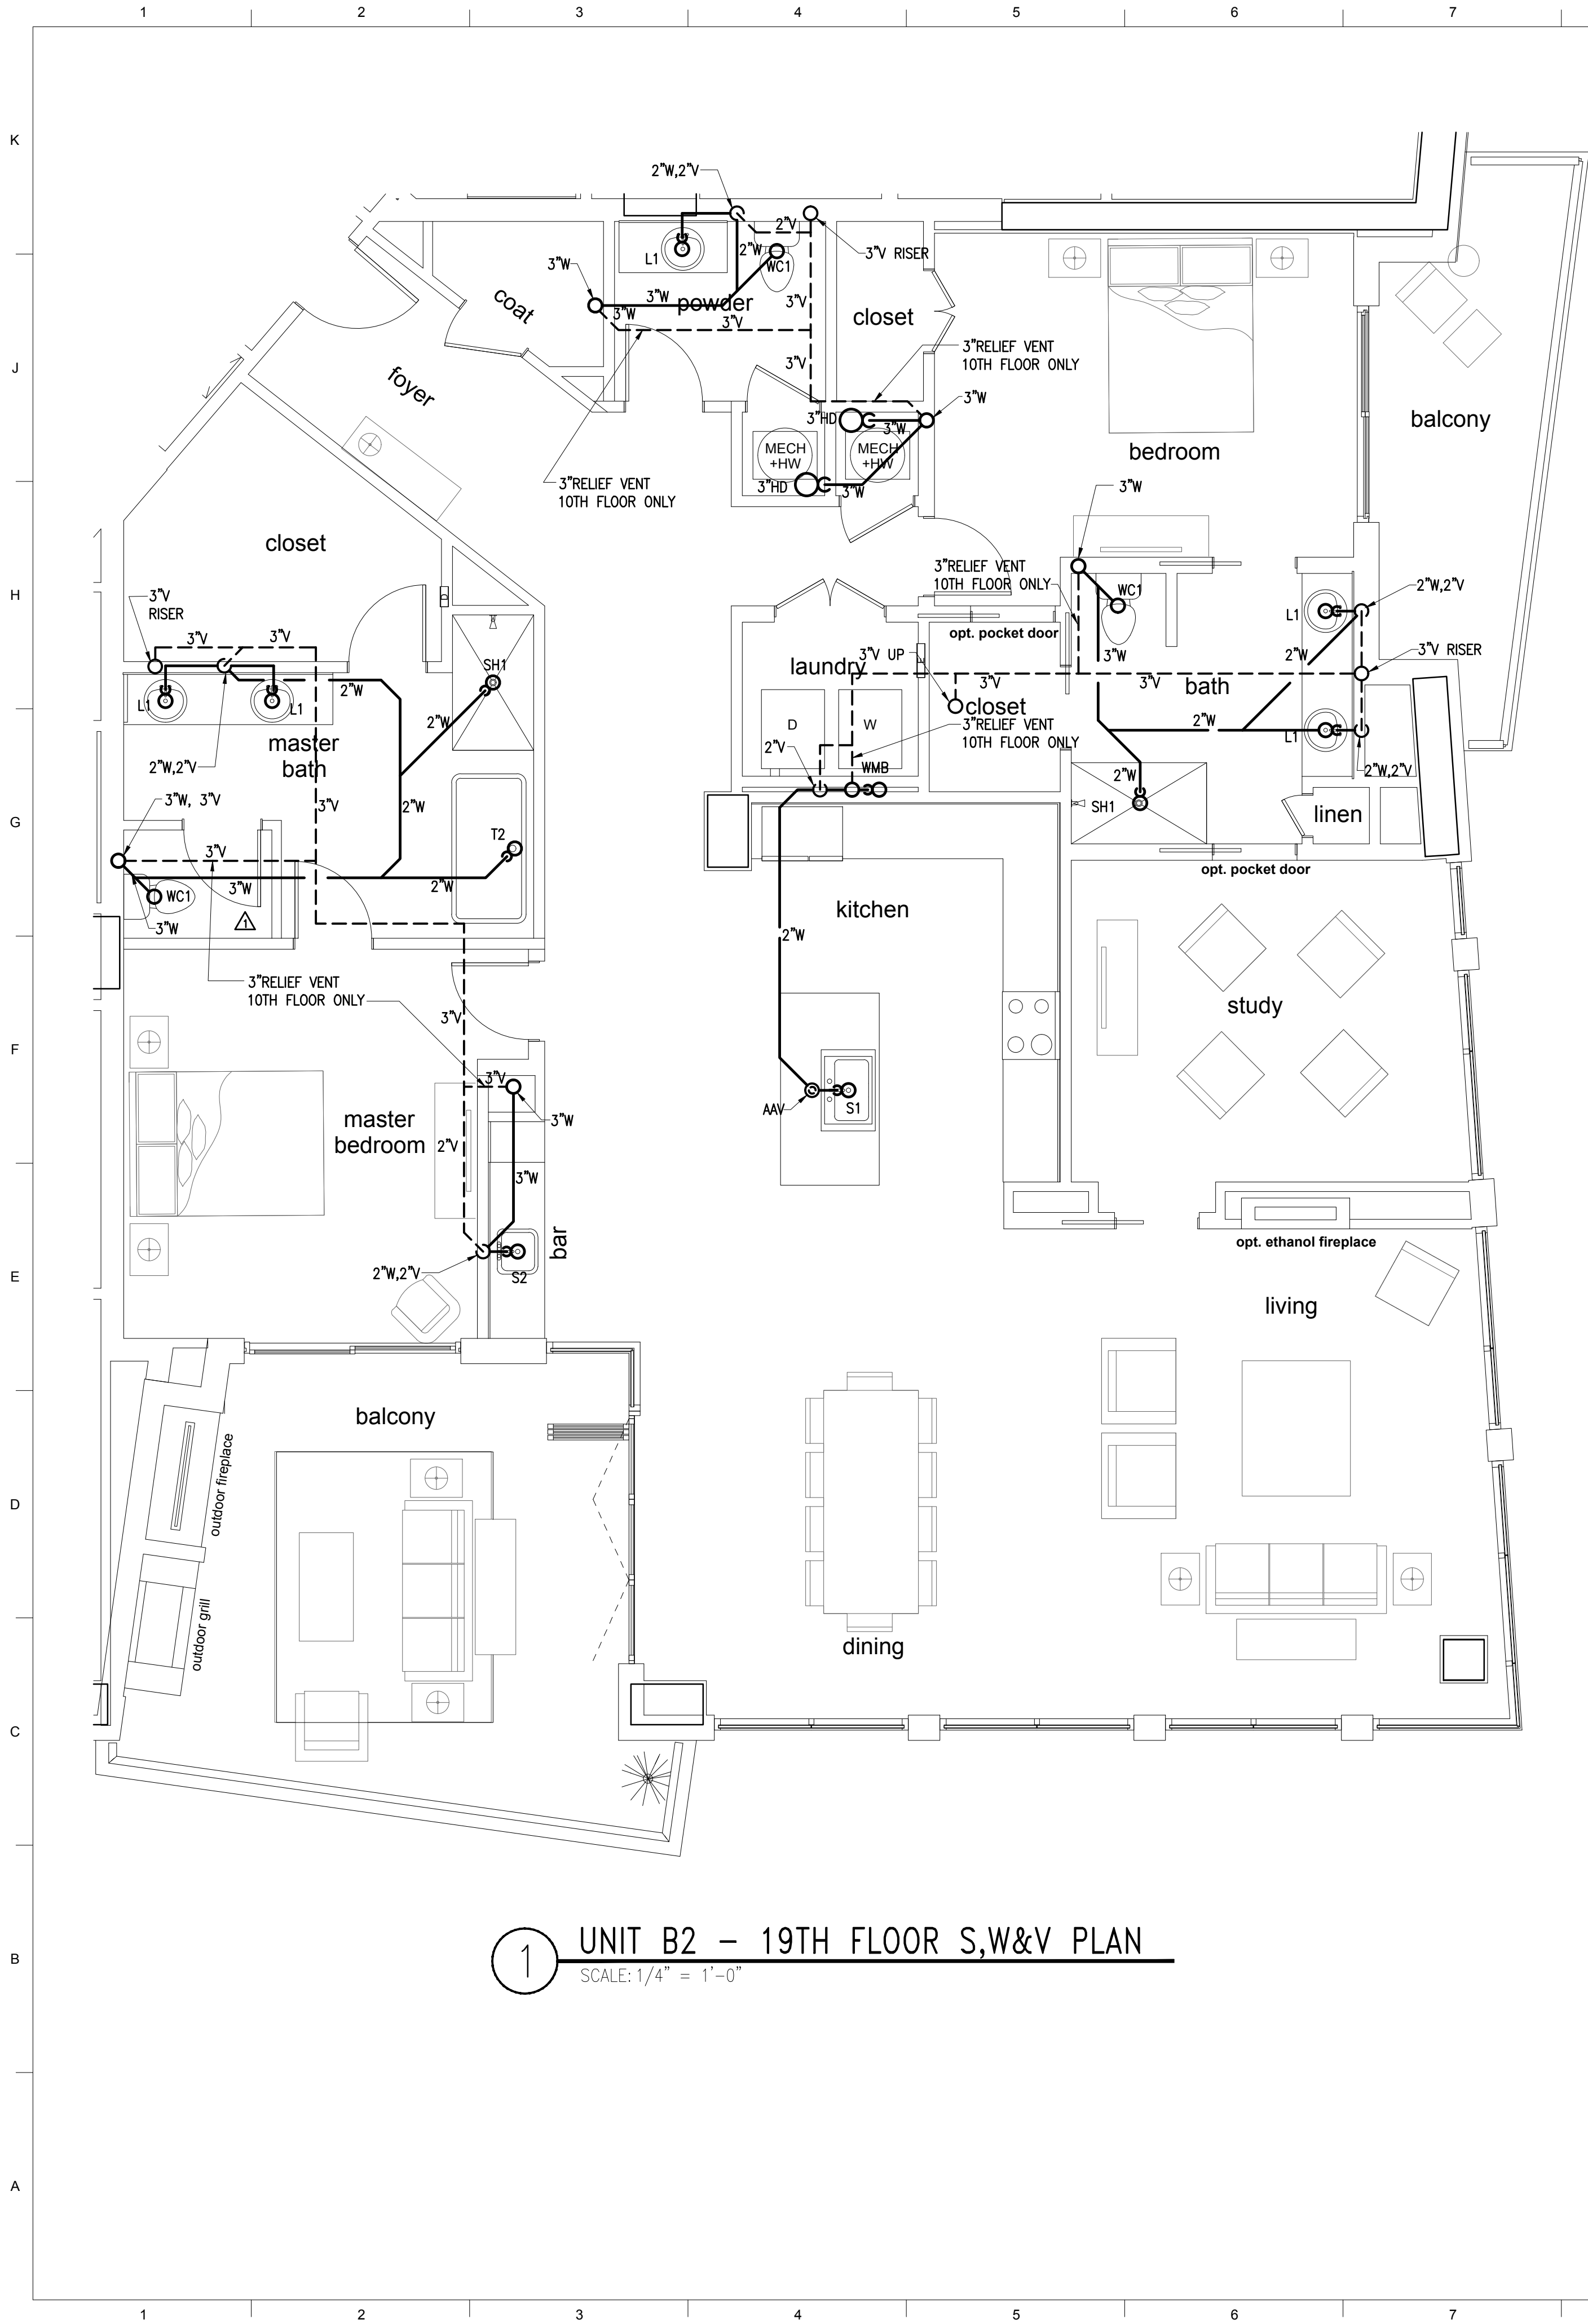

**LORD
AECK
SARGENT**

© 2015 Lord Aeck Sargent
LordAeckSargent.com
Unless otherwise agreed to in writing, this document is the sole property of Lord Aeck Sargent and is to be returned upon demand. The information herein is confidential and may not be used nor divulged without the written permission of Lord Aeck Sargent



REVISION:
#1 PERMIT REVISIONS 4/11/2017


**PHILLIPS GRADICK
ENGINEERING, P.C.**
500 Sugar Mill Rd.
Bldg. A Suite 105
Atlanta, Georgia 30305
(770) 335-5600 (F)
(770) 335-5601 (T)
The drawings on these plans were prepared by the undersigned, a duly Licensed Professional Engineer, P.E., and shall not be reproduced, published or used in any way without the permission of Phillips Gradick Engineering, P.C. This drawing is copyright and the property of Phillips Gradick Engineering, P.C. and shall not be reproduced, published or used in any way without the written permission of Phillips Gradick Engineering, P.C. is prohibited.

SHEET TITLE
UNIT PLANS
SCALE (UNITS)
1/4" = 1'-0"


JOB NAME
THE LOUDERMILK COMPANIES, LLC.
LOCATION
THE CHARLES CONDOMINIUMS
3107 PEACHTREE RD.
ATLANTA, GA 30305

ISSUE DATE
06/30/17
JOB NO.
10605-01
DWG. NO.
P3-05A

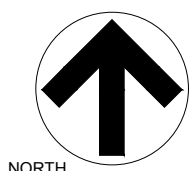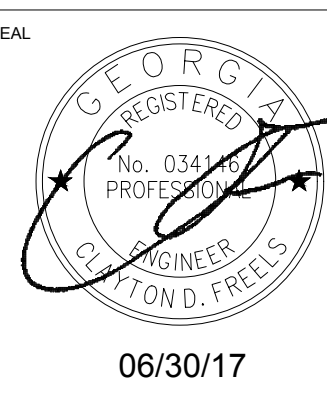

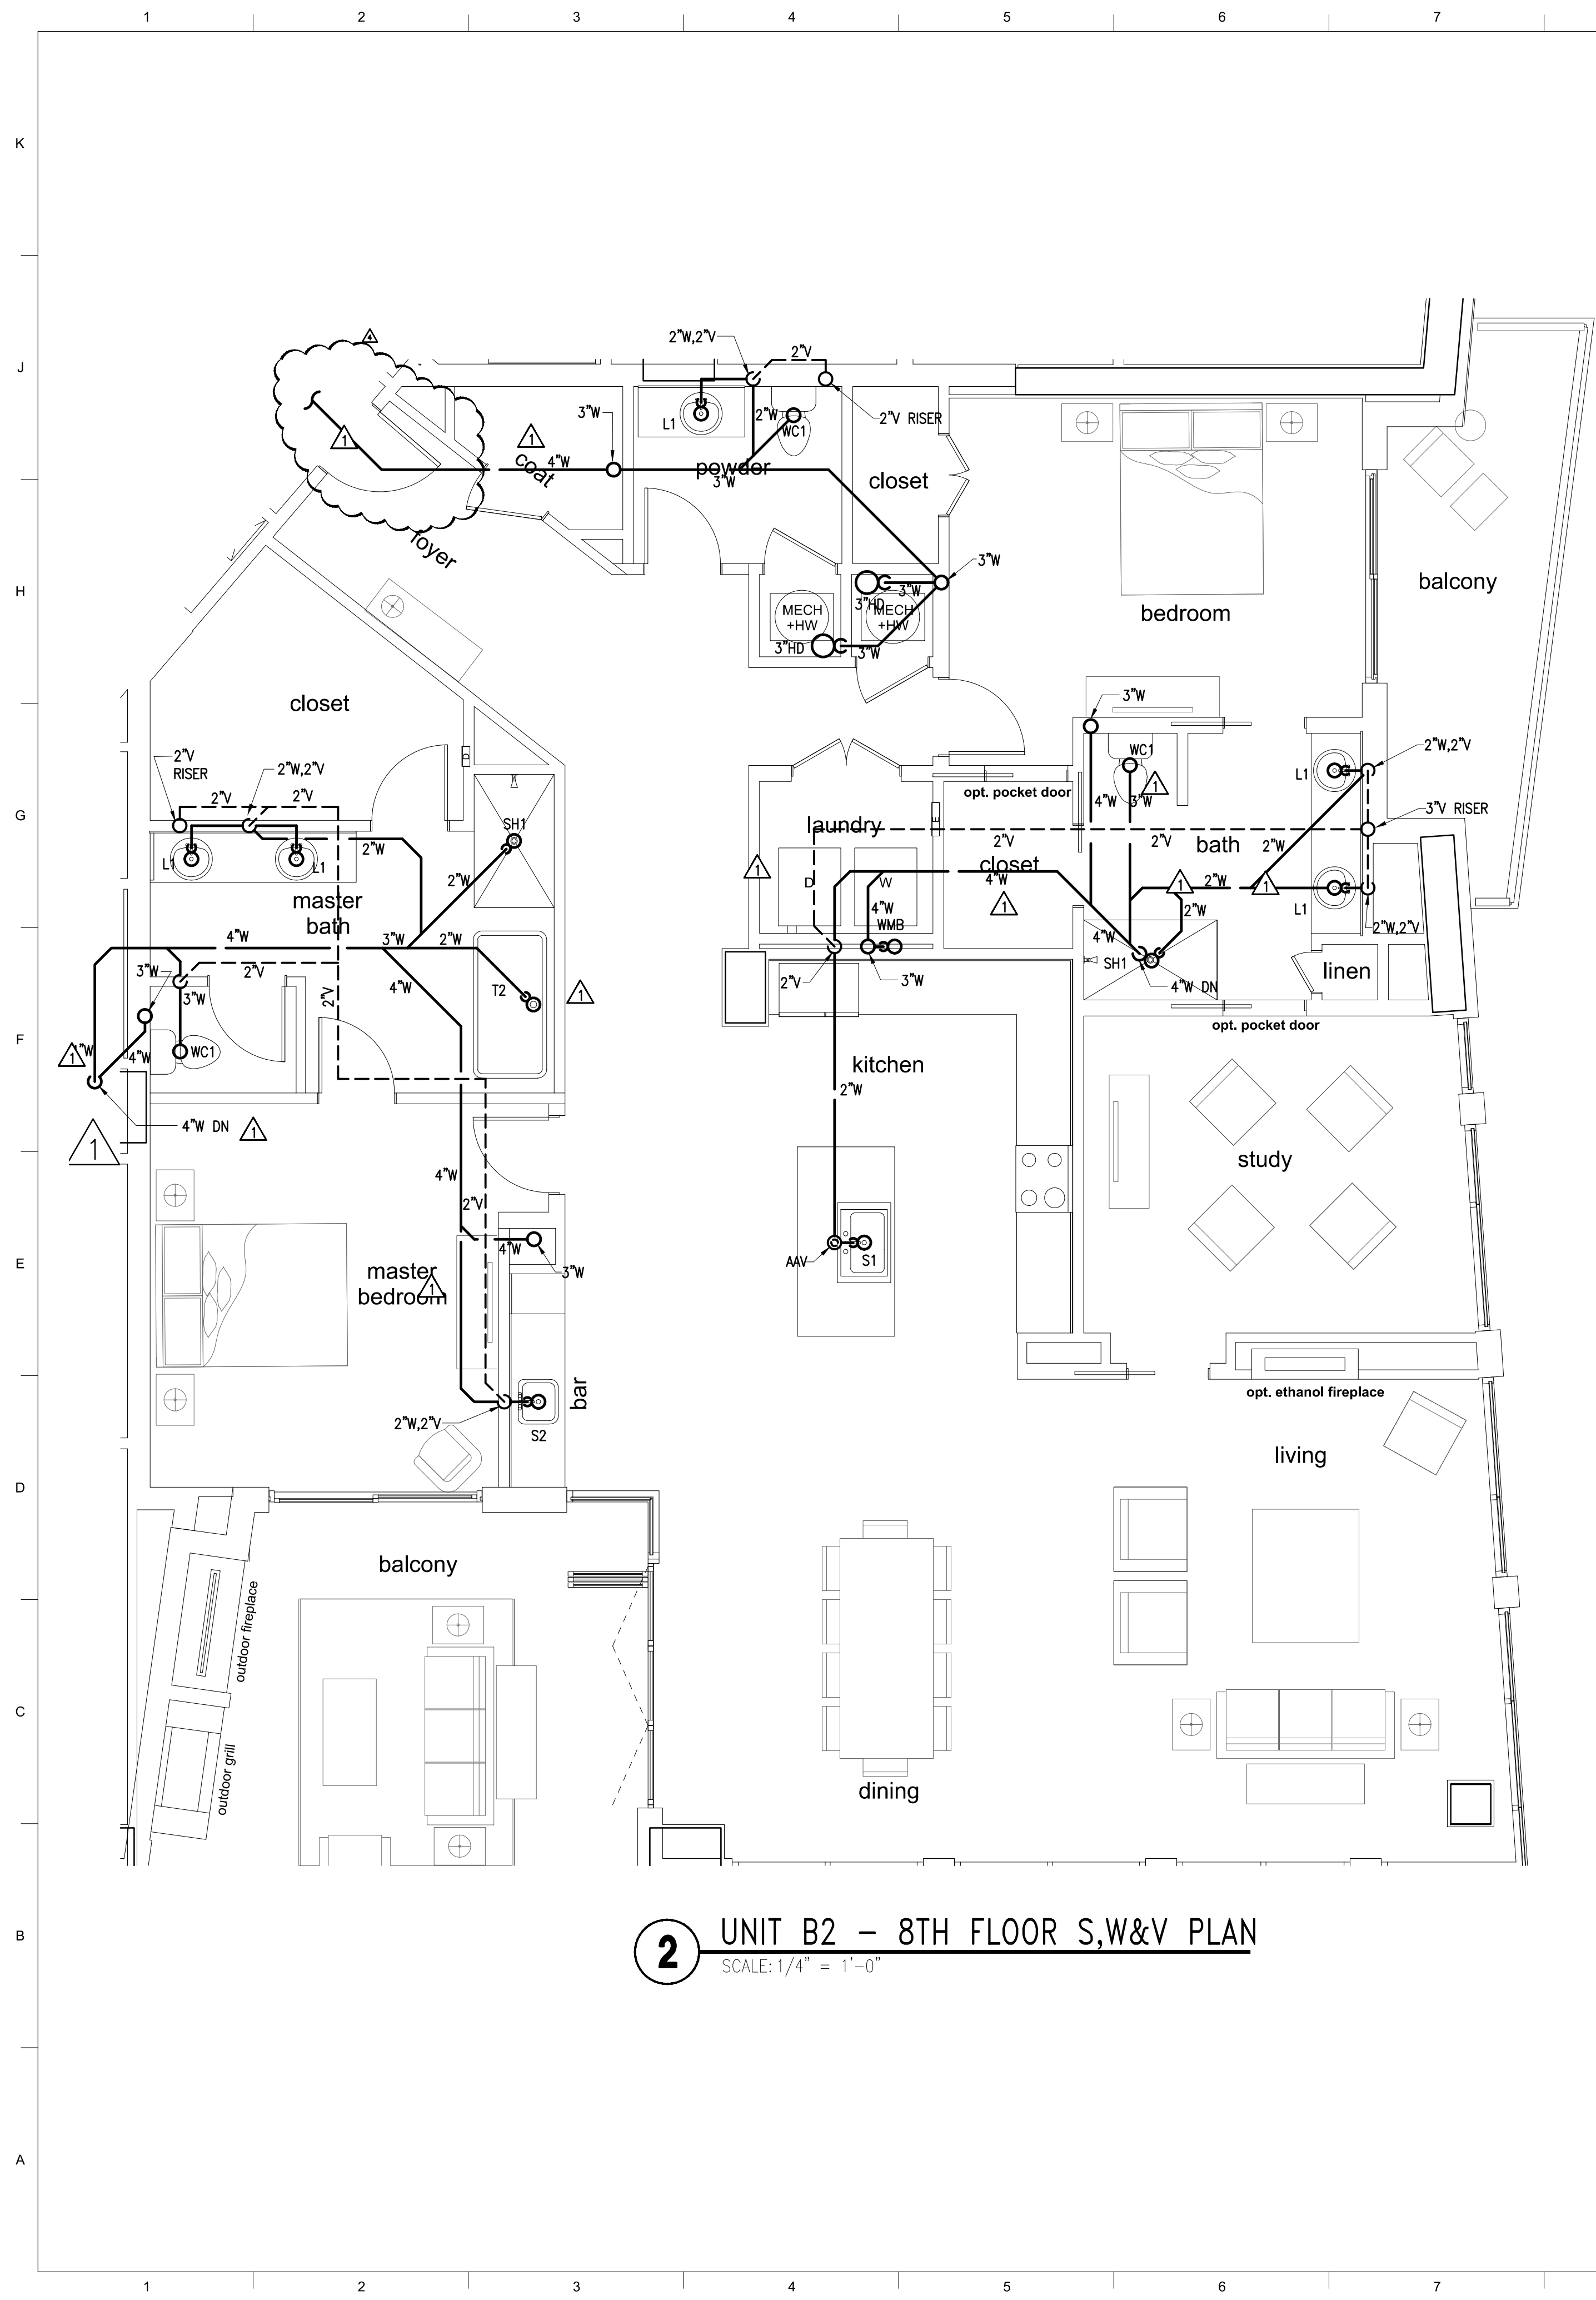

2 UNIT B2 - 8TH FLOOR S,W&V PLAN
SCALE: 1/4" = 1'-0"

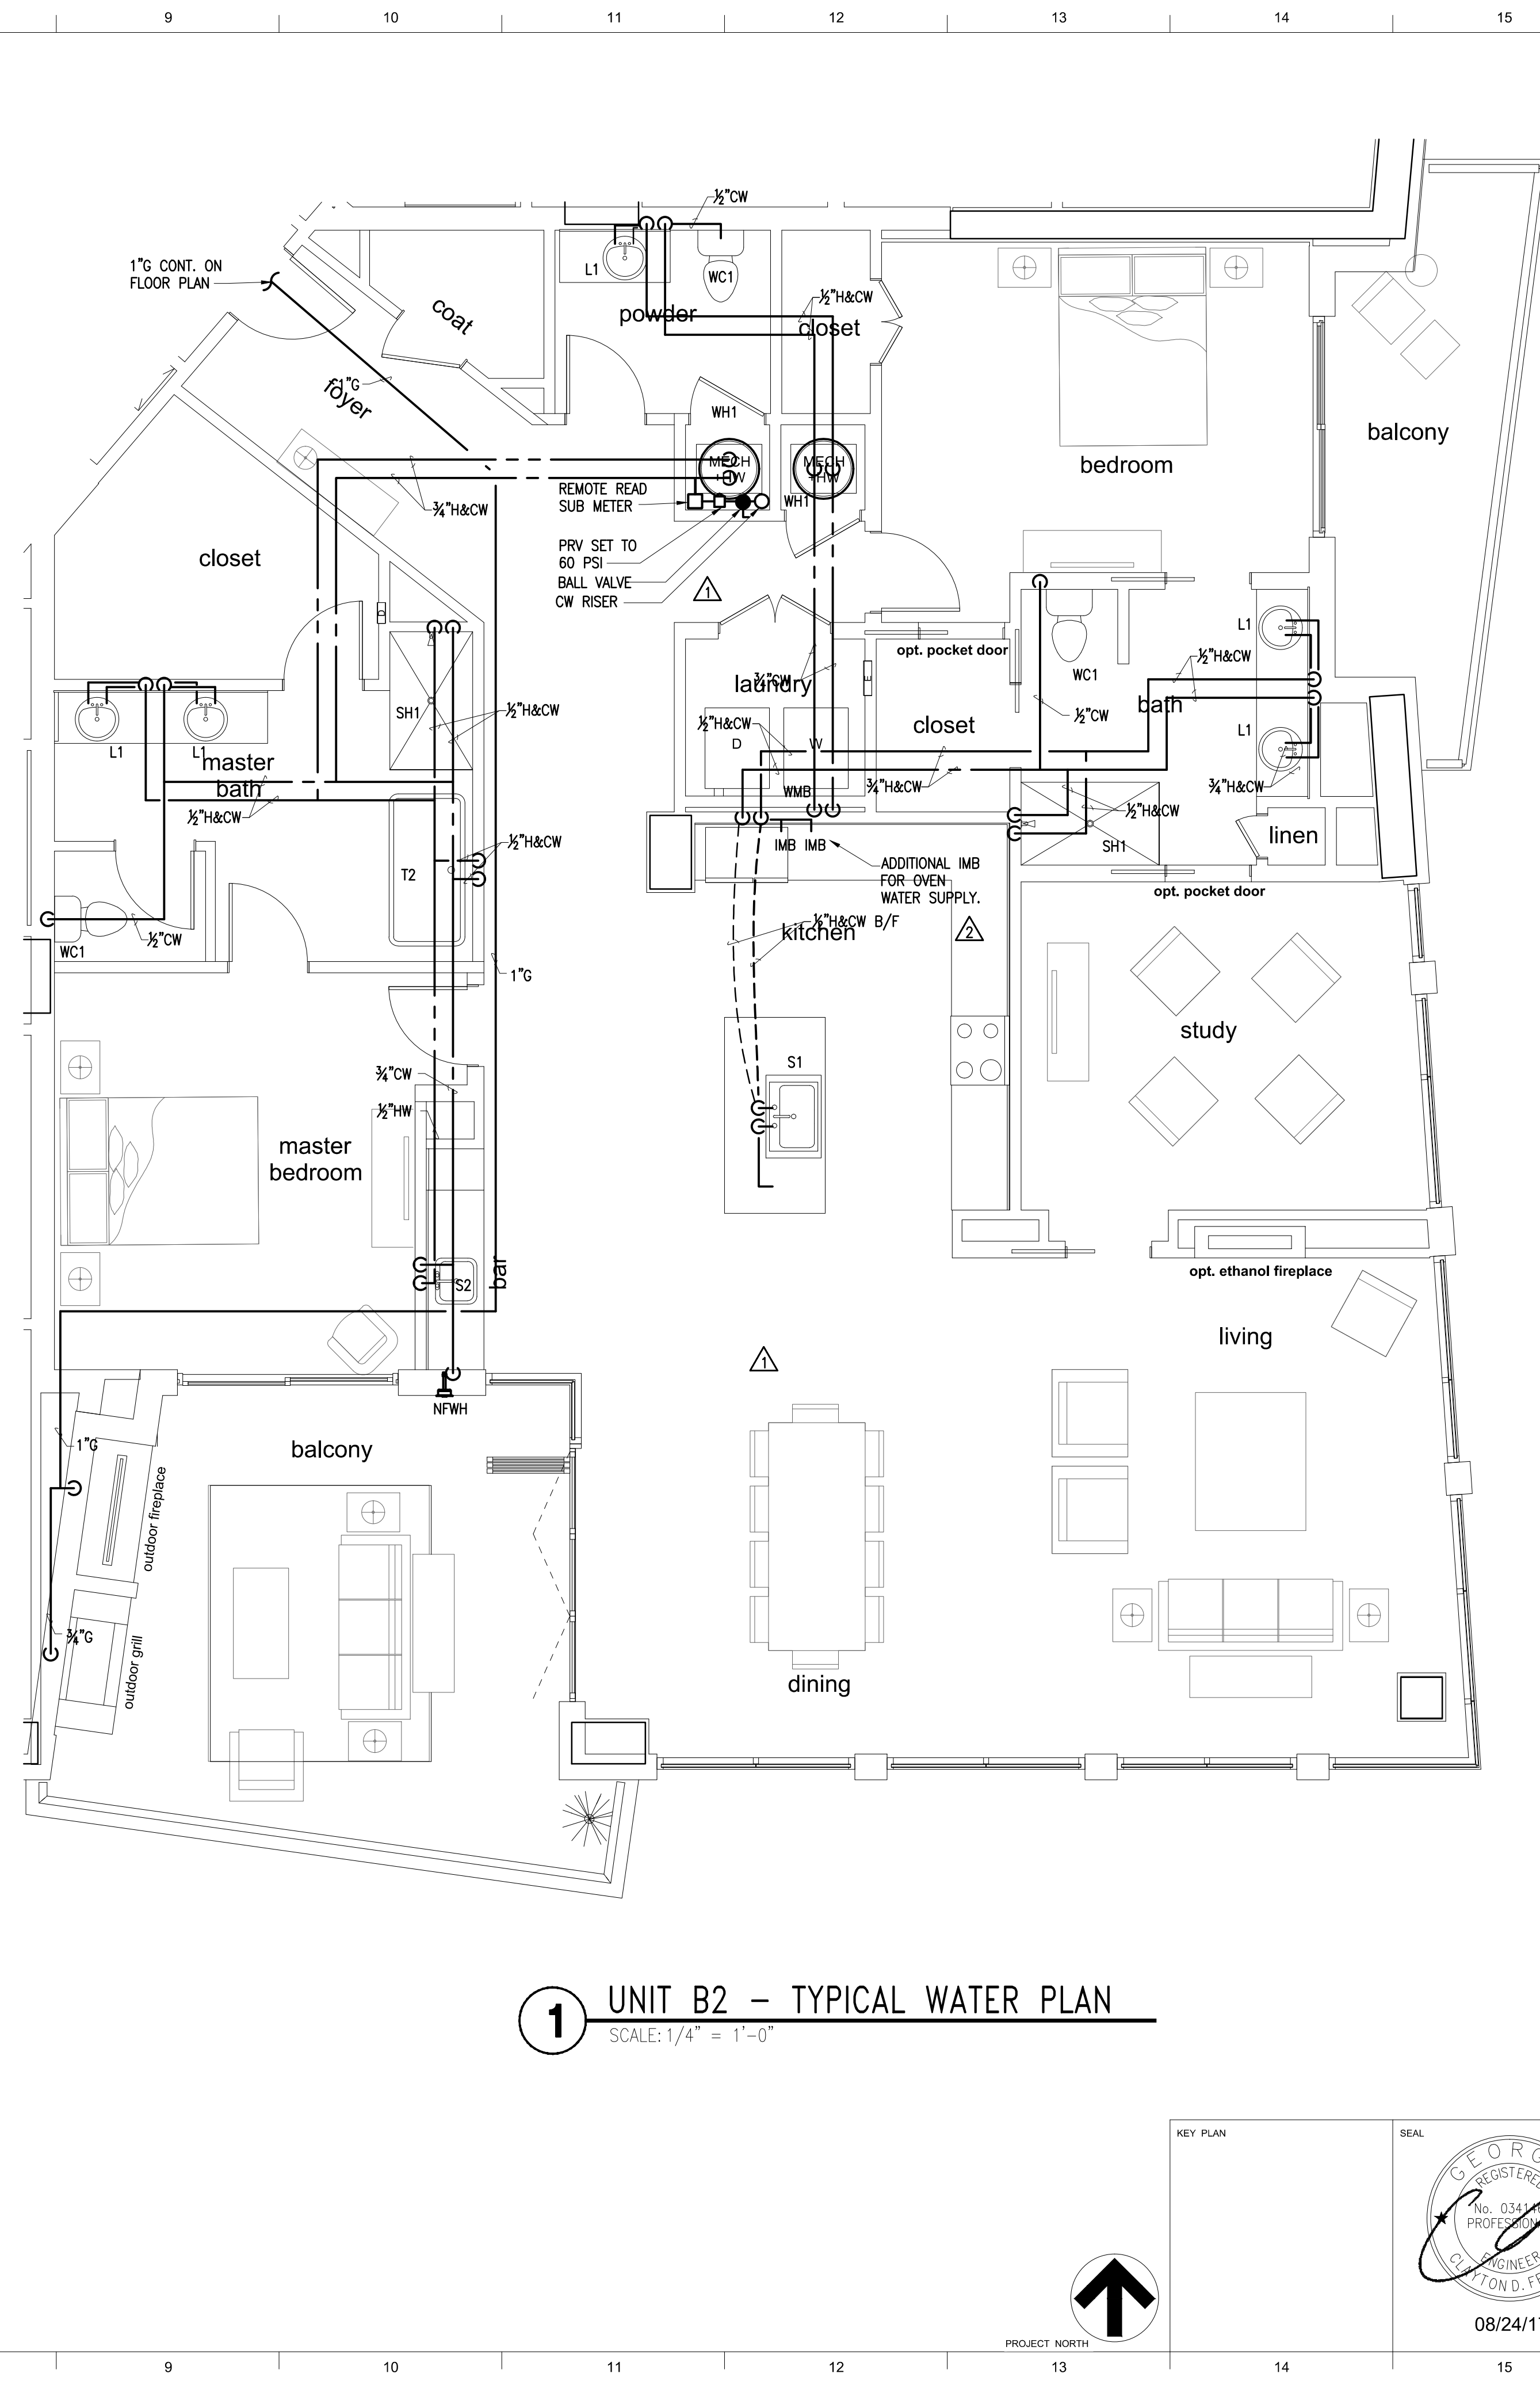

1 UNIT B2 - TYPICAL WATER PLAN
SCALE: 1/4" = 1'-0"

KEY PLAN

PROJECT NORTH

SEAL

THE LOUDERMILK COMPANIES, LLC.

THE CHARLES CONDOMINIUMS

3107 PEACHTREE RD.
ATLANTA, GA 30305

ISSUE DATE
06/30/17

JOB NO.
10605-01

DWG. NO.
P3-05B

08/24/17

LORD AECK SARGENT

© 2015 Lord Aeck Sargent
LordAeckSargent.com

Unless otherwise agreed to in writing, this document is the sole property of Lord Aeck Sargent and is to be returned upon demand. The information herein is confidential and may not be used nor divulged without the written permission of Lord Aeck Sargent.

REVISION:

PERMIT REVISIONS	4/1/2017
ADDENDUM #1	7/10/2017
42-008	8/24/2017

PHILLIPS GRADICK ENGINEERING, P.C.

500 Sugar Mill Rd.
Bldg. A Suite 105
Atlanta, GA 30305
(770) 455-5811 (T)
(770) 455-5812 (F)
phillips@gradick-engineering.com
www.gradick-engineering.com

This drawing is the property of Phillips Gradick Engineering, P.C. and shall not be reproduced, stored in a retrieval system, or transmitted in any form or by any means, electronic, mechanical, photocopying, recording, or by any information storage and retrieval system, without the prior written permission of Phillips Gradick Engineering, P.C. Its use is prohibited.

SHEET TITLE
UNIT PLANS

SCALE (UNITS)
1/4" = 1'-0"

ISSUED FOR CONSTRUCTION



2 UNIT B3 – 19TH FLOOR S,W&V PLAN
SCALE: 3/16" = 1'-0"

1 UNIT B3 – TYPICAL S,W&V PLAN
SCALE: 3/16" = 1'-0"

LORD AECK SARGENT

© 2015 Lord Aeck Sargent
LordAeckSargent.com

Unless otherwise agreed to in writing, this document is the sole property of Lord Aeck Sargent and is to be returned upon demand. The information herein is confidential and may not be used nor divulged without the written permission of Lord Aeck Sargent.

REVISION:	
PERMIT REVISIONS	4/1/2017
PC	6/29/2017
45-205	8/24/2017

PHILLIPS GRADICK
ENGINEERING, P.C.

PHILLIPS GRADICK ENGINEERING, P.C.
500 Sugar Mill Rd.
Raleigh, NC 27605
(770) 655-5811 (T)
(770) 655-5812 (F)
www.phillipsgradick.com

This drawing is the property of Phillips Gradick Engineering, P.C. and shall not be reproduced, stored in a retrieval system, or transmitted in any form or by any means, electronic, mechanical, photocopying, recording, or by any information storage and retrieval system, without the prior written permission of Phillips Gradick Engineering, P.C. Any unauthorized use of this drawing without the express written permission of Phillips Gradick Engineering, P.C. is prohibited.

SHEET TITLE
UNIT PLANS

SCALE (U.N.C.)
3/16" = 1'-0"

JOB NAME
THE LOUDERMILK COMPANIES, LLC.

JOB NO.
10605-01

DWG. NO.
P3-06A

ISSUE DATE
06/30/17

LOCATION
THE CHARLES CONDOMINIUMS
3107 PEACHTREE RD.
ATLANTA, GA 30305



ISSUED FOR CONSTRUCTION



**LORD
AECK
SARGENT**

© 2015 Lord Aeck Sargent
LordAeckSargent.com

Unless otherwise agreed to in writing, this document is the sole property of Lord Aeck Sargent and is to be returned upon demand. The information herein is confidential and may not be used nor divulged without the written permission of Lord Aeck Sargent.

REVISION:	
PERMIT REVISIONS	4/1/2017
PC	6/20/2017
REVISION #1	7/10/2017
AS-006	8/24/2017

PHILLIPS GRADICK
ENGINEERING, P.C.
500 Sugar Mill Rd.
Bldg. A Suite 105
Atlanta, GA 30305
(770) 455-5811 (T)
(770) 455-5812 (F)
P.E. # 210633



This drawing, as well as all other documents created and issued by us, are the property of Phillips Gradick Engineering, P.C. and shall not be reproduced, published or used in any way without the permission of Phillips Gradick Engineering, P.C. This drawing is completed and issued by us under the professional seal and signature of a duly licensed Professional Engineer in the State of Georgia. Any use of this drawing without the express written permission of Phillips Gradick Engineering, P.C. is prohibited.

SHEET TITLE
UNIT PLANS

SCALE (UNITS)
3/16" = 1'-0"

JOB NAME
THE LOUDERMILK COMPANIES, LLC.

ISSUE DATE
06/30/17


JOB NO.
10605-01

DWG. NO.
P3-06B

LOCATION
**THE CHARLES CONDOMINIUMS
3107 PEACHTREE RD.
ATLANTA, GA 30305**

ISSUED FOR CONSTRUCTION

KEY PLAN

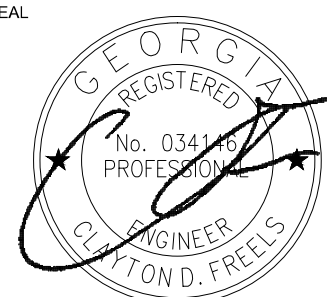SEAL


08/24/17



1 PENTHOUSE 1-TYPICAL S,W&V PLAN
SCALE: 3/16" = 1'-0"

**LORD
AECK
SARGENT**

© 2015 Lord Aeck Sargent
LordAeckSargent.com
Unless otherwise agreed to in writing, this document is the sole property of Lord Aeck Sargent and is to be returned upon demand. The information herein is confidential and may not be used nor divulged without the written permission of Lord Aeck Sargent

REVISION:




**PHILLIPS GRADICK
ENGINEERING, P.C.**
500 Sugar Mill Rd.
Bldg. A Suite 105
Atlanta, Georgia 30350
(770) 244-2410
Fax: (770) 244-2411
www.phillipsgradiak.com

PG# # 210033


SHEET TITLE
PENTHOUSE 1
SCALE (UNITS)
3/16" = 1'-0"

JOB NAME
THE LOUDERMILK COMPANIES, LLC.
LOCATION
THE CHARLES CONDOMINIUMS
3107 PEACHTREE RD.
ATLANTA, GA 30305

ISSUE DATE
06/30/17
JOB NO.
10605-01
DWG. NO.

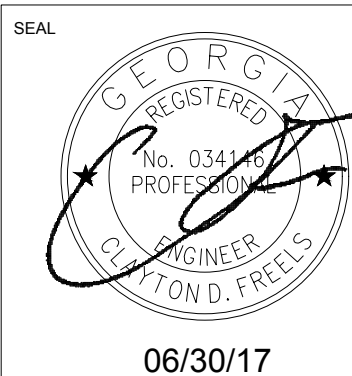

P3-07A

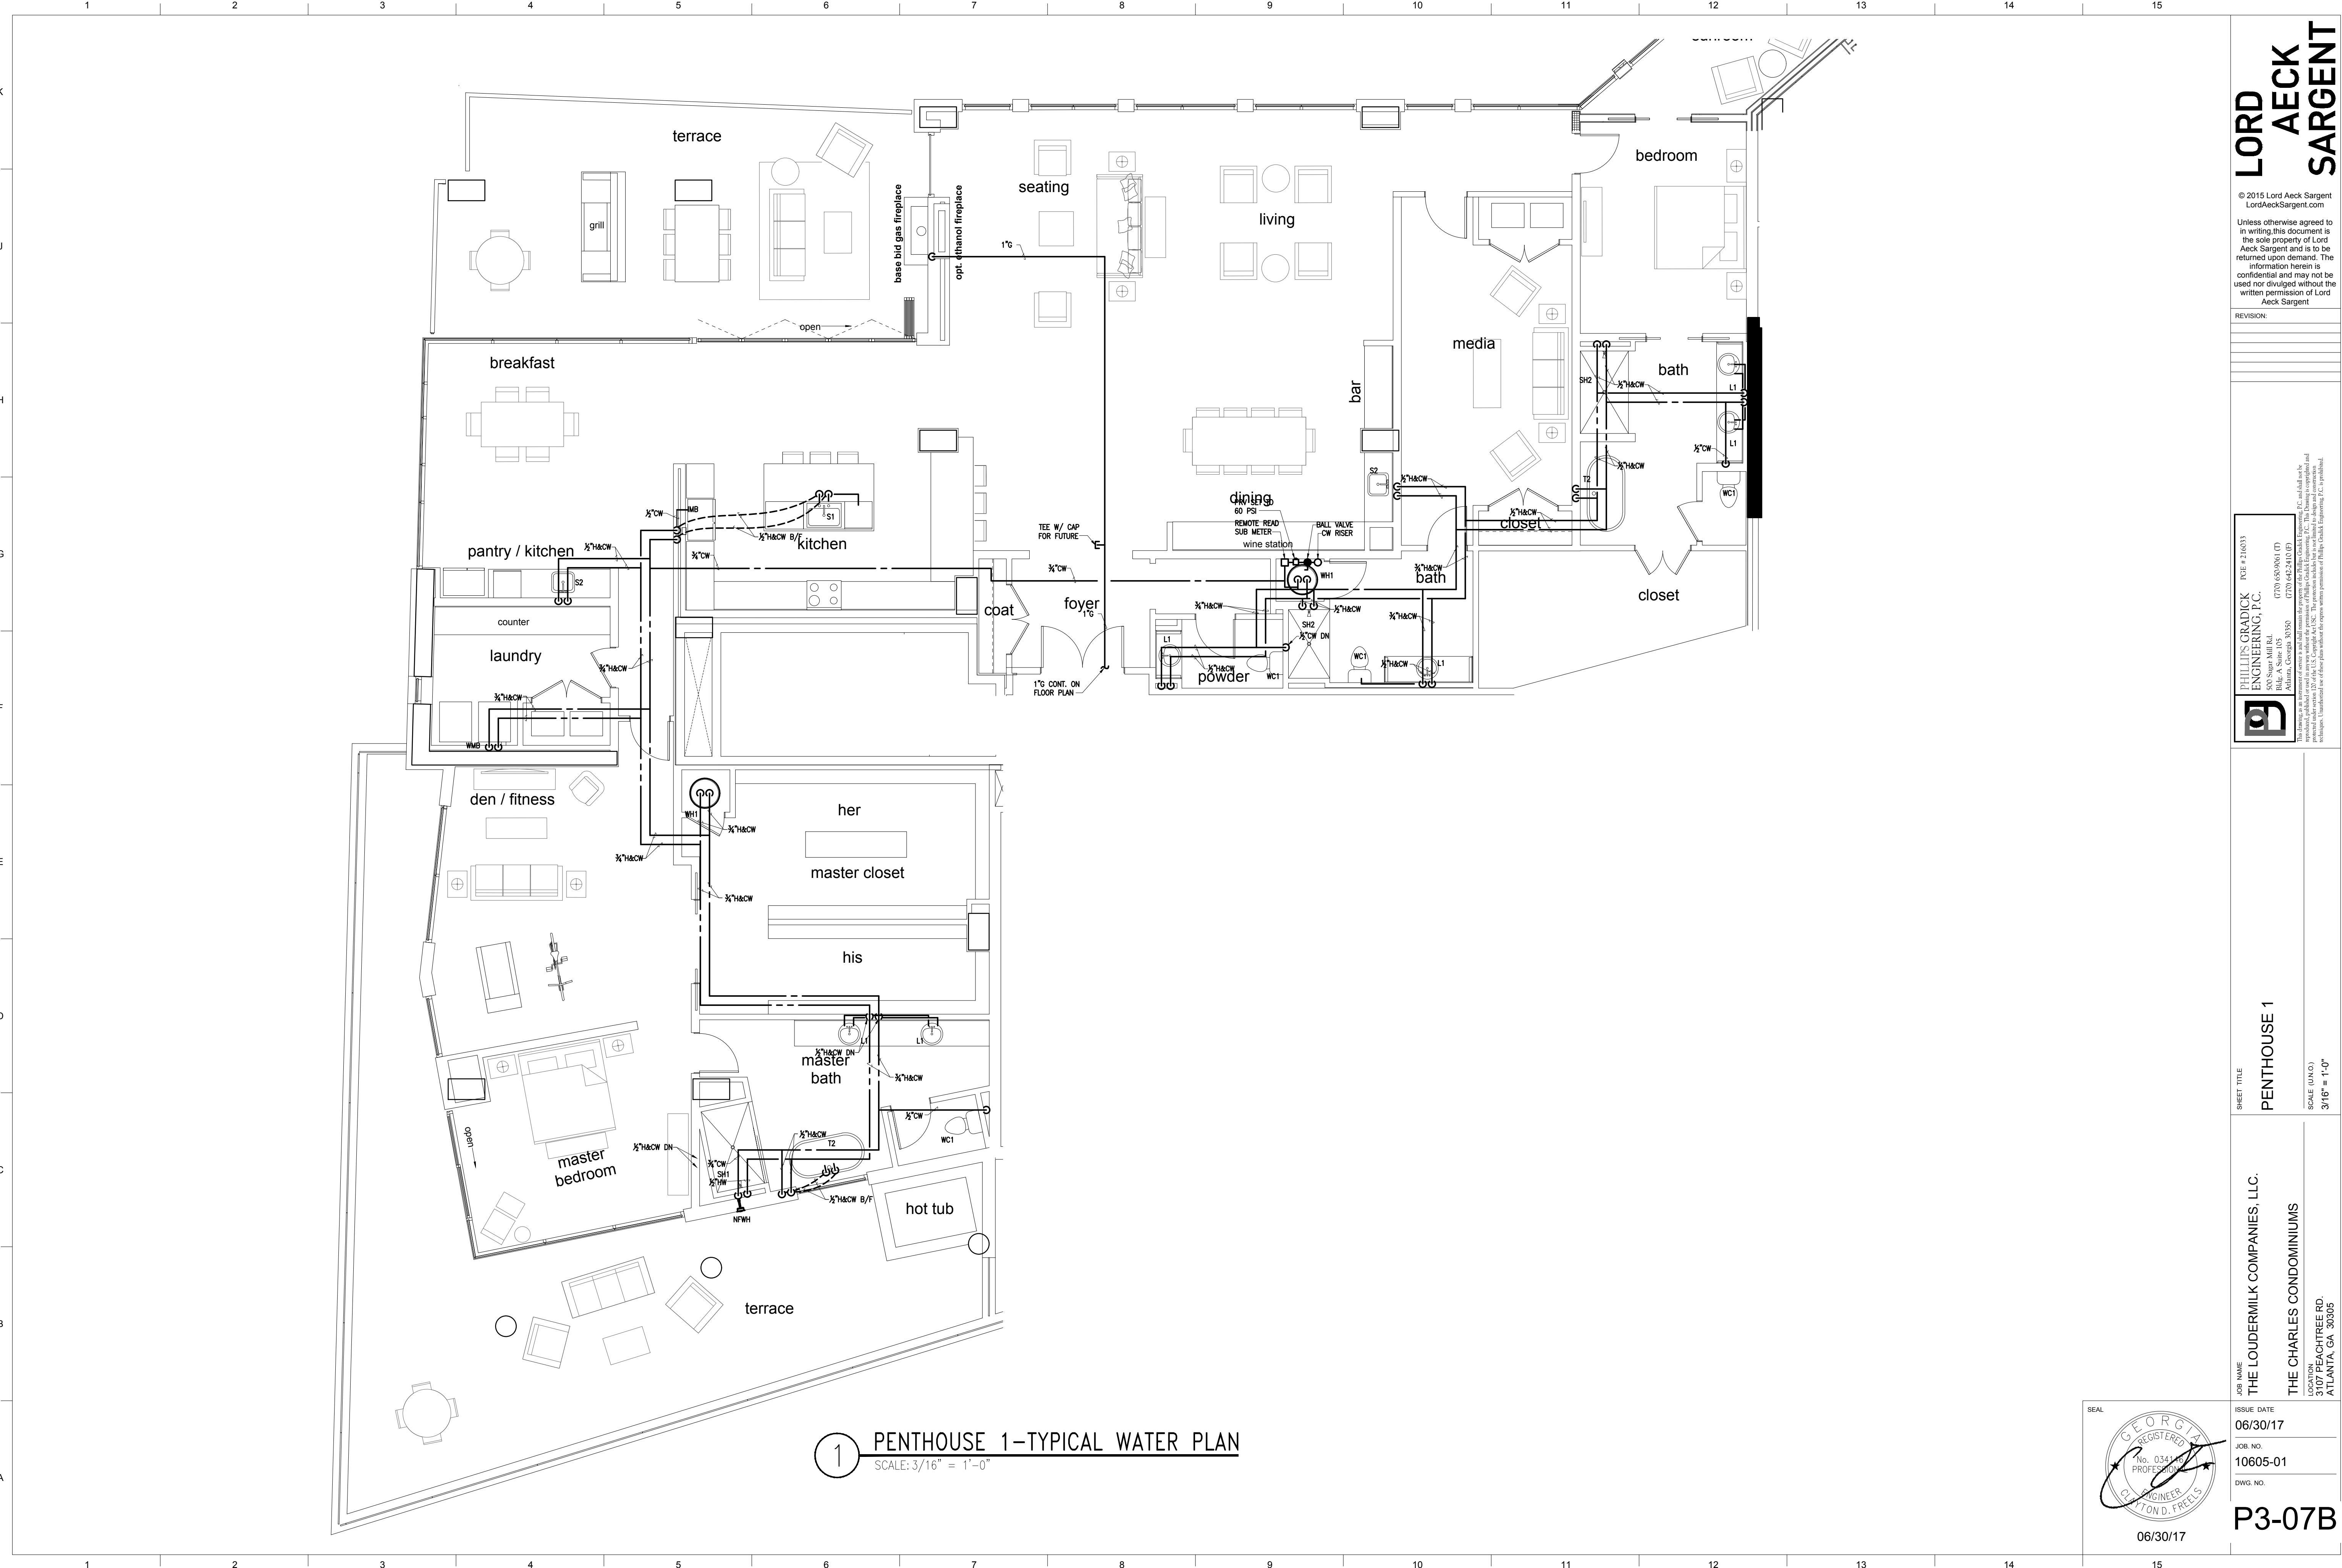

1 PENTHOUSE 1-TYPICAL WATER PLAN
SCALE: 3/16" = 1'-0"

LORD
AECK
SARGENT

© 2015 Lord Aeck Sargent
LordAeckSargent.com
Unless otherwise agreed to in writing, this document is the sole property of Lord Aeck Sargent and is to be returned upon demand. The information herein is confidential and may not be used nor divulged without the written permission of Lord Aeck Sargent.


REVISION:

PHILLIPS GRADICK
ENGINEERING, P.C.
500 Super Mill Rd.
Bldg. A Suite 105
Atlanta, Georgia 30305
(770) 442-2410
Fax: (770) 442-2411
www.phillipsgradick.com
P.E. and shall not be
reproduced, published or used in any way without the permission of Phillips Gradick Engineering, P.C. This drawing is complete and
inclosed. Unintentional use of these plans without the express written permission of Phillips Gradick Engineering, P.C. is prohibited.


SHEET TITLE
PENTHOUSE 1
SCALE (UNITS)
3/16" = 1'-0"

JOB NAME
THE LOUDERMILK COMPANIES, LLC.
THE CHARLES CONDOMINIUMS
LOCATION
3107 PEACHTREE RD.
ATLANTA, GA 30305


ISSUE DATE
06/30/17
JOB NO.
10605-01
DWG. NO.

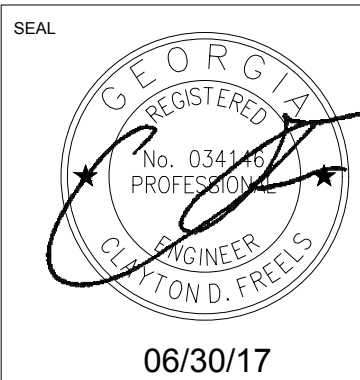

P3-07B

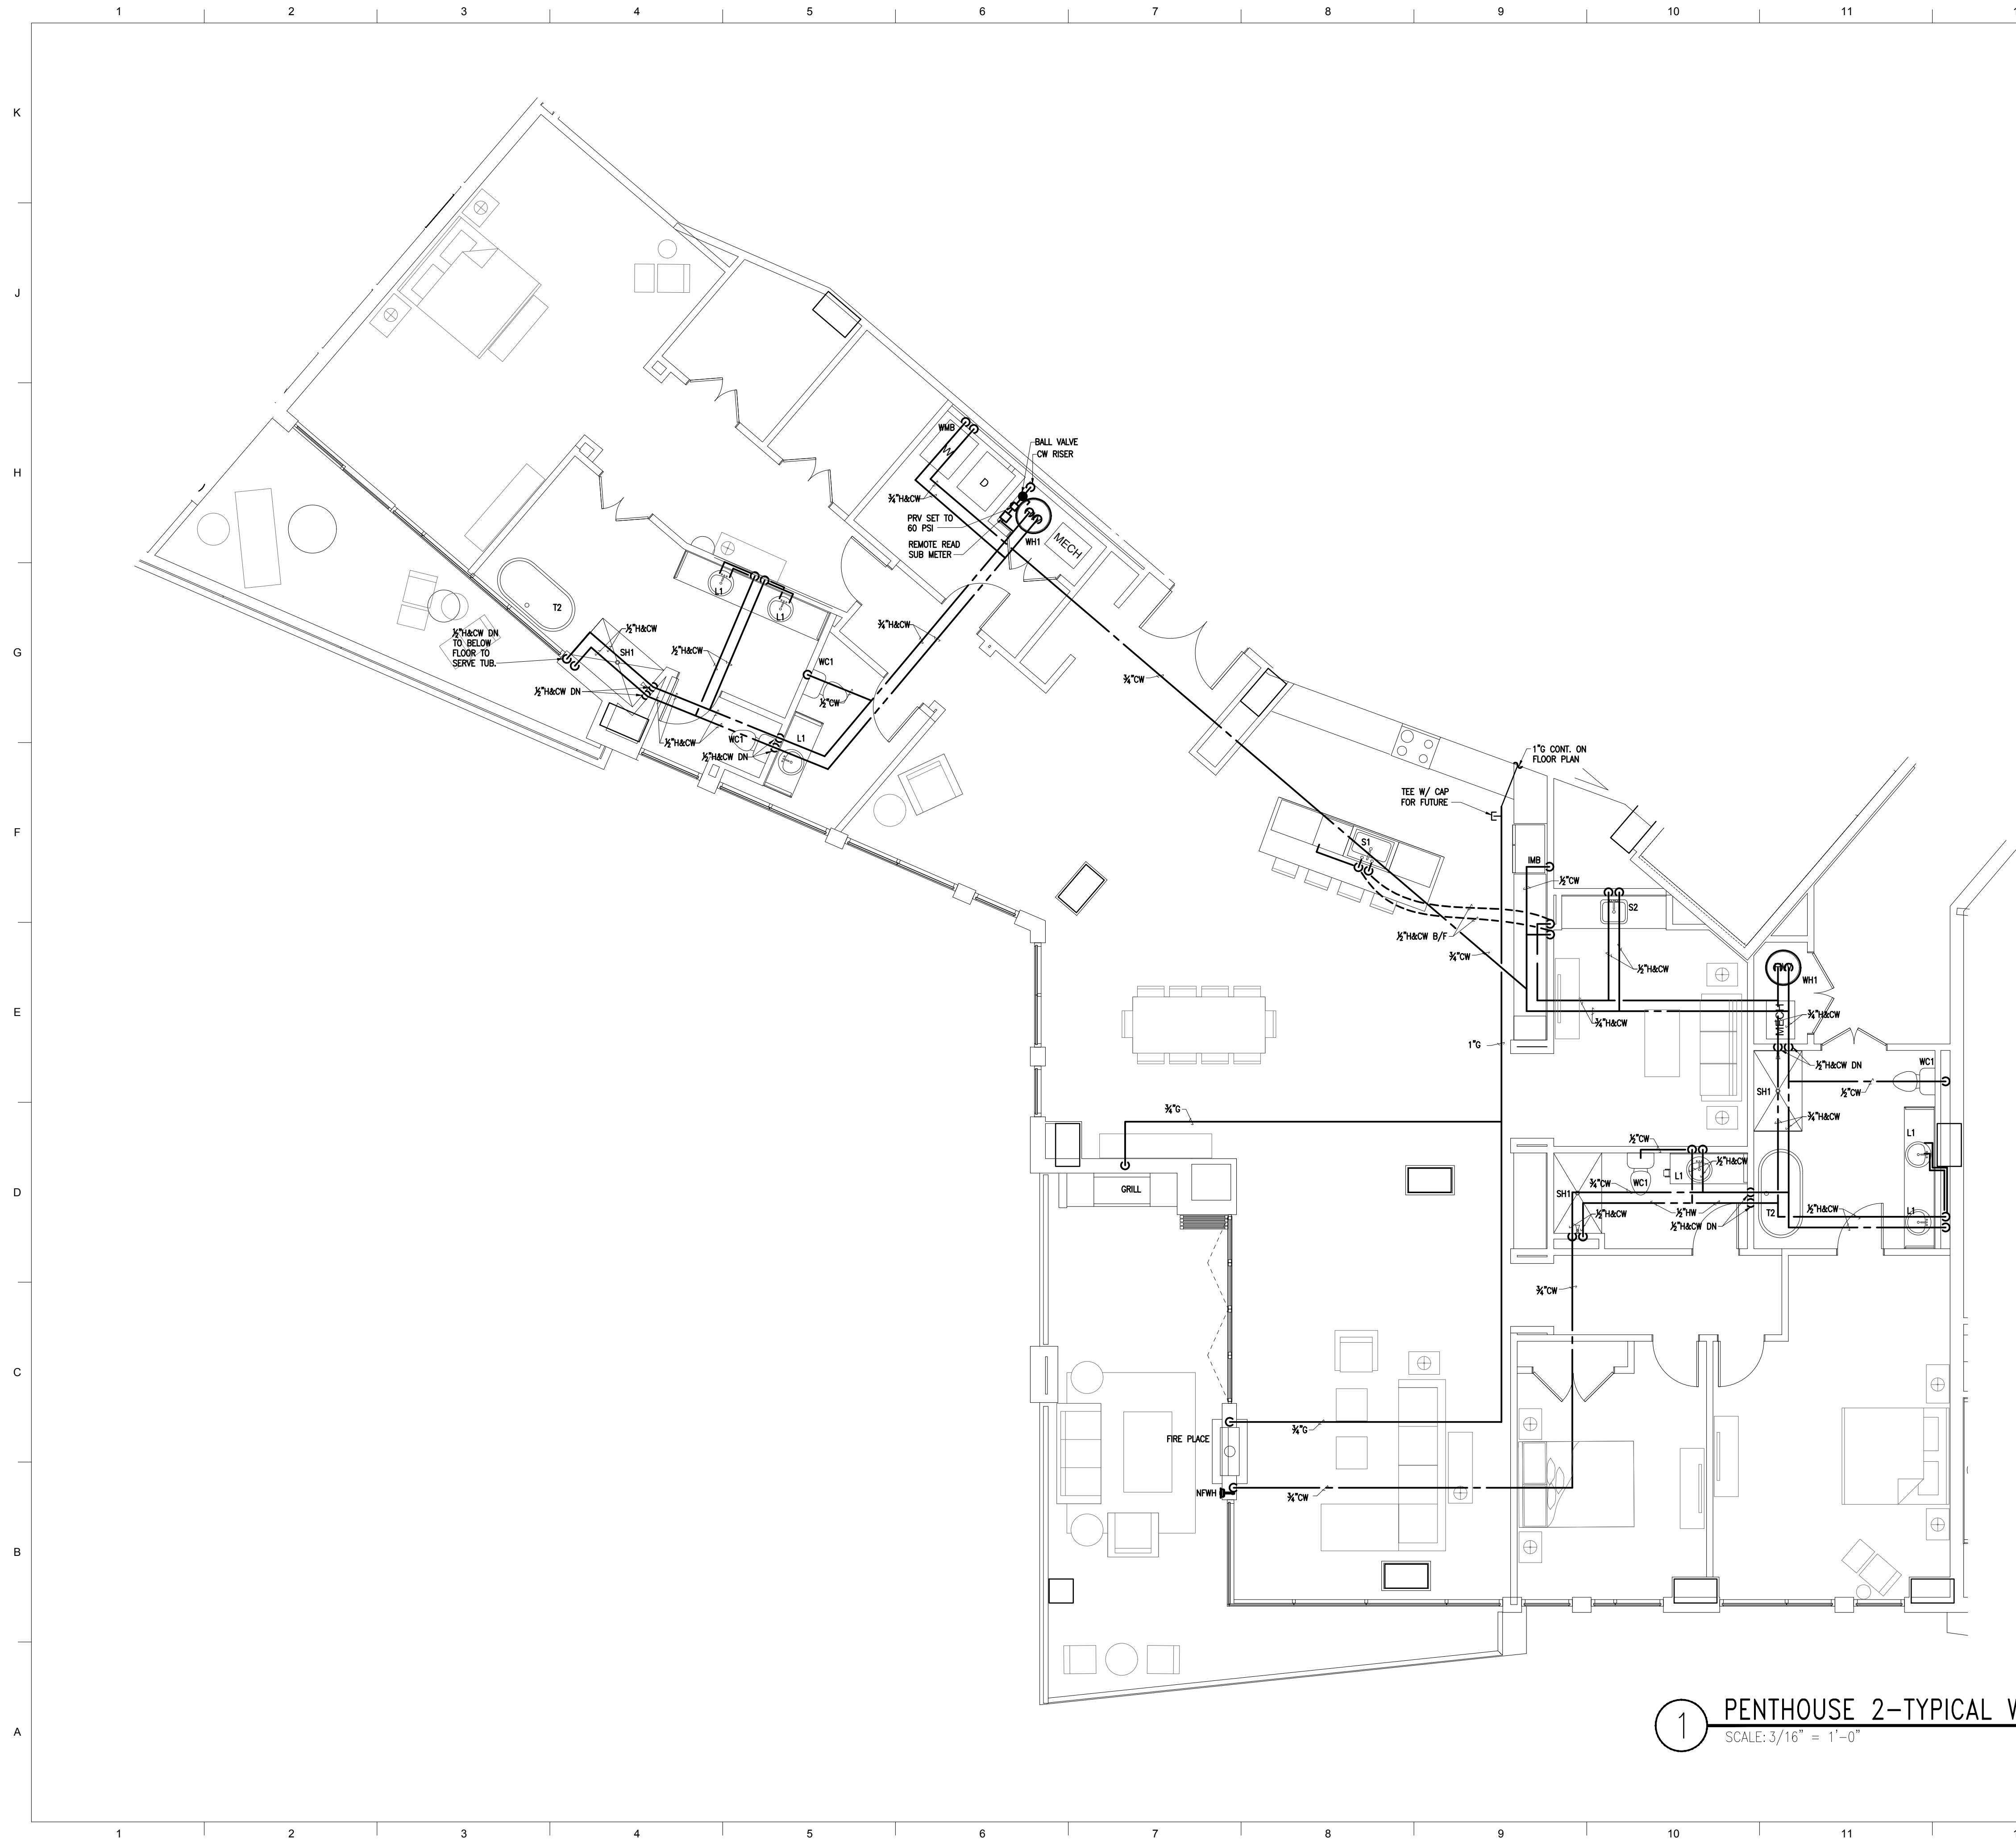

1 PENTHOUSE 2-TYPICAL WATER PLAN
SCALE: 3/16" = 1'-0"

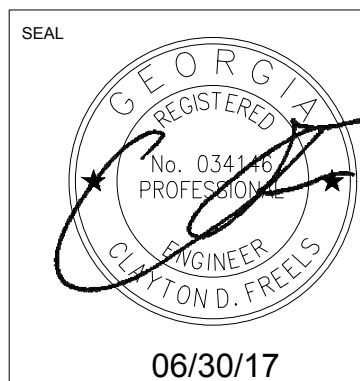

**LORD
AECK
SARGENT**

© 2015 Lord Aeck Sargent
LordAeckSargent.com

Unless otherwise agreed to in writing, this document is the sole property of Lord Aeck Sargent and is to be returned upon demand. The information herein is confidential and may not be used nor divulged without the written permission of Lord Aeck Sargent

REVISION:

--

will not be
copyrighted and
no
is prohibited.

engineering, P.C., and
P.C.. This Drawing is c
entitled to design and c
Black Engineering, P.C.

PGE # 216033
650-9061 (T)
642-2410 (F)

ADICK
NG, P.C.
(770)
350 (770)

PHILLIPS GRIFFIN ENGINEERING
Sugar Mill Rd.
Box A Suite 105
Atlanta, Georgia 30308

PH
EN
500
Bldg
Atlanta

This design is needed to protect technicians

--	--	--

--	--	--

--	--	--

[illegible]

32

HOUSE

SHEET TITLE
PENTITION
SCALE (U.N.O.)
3/16" = 1'

S
S, LLC.

COMPANIES	MINIMUM
-----------	---------

MILK CONDENSED
CONDENSED
RD.
5

DOUDERM
CHARLES
BACHTREE F
A, GA 30300

JOB NAME	THE LO	THE CI	LOCATION	3107 PEA ATLANTA
----------	--------	--------	----------	---------------------

ISSUE DATE
06/30/17


JOB. NO.

10605-01

DWG. NO.

P3-08B

--	--

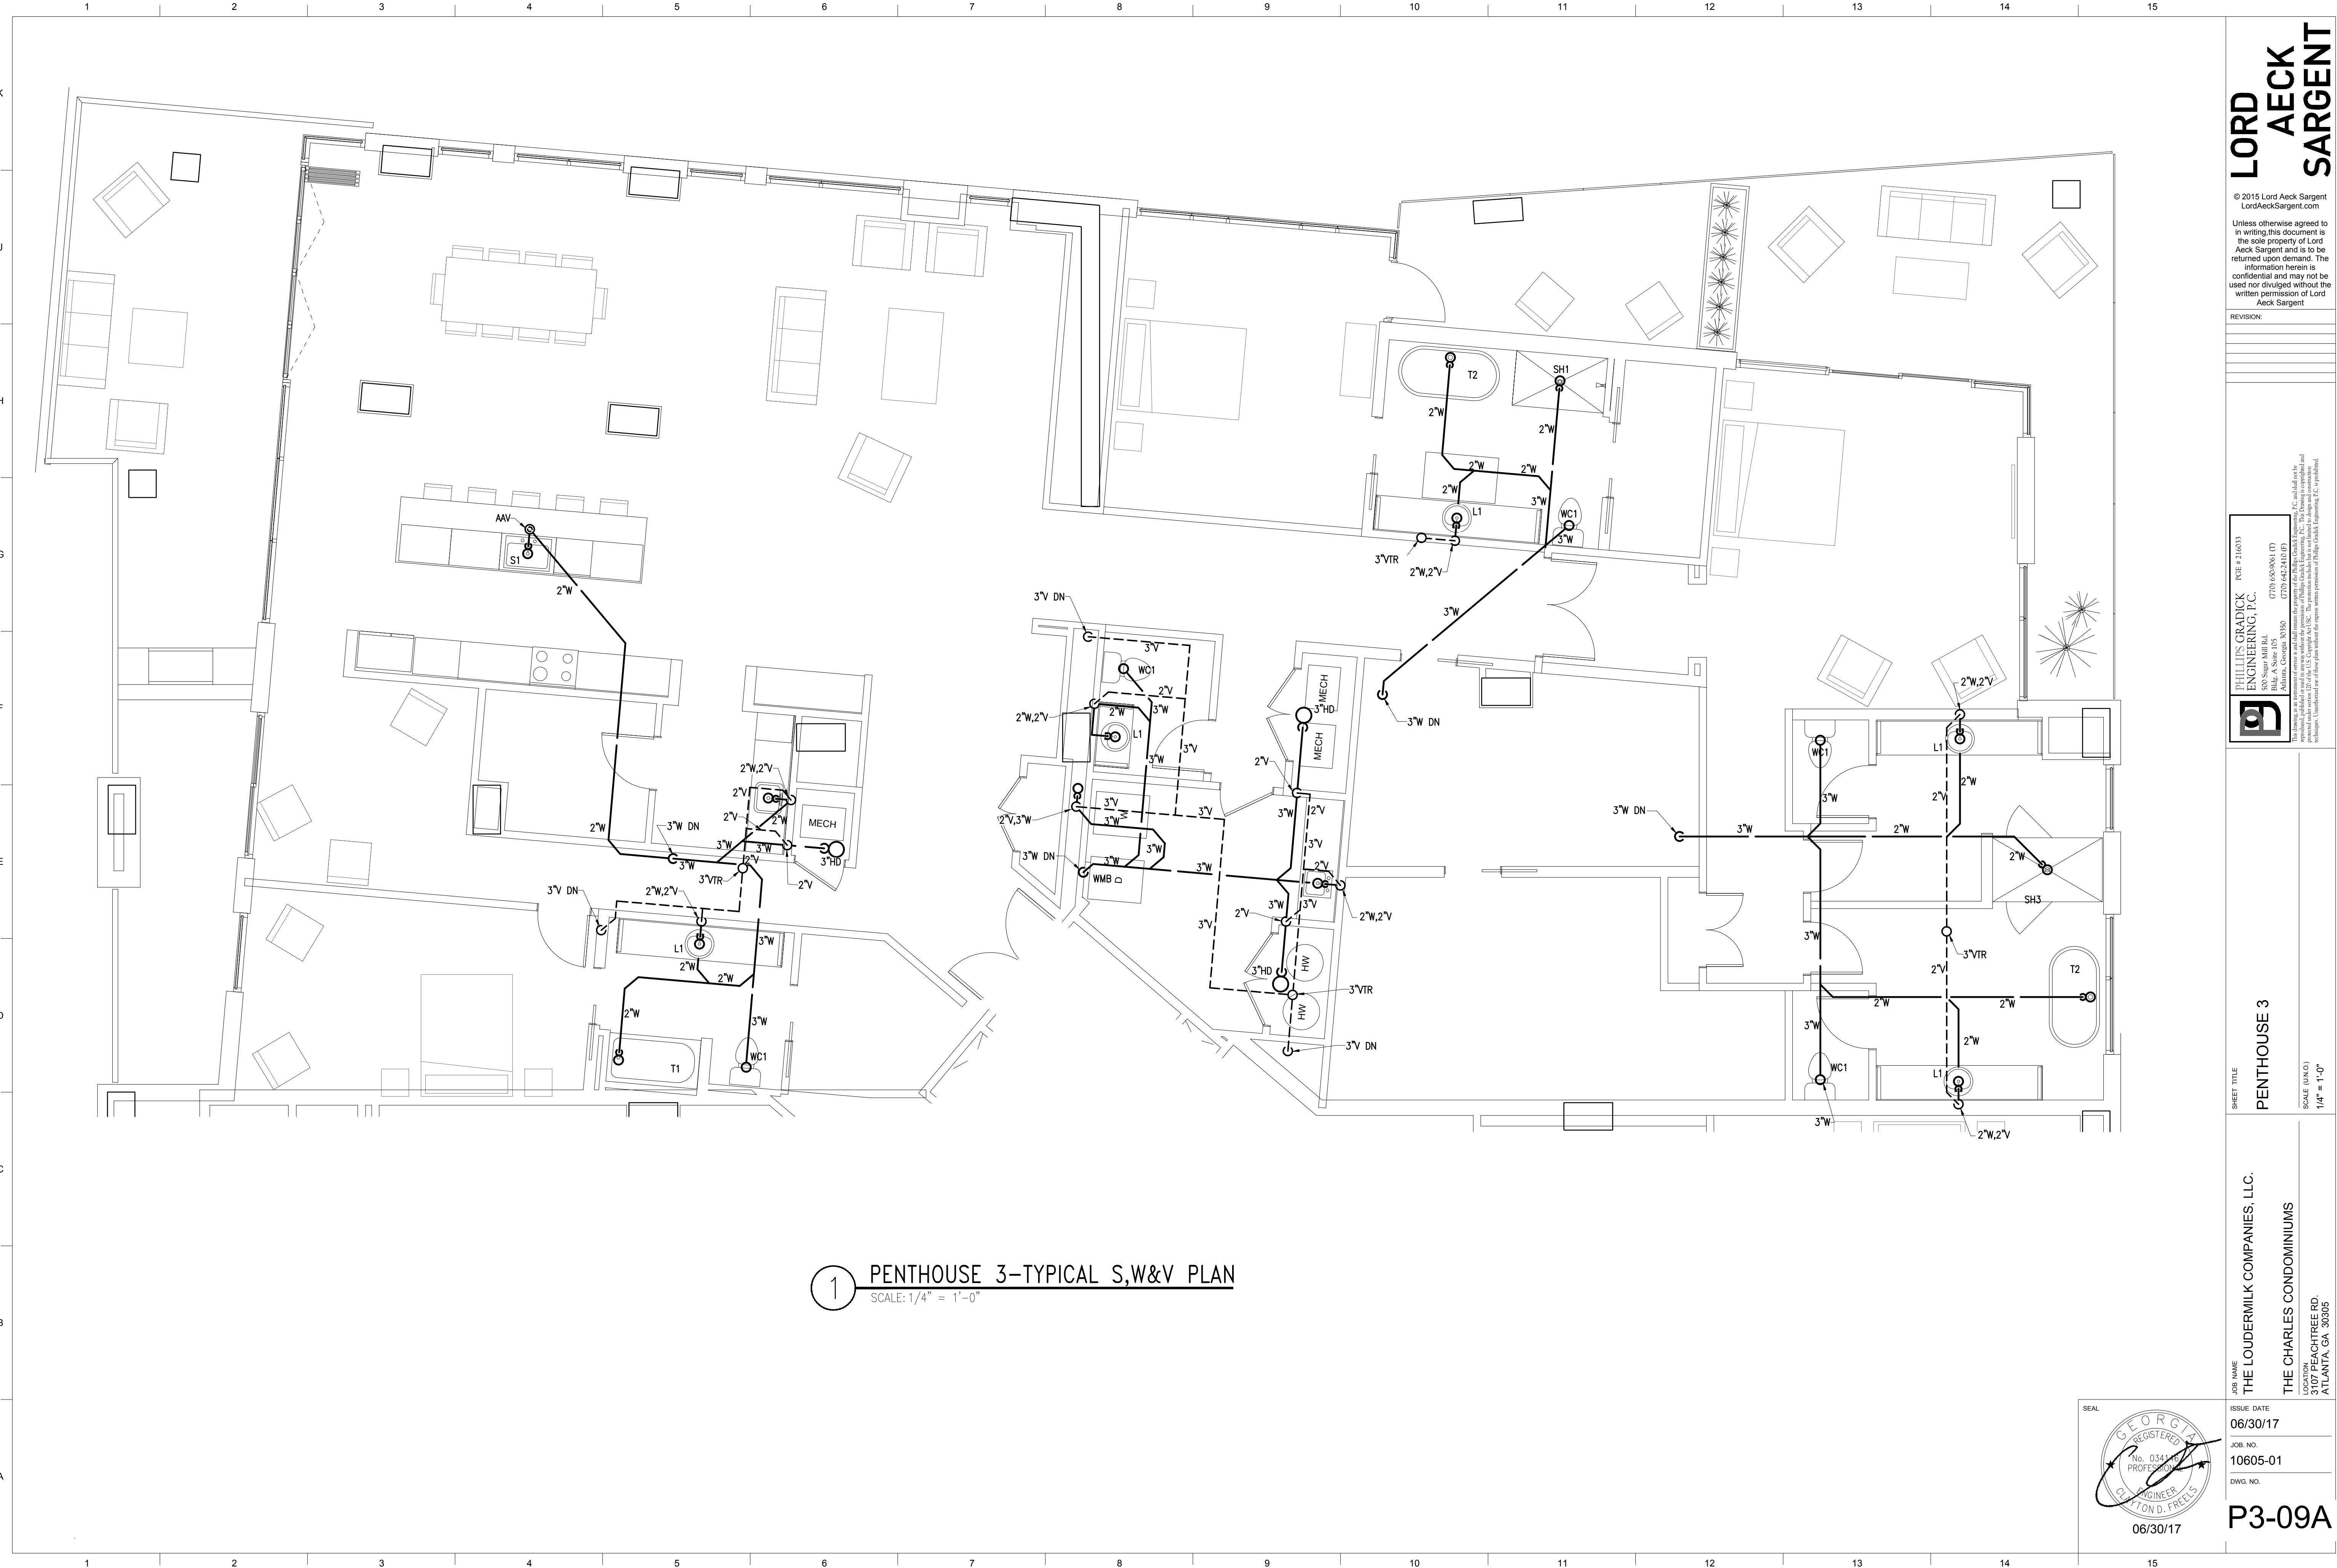

1 PENTHOUSE 3-TYPICAL S,W&V PLAN
SCALE: 1/4" = 1'-0"

LORD AECK SARGENT

© 2015 Lord Aeck Sargent
LordAeckSargent.com
Unless otherwise agreed to in writing, this document is the sole property of Lord Aeck Sargent and is to be returned upon demand. The information herein is confidential and may not be used nor divulged without the written permission of Lord Aeck Sargent

REVISION:

JOB NAME
THE LOUDERMILK COMPANIES, LLC.

ISSUE DATE
06/30/17

JOB NO.
10605-01

DWG. NO.

06/30/17

THE CHARLES CONDOMINIUMS
3107 PEACHTREE RD.
ATLANTA, GA 30305

LOCATION

10605-01

DWG. NO.


06/30/17

P3-09A


SHEET TITLE
PENTHOUSE 3

SCALE (UNITS)
1/4" = 1'-0"


PHILLIPS GRADICK
ENGINEERING, P.C.
500 Super Hill Rd.
Bldg. A Suite 105
Atlanta, Georgia 30305
(770) 638-5661 (T)
(770) 638-5410 (F)
www.phillipsgradick.com
P.C. and shall not be
reproduced, published or used in any way without the permission of Phillips Gradick Engineering, P.C. This Drawing is confidential and
intended for the exclusive use of the client. No part of this drawing may be reproduced or transmitted in any form or by any means
electronic, mechanical, photocopying, recording, or by any information storage and retrieval system, without the prior written permission of Phillips Gradick Engineering, P.C.

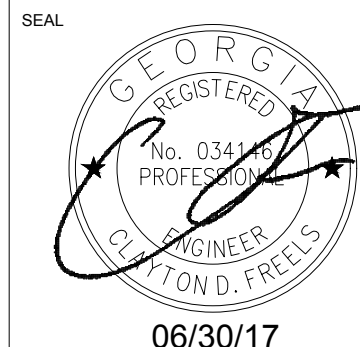


1 FITNESS – 8TH FLOOR S,W&V PLAN
SCALE: 1/4" = 1'-0"

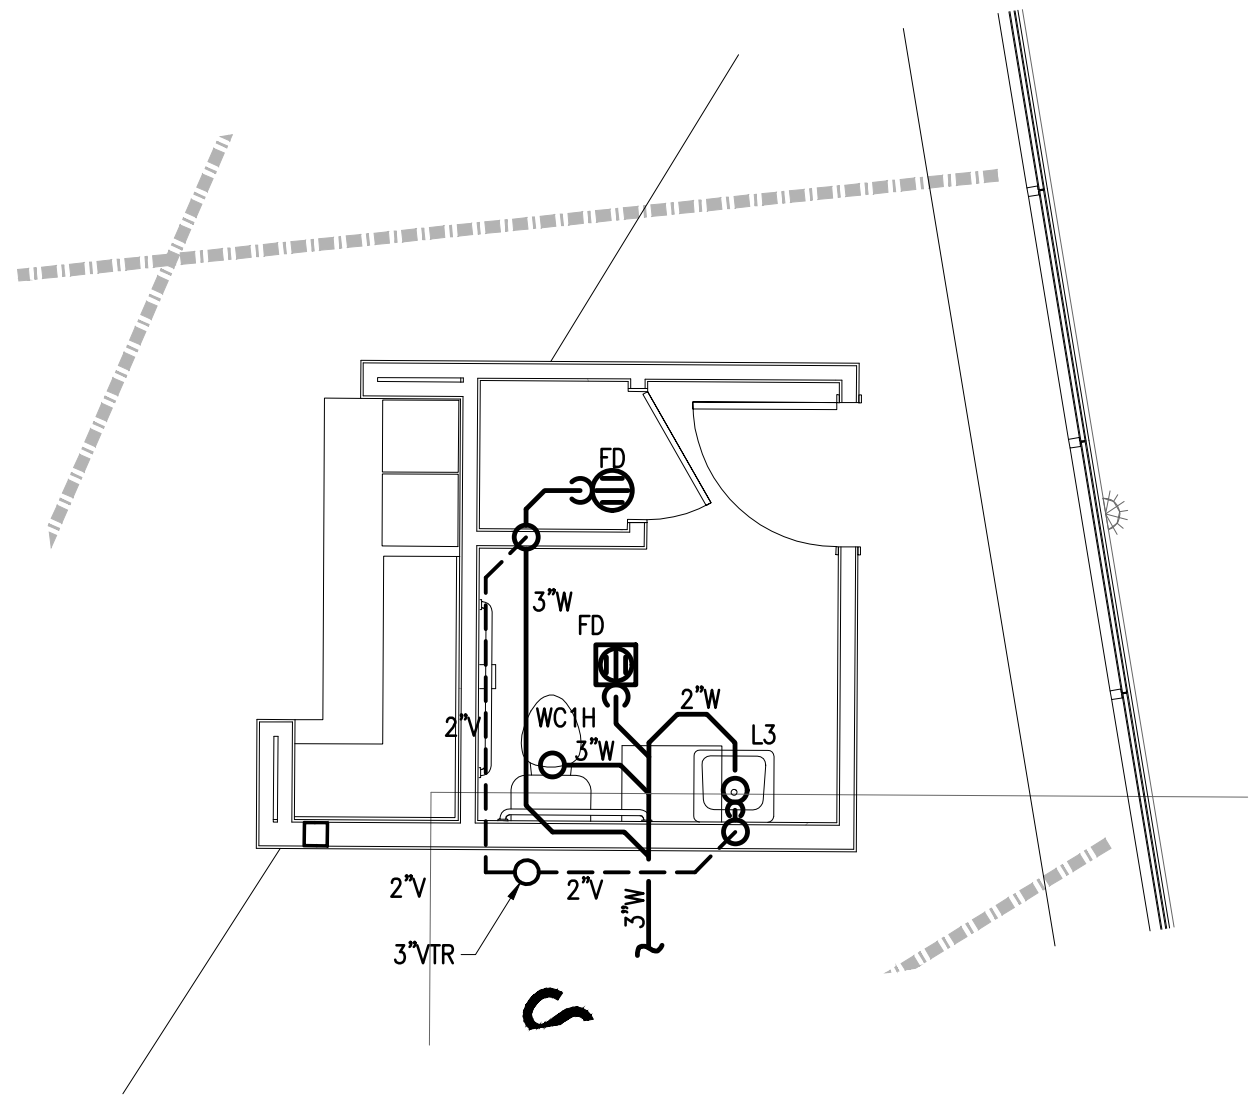


3 GUEST SUITE – 8TH FLOOR S,W&V PLAN
SCALE: 1/4" = 1'-0"

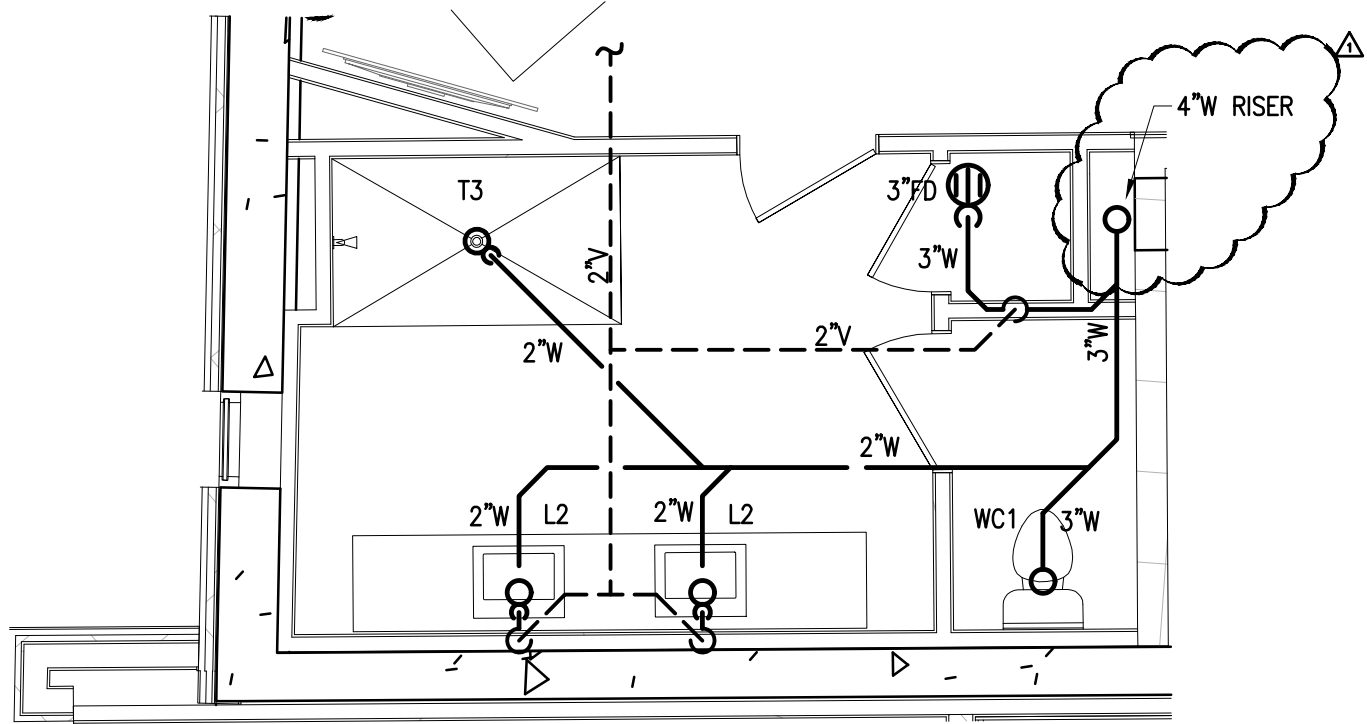


5 AMENITIES – 8TH FLOOR S,W&V PLAN
SCALE: 1/4" = 1'-0"

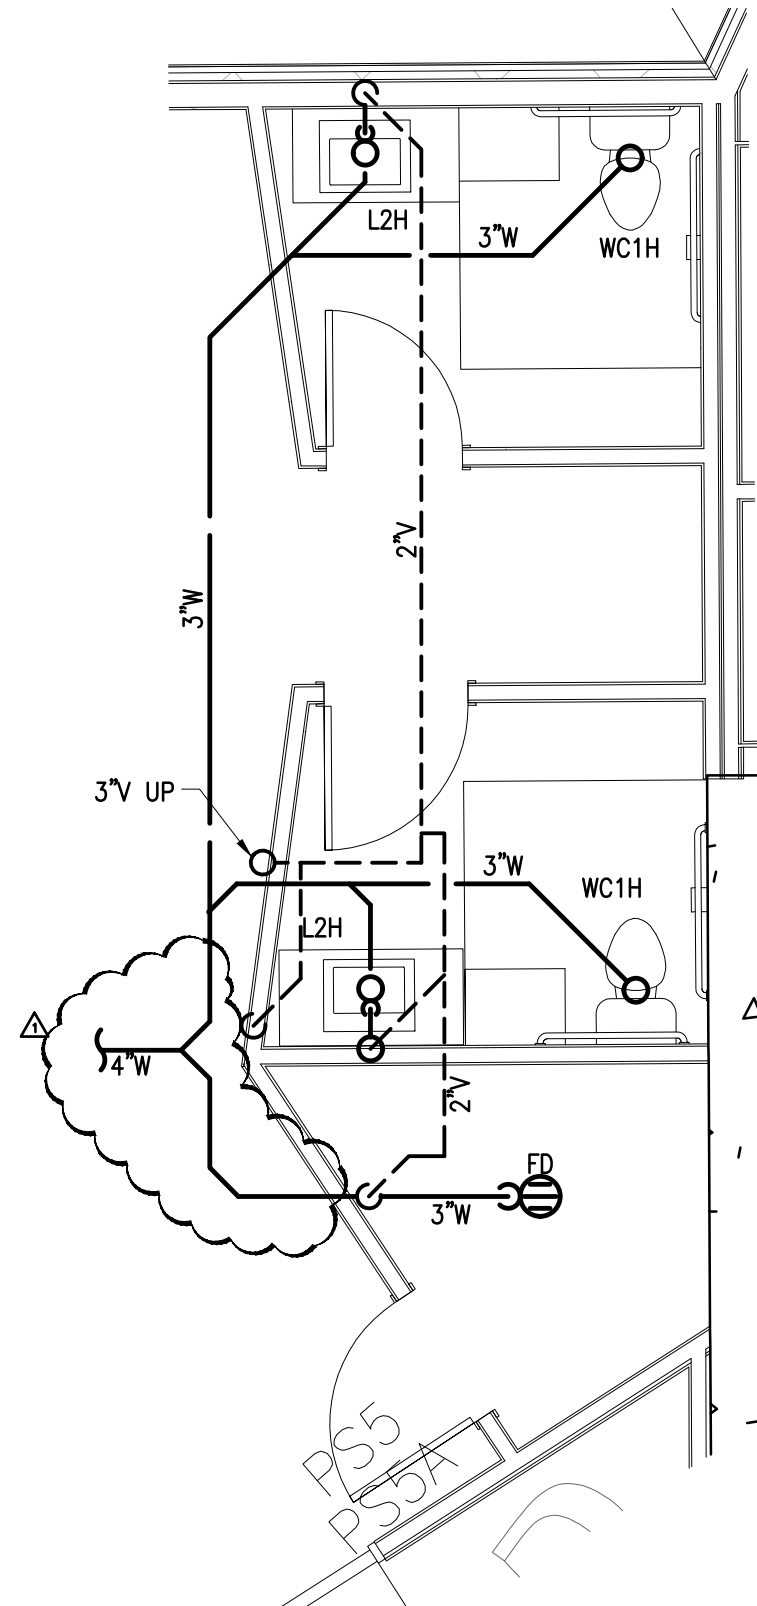


2 FITNESS – 8TH FLOOR WATER PLAN
SCALE: 1/4" = 1'-0"

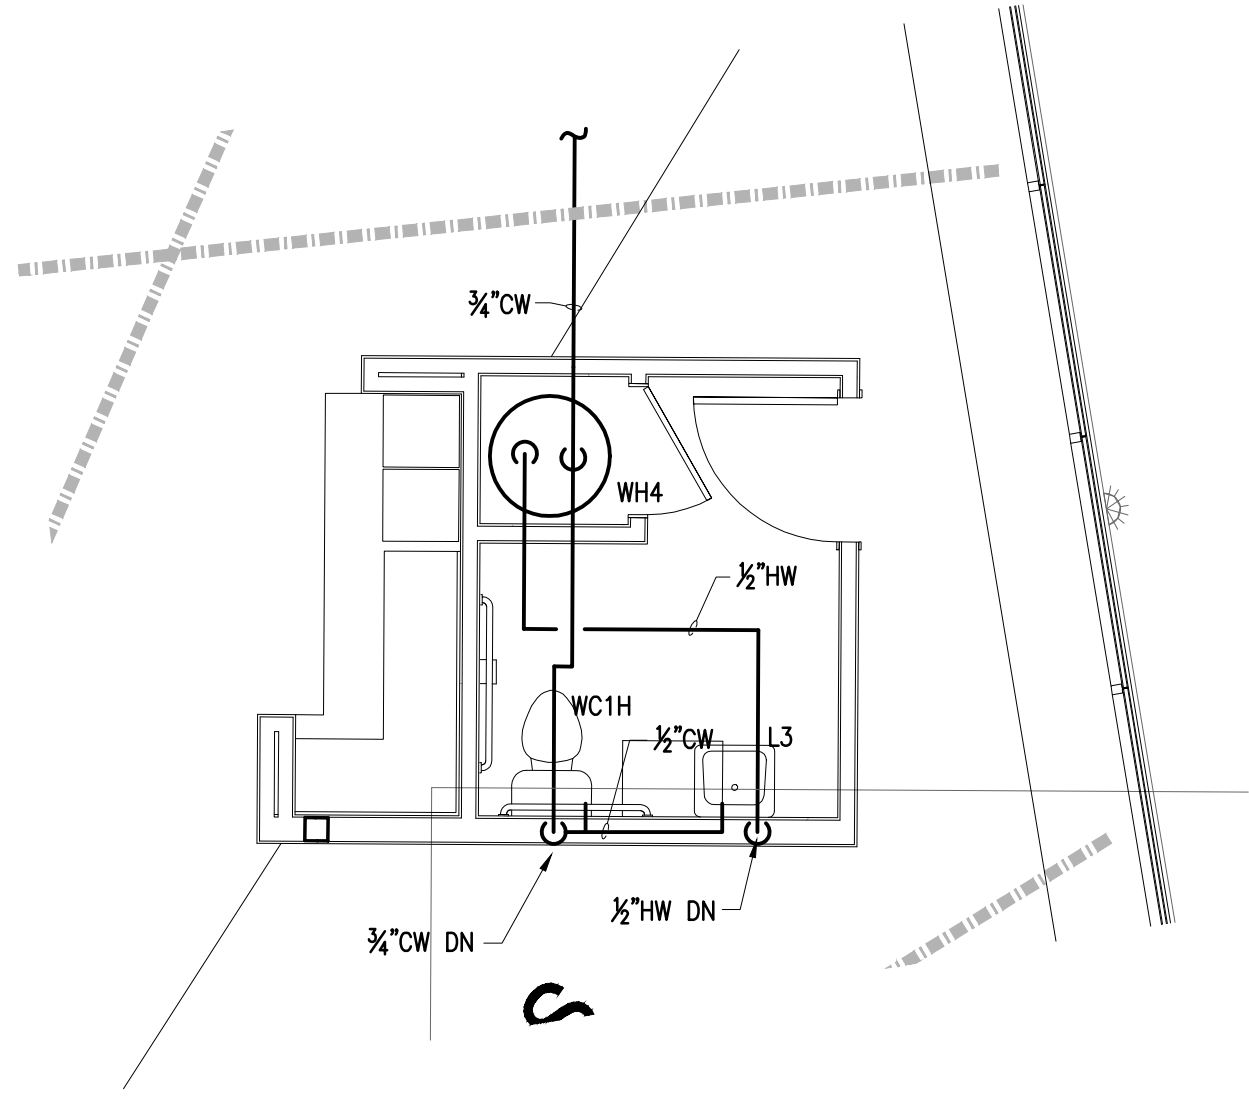

4 GUEST SUITE – 8TH FLOOR WATER PLAN
SCALE: 1/4" = 1'-0"

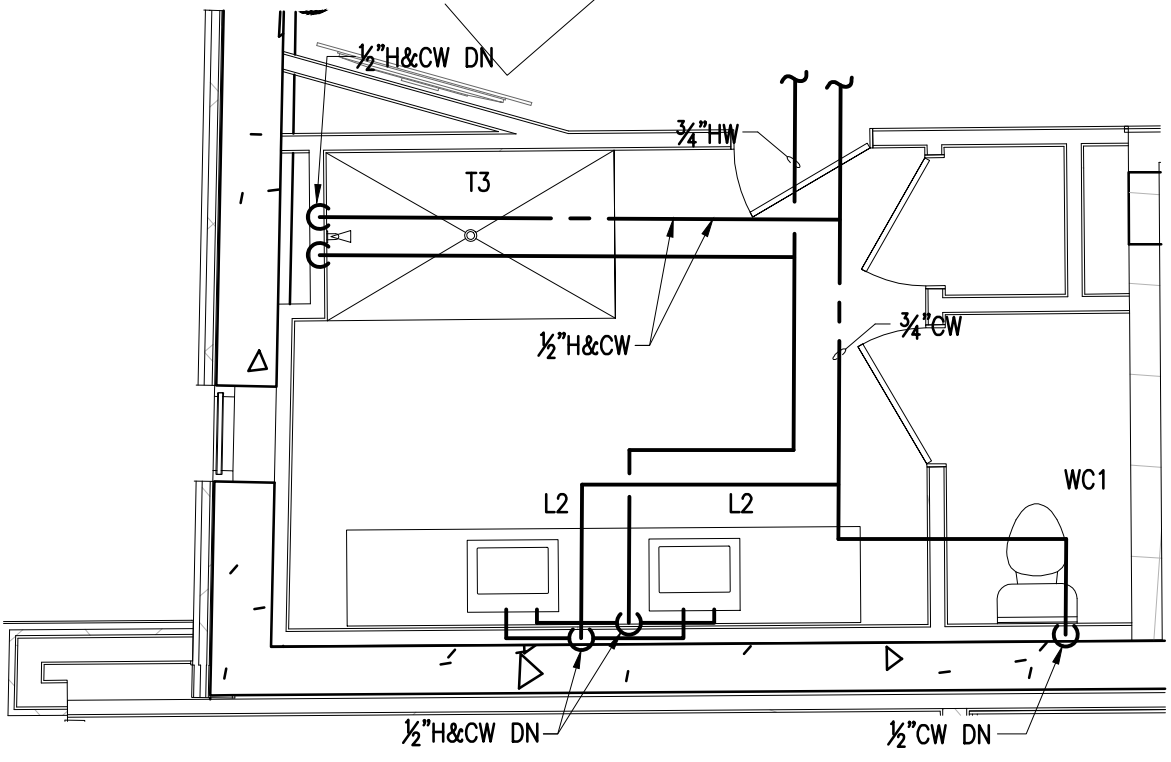

6 AMENITIES – 8TH FLOOR WATER PLAN
SCALE: 1/4" = 1'-0"

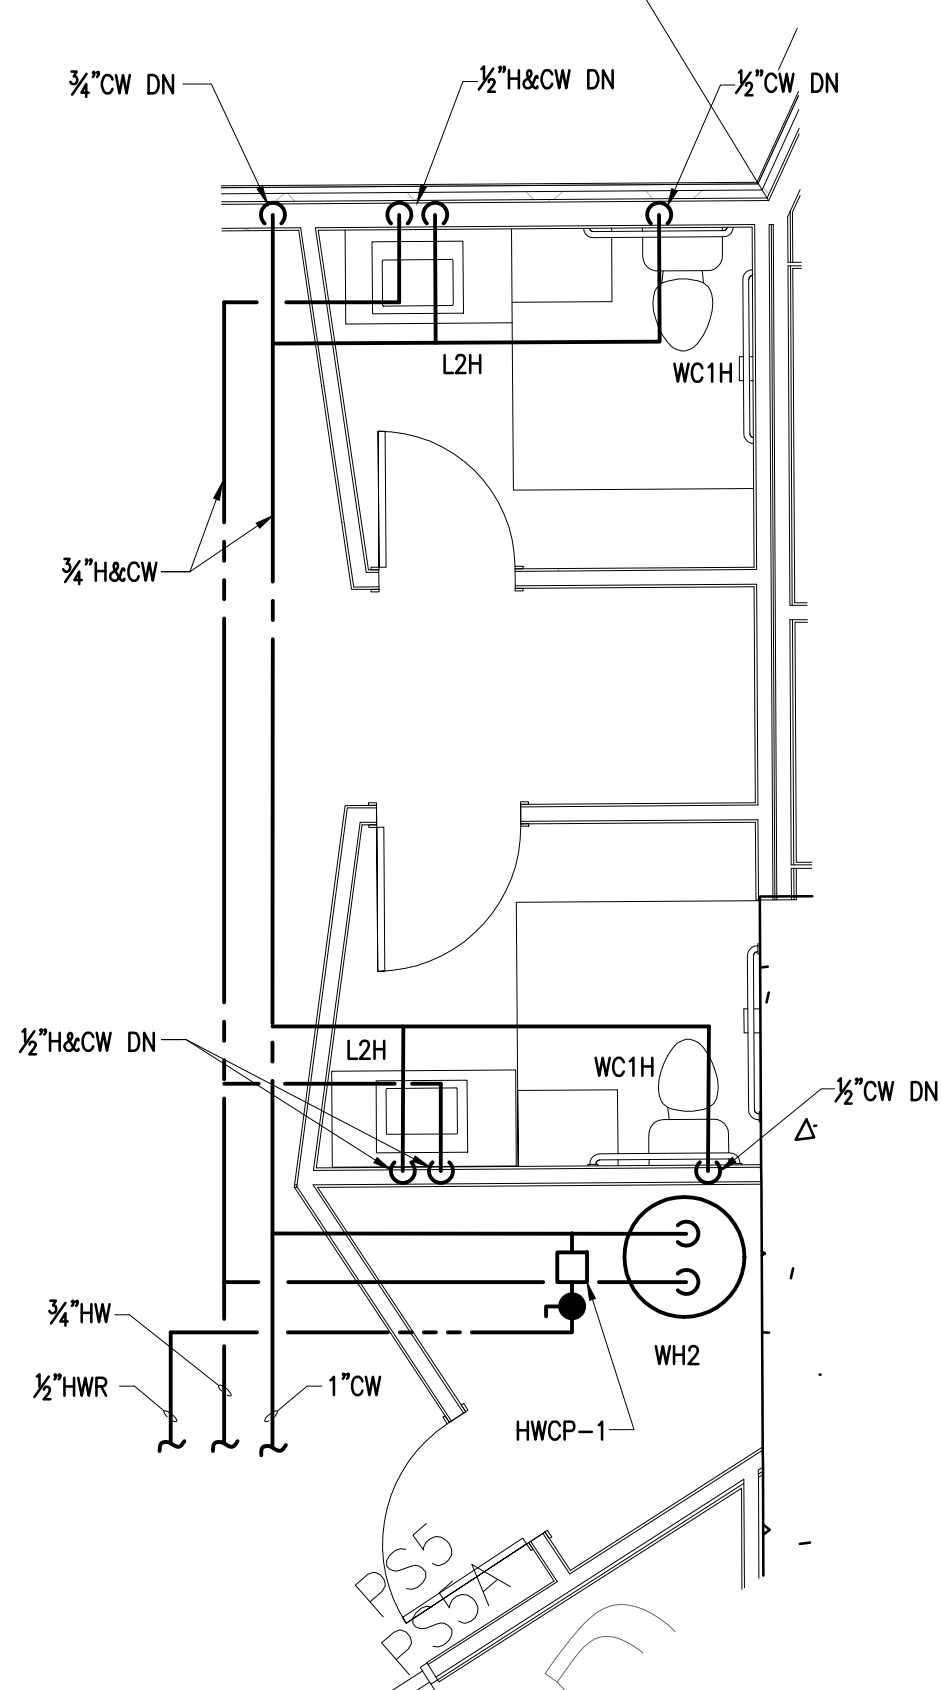

LORD
AECK
SARGENT

© 2015 Lord Aeck Sargent
LordAeckSargent.com
Unless otherwise agreed to
in writing, this document is
the sole property of Lord
Aeck Sargent and is to be
returned upon demand. The
information herein is
confidential and may not be
used nor divulged without the
written permission of Lord
Aeck Sargent


REVISION:
AS-008 8/24/2017

PHILLIPS GRADICK
ENGINEERING, P.C.
500 Sugar Mill Rd.
Bldg. A Suite 105
Canton, MS 39046
Tel: 662.344.1350
Fax: 662.344.1351
www.phillipsgradick.com
This drawing, as well as all other documents created by Phillips Gradick Engineering, P.C., and shall not be
reproduced, published, or used in any way without the permission of Phillips Gradick Engineering, P.C. This drawing is copyrighted and
all rights are reserved. No part of this drawing may be reproduced without the express written permission of Phillips Gradick Engineering, P.C. is prohibited.


SHEET TITLE
AMENITIES ENLARGED PLANS
SCALE (UNCO.)
1/4" = 1'-0"


JOB NAME
THE LOUDERMILK COMPANIES, LLC.
THE CHARLES CONDOMINIUMS
LOCATION
3107 PEACHTREE RD.
ATLANTA, GA 30305

ISSUE DATE
06/30/17
JOB NO.
10605-01
DWG. NO.
P3-10

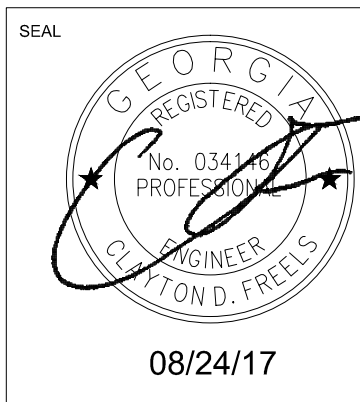

ISSUED FOR CONSTRUCTION


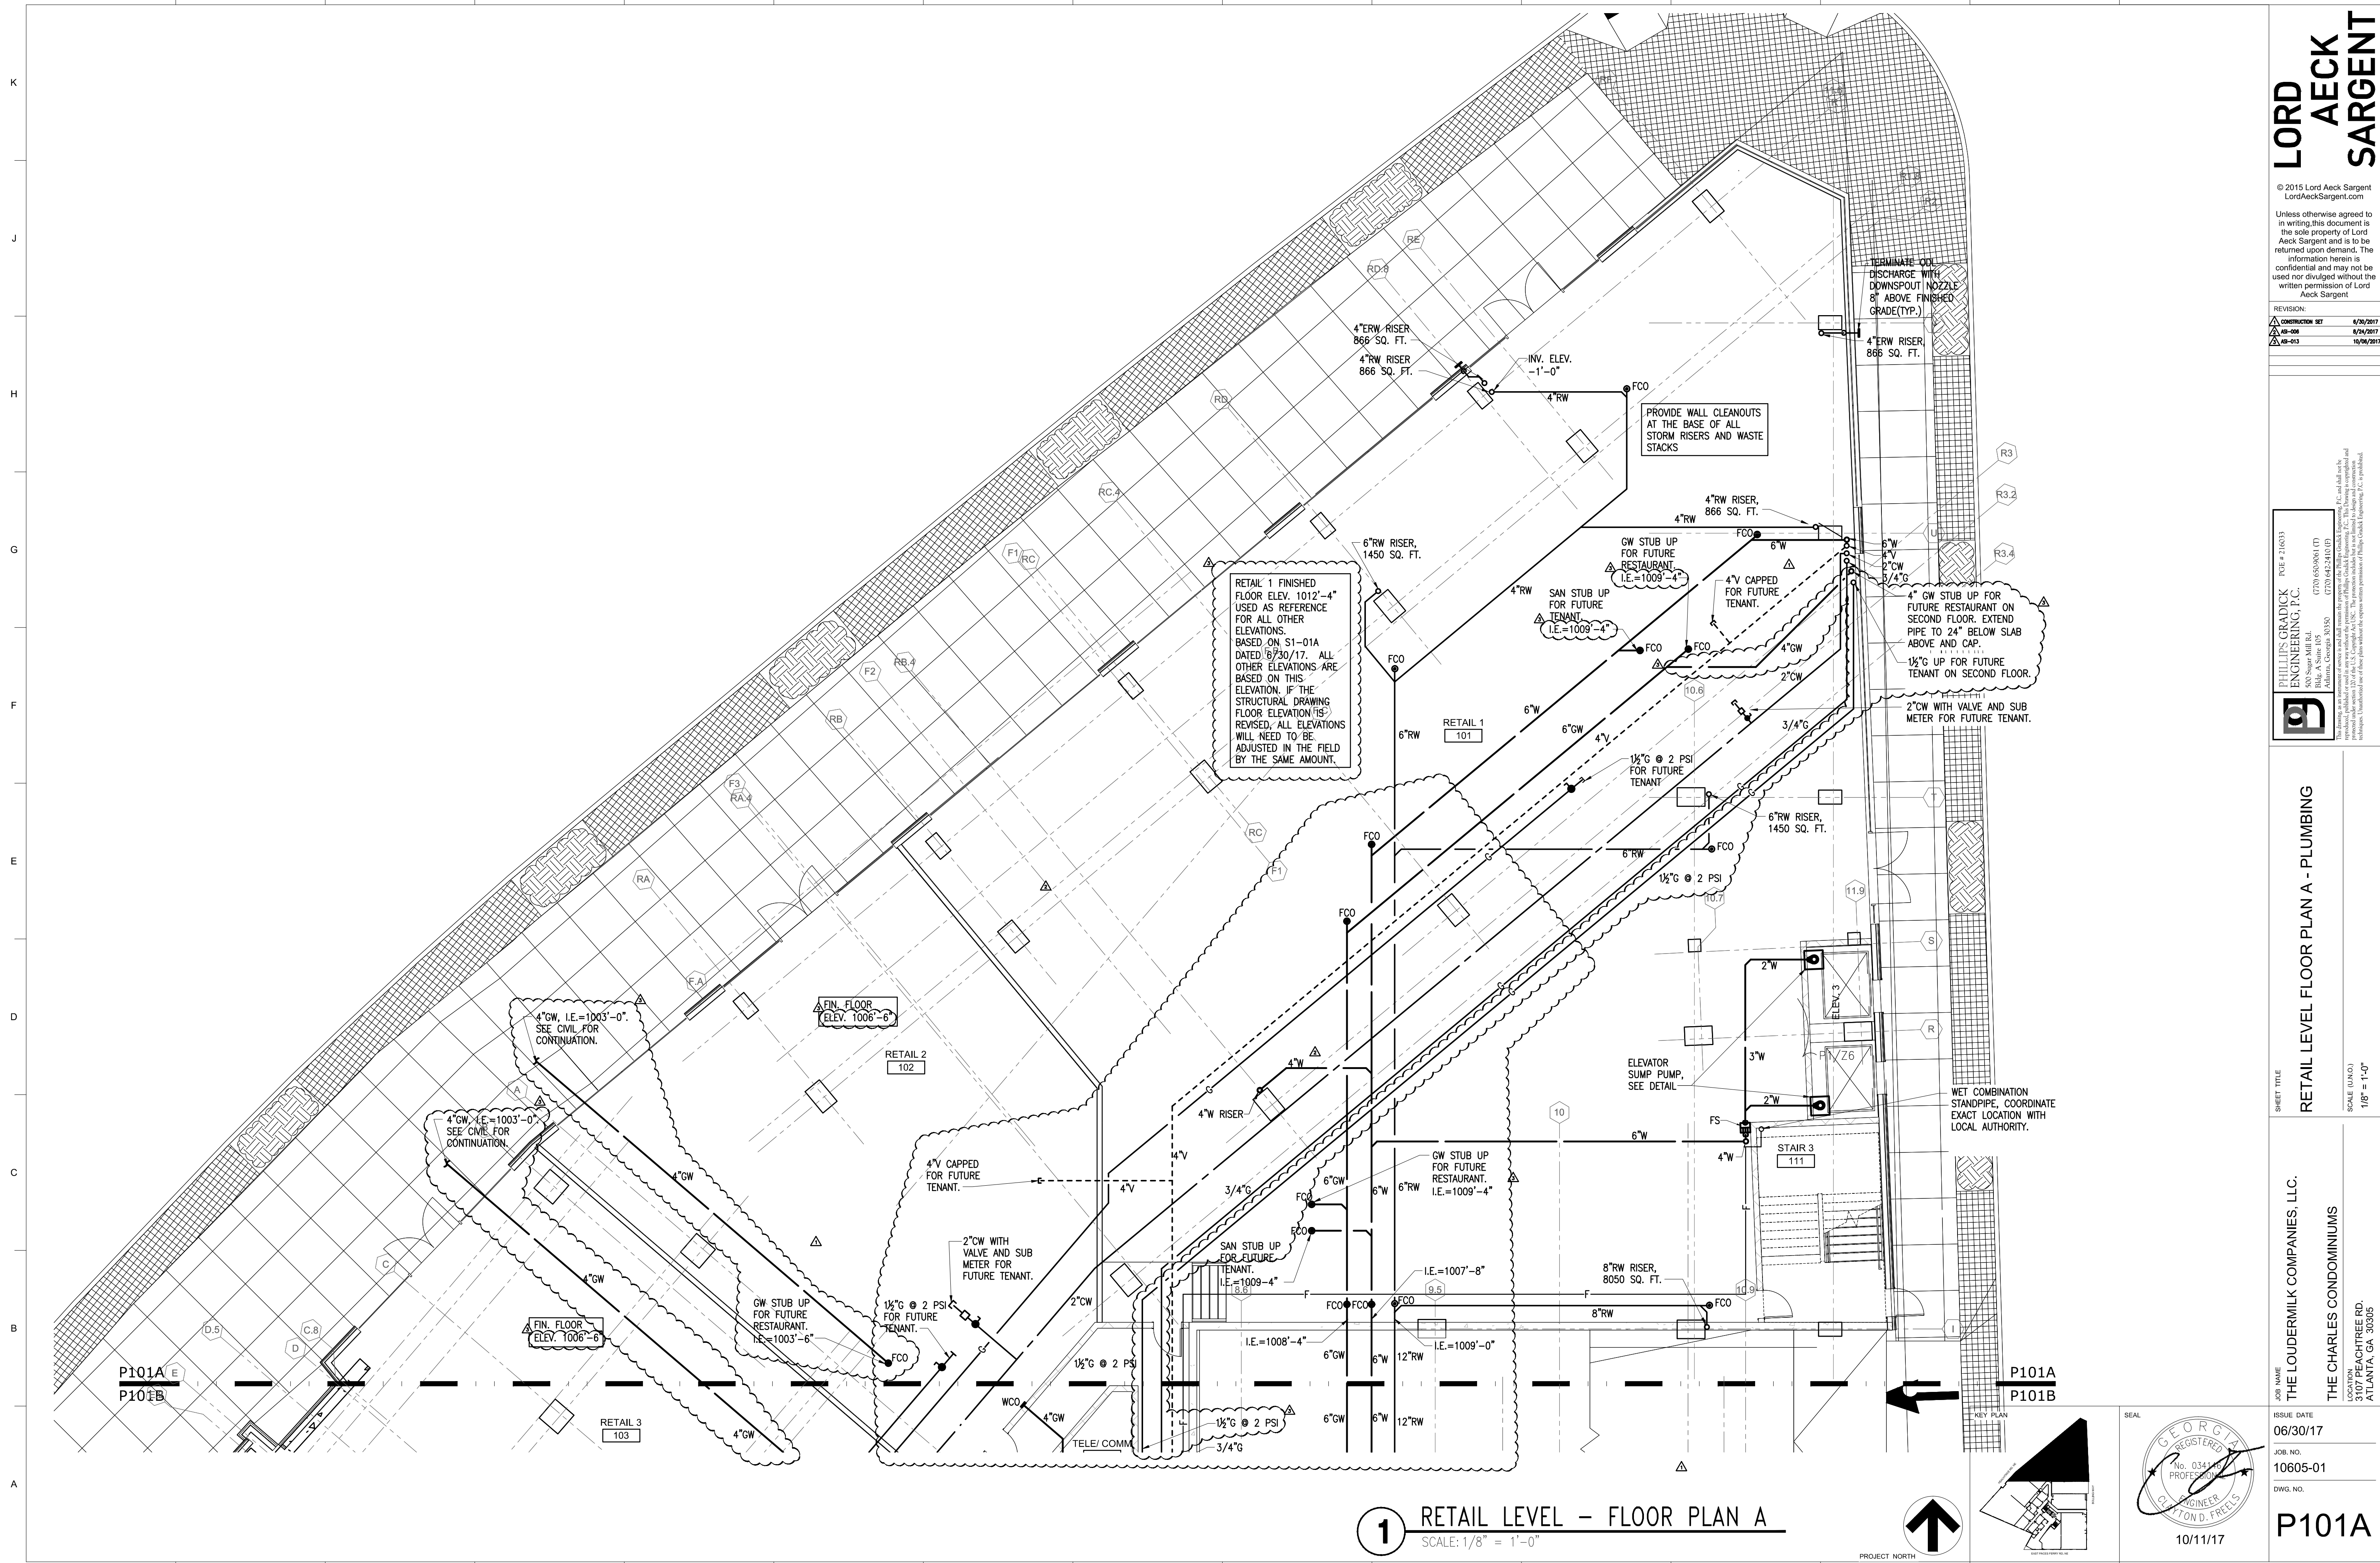


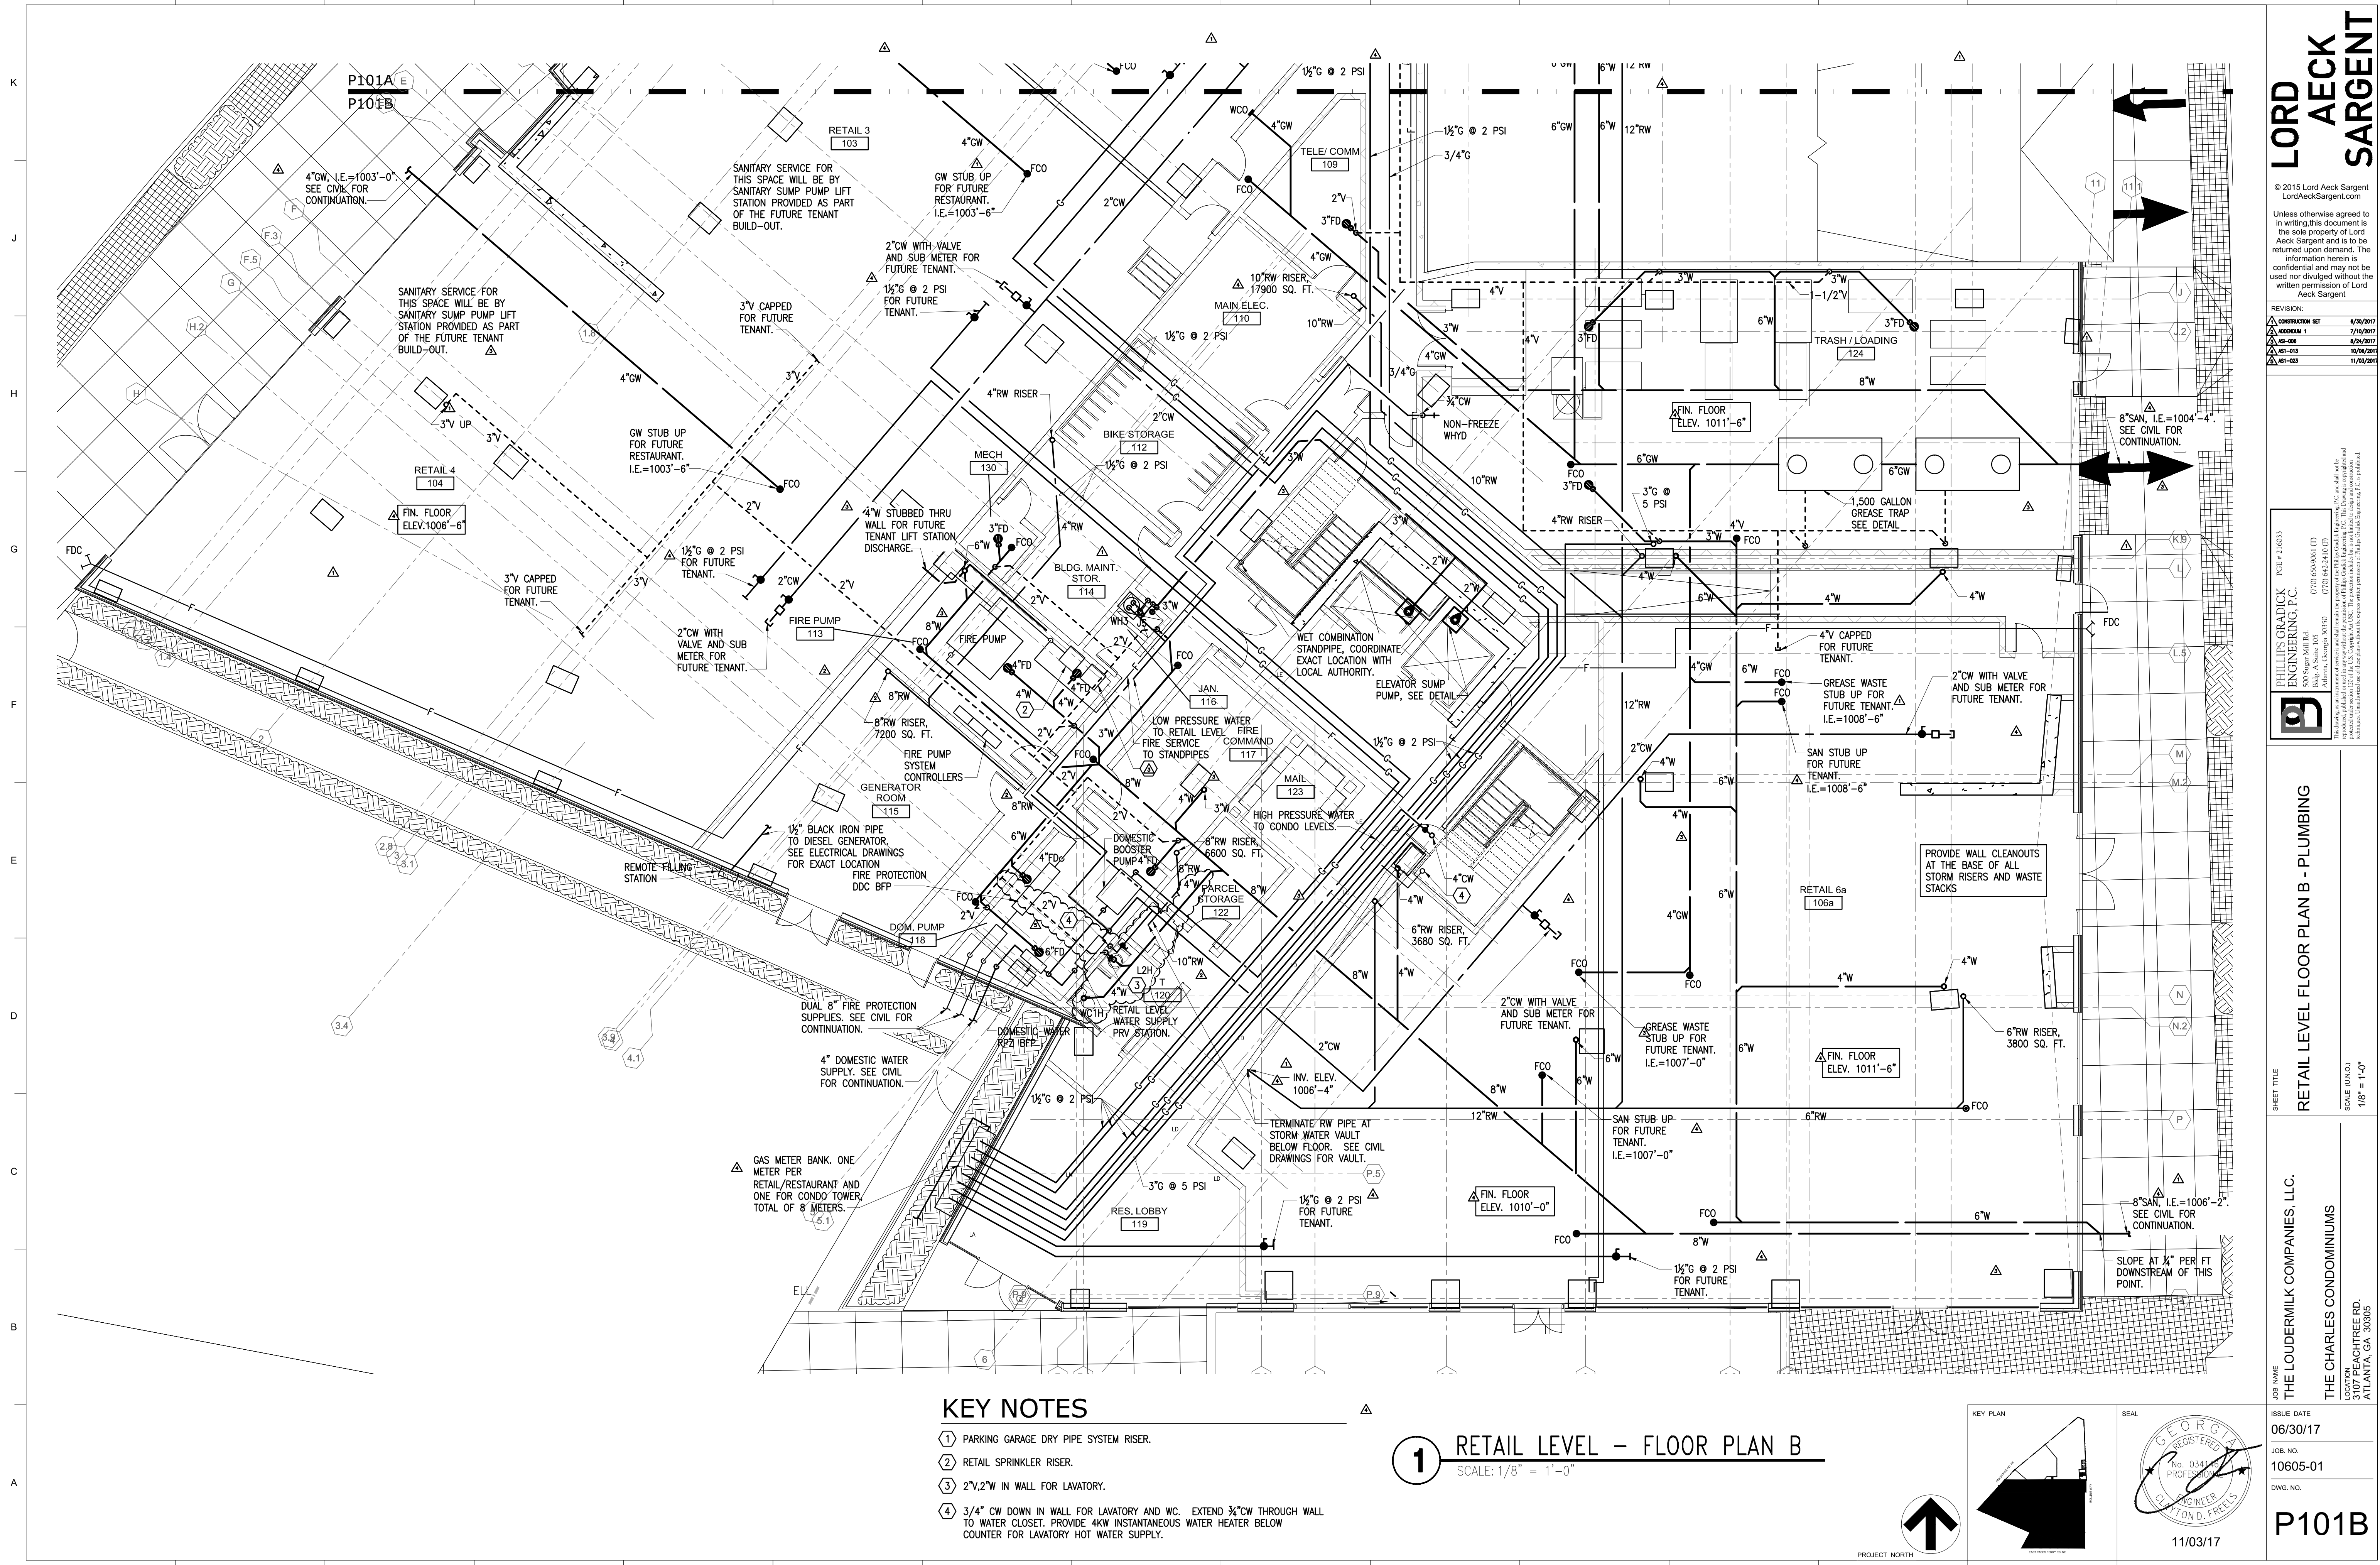

KEY NOTES

- 1 PARKING GARAGE DRY PIPE SYSTEM RISER.
- 2 RETAIL SPRINKLER RISER.
- 3 2"V, 2"W IN WALL FOR LAVATORY.
- 4 3/4" CW DOWN IN WALL FOR LAVATORY AND WC. EXTEND 3/4" CW THROUGH WALL TO WATER CLOSET. PROVIDE 4KW INSTANTANEOUS WATER HEATER BELOW COUNTER FOR LAVATORY HOT WATER SUPPLY.

1 RETAIL LEVEL - FLOOR PLAN B
SCALE: 1/8" = 1'-0"

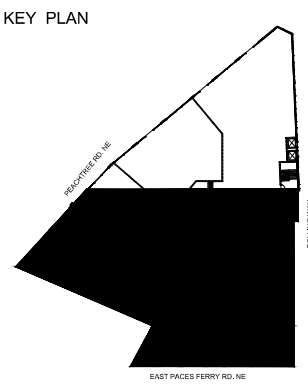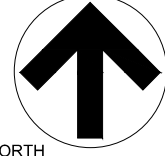


JOB NAME
THE LOUDERMILK COMPANIES, LLC.
LOCATION
THE CHARLES CONDOMINIUMS
3107 PEACHTREE RD.
ATLANTA, GA 30305
ISSUE DATE
06/30/17
JOB NO.
10605-01
DWG. NO.
P101B

SHEET TITLE
RETAIL LEVEL FLOOR PLAN B - PLUMBING
SCALE (INCHES)
1/8" = 1'-0"


PHILLIPS GRADICK
ENGINEERING, P.C.
500 Sugar Mill Rd.
Bldg. A, Suite 103
Cobb County, GA 30006
770.435.9861 (T)
770.435.9862 (F)
770.435.9863 (C)
770.435.9864 (E)
770.435.9865 (M)
770.435.9866 (F)
770.435.9867 (S)
770.435.9868 (T)
770.435.9869 (F)
770.435.9870 (S)
770.435.9871 (M)
770.435.9872 (F)
770.435.9873 (S)
770.435.9874 (M)
770.435.9875 (F)
770.435.9876 (S)
770.435.9877 (M)
770.435.9878 (F)
770.435.9879 (S)
770.435.9880 (M)




LORD
AECK
SARGENT
© 2015 Lord Aeck Sargent
LordAeckSargent.com
Unless otherwise agreed to in writing, this document is the sole property of Lord Aeck Sargent and is to be returned upon demand. The information herein is confidential and may not be used or divulged without the written permission of Lord Aeck Sargent.
REVISION:
CONSTRUCTION SET 6/20/2017
REVISION 1 7/20/2017
AS-206 8/24/2017
AS-013 10/06/2017
AS-023 11/03/2017

 
ISSUED FOR CONSTRUCTION



SCALE: $1/8" = 1'-0"$

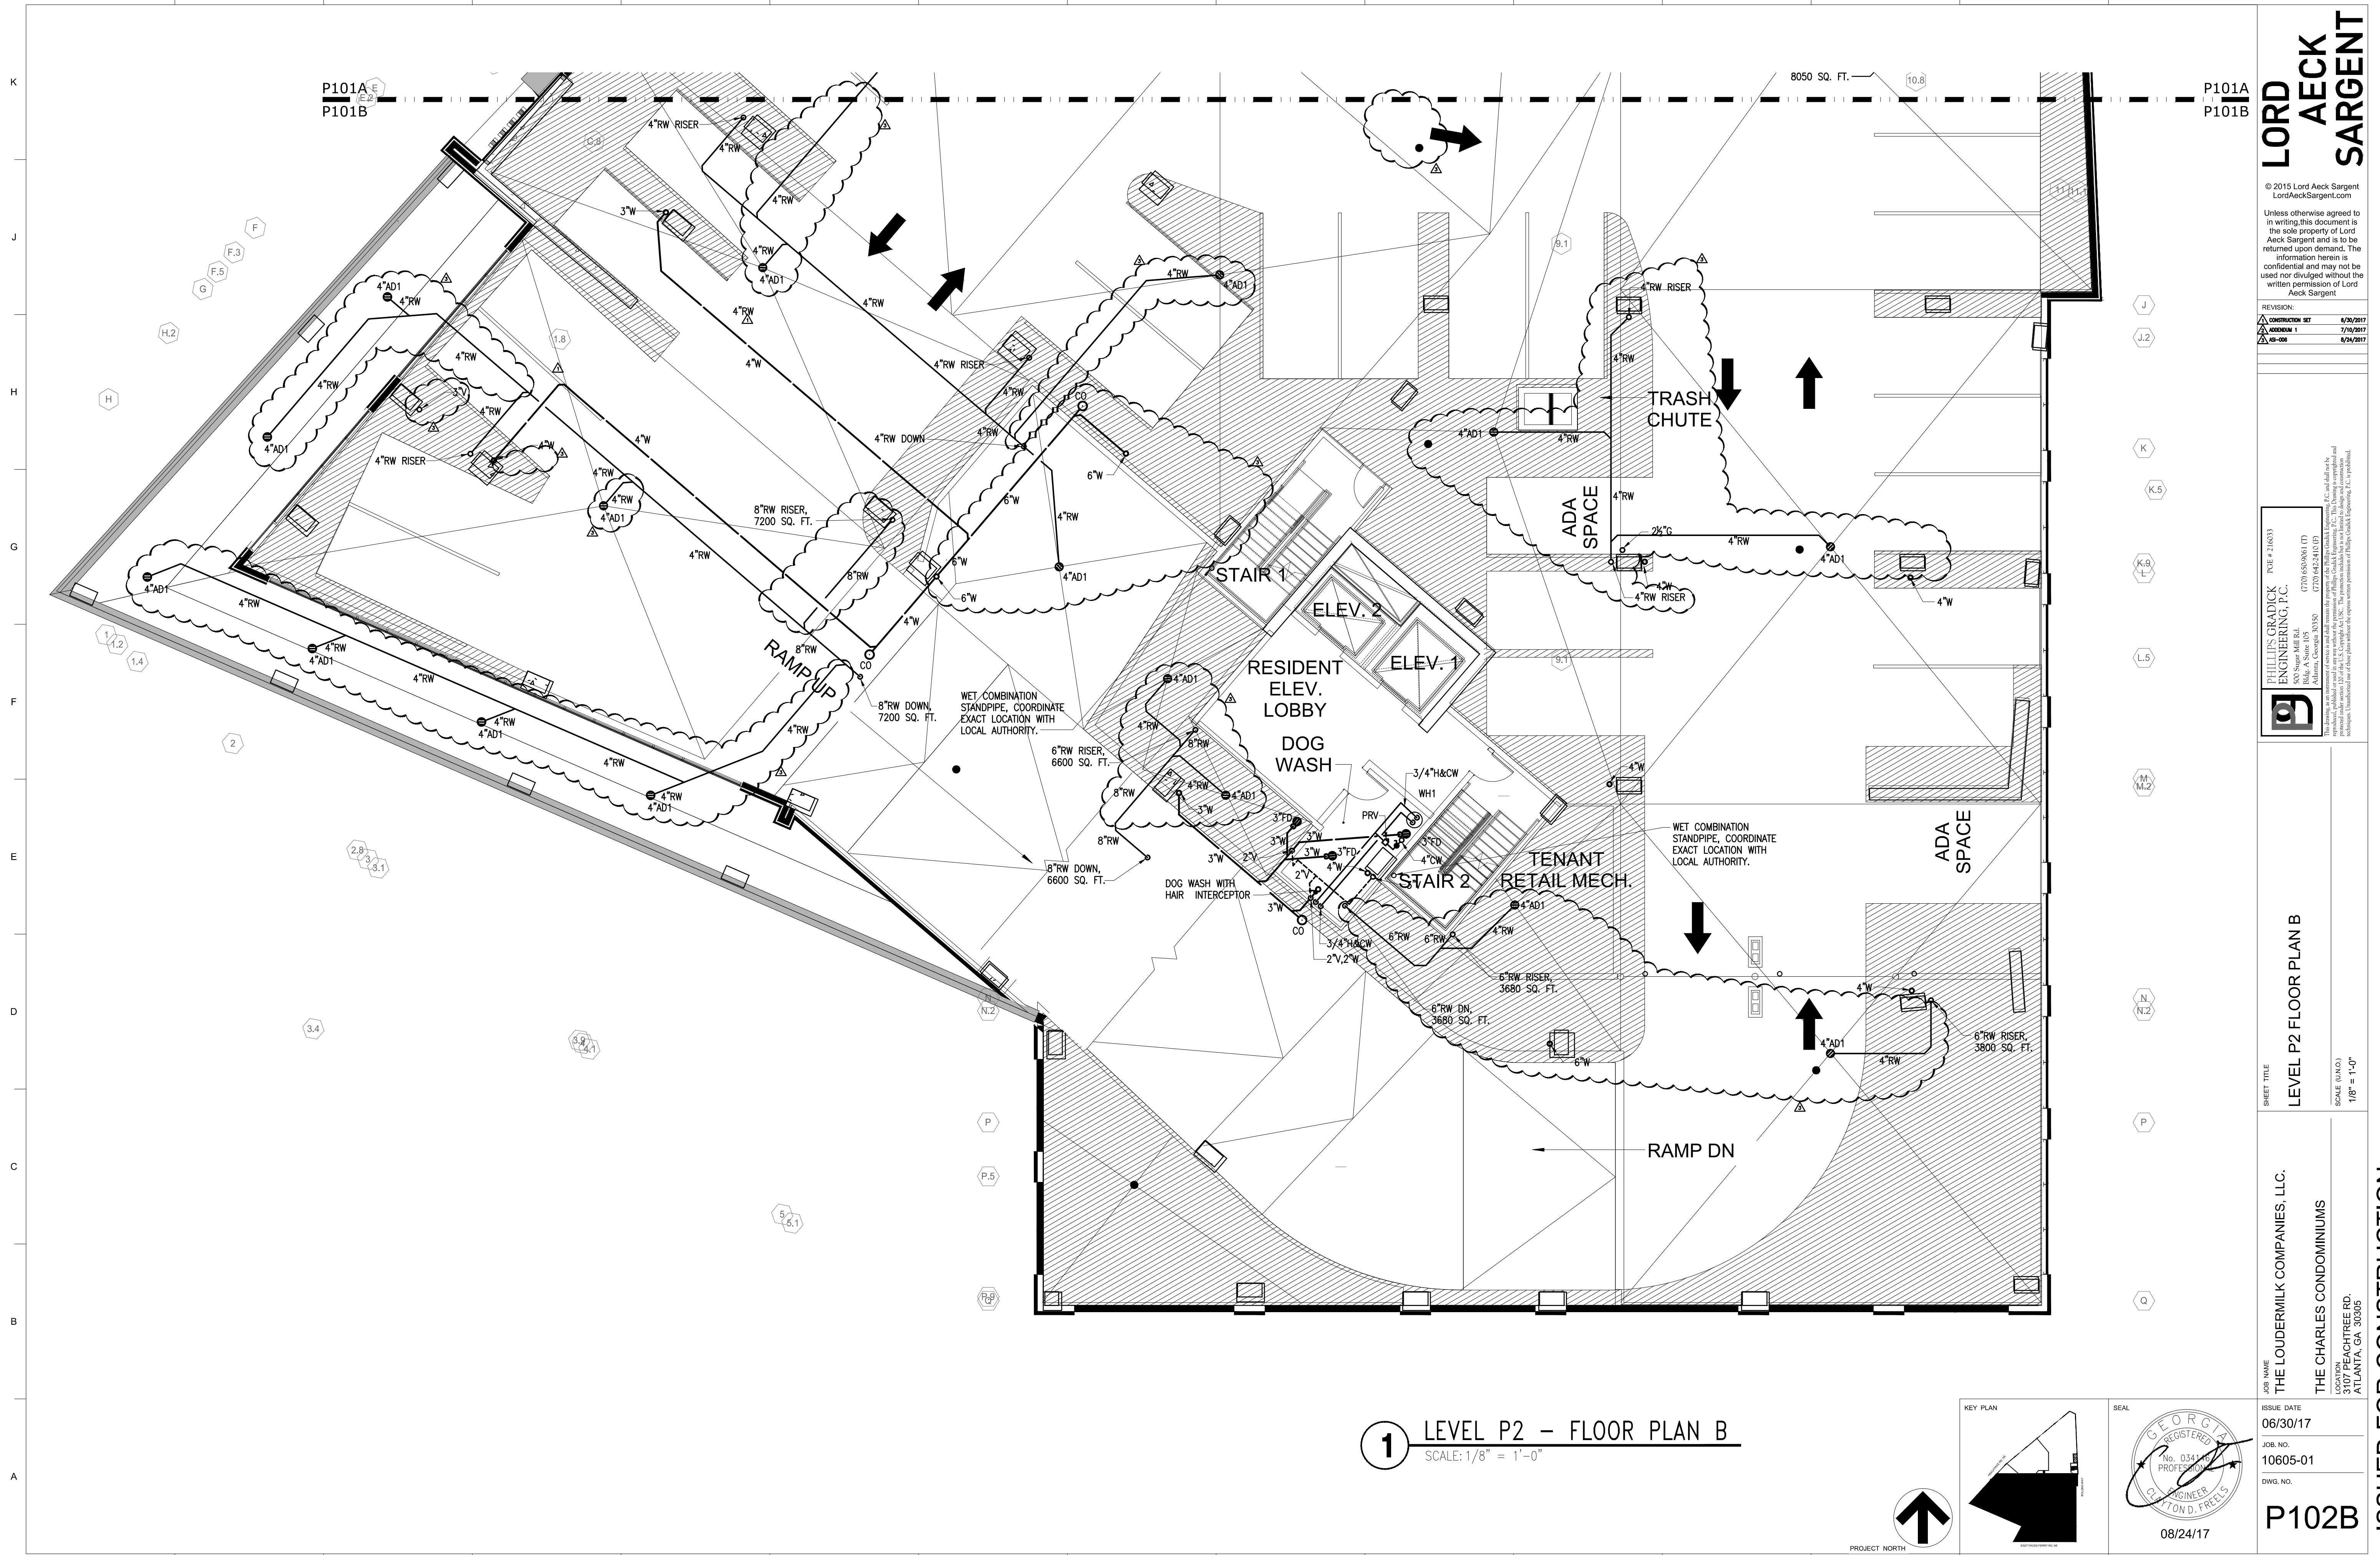

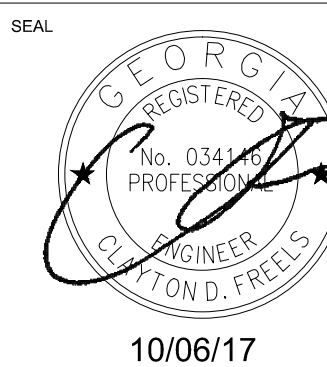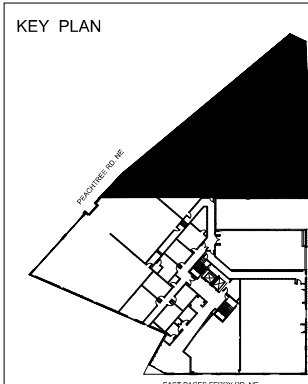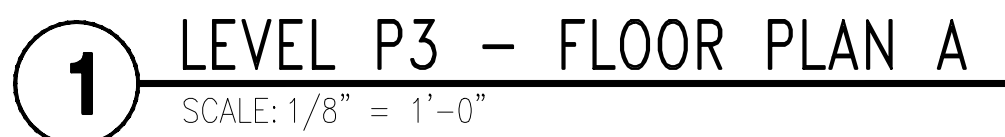

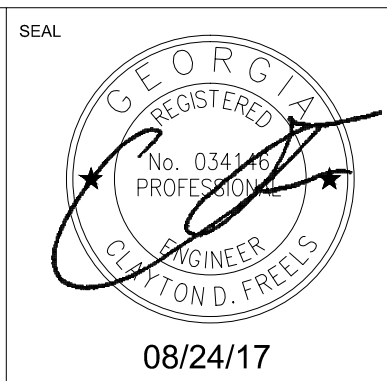


K
J
H
G
F
E
D
C
B
A

P101A
P101B

KEY PLAN

SEAL

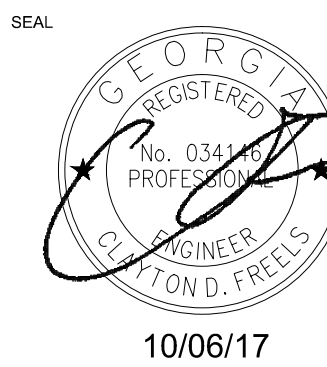

ISSUE DATE
06/30/17
JOB NO.
10605-01
DWG. NO.

P104A

ISSUED FOR CONSTRUCTION

JOB NAME
THE LOUDERMILK COMPANIES, LLC.

THE CHARLES CONDOMINIUMS
LOCATION
3107 PEACHTREE RD.
ATLANTA, GA 30305

SHEET TITLE
LEVEL P4 FLOOR PLAN A

SCALE (UNCL.)
1/8" = 1'-0"

PHILLIPS GRADICK
ENGINEERING, P.C.
500 Sugar Mill Rd.
Bldg. A, Suite 103
Lawrenceville, GA 30046
Phone: 770.455.9861 (T)
Fax: 770.455.9862 (F)
Email: info@pg-engineering.com
www.pg-engineering.com




PGEE # 216033
This drawing, and all other drawings created by or for Phillips Gradick Engineering, P.C., are the property of Phillips Gradick Engineering, P.C. and shall remain the confidential property of Phillips Gradick Engineering, P.C. and shall not be reproduced, published, or used in any way without the written permission of Phillips Gradick Engineering, P.C. The drawing is copyrighted and all rights are reserved. No part of this drawing may be reproduced or transmitted in any form or by any means, electronic, mechanical, photocopying, recording, or by any information storage and retrieval system, without the prior written permission of Phillips Gradick Engineering, P.C. This is prohibited. Unpublished use of these plans without the express written permission of Phillips Gradick Engineering, P.C. is prohibited.

REVISION:
AS-008 8/24/2017
AS-013 10/06/2017

© 2015 Lord Aeck Sargent
LordAeckSargent.com
Unless otherwise agreed to in writing, this document is the sole property of Lord Aeck Sargent and is to be returned upon demand. The information herein is confidential and may not be used nor divulged without the written permission of Lord Aeck Sargent.

LORD
AECK
SARGENT

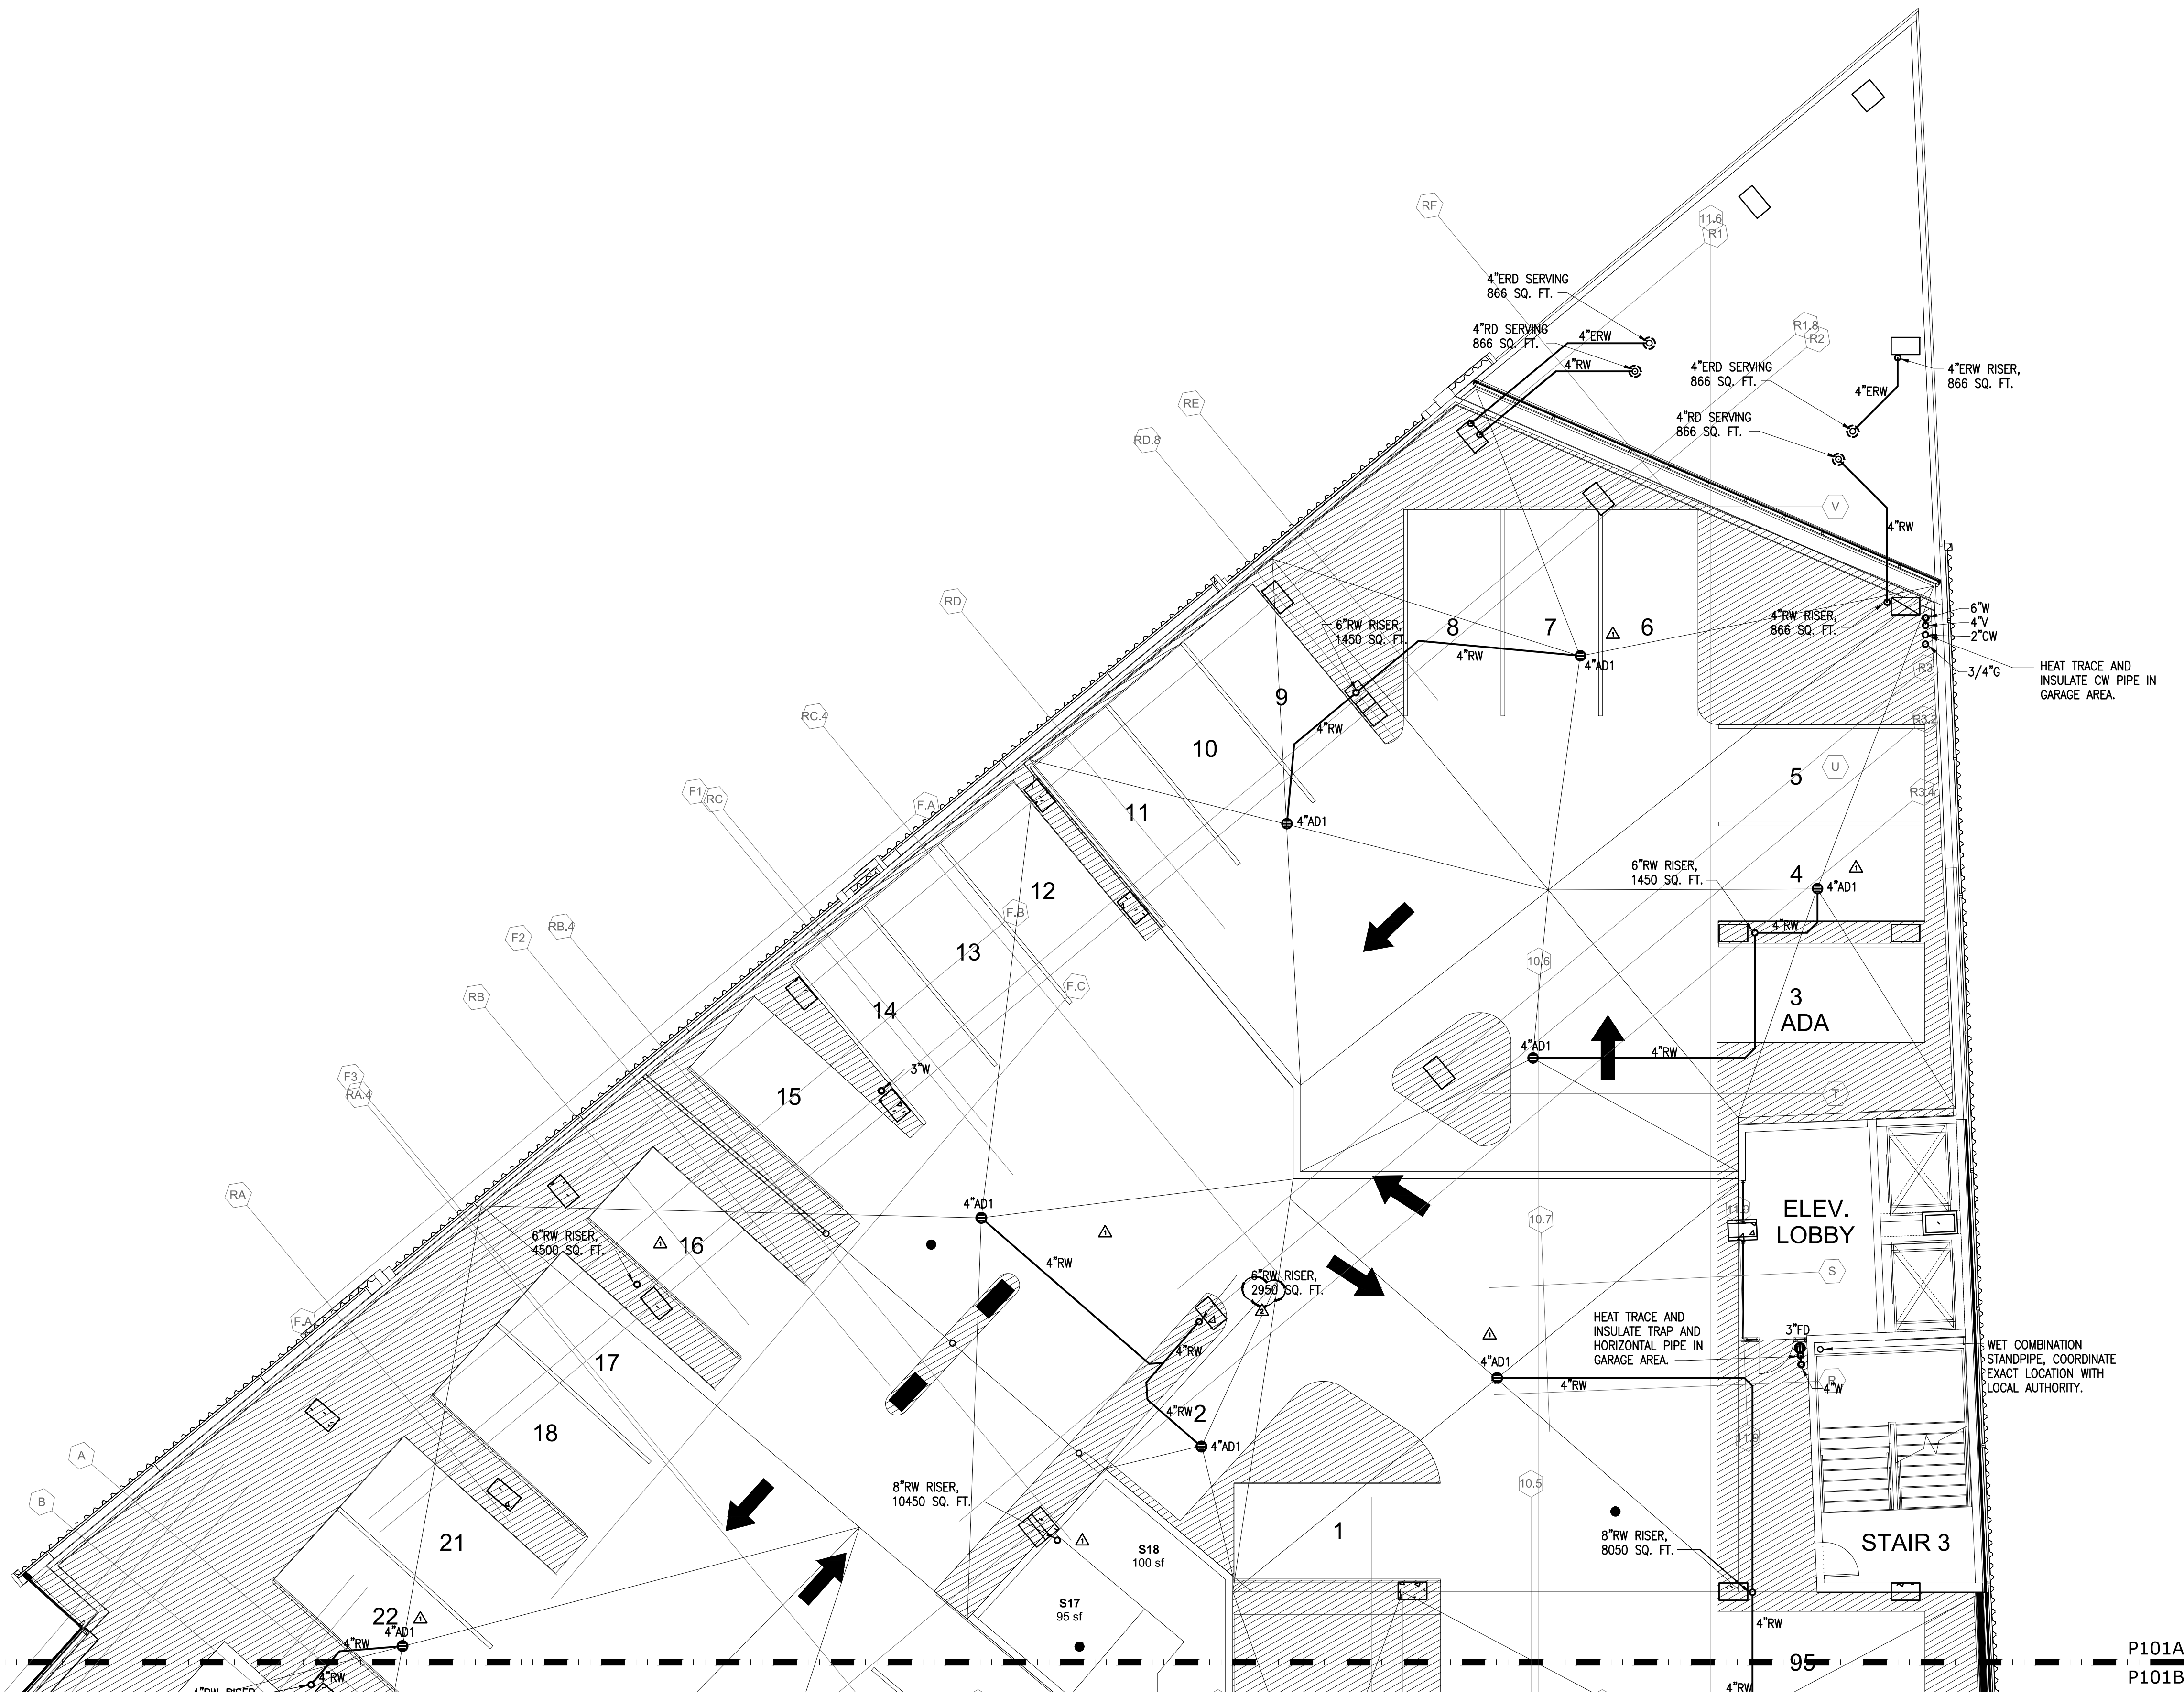

1 LEVEL P4 - FLOOR PLAN A
SCALE: 1/8" = 1'-0"

K
J
H
G
F
E
D
C
B
A

P101A
P101B

KEY PLAN

SEAL

JOB NAME

THE LOUDERMILK COMPANIES, LLC.

SHEET TITLE

LEVEL P4 FLOOR PLAN A

PHILLIPS GRADICK
ENGINEERING, P.C.

1001 Peachtree Road, Suite 1050
Atlanta, Georgia 30305
(404) 525-1350
www.phillipsgradick.com

REVISION:

AS-008 8/24/2017

Unless otherwise agreed to in writing, this document is the sole property of Lord Aeck Sargent and is to be returned upon demand. The information herein is confidential and may not be used or divulged without the written permission of Lord Aeck Sargent.

© 2015 Lord Aeck Sargent
LordAeckSargent.com

LORD
AECK
SARGENT

1 LEVEL P4 - FLOOR PLAN A
SCALE: 1/8" = 1'-0"

PROJECT NORTH

WET COMBINATION
STANDPIPE, COORDINATE
EXACT LOCATION WITH
LOCAL AUTHORITY.

08/24/17

ISSUE DATE

06/30/17

JOB NO.

10605-01

DWG. NO.

P104A

ISSUED FOR CONSTRUCTION

THE CHARLES CONDOMINIUMS

3107 PEACHTREE RD.
ATLANTA, GA 30305

SCALE (UNCL.)

1/8" = 1'-0"



PHILLIPS GRADICK
ENGINEERING, P.C.

1001 Peachtree Road, Suite 1050
Atlanta, Georgia 30305
(404) 525-1350
www.phillipsgradick.com

REVISION:


AS-008 8/24/2017

Unless otherwise agreed to in writing, this document is the sole property of Lord Aeck Sargent and is to be returned upon demand. The information herein is confidential and may not be used or divulged without the written permission of Lord Aeck Sargent.




© 2015 Lord Aeck Sargent
LordAeckSargent.com

LORD
AECK
SARGENT

K
J
H
G
F
E
D
C
B
A

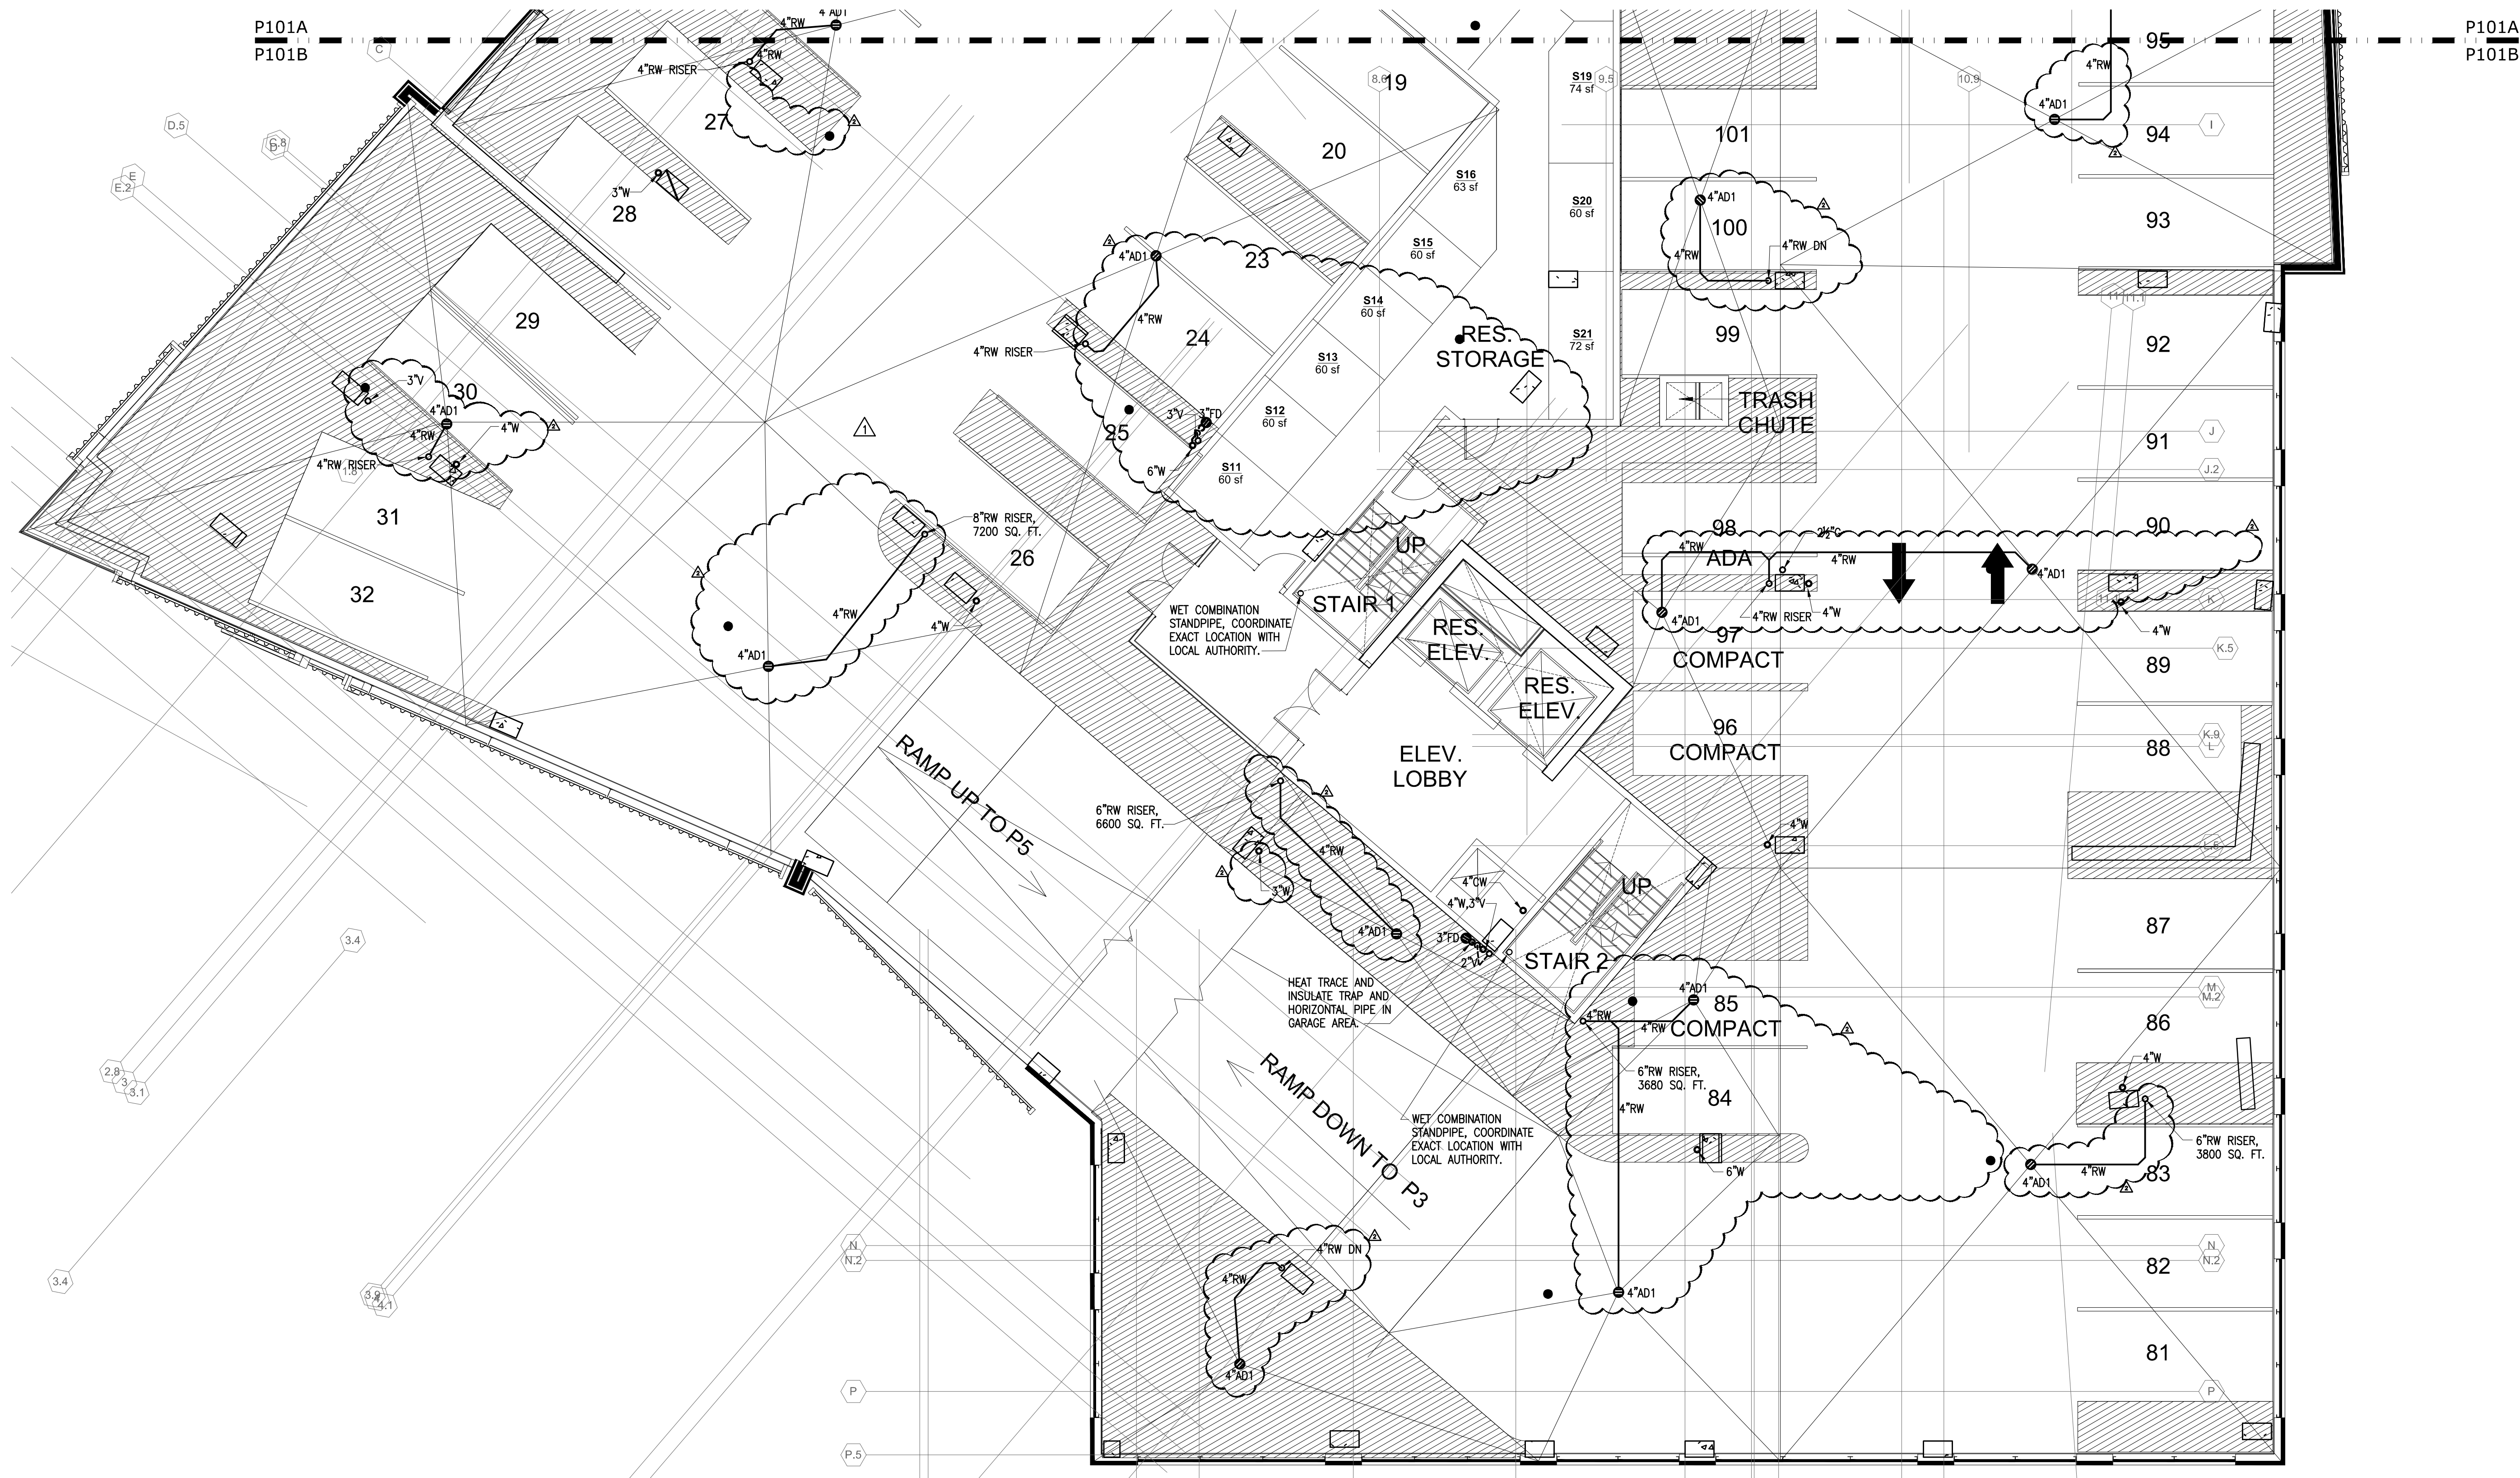

1 LEVEL P4 – FLOOR PLAN B
SCALE: 1/8" = 1'-0"

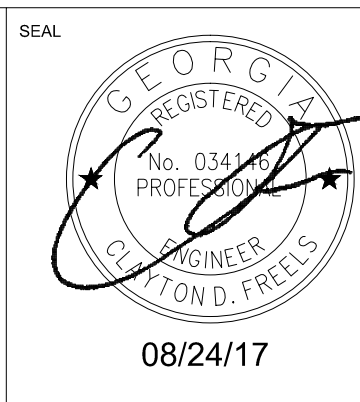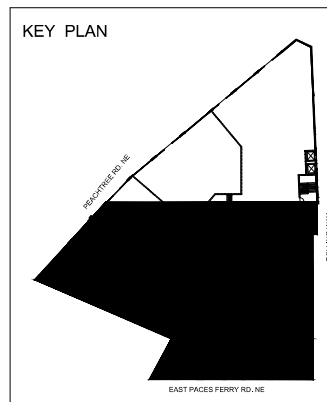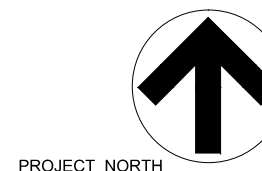

LORD AECK SARGENT

© 2015 Lord Aeck Sargent
LordAeckSargent.com

Unless otherwise agreed to in writing, this document is the sole property of Lord Aeck Sargent and is to be returned upon demand. The information herein is confidential and may not be used nor divulged without the written permission of Lord Aeck Sargent.

REVISION:
1 7/10/2017
2 8/24/2017

PHILLIPS GRADICK ENGINEERING, P.C.
500 Sugar Mill Rd.
Bldg. A Suite 105
Columbus, GA 31906
(770) 655-2843 (F)
(770) 655-2843 (C)
(770) 655-2843 (T)

PHILLIPS GRADICK ENGINEERING, P.C. shall not be responsible for any errors or omissions in this drawing or any other documents prepared by or for Phillips Gradick Engineering, P.C. This drawing is copyrighted and its reproduction, publication or use in any way without the written permission of Phillips Gradick Engineering, P.C. is prohibited. Unpublished use of these data without the express written permission of Phillips Gradick Engineering, P.C. is prohibited.

SHEET TITLE
LEVEL P4 FLOOR PLAN B

SCALE (UNITS)
1/8" = 1'-0"

JOB NAME
THE LOUDERMILK COMPANIES, LLC.

JOB NO.
106005-01

DWG. NO.
P104B


ISSUE DATE
06/30/17

LOCATION
**THE CHARLES CONDOMINIUMS
3107 PEACHTREE RD.
ATLANTA, GA 30305**

ISSUED FOR CONSTRUCTION

Unless otherwise agreed to in writing, this document is the sole property of Lord Aeck Sargent and is to be returned upon demand. The information herein is confidential and may not be used nor divulged without the written permission of Lord Aeck Sargent

REVISION:	
1	ASI-006 8/24/2017
2	ASI-013 10/06/2017

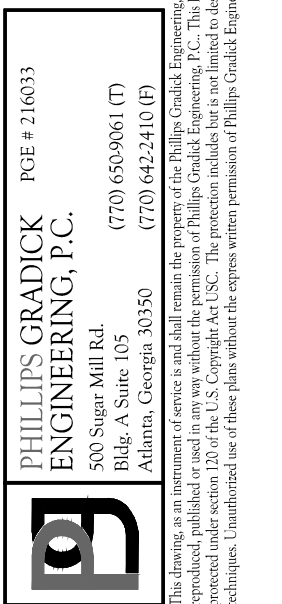


SHEET TITLE

LEVEL P5 FLOOR PLAN A



JOB NAME	THE LOUDERMILK COMPANIES, LLC.
LOCATION	THE CHARLES CONDOMINIUMS 3107 PEACHTREE RD. ATLANTA, GA 30305

P105A


ISSUED FOR CONSTRUCTION

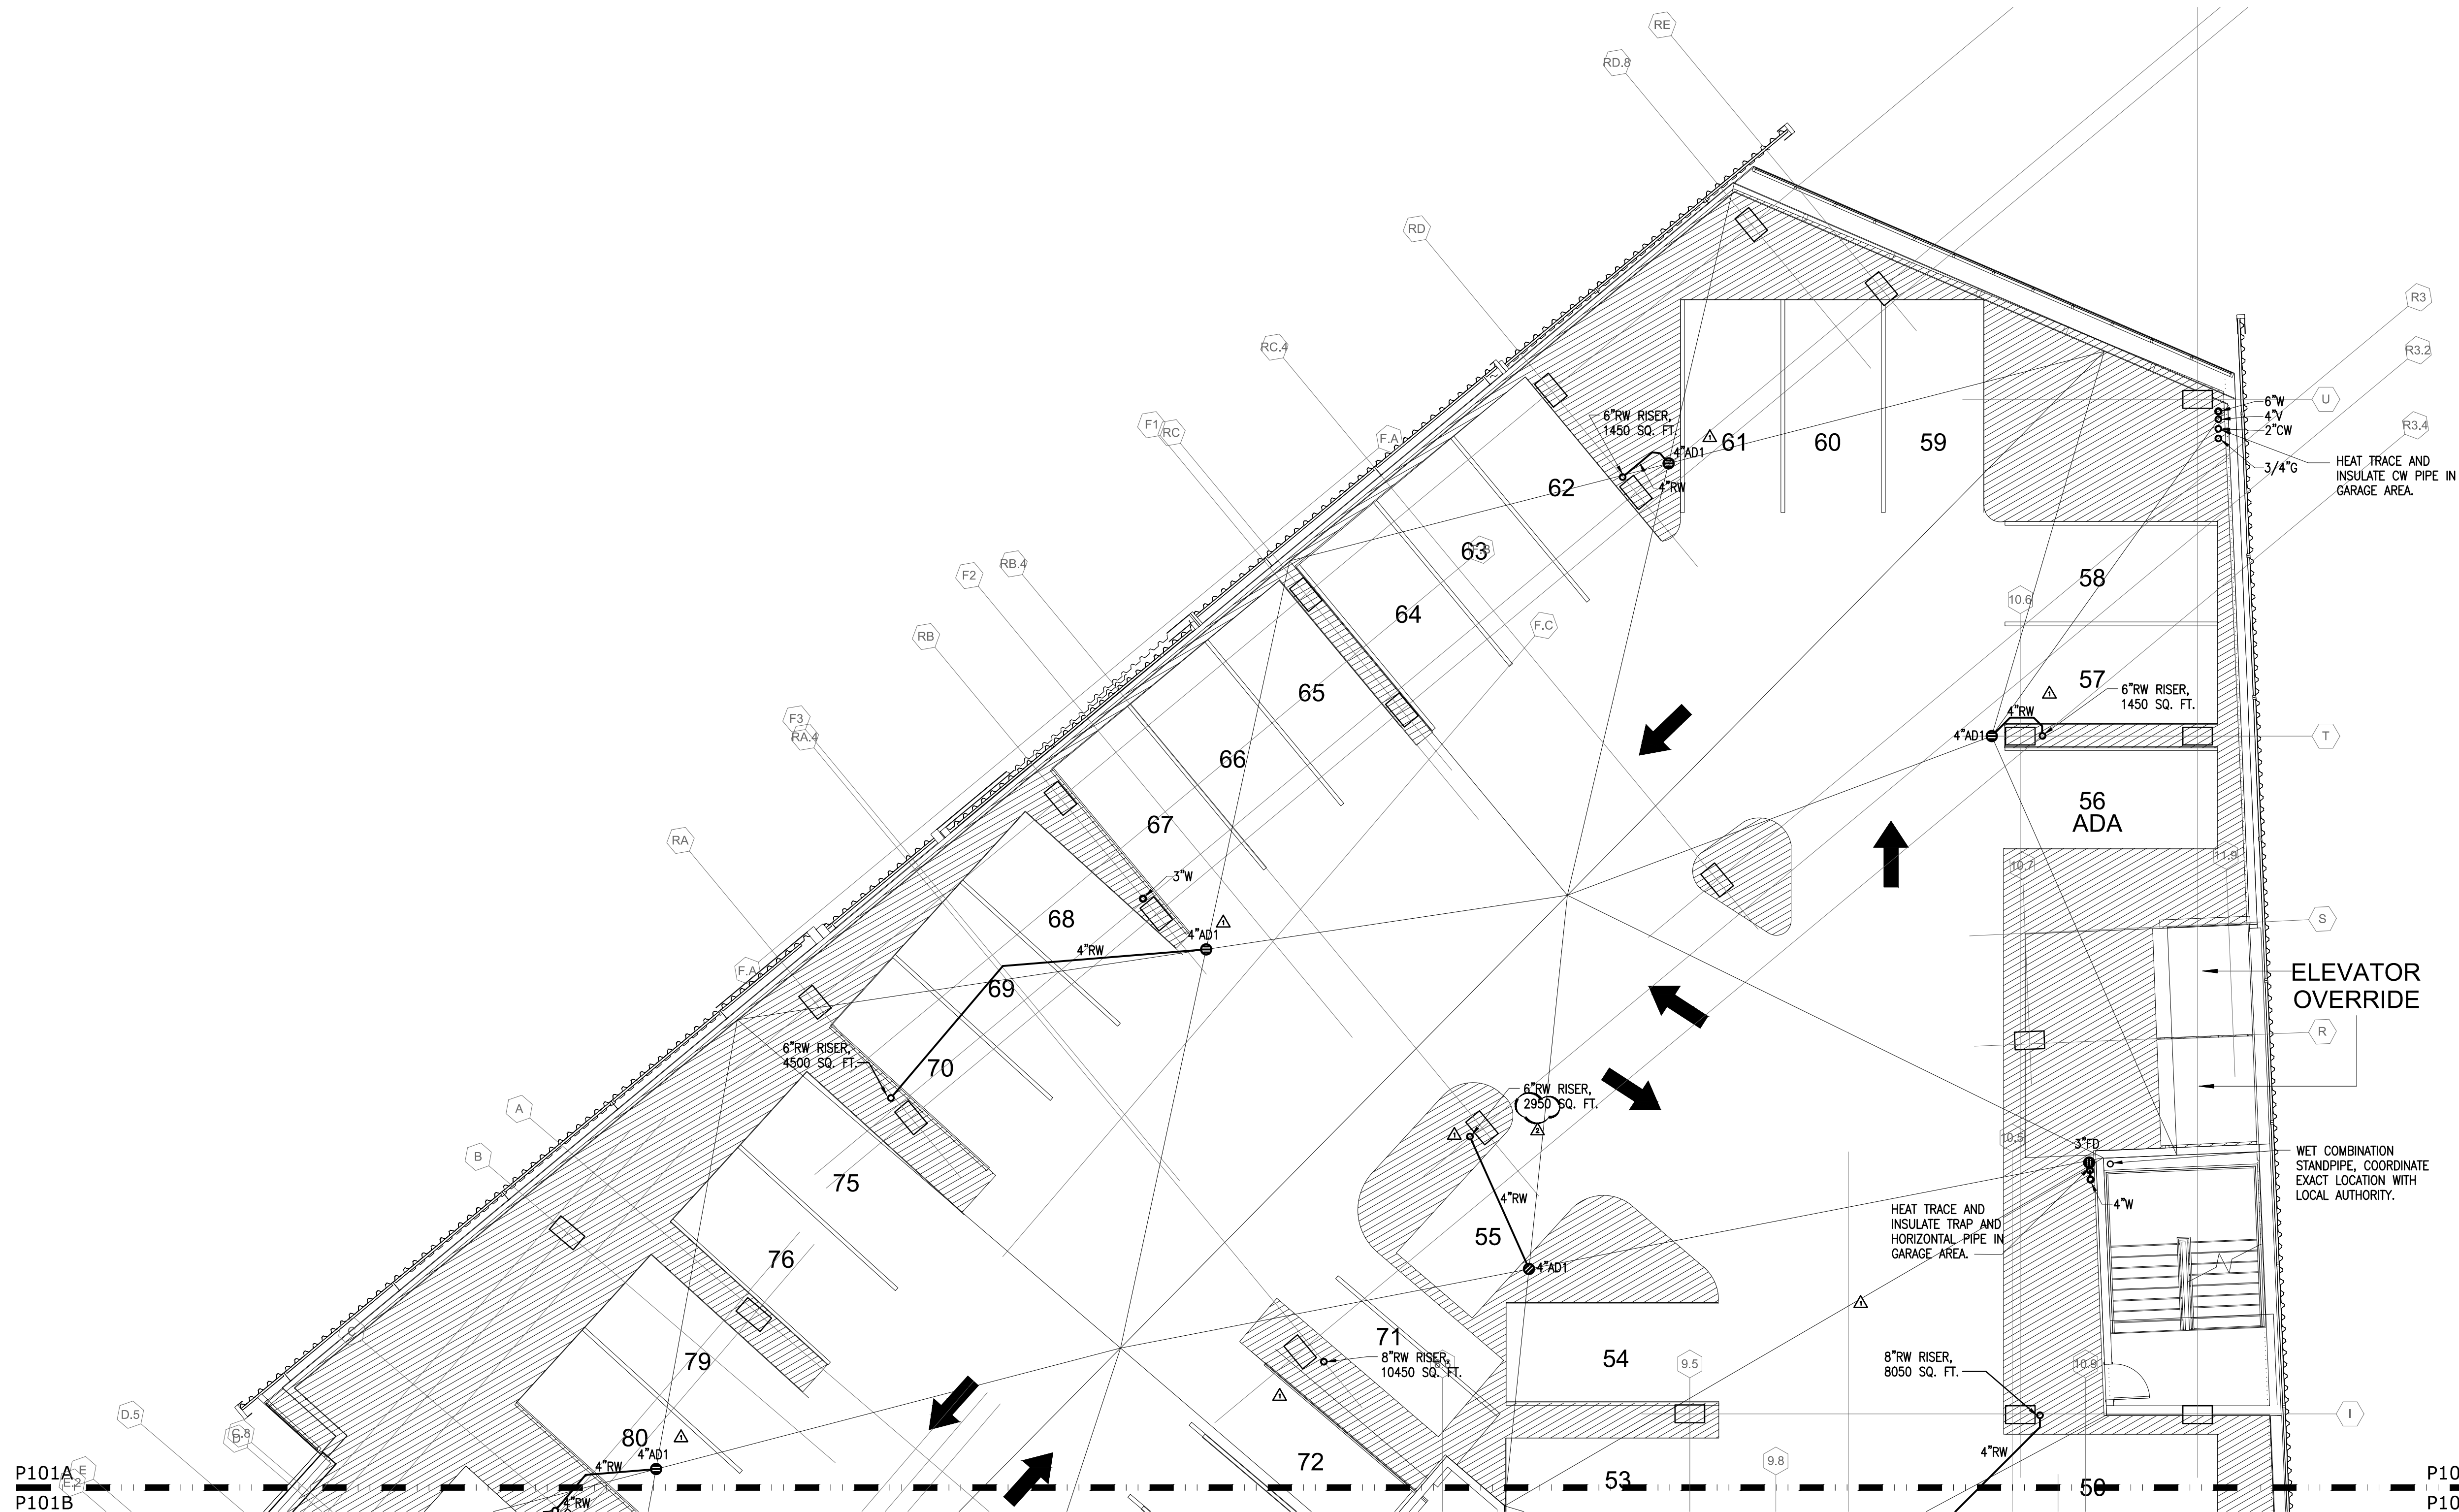




1 LEVEL P5 – FLOOR PLAN A
SCALE: 1/8" = 1'-0"

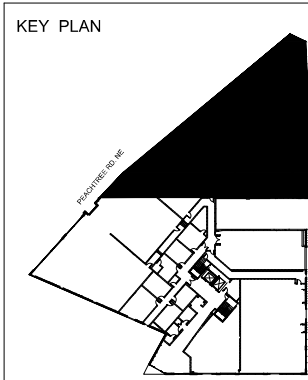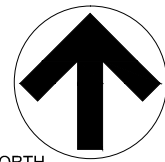

K
J
H
G
F
E
D
C
B
A

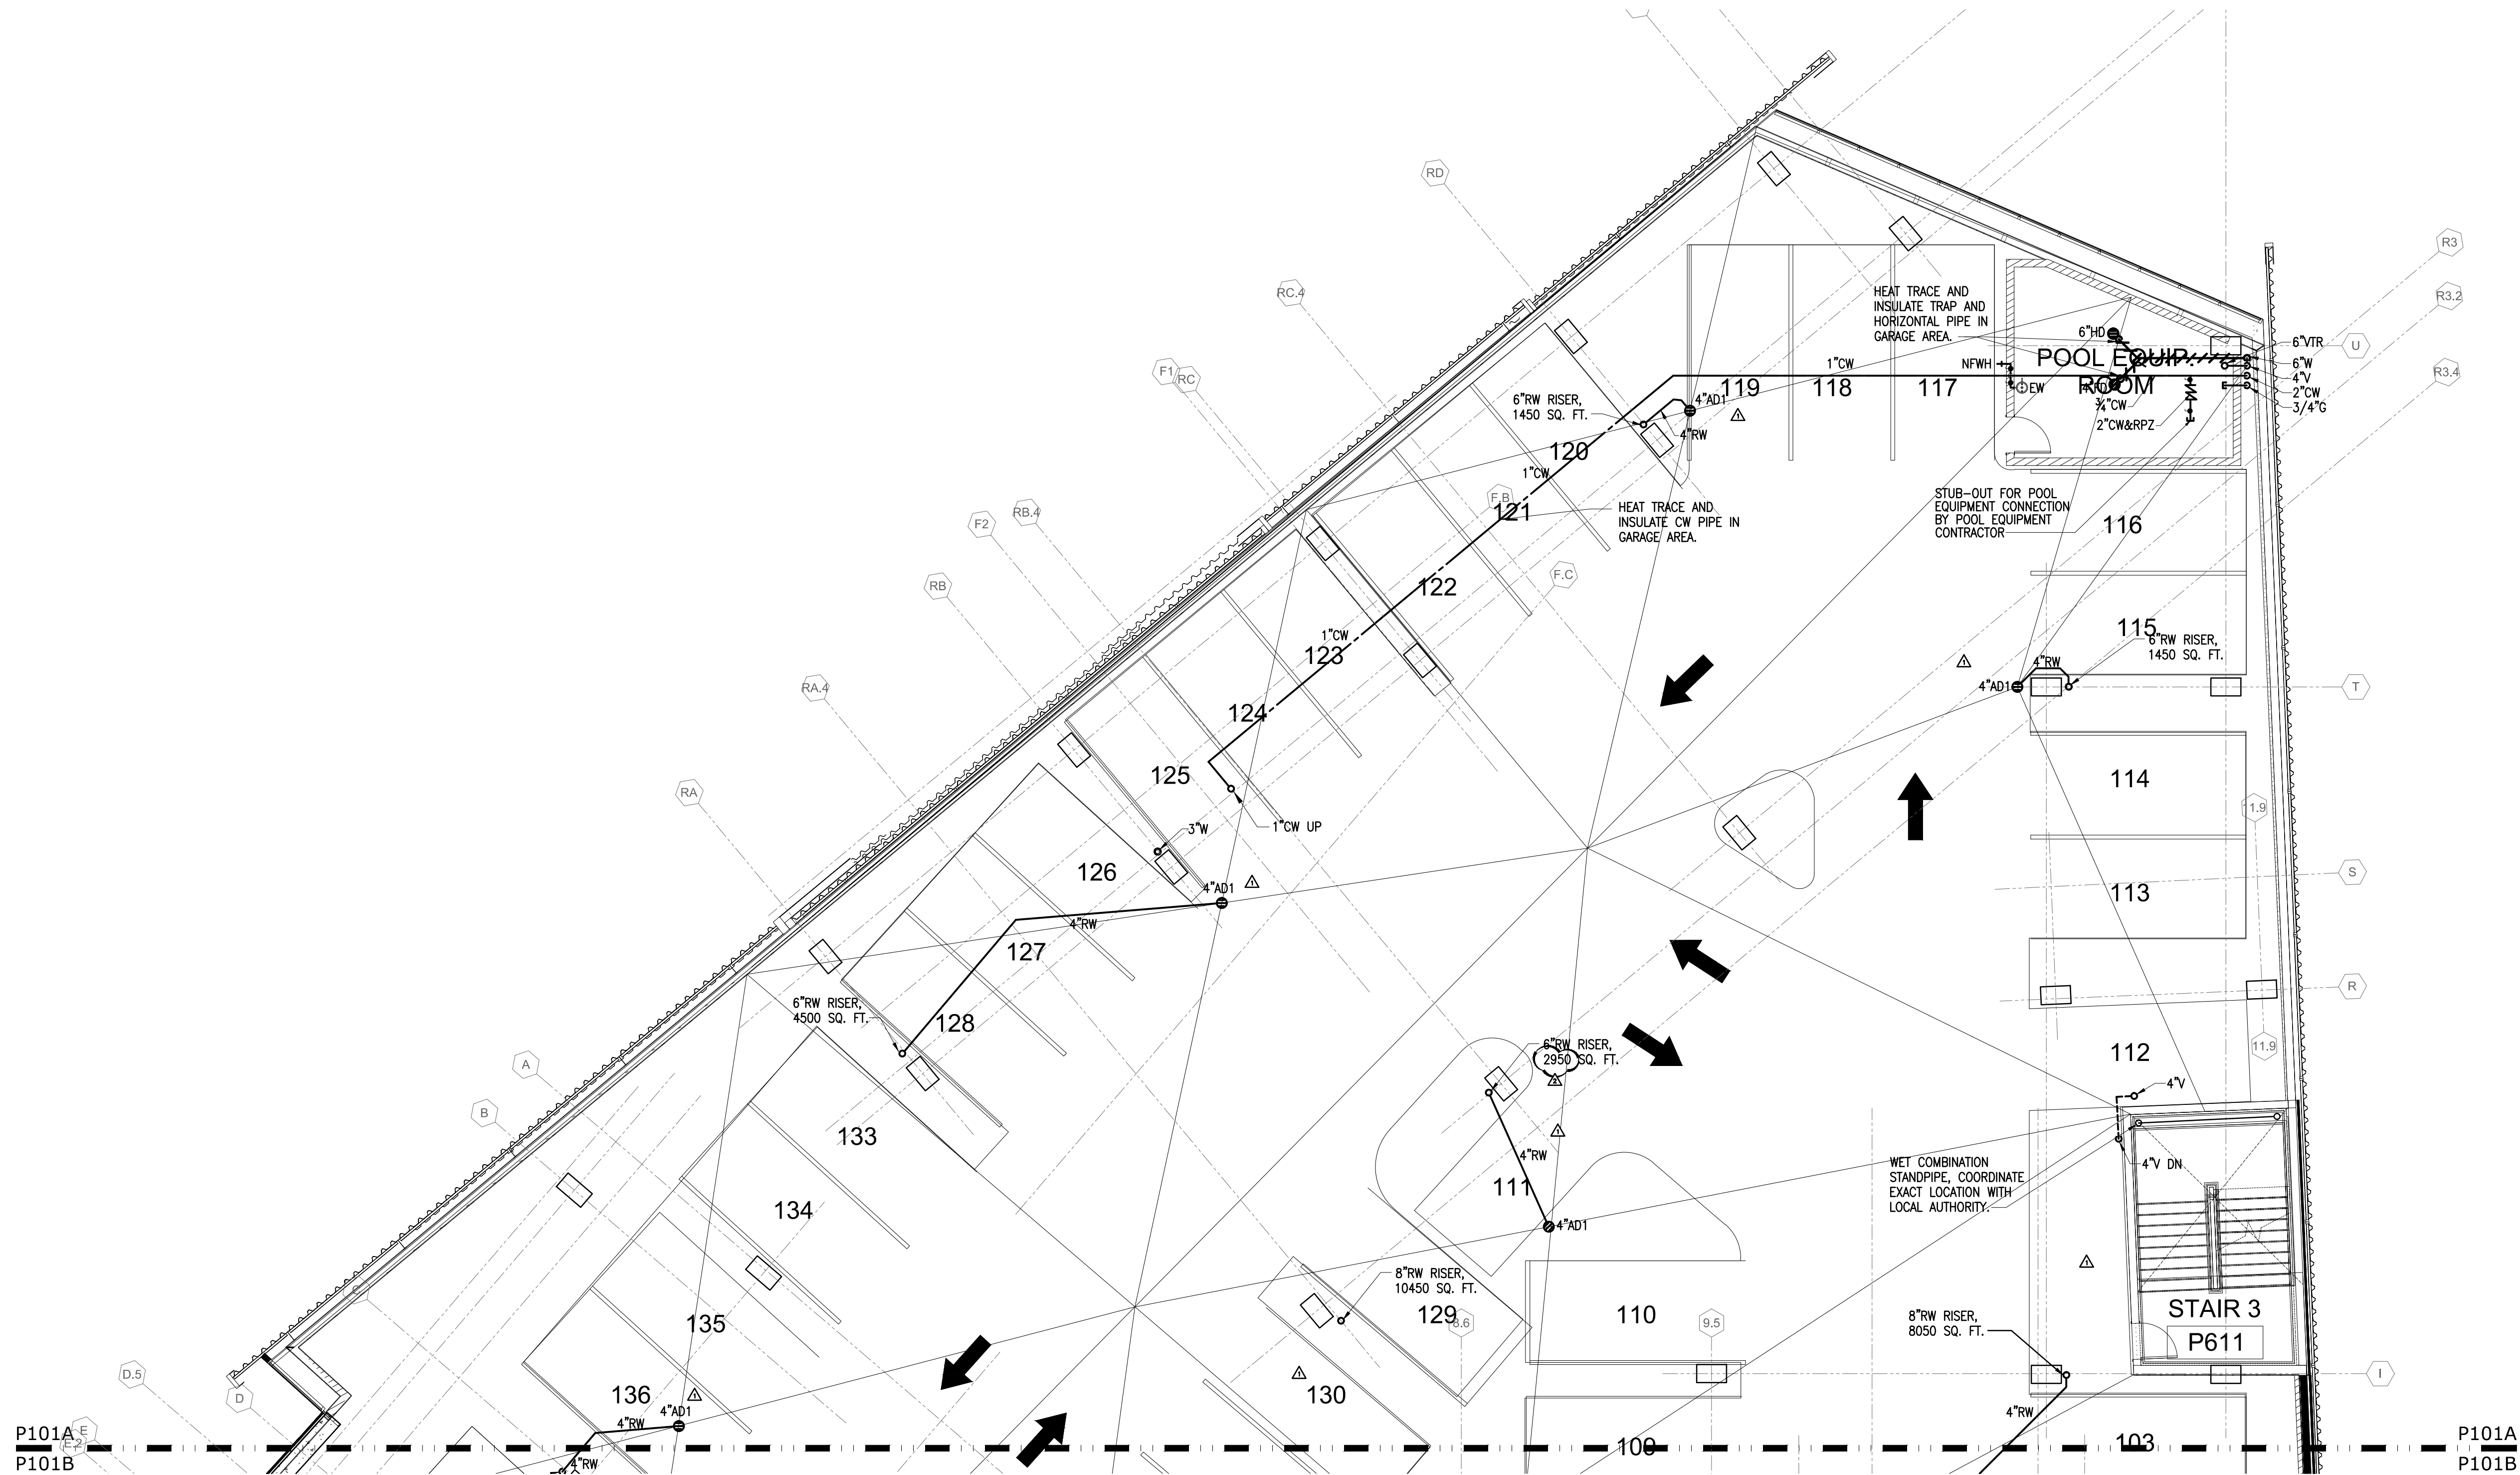

1 LEVEL P6 – FLOOR PLAN A
SCALE: 1/8" = 1'-0"

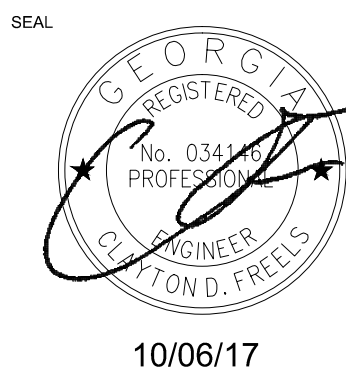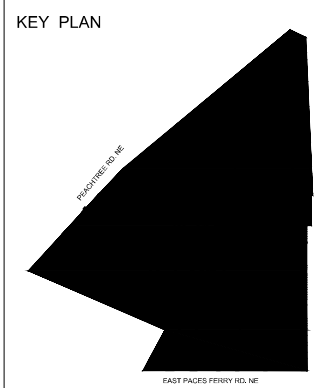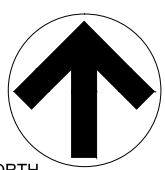

LORD AECK SARGENT

© 2015 Lord Aeck Sargent
LordAeckSargent.com

Unless otherwise agreed to in writing, this document is the sole property of Lord Aeck Sargent and is to be returned upon demand. The information herein is confidential and may not be used nor divulged without the written permission of Lord Aeck Sargent.

REVISION:	
AS-006	8/24/2017
AS-013	10/06/2017

PHILLIPS GRADICK ENGINEERING, P.C.
500 Sugar Mill Rd.
Bldg. A, Suite 103
Cobb County, GA 30006
(770) 455-9861 (T)
(770) 455-9862 (F)
(770) 455-9863 (C)

Small text: This drawing, as well as all other documents created by or for Phillips Gradick Engineering, P.C., and all other documents created by or for Phillips Gradick Engineering, P.C., are the property of Phillips Gradick Engineering, P.C. and shall remain the property of Phillips Gradick Engineering, P.C. No part of this drawing may be reproduced, stored in a retrieval system, or transmitted in any form or by any means, electronic, mechanical, photocopying, recording, or by any information storage and retrieval system, without the prior written permission of Phillips Gradick Engineering, P.C. This drawing is prepared and published in accordance with the provisions of the Professional Engineering Act of 1992, as amended, and the rules and regulations of the Board of Professional Engineers of the State of Georgia. Unpublished use of these plans without the express written permission of Phillips Gradick Engineering, P.C., is prohibited.

SHEET TITLE
LEVEL P6 FLOOR PLAN A

SCALE (INCH)
1/8" = 1'-0"

JOB NAME
THE LOUDERMILK COMPANIES, LLC.


JOB NO.
10605-01

LOCATION
**THE CHARLES CONDOMINIUMS
3107 PEACHTREE RD.
ATLANTA, GA 30305**




ISSUE DATE
06/30/17

DWG. NO.
P106A

ISSUED FOR CONSTRUCTION

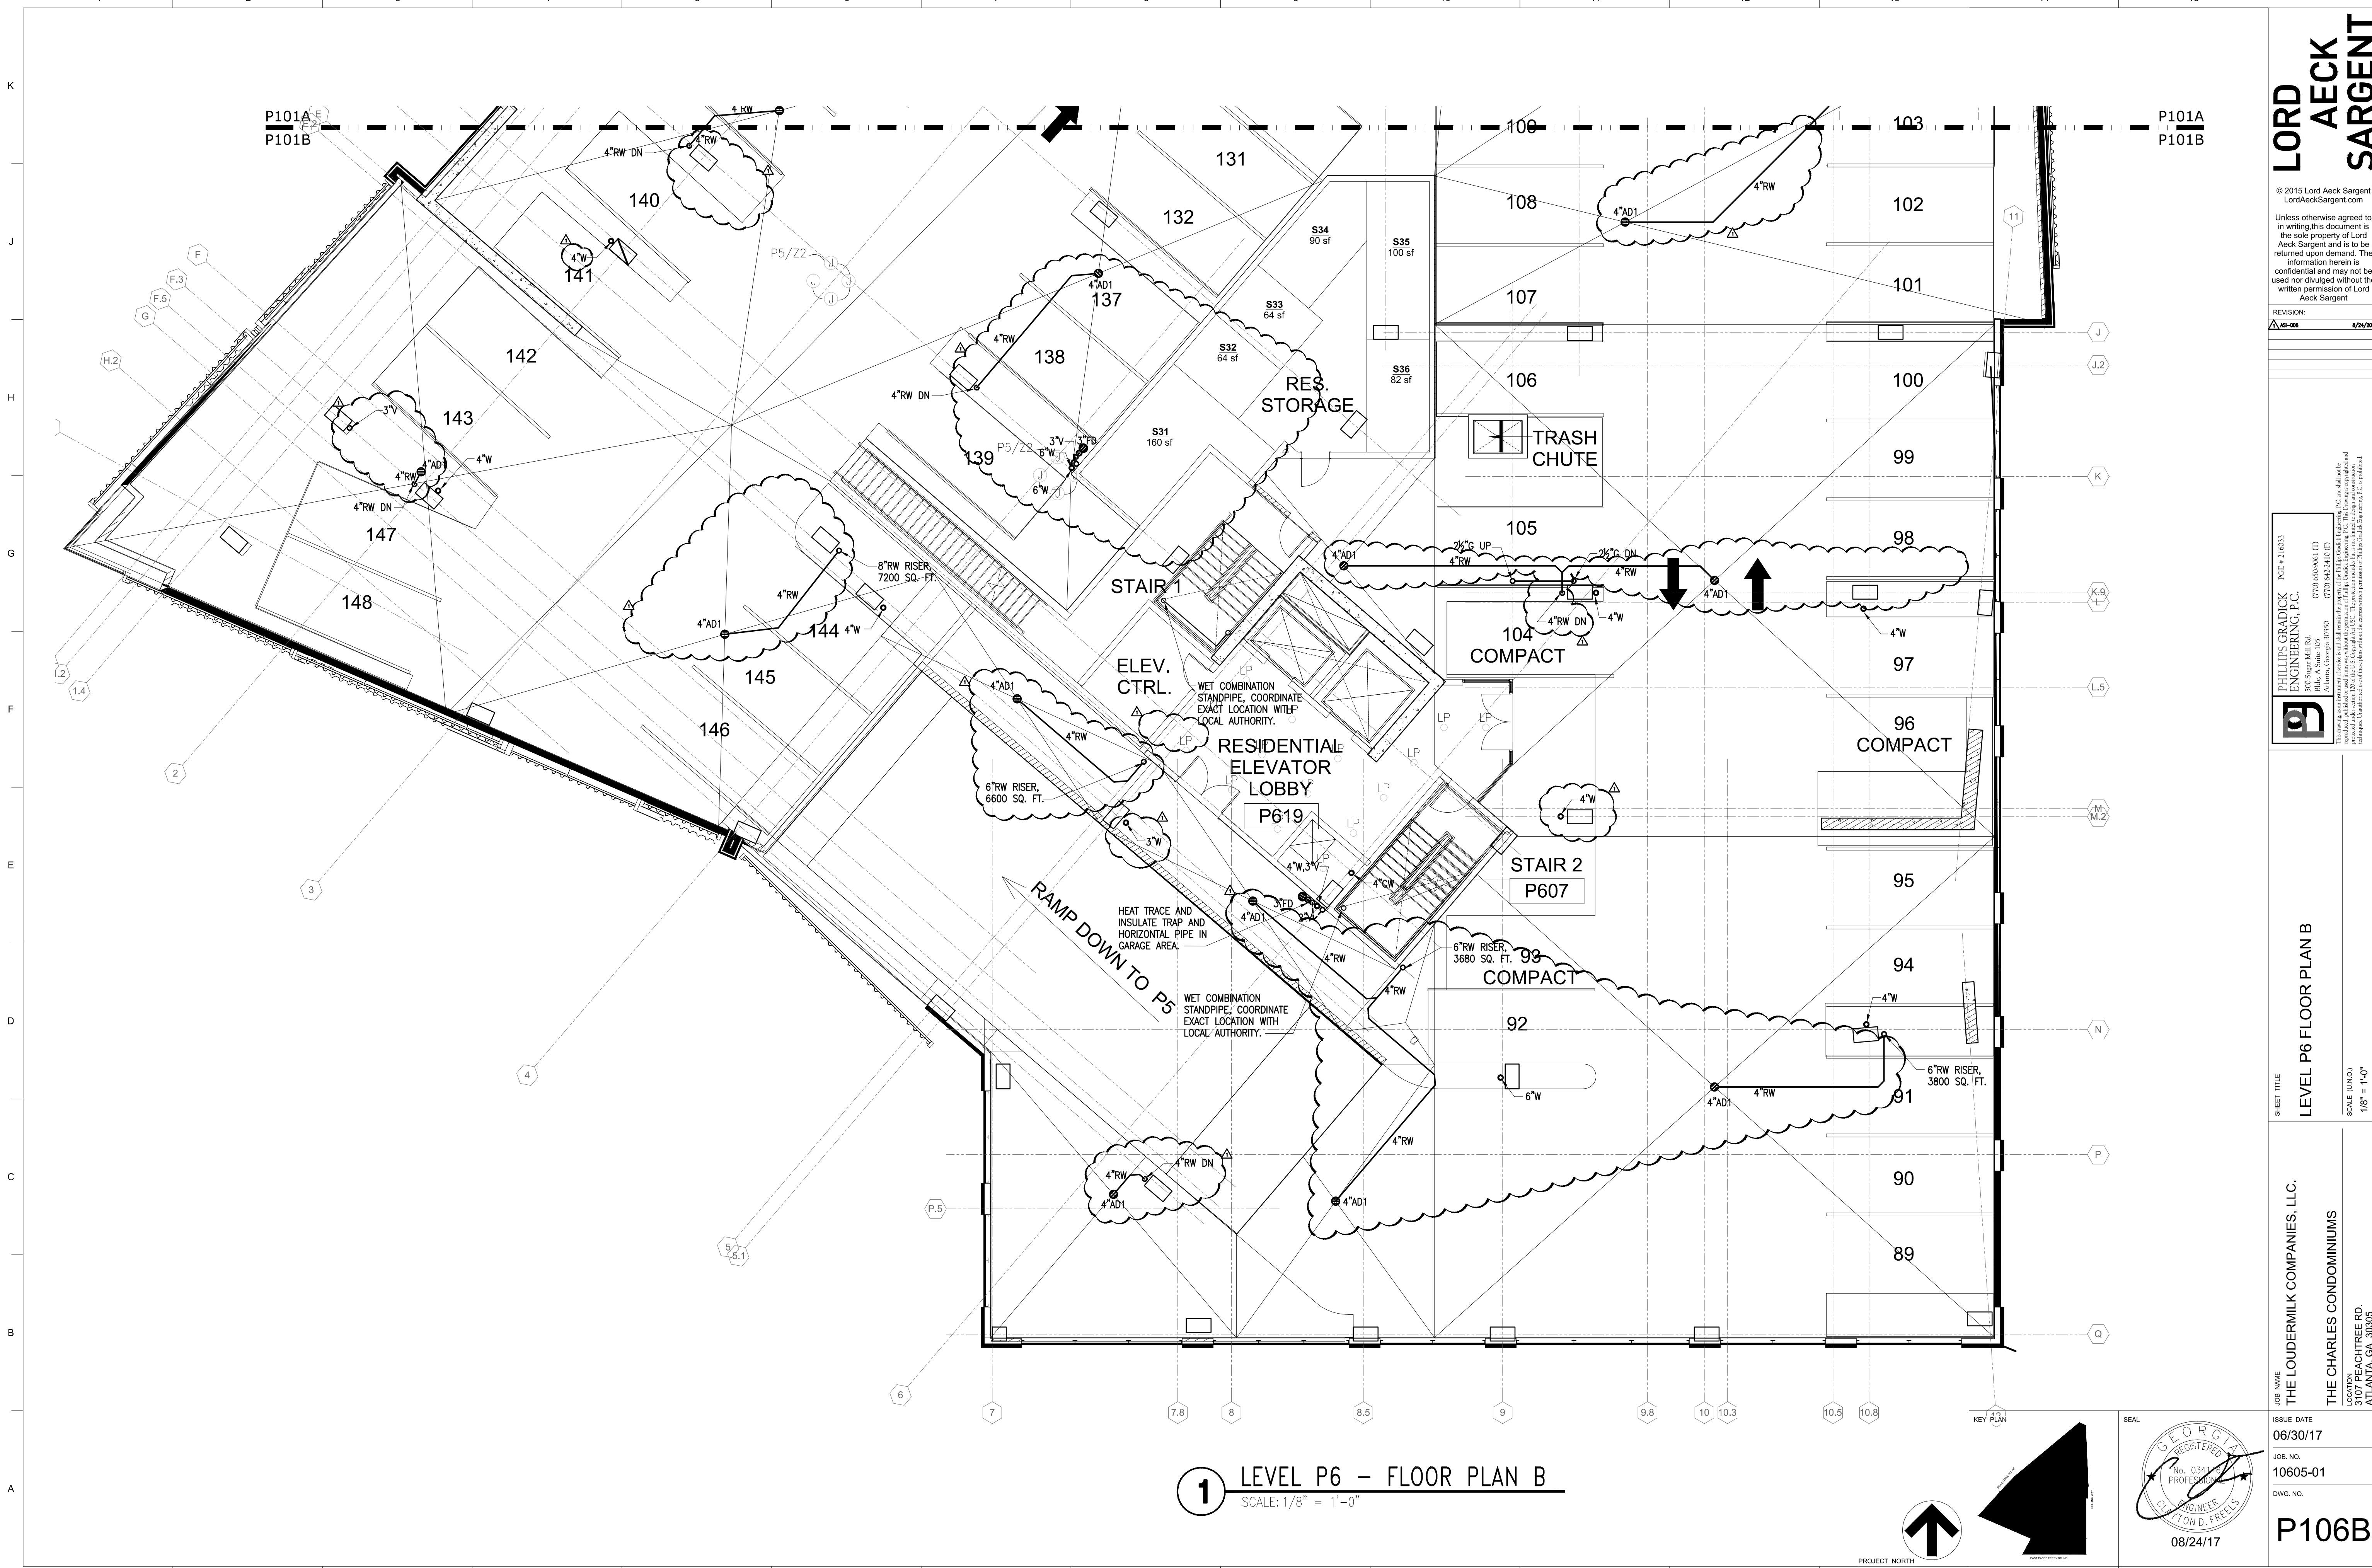

1 LEVEL P6 – FLOOR PLAN B
SCALE: 1/8" = 1'-0"

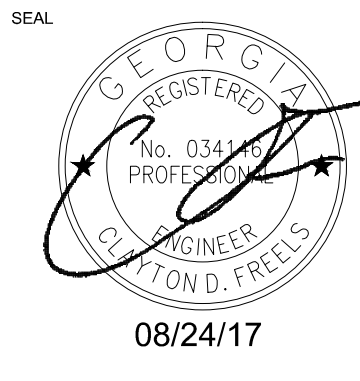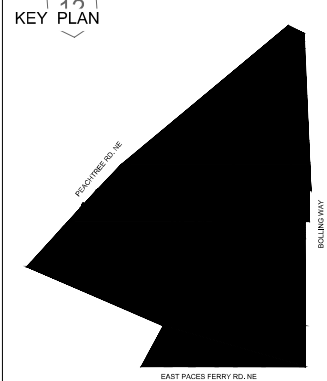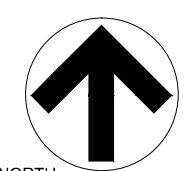


LORD AECK SARGENT © 2015 Lord Aeck Sargent LordAeckSargent.com Unless otherwise agreed to in writing this document is the sole property of Lord Aeck Sargent and is to be returned upon demand. The information herein is confidential and may not be used nor divulged without the written permission of Lord Aeck Sargent.	
REVISION:	8/24/2017
PHILLIPS GRADICK ENGINEERING, P.C. P.O. #216033 300 Sugar Mill Rd. Atlanta, Georgia 30350 (770) 650-0061 (T) (770) 642-2410 (F) This drawing is an instrument of service and shall remain the property of Phillips Graddock Engineering, P.C. and shall not be reproduced, copied, or transmitted in any form or by any means, electronic or mechanical, including photocopying, recording, or by any information storage and retrieval system, without the prior written permission of Phillips Graddock Engineering, P.C. is prohibited.	
SHEET TITLE LEVEL P6 FLOOR PLAN B	
JOB NAME THE LOUDERMILK COMPANIES, LLC. THE CHARLES CONDOMINIUMS LOCATION 3107 PEACHTREE RD. ATLANTA, GA 30305	
ISSUE DATE 06/30/17	JOB NO. 10605-01
DWG. NO. P106B	


ISSUED FOR CONSTRUCTION

08/24/17

K
J
H
G
F
E
D
C
B
A

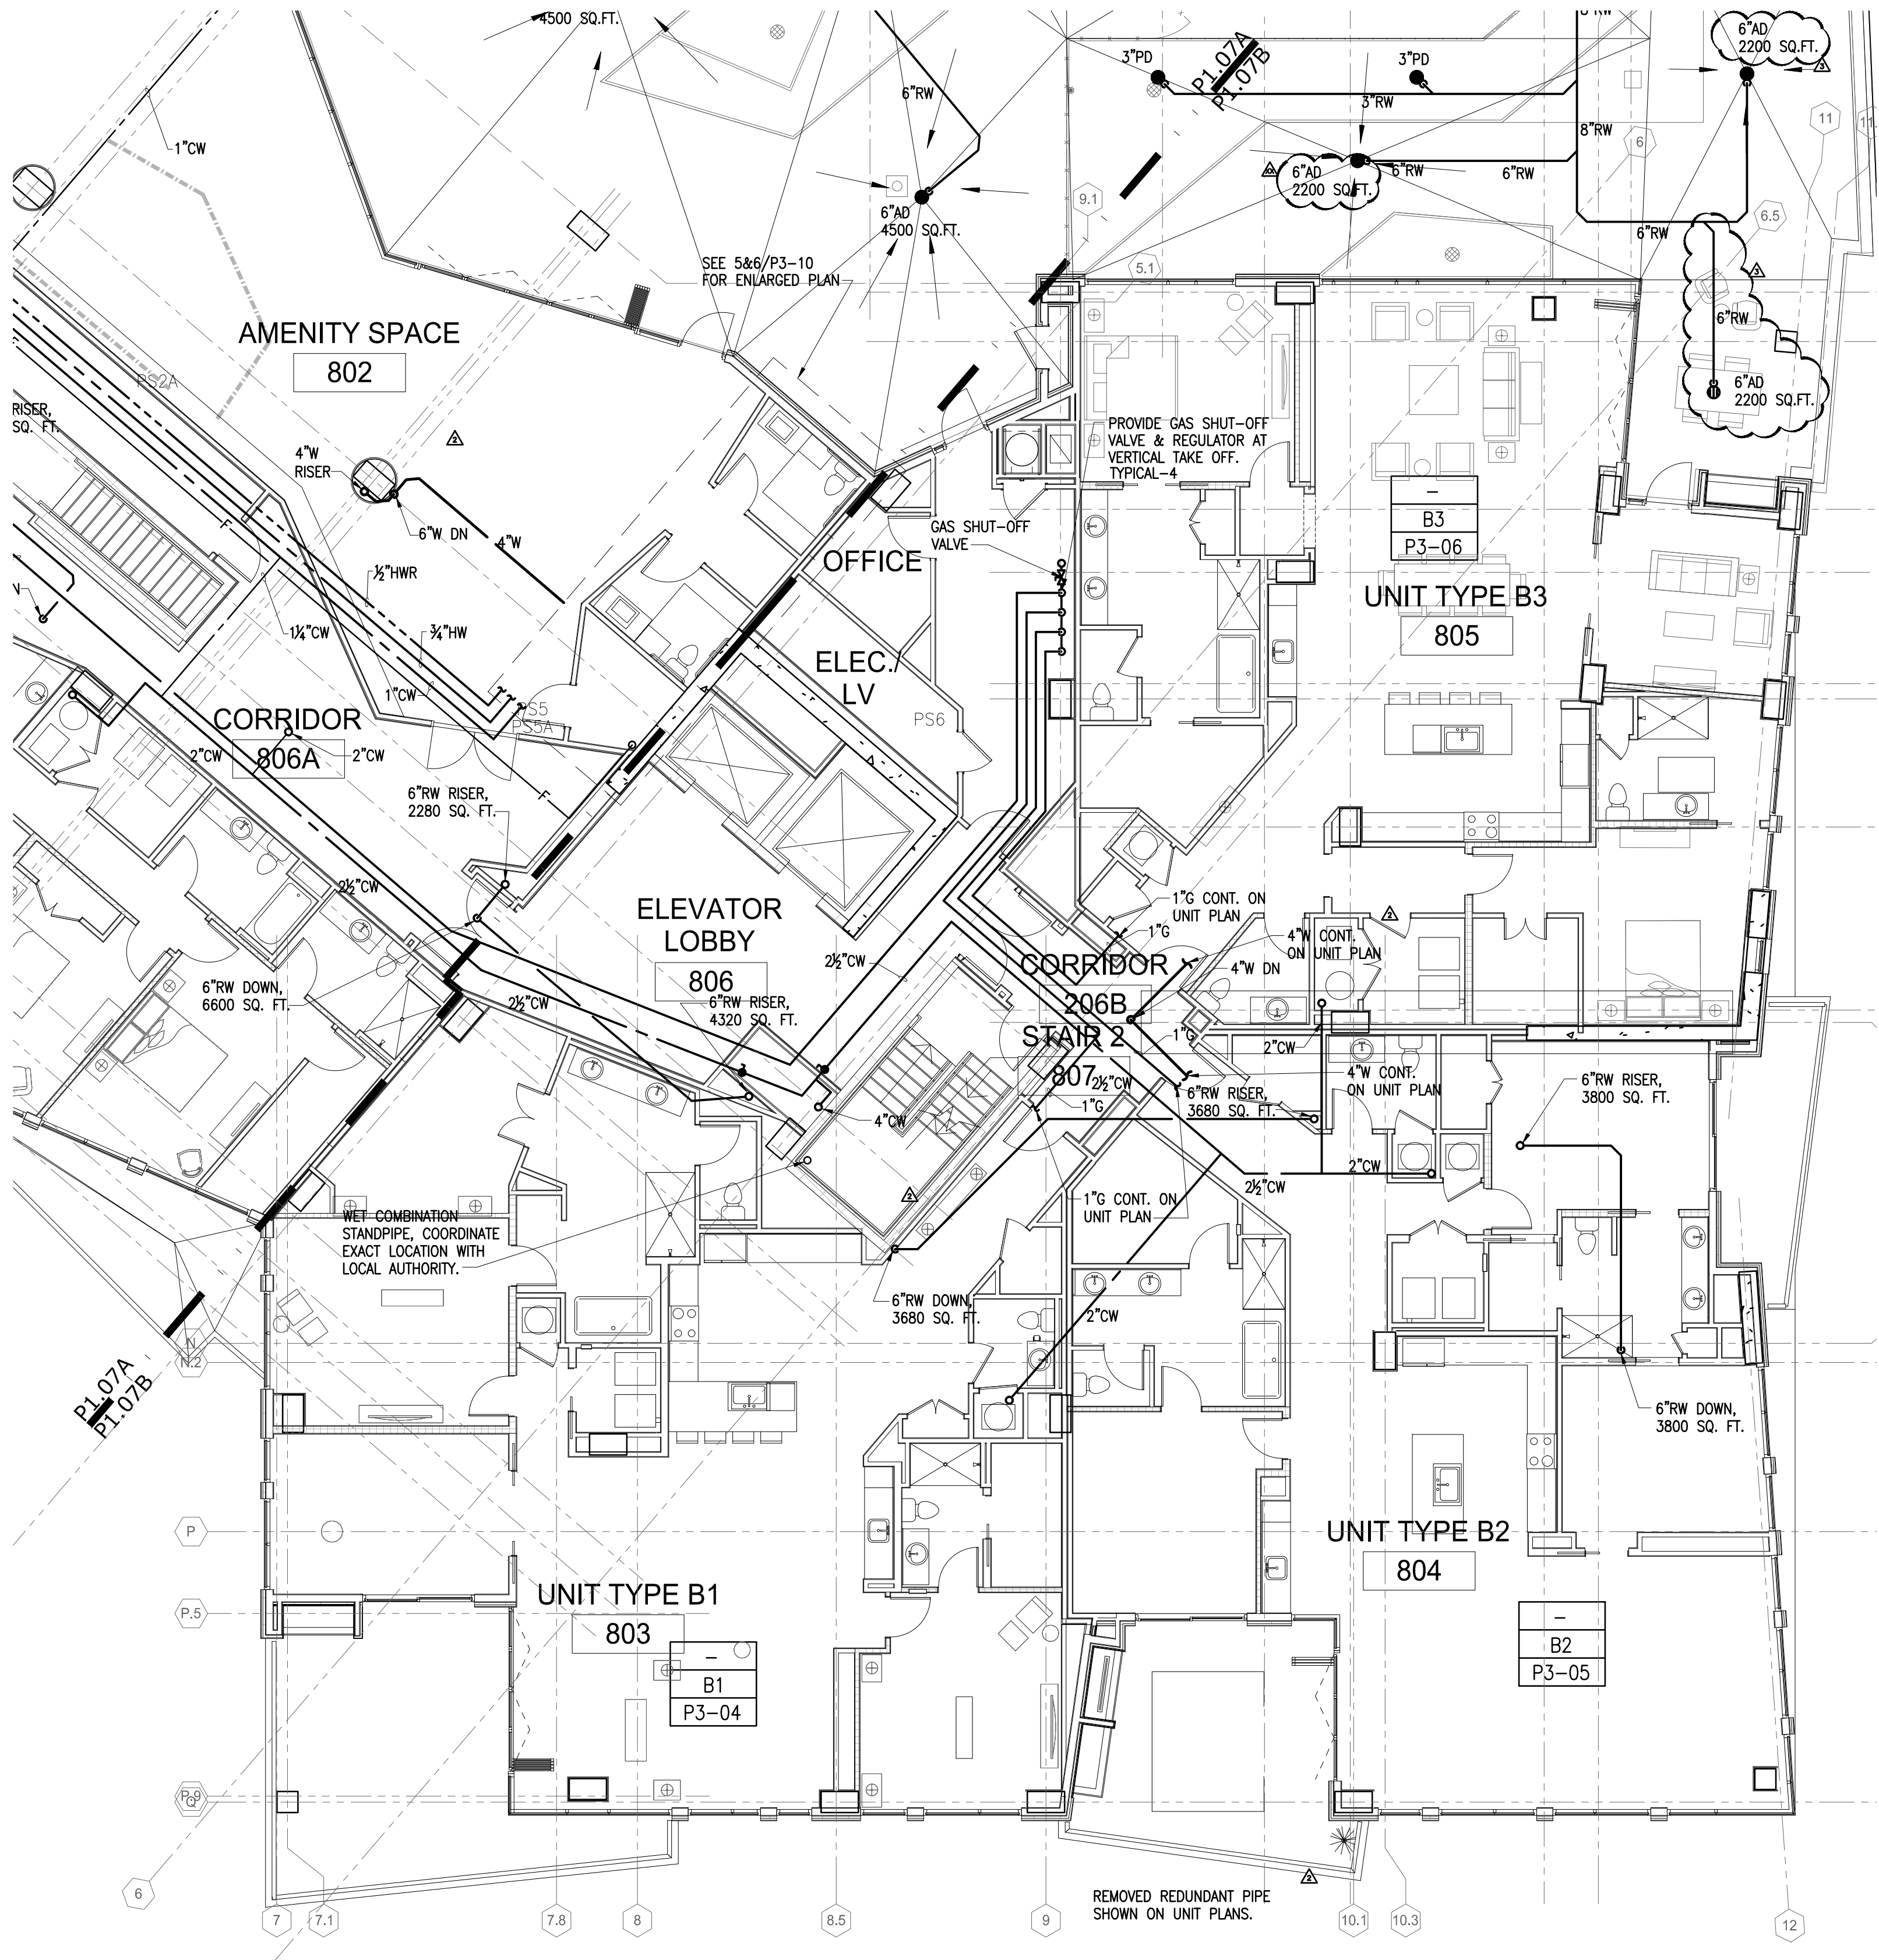

1 LEVEL 8 - FLOOR PLAN B
SCALE: 1/8" = 1'-0"

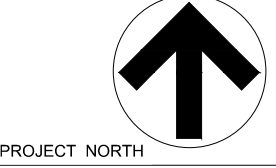

KEY PLAN	SEAL
JOB NAME THE LOUDERMILK COMPANIES, LLC.	
ISSUE DATE 06/30/17	
JOB NO. 10605-01	
DWS. NO.	
P108B	
LOCATION THE CHARLES CONDOMINIUMS 3107 PEACHTREE RD. ATLANTA, GA 30305	
SCALE (UNCL.) 1/8" = 1'-0"	

LORD AECK SARGENT

© 2015 Lord Aeck Sargent
LordAeckSargent.com

Unless otherwise agreed to in writing, this document is the sole property of Lord Aeck Sargent and is to be returned upon demand. The information herein is confidential and may not be used nor divulged without the written permission of Lord Aeck Sargent.

REVISION:	
CONSTRUCTION SET	6/29/2017
AS-006	6/24/2017
AS-013	10/06/2017

PHILLIPS GRADICK ENGINEERING, P.C.
PGE # 216033
1000 Peachtree Street, N.E.
Atlanta, Georgia 30309
(404) 525-1350
Fax: (404) 525-1351
www.phillipsgradick.com

PHILLIPS GRADICK ENGINEERING, P.C. is a professional engineering firm registered in the State of Georgia. The firm is not responsible for the design or construction of any project unless it is specifically stated on the drawings. The firm is not responsible for the design or construction of any project unless it is specifically stated on the drawings. The firm is not responsible for the design or construction of any project unless it is specifically stated on the drawings.

SHEET TITLE
LEVEL 8 FLOOR PLAN B

SCALE (UNCL.)
1/8" = 1'-0"

JOB NAME
THE LOUDERMILK COMPANIES, LLC.

ISSUE DATE
06/30/17


JOB NO.
10605-01

DWS. NO.


P108B

ISSUED FOR CONSTRUCTION

K
J
H
G
F
E
D
C
B
A

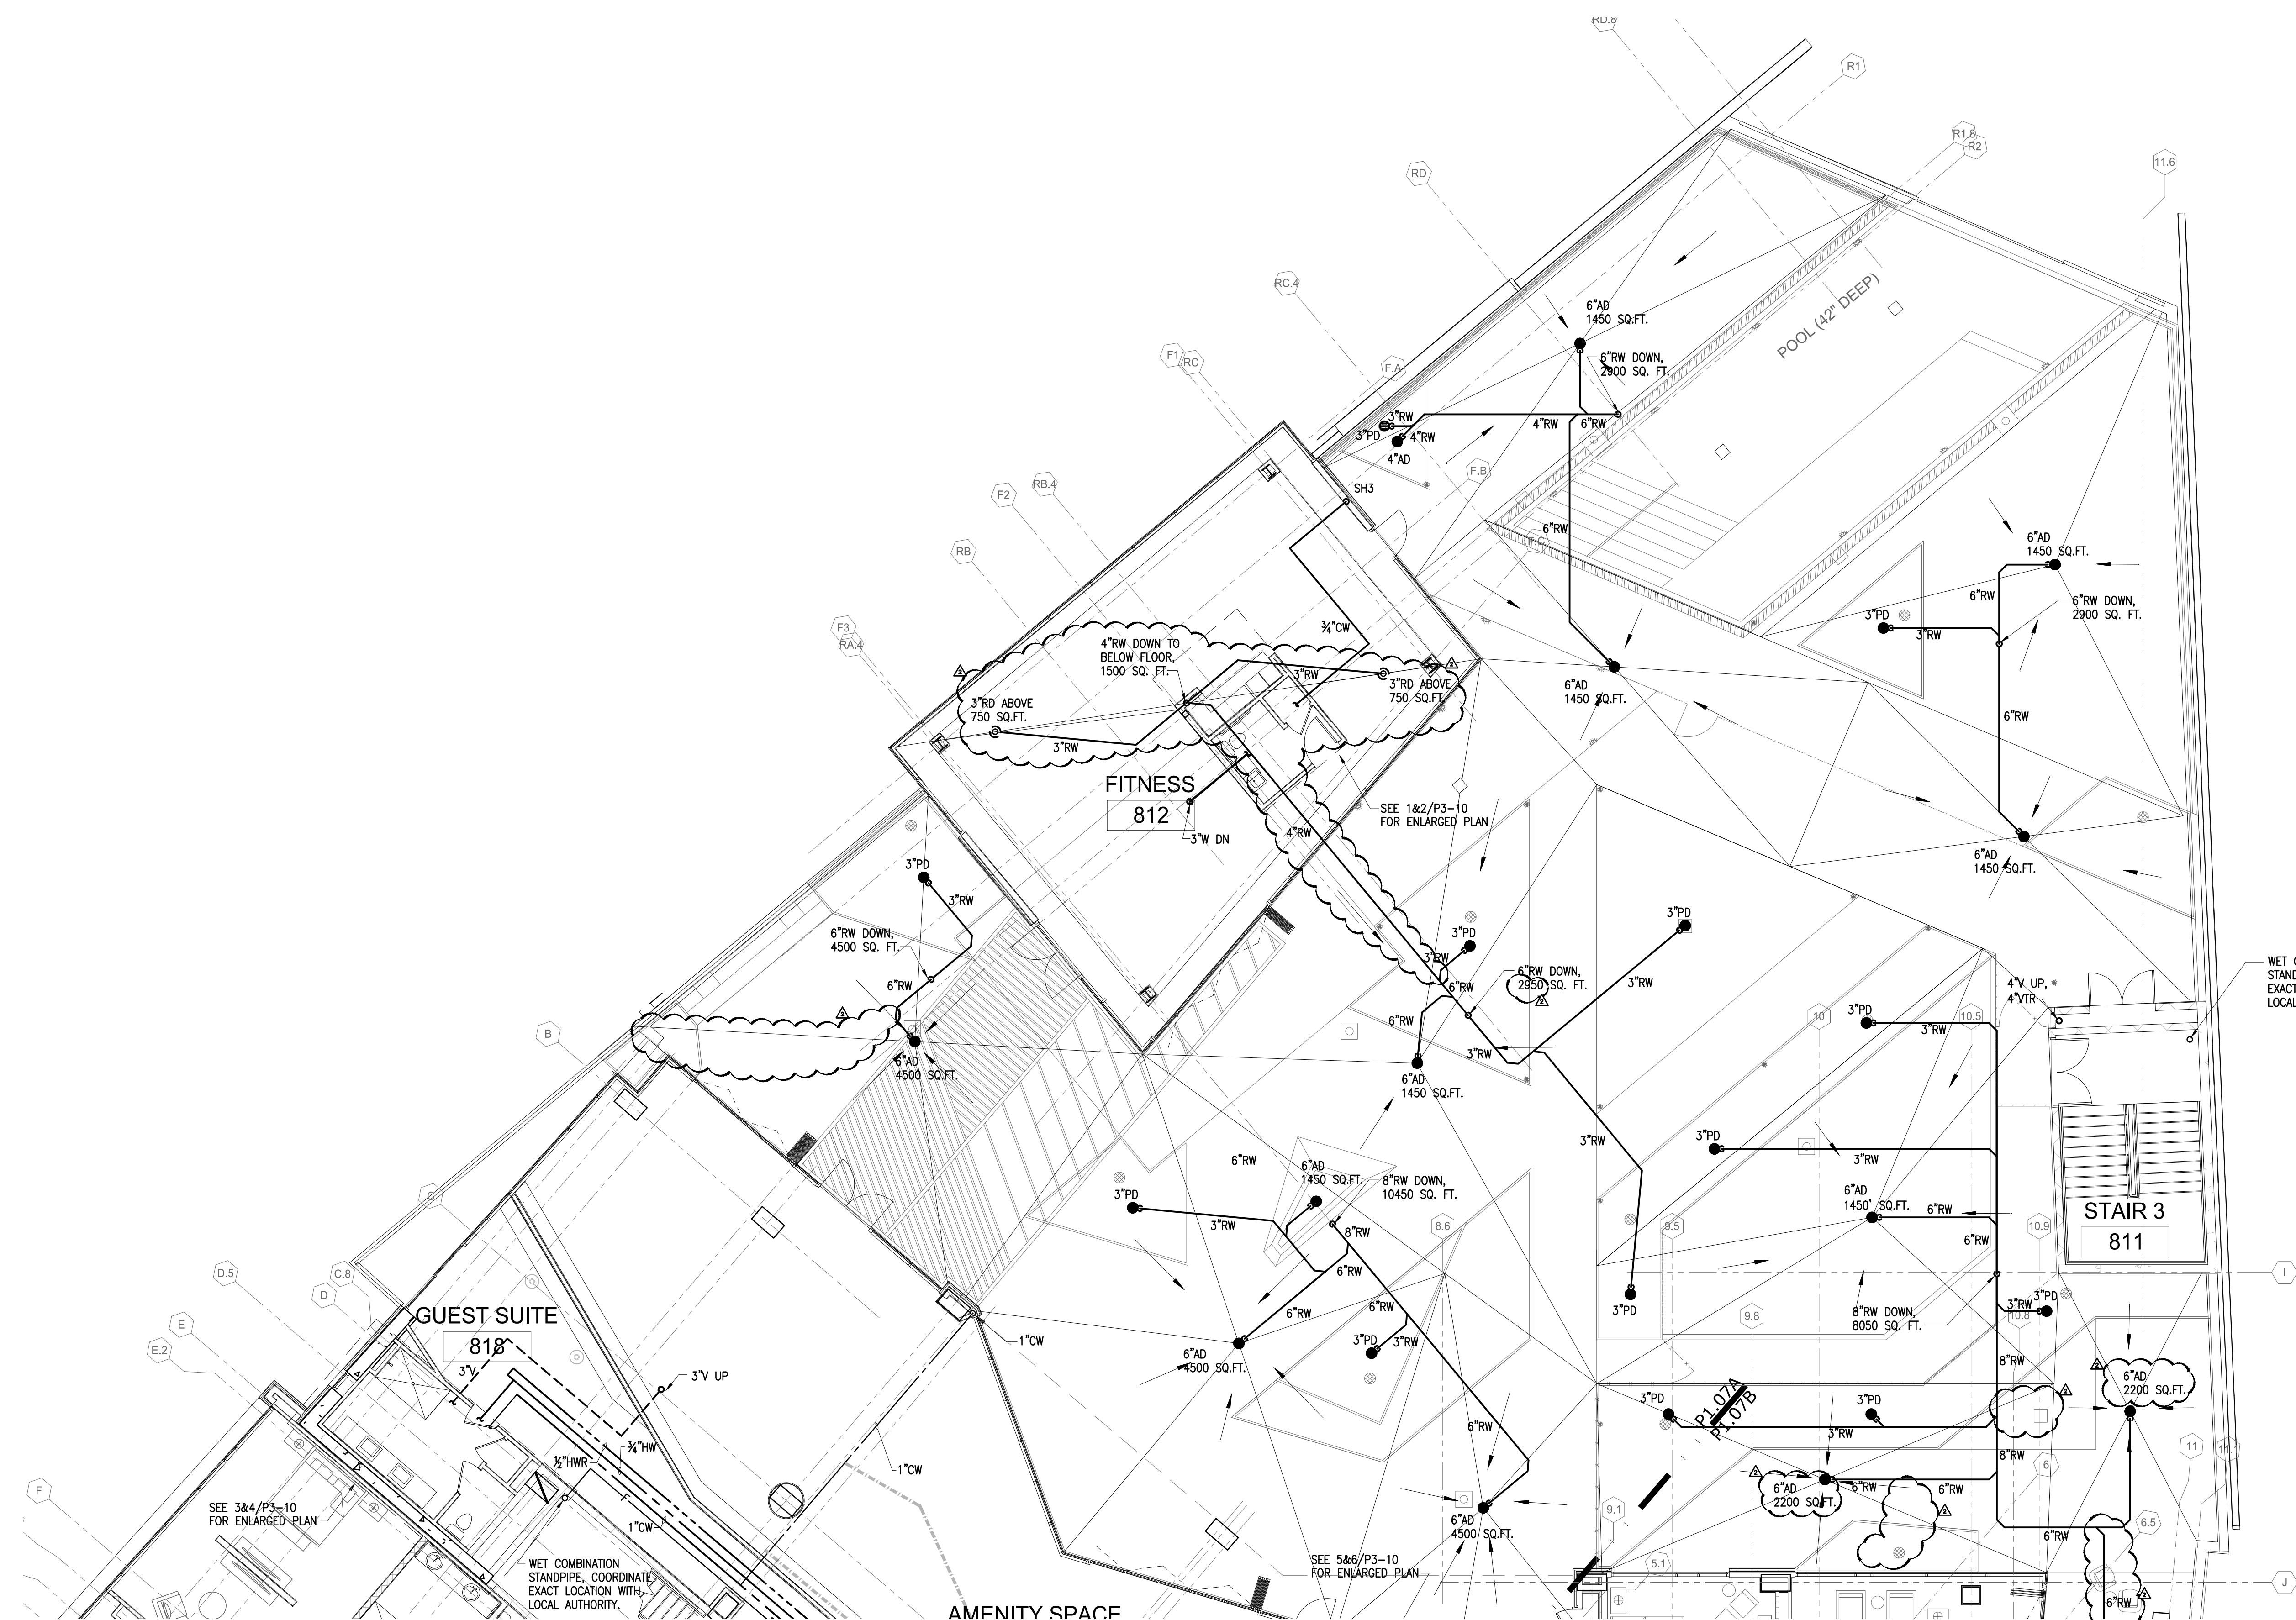

1 LEVEL 8 – FLOOR PLAN C
SCALE: 1/8" = 1'-0"

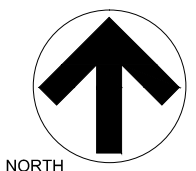

KEY PLAN

SEAL



JOB NAME
THE LOUDERMILK COMPANIES, LLC.

ISSUE DATE
06/30/17

JOB NO.
10605-01

DWG. NO.
P108C

LOCATION
**THE CHARLES CONDOMINIUMS
3107 PEACHTREE RD.
ATLANTA, GA 30305**

SHEET TITLE
LEVEL 8 FLOOR PLAN C

SCALE (UNCL.)
1/8" = 1'-0"



REVISION:
CONSTRUCTION SET 6/29/2017
48-013 10/06/2017


© 2015 Lord Aeck Sargent
LordAeckSargent.com

Unless otherwise agreed to in writing, this document is the sole property of Lord Aeck Sargent and is to be returned upon demand. The information herein is confidential and may not be used nor divulged without the written permission of Lord Aeck Sargent.

**LORD
AECK
SARGENT**

ISSUED FOR CONSTRUCTION

K
J
H
G
F
E
D
C
B
A

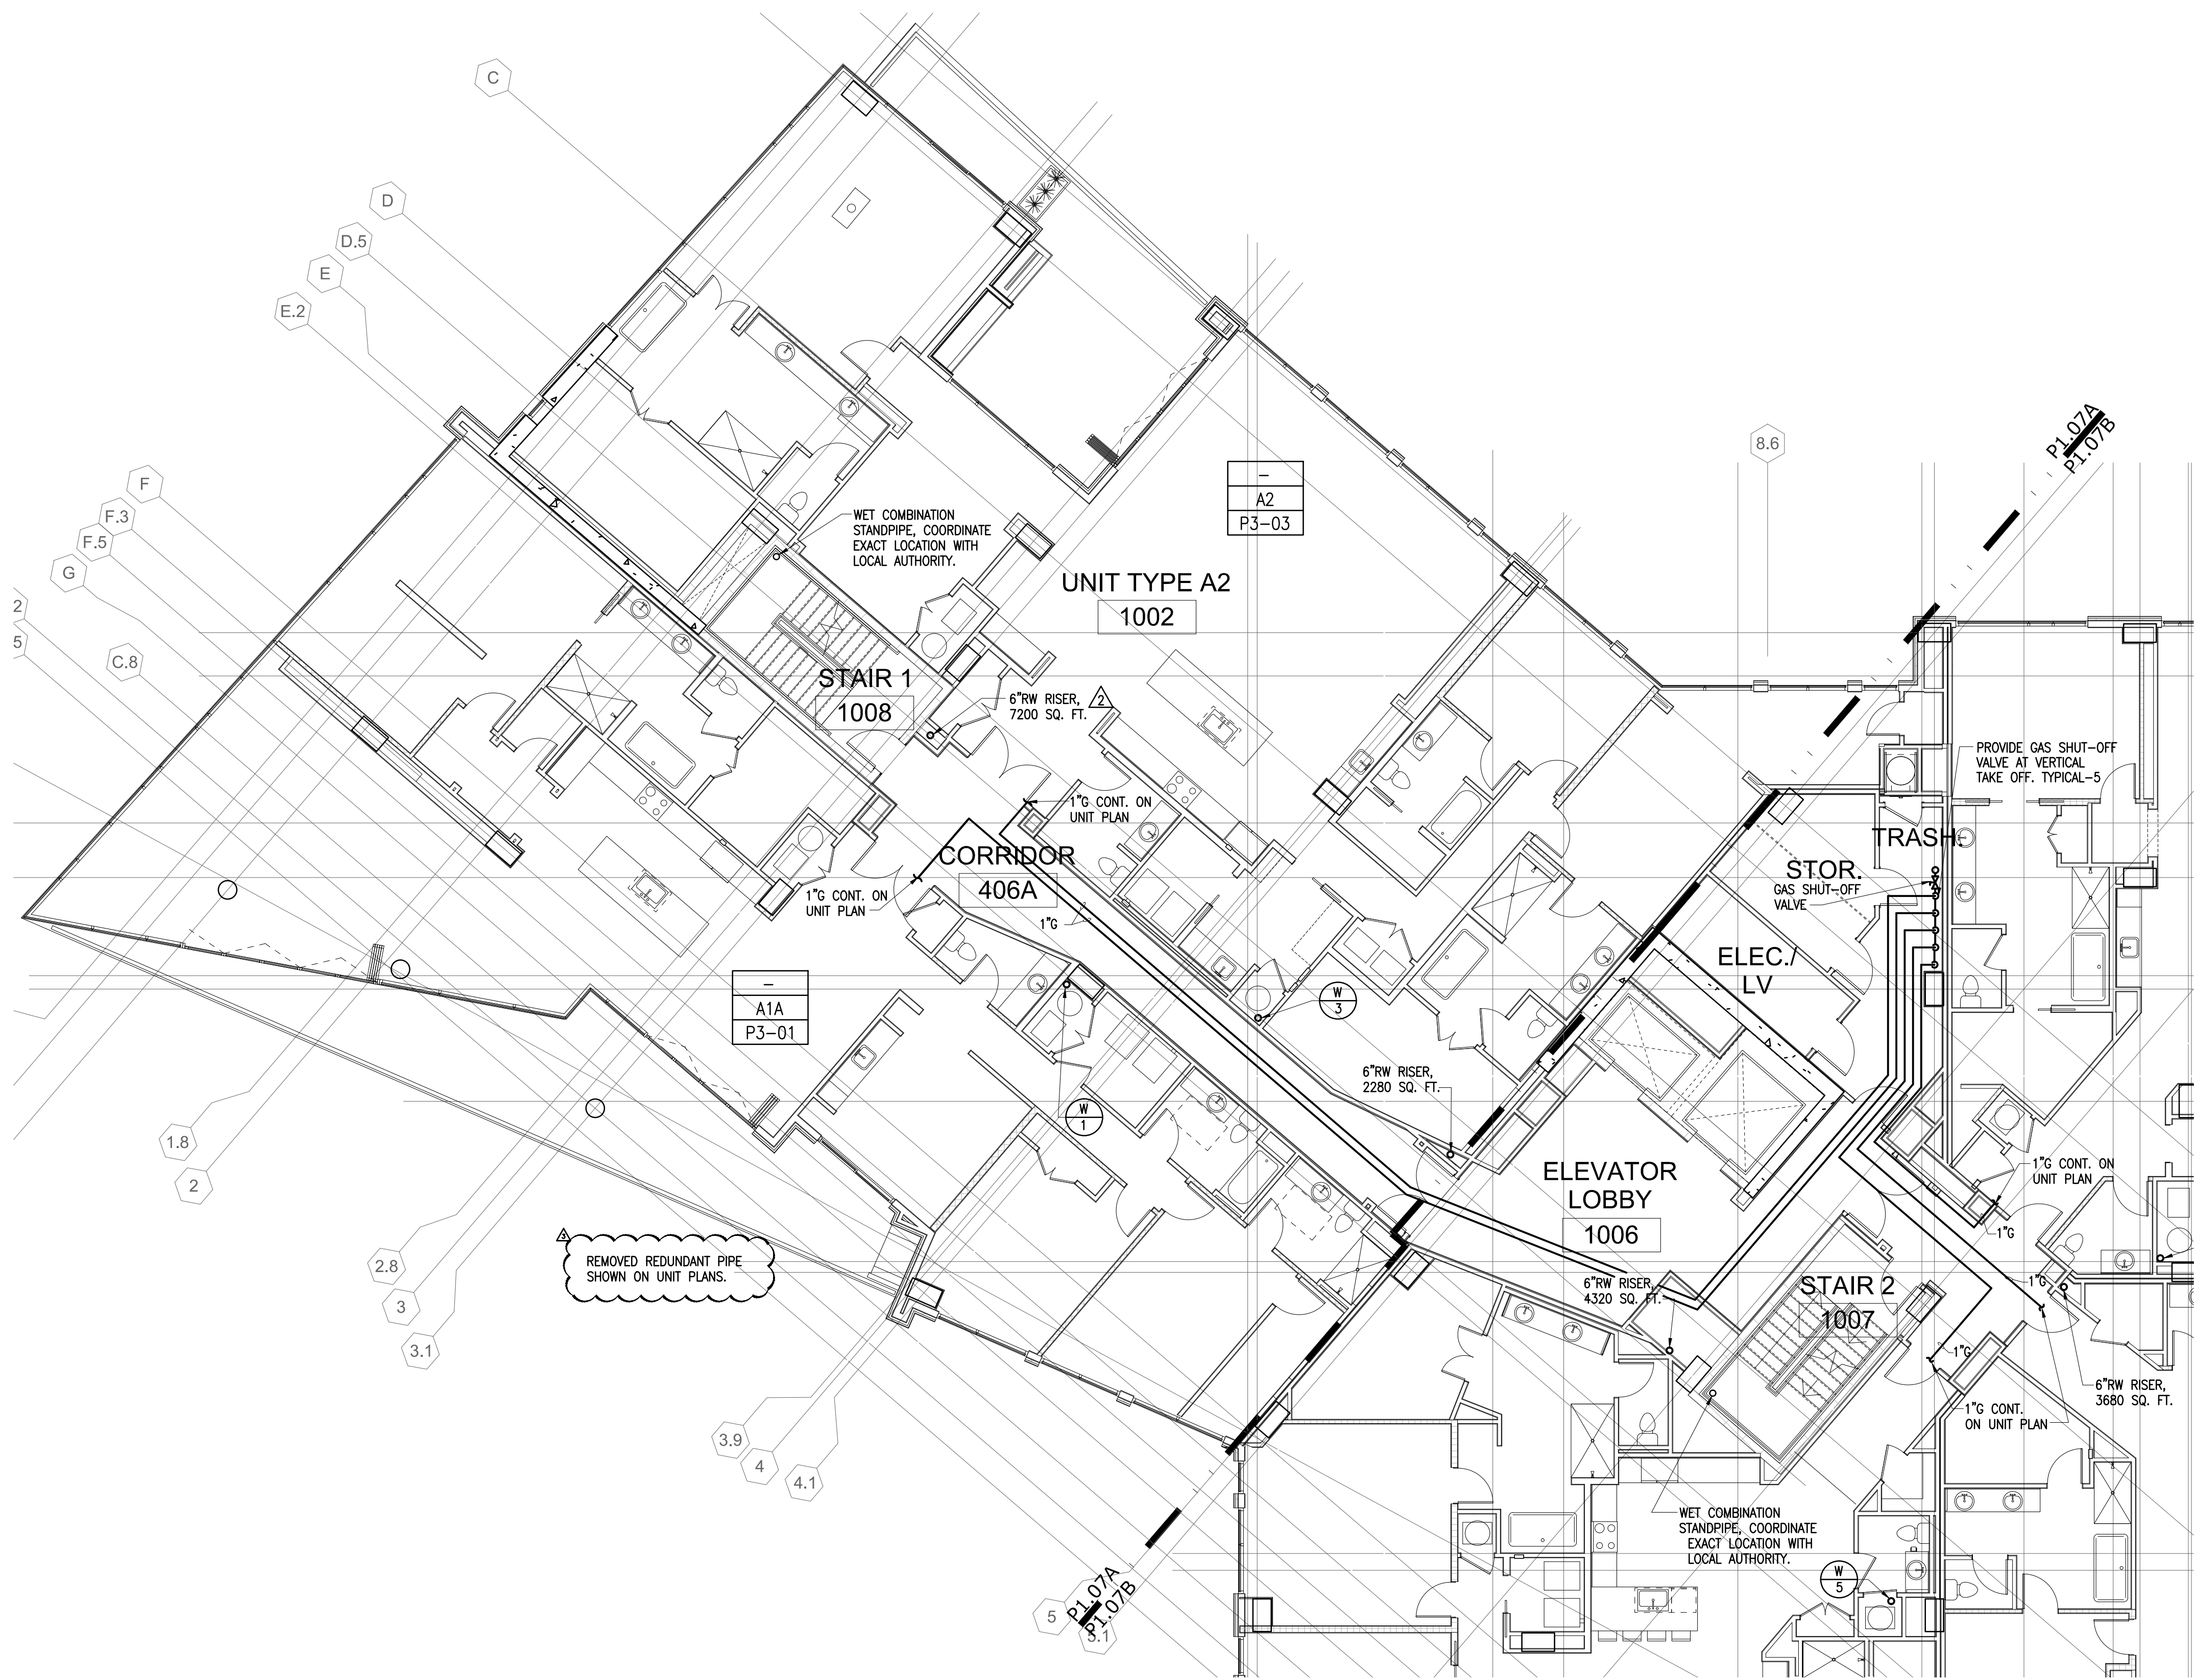

1 LEVELS 9, 11, 14, 16 & 18 - FLOOR PLAN A
SCALE: 1/8" = 1'-0"

KEY PLAN

SEAL



JOB NAME
THE LOUDERMILK COMPANIES, LLC.
LOCATION
THE CHARLES CONDOMINIUMS
3107 PEACHTREE RD.
ATLANTA, GA 30305

SHEET TITLE
LEVELS 3,5,7,9,11 FLOOR PLAN A

PHILLIPS GRADICK
ENGINEERING, P.C.
500 Sugar Mill Rd.
Bldg. A Suite 105
Cobb County, GA 30006
Phone: 770.455.0861 (T)
Fax: 770.455.0862 (F)
Web: www.phillipsgradick.com

REVISION:	
CONSTRUCTION SET	6/29/2017
REVISION 1	7/19/2017
AS-BUILT	12/24/2017


© 2015 Lord Aeck Sargent
LordAeckSargent.com

Unless otherwise agreed to in writing, this document is the sole property of Lord Aeck Sargent and is to be returned upon demand. The information herein is confidential and may not be used nor divulged without the written permission of Lord Aeck Sargent.


**LORD
AECK
SARGENT**

ISSUED FOR CONSTRUCTION
P109A

K
J
H
G
F
E
D
C
B
A

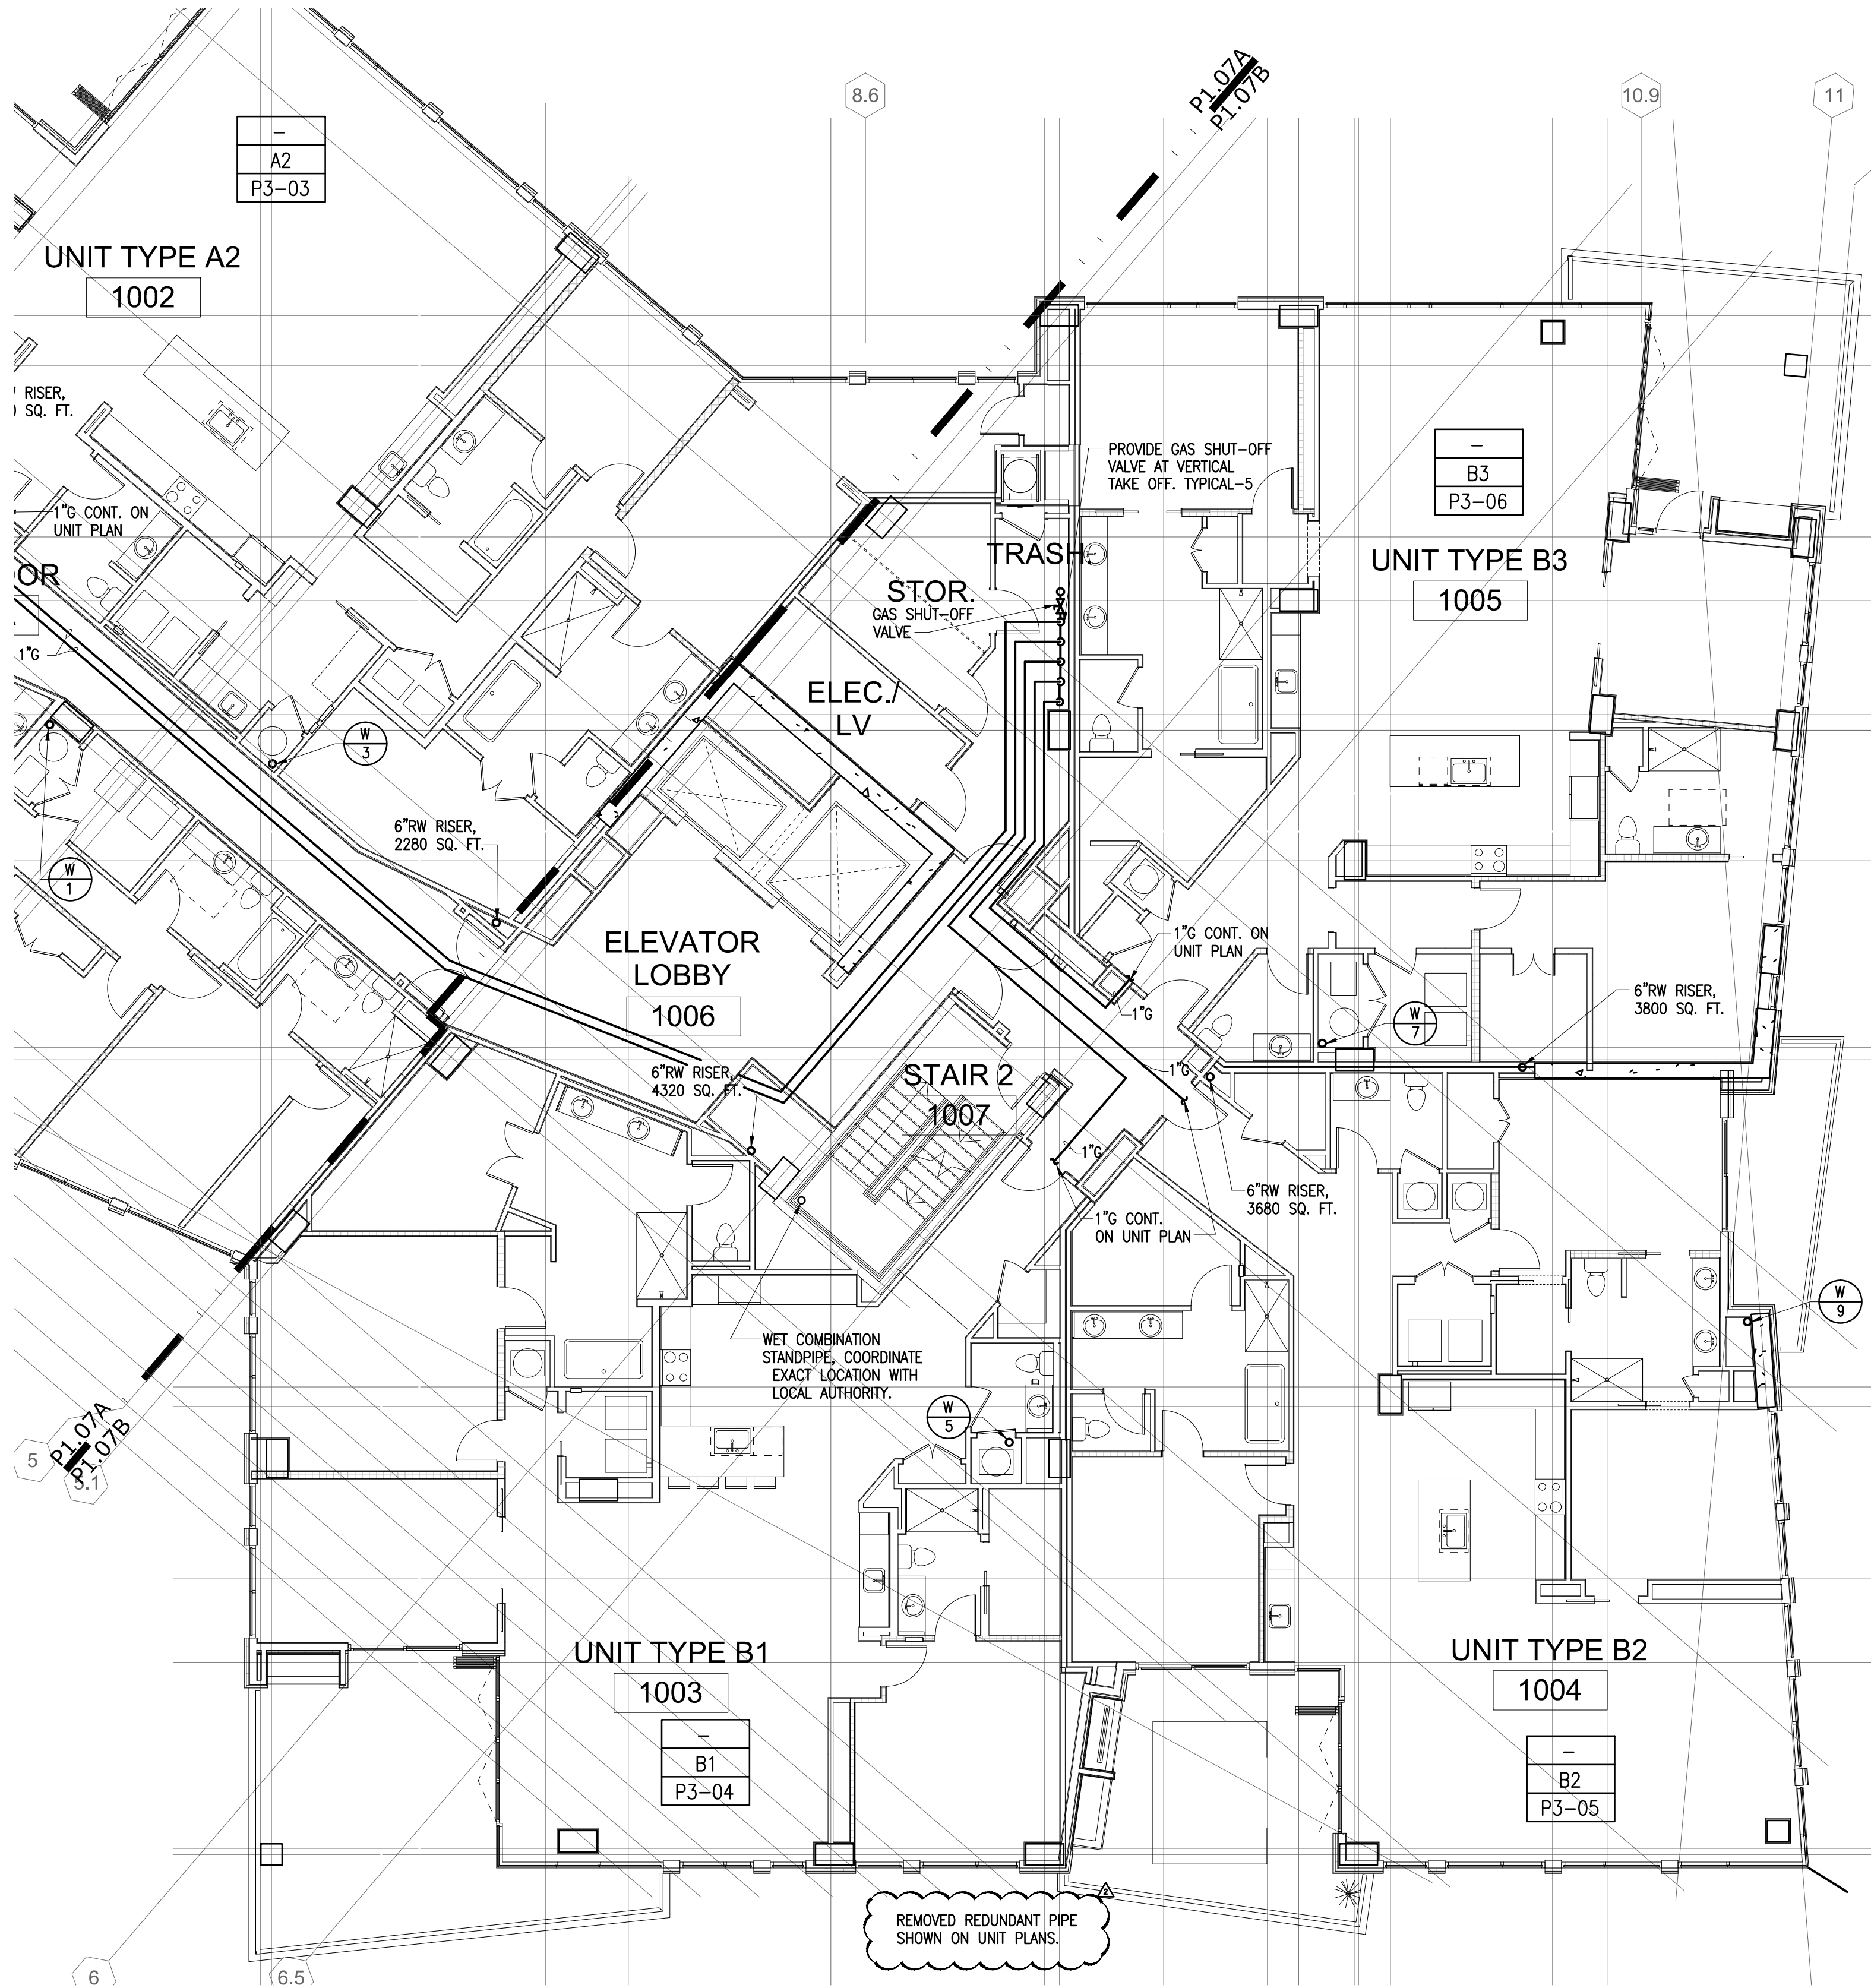

1 LEVELS 9, 11, 14, 16 & 18 - FLOOR PLAN B
SCALE: 1/8" = 1'-0"

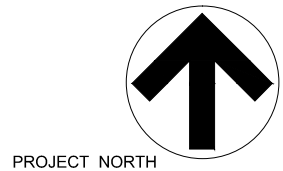

KEY PLAN

SEAL



JOB NAME
THE LOUDERMILK COMPANIES, LLC.

THE CHARLES CONDOMINIUMS

LOCATION
3107 PEACHTREE RD.
ATLANTA, GA 30305

ISSUE DATE
06/30/17

JOB NO.
10605-01

DWG. NO.

P109B

SHEET TITLE

LEVELS 3,5,7,9,11 FLOOR PLAN B

SCALE (UNCL.)
1/8" = 1'-0"

PHILLIPS GRADICK
ENGINEERING, P.C.
530 Sugar Mill Rd.
Bldg. A Suite 105
Atlanta, GA 30340
Phone: 404.525.1350
Fax: 404.525.1351
www.phillipsgradick.com



THESE DRAWINGS ARE THE PROPERTY OF PHILLIPS GRADICK ENGINEERING, P.C. AND SHALL NOT BE REPRODUCED, COPIED, OR TRANSMITTED IN ANY FORM OR BY ANY MEANS, ELECTRONIC OR MECHANICAL, WITHOUT THE WRITTEN PERMISSION OF PHILLIPS GRADICK ENGINEERING, P.C. THIS DRAWING IS COPYRIGHTED AND ALL RIGHTS ARE RESERVED. UNAUTHORIZED USE OF THESE PLANS WITHOUT THE EXPRESS WRITTEN PERMISSION OF PHILLIPS GRADICK ENGINEERING, P.C. IS PROHIBITED.

REVISION:
CONSTRUCTION SET 6/29/2017
AS-008 6/24/2017

© 2015 Lord Aeck Sargent
LordAeckSargent.com
Unless otherwise agreed to in writing, this document is the sole property of Lord Aeck Sargent and is to be returned upon demand. The information herein is confidential and may not be used nor divulged without the written permission of Lord Aeck Sargent.

**LORD
AECK
SARGENT**

ISSUED FOR CONSTRUCTION



1 LEVELS 10, 12, 15, 17 & 19 - FLOOR PLAN B
SCALE: 1/8" = 1'-0"

**LORD
AECK
SARGENT**

© 2015 Lord Aeck Sargent
LordAeckSargent.com
Unless otherwise agreed to in writing, this document is the sole property of Lord Aeck Sargent and is to be returned upon demand. The information herein is confidential and may not be used nor divulged without the written permission of Lord Aeck Sargent.


REVISION:
CONSTRUCTION SET 6/30/2017


**PHILLIPS GRADICK
ENGINEERING, P.C.**
P.C. # 210613
770 535-5661 (T)
770 535-5662 (F)
Atlanta, Georgia 30308
Bldg. A Suite 105
500 Sugar Mill Rd.
The drawings on these plans were prepared by the staff of Phillips Gradiack Engineering, P.C. The drawings are prepared and checked by the staff of Phillips Gradiack Engineering, P.C. and shall not be used for any other purpose without the written permission of Phillips Gradiack Engineering, P.C. is published.

SHEET TITLE
LEVELS 10, 12, 15, 17 & 19 - FLOOR PLAN B
SCALE (UNITS)
1/8" = 1'-0"

JOB NAME
THE LOUDERMILK COMPANIES, LLC.
LOCATION
THE CHARLES CONDOMINIUMS
3107 PEACHTREE RD.
ATLANTA, GA 30305


ISSUE DATE
06/30/17
JOB NO.
10605-01
DWG. NO.
P110B

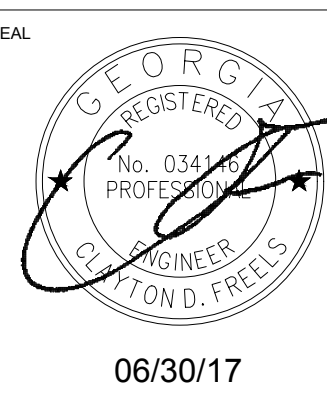

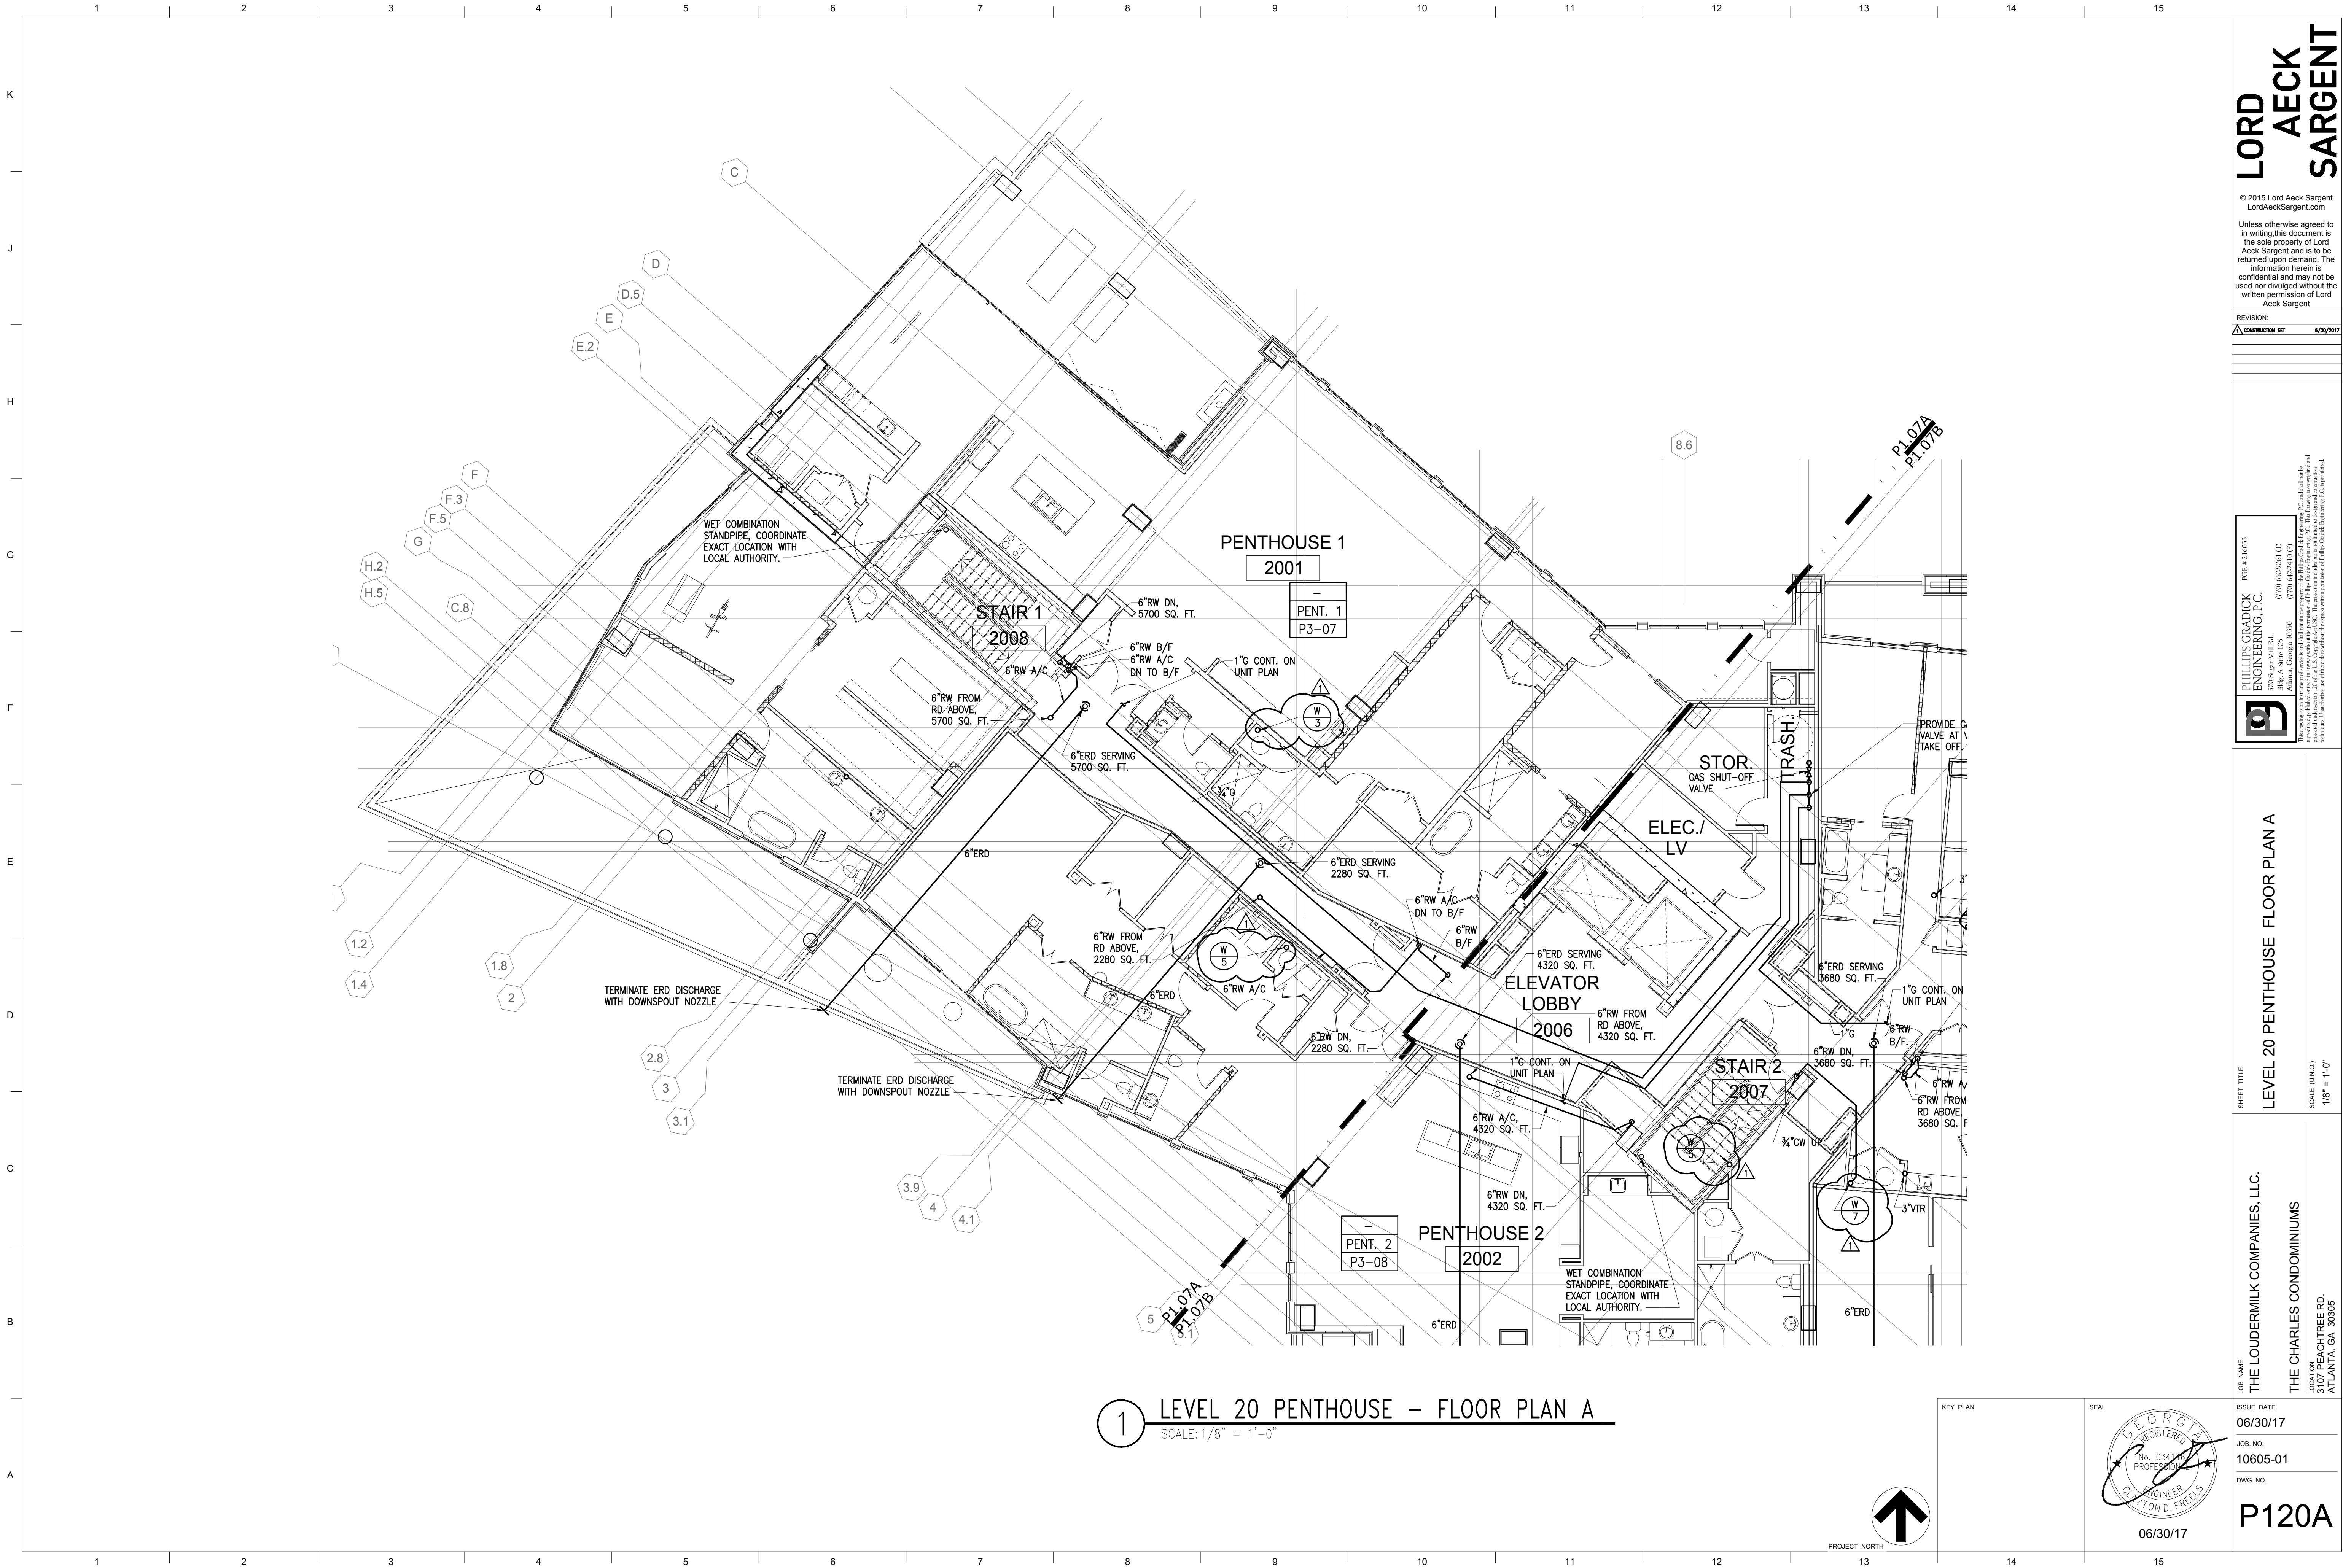


1 LEVEL 20 PENTHOUSE - FLOOR PLAN A
SCALE: 1/8" = 1'-0"

KEY PLAN

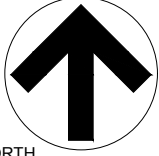

SEAL

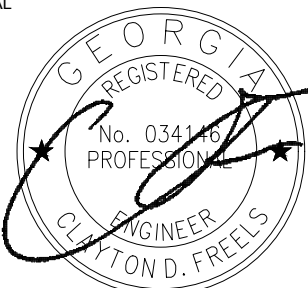

JOB NAME
THE LOUDERMILK COMPANIES, LLC.
THE CHARLES CONDOMINIUMS
LOCATION
3107 PEACHTREE RD.
ATLANTA, GA 30305

SHEET TITLE
LEVEL 20 PENTHOUSE FLOOR PLAN A

PHILLIPS GRADICK
ENGINEERING, P.C.
500 Sugar Mill Rd.
Atlanta, Georgia 30305
P.E. # 210033
(770) 442-2410 (F)
0770 442-2410 (F)

Unless otherwise agreed to in writing, this document is the sole property of Lord Aeck Sargent and is to be returned upon demand. The information herein is confidential and may not be used nor divulged without the written permission of Lord Aeck Sargent.

REVISION:
CONSTRUCTION SET 6/30/2017

LORD
AECK
SARGENT

 
© 2015 Lord Aeck Sargent
LordAeckSargent.com

Unless otherwise agreed to in writing, this document is the sole property of Lord Aeck Sargent and is to be returned upon demand. The information herein is confidential and may not be used nor divulged without the written permission of Lord Aeck Sargent.

06/30/17
10605-01
P120A





SEAN



This drawing, as an instrument of service, is and shall remain the property of Phillips Grackel Engineering, P.C., and shall not be reproduced, published or used in any way without the permission of Phillips Grackel Engineering, P.C. This Drawing is copyrighted and protected under section 120 of the U.S. Copyright Act USC. The protection includes but is not limited to design and construction techniques. Unauthorized use of these plans without the express written permission of Phillips Grackel Engineering, P.C. is prohibited.

Unless otherwise agreed to in writing, this document is the sole property of Lord Aeck Sargent and is to be returned upon demand. The information herein is confidential and may not be used nor divulged without the written permission of Lord Aeck Sargent

**LORD
AECK
SARGENT**

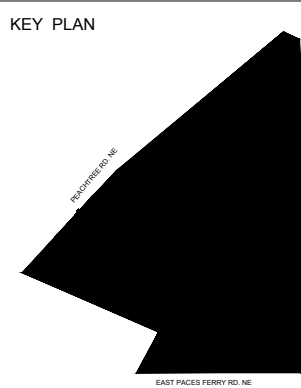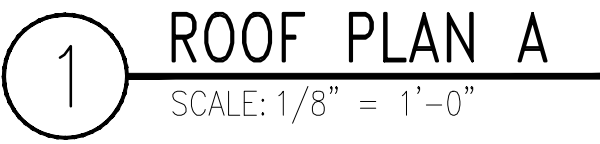


ISSUE DATE
06/30/17

JOB. NO.
10605-01

DWG. NO.
P121A

ISSUED FOR CONSTRUCTION

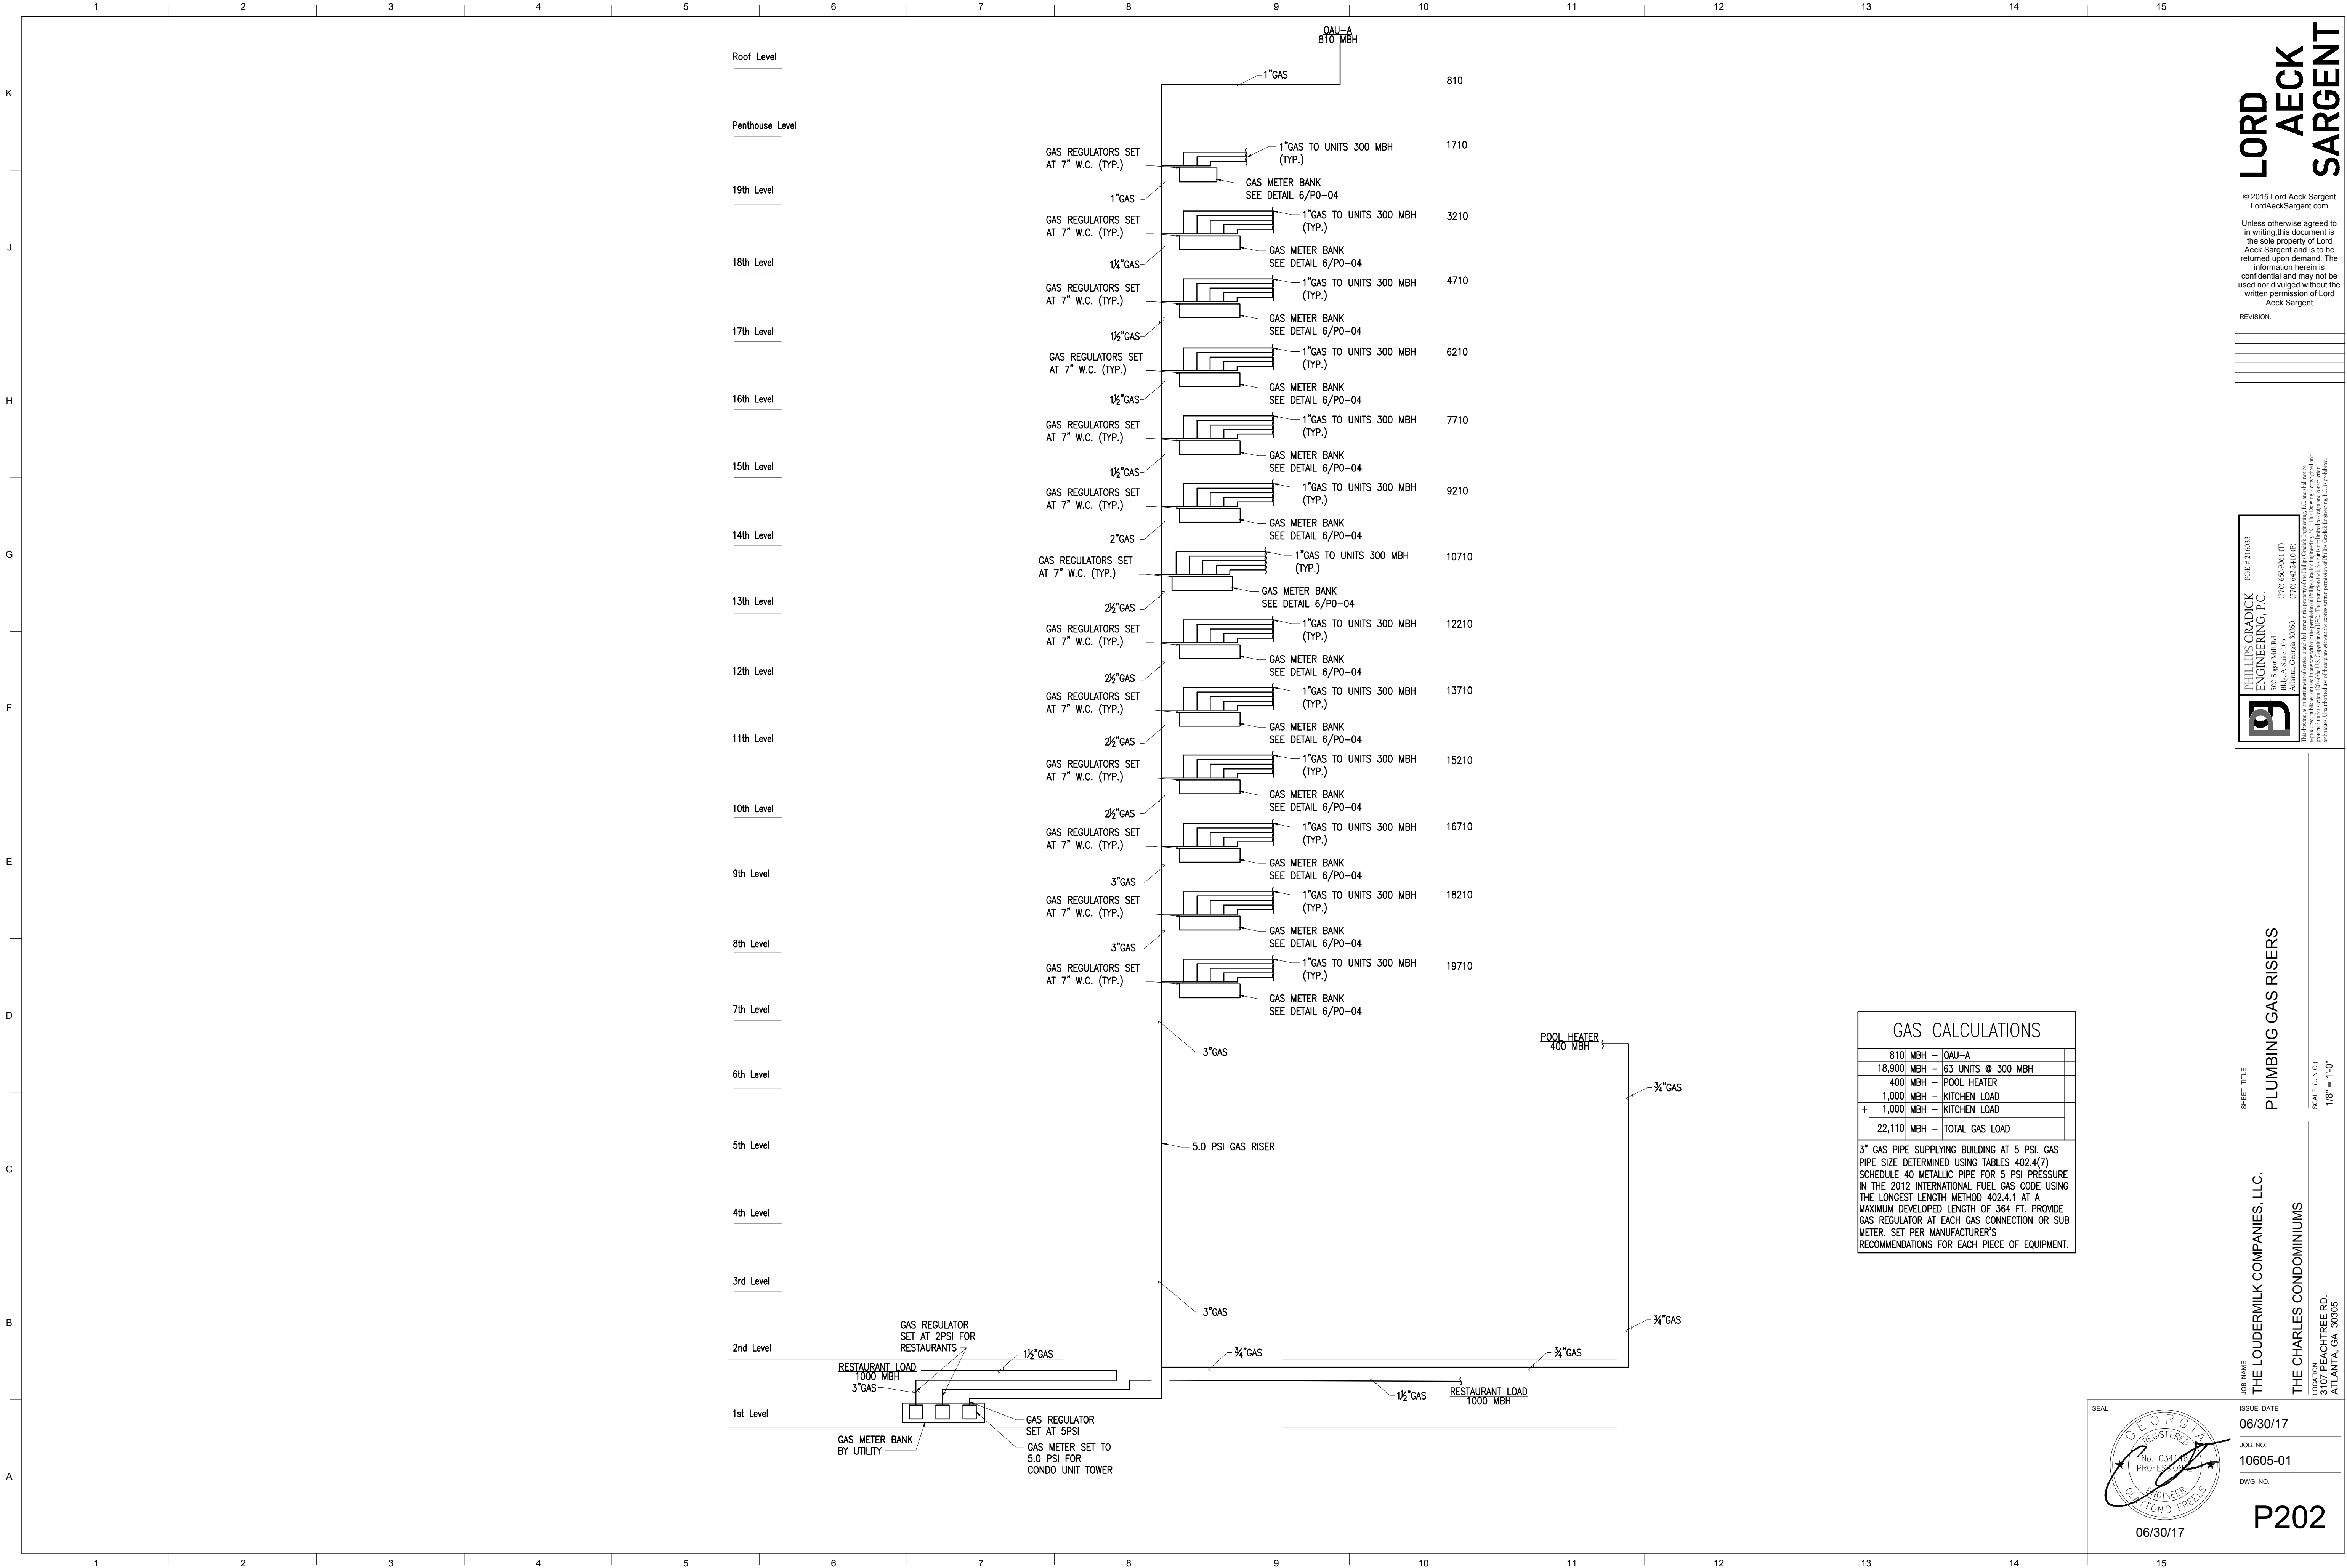

LORD AECK SARGENT

© 2015 Lord Aeck Sargent
LordAeckSargent.com
Unless otherwise agreed to in writing, this document is the sole property of Lord Aeck Sargent and is to be returned upon demand. The information herein is confidential and may not be used nor divulged without the written permission of Lord Aeck Sargent.

REVISION:




**PHILLIPS GRADICK
ENGINEERING, P.C.**
500 Sugar Hill Rd.
Bldg. A Suite 105
Atlanta, GA 30328
(770) 653-9811 (F)
(770) 653-9812 (T)
Fax: (770) 653-9813
www.phillipsgradiack.com

PHILLIPS GRADICK ENGINEERING, P.C. and its affiliates are not responsible for the design or construction of any building or structure. The design is the property of Phillips Gradiack Engineering, P.C. and its affiliates. The design is not to be used for any other purpose without the written permission of Phillips Gradiack Engineering, P.C. and its affiliates.


PLUMBING GAS RISERS

THE LOUDERMILK COMPANIES, LLC.
THE CHARLES CONDOMINIUMS
3107 PEACHTREE RD.
ATLANTA, GA 30305

ISSUED FOR CONSTRUCTION

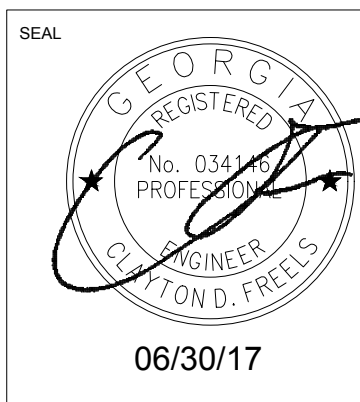

P202

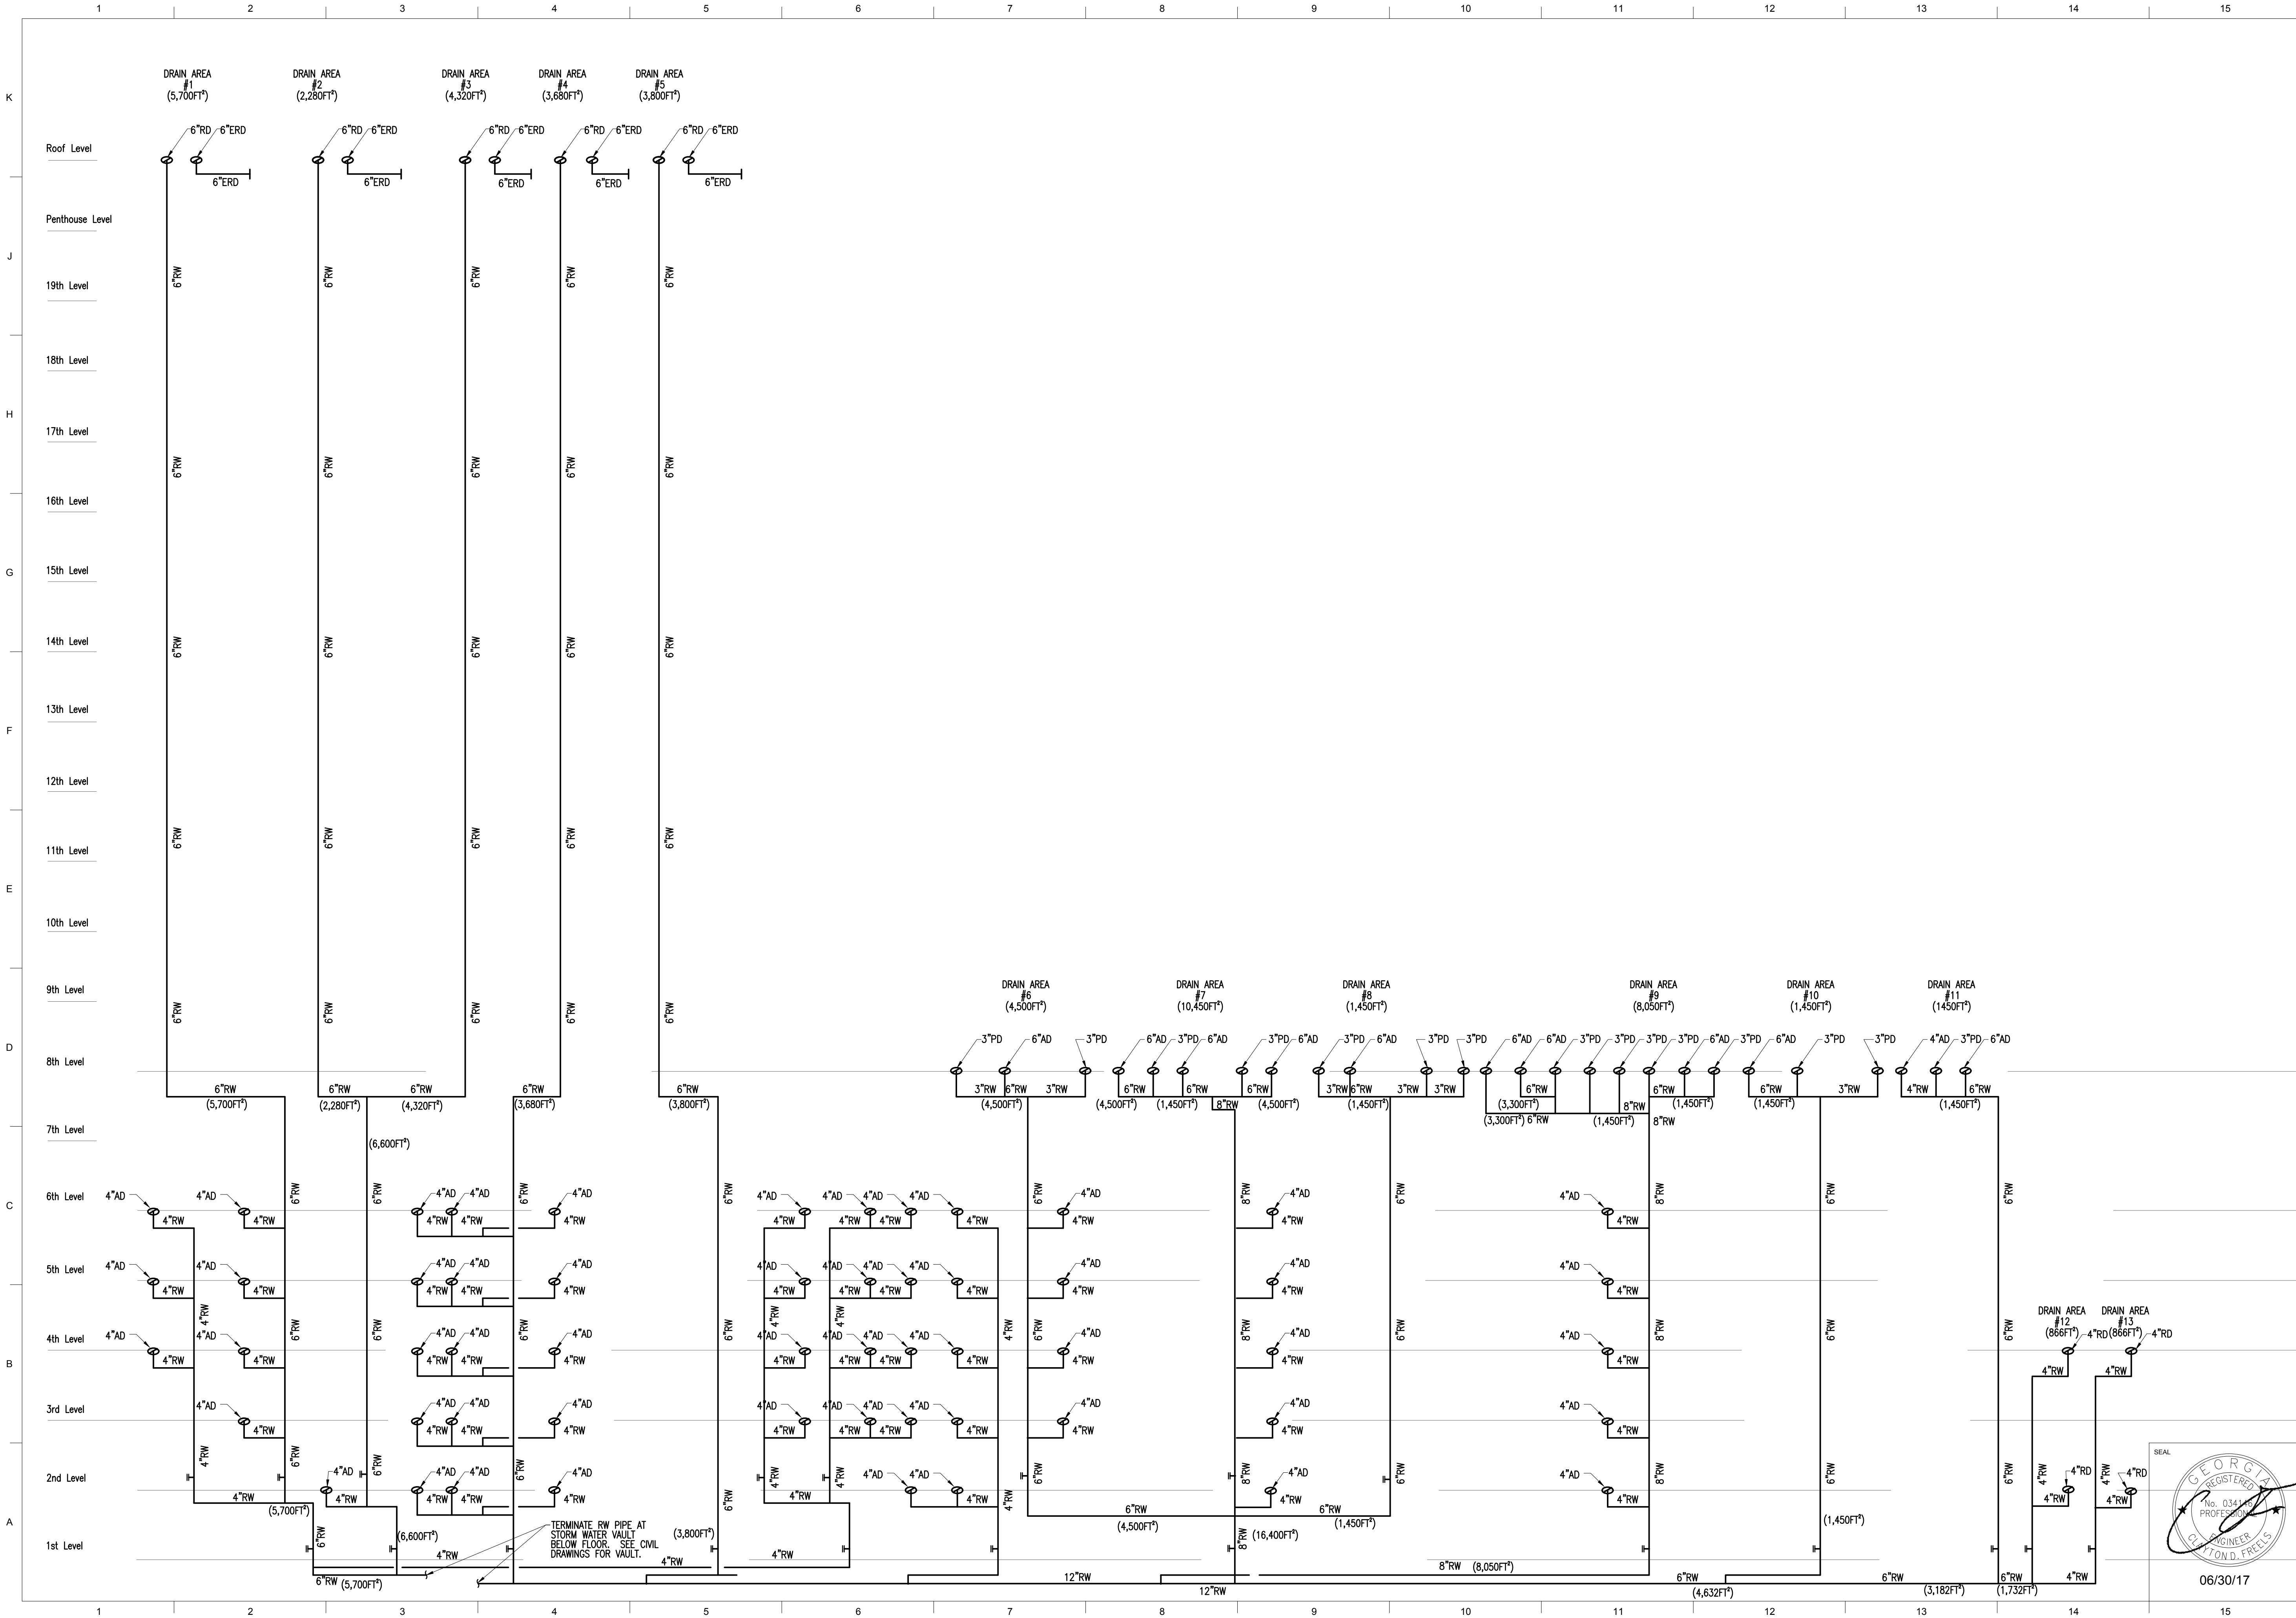

LORD
AECK
SARGENT

© 2015 Lord Aeck Sargent
LordAeckSargent.com

Unless otherwise agreed to in writing, this document is the sole property of Lord Aeck Sargent and is to be returned upon demand. The information herein is confidential and may not be used nor divulged without the written permission of Lord Aeck Sargent.

PHILLIPS GRADICK
ENGINEERING, P.C.

PHILLIPS GRADICK
ENGINEERING, P.C.
500 Sugar Hill Rd.
Billerica, MA 01821-1035
(781) 663-3400
www.phillipsgradick.com

PHILLIPS GRADICK
ENGINEERING, P.C.
500 Sugar Hill Rd.
Billerica, MA 01821-1035
(781) 663-3400
www.phillipsgradick.com

SHEET TITLE

PLUMBING RAIN WATER RISERS

JOB NAME

THE LOUDERMILK COMPANIES, LLC.

JOB NO.

106005-01

DWG. NO.

P203

THE LOUDERMILK COMPANIES, LLC.

THE CHARLES CONDOMINIUMS


3107 PEACHTREE RD.
ATLANTA, GA 30305

06/30/17

106005-01

P203

ISSUED FOR CONSTRUCTION

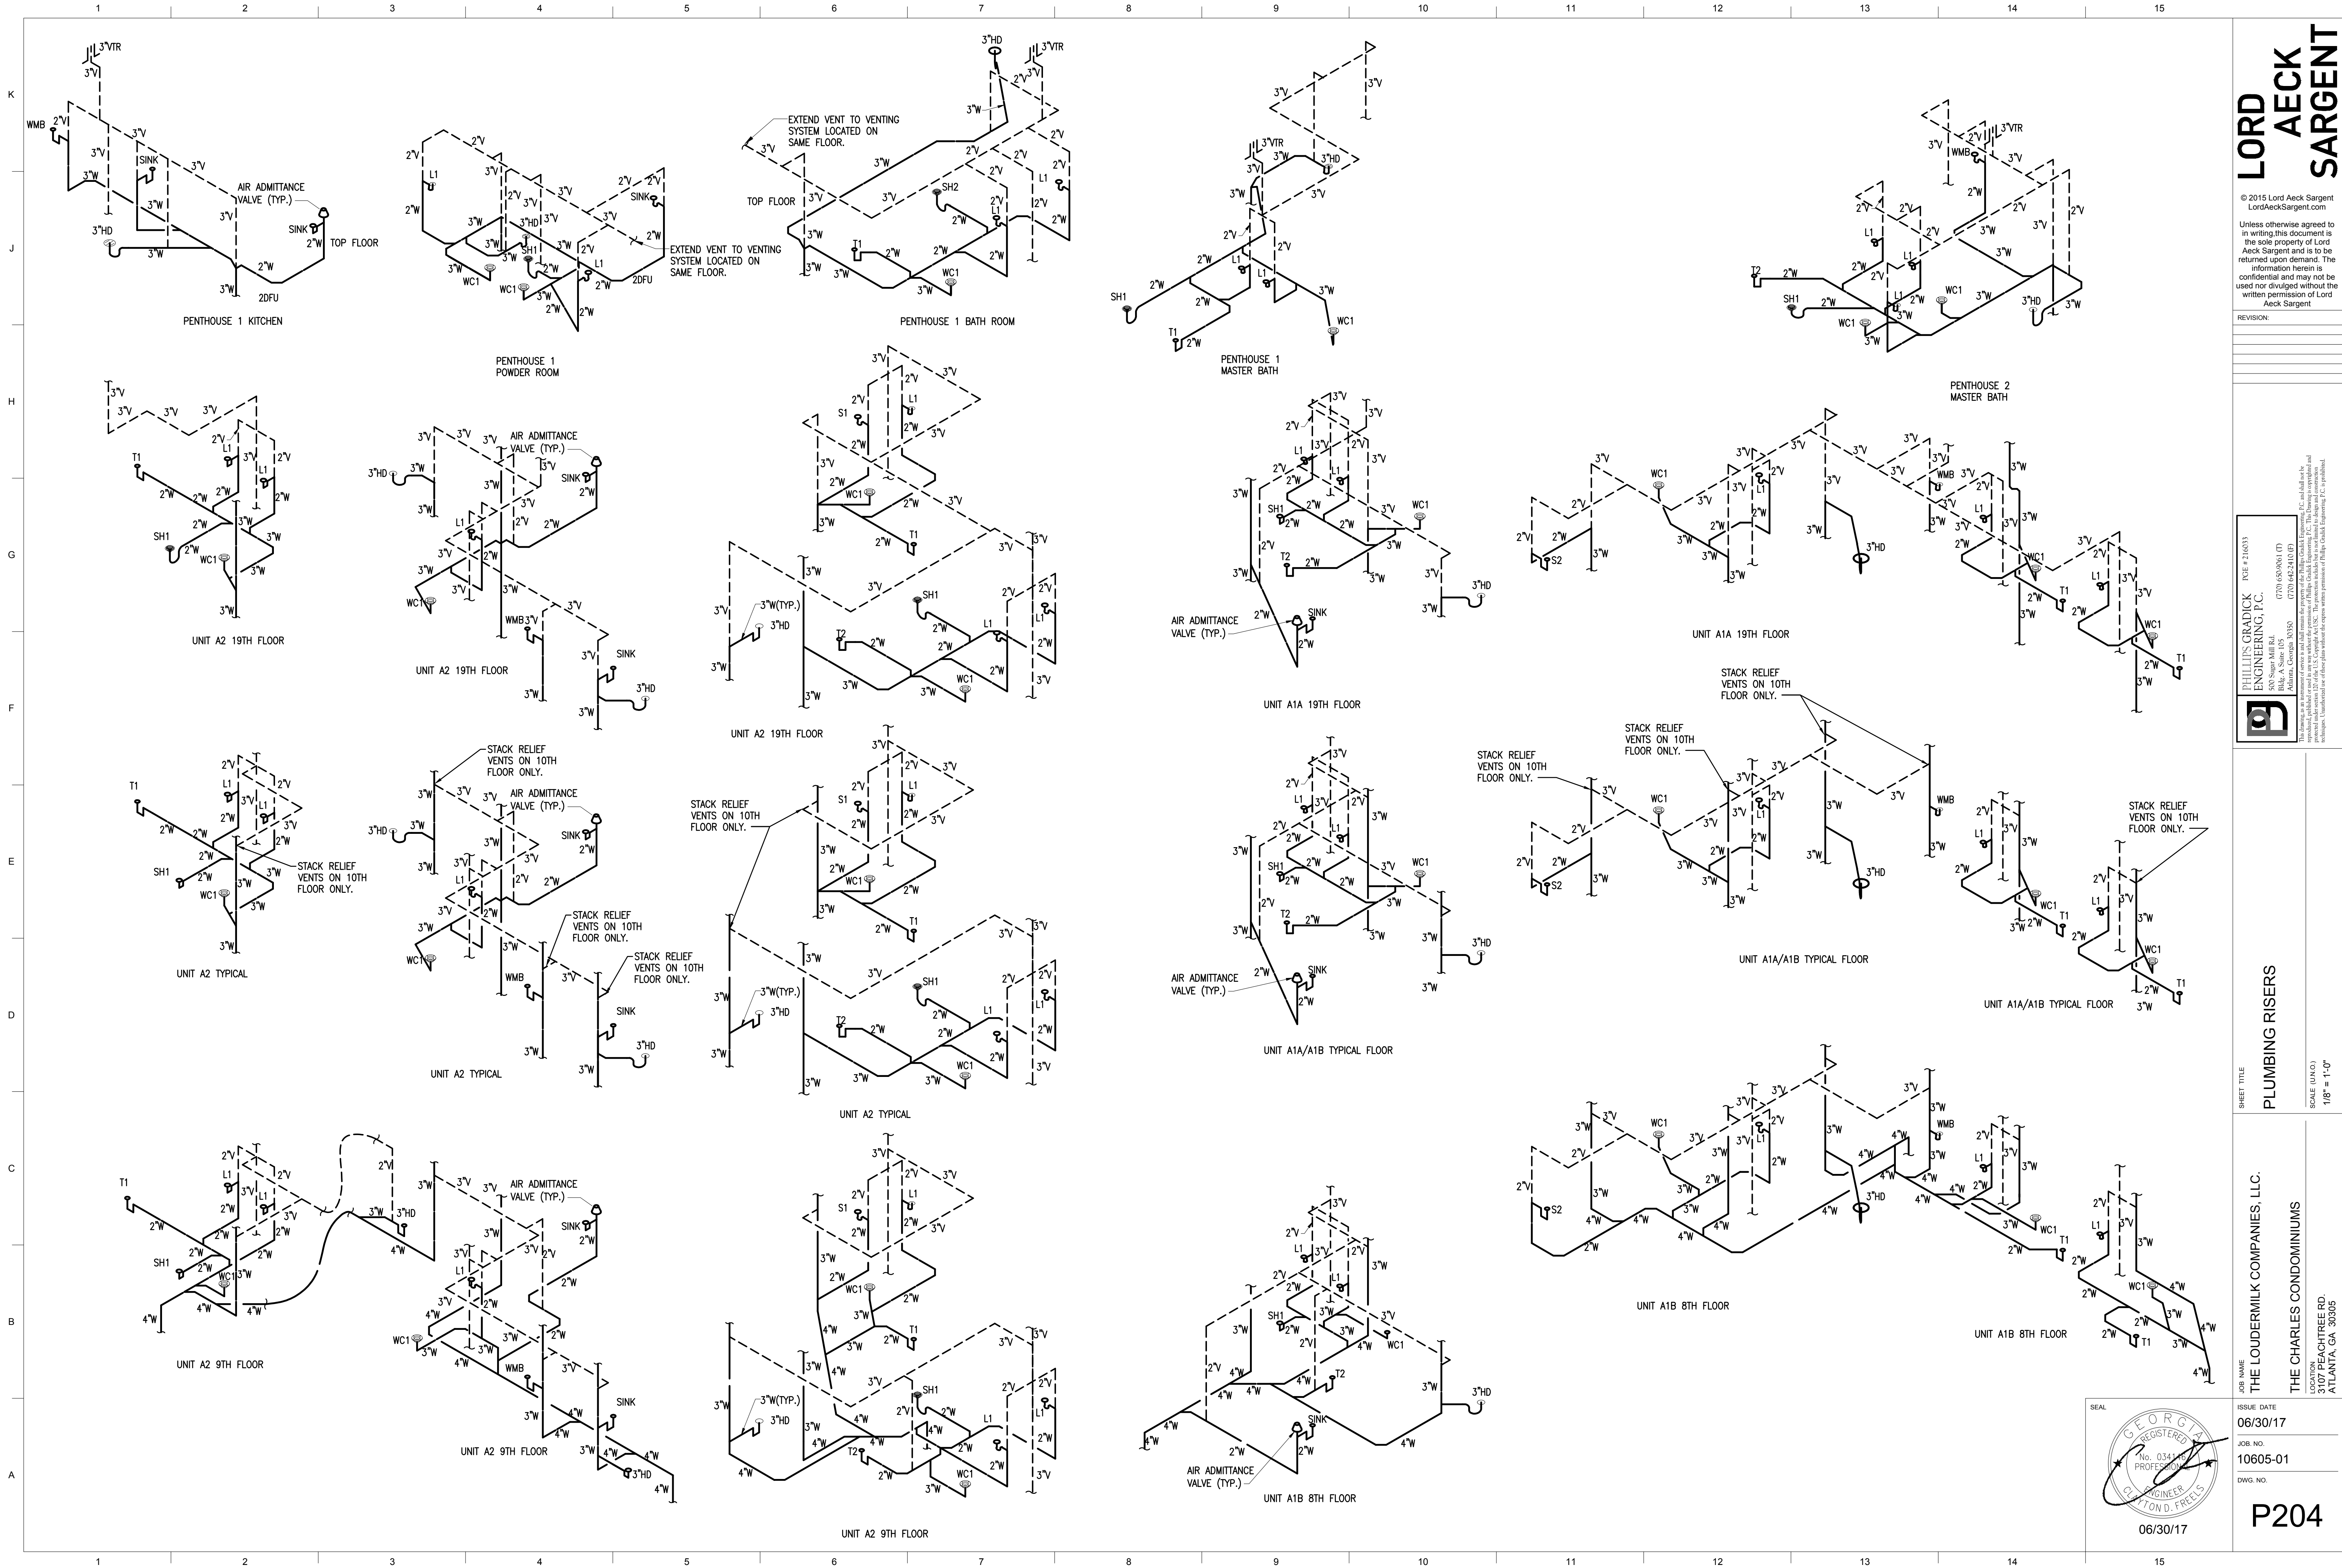

REVISION:

PHILLIPS GRADICK
ENGINEERING, P.C.

PHILLIPS GRADICK ENGINEERING, P.C.
500 Sugar Hill Rd.
Bldg. A Suite 105
Atlanta, GA 30328
(770) 655-8100
www.phillipsgradick.com

PHILLIPS GRADICK ENGINEERING, P.C. and its affiliates are not responsible for the accuracy or completeness of the information contained herein. The information is provided for informational purposes only and does not constitute an offer of any financial product or service. The information is provided for informational purposes only and does not constitute an offer of any financial product or service. The information is provided for informational purposes only and does not constitute an offer of any financial product or service.

SHEET TITLE
PLUMBING RISERS

SCALE (INCHES)
1/8" = 1'-0"

JOB NAME
THE LOUDERMILK COMPANIES, LLC.


JOB NO.
10605-01

DWG. NO.
P204


ISSUE DATE
06/30/17

LOCATION
3107 PEACHTREE RD.
ATLANTA, GA 30305

THE CHARLES CONDOMINIUMS

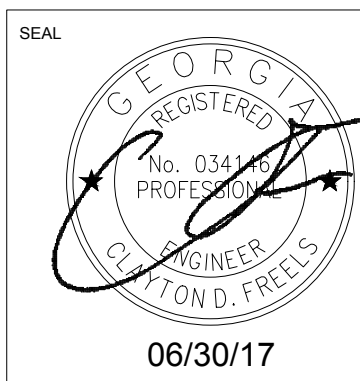

ISSUED FOR CONSTRUCTION

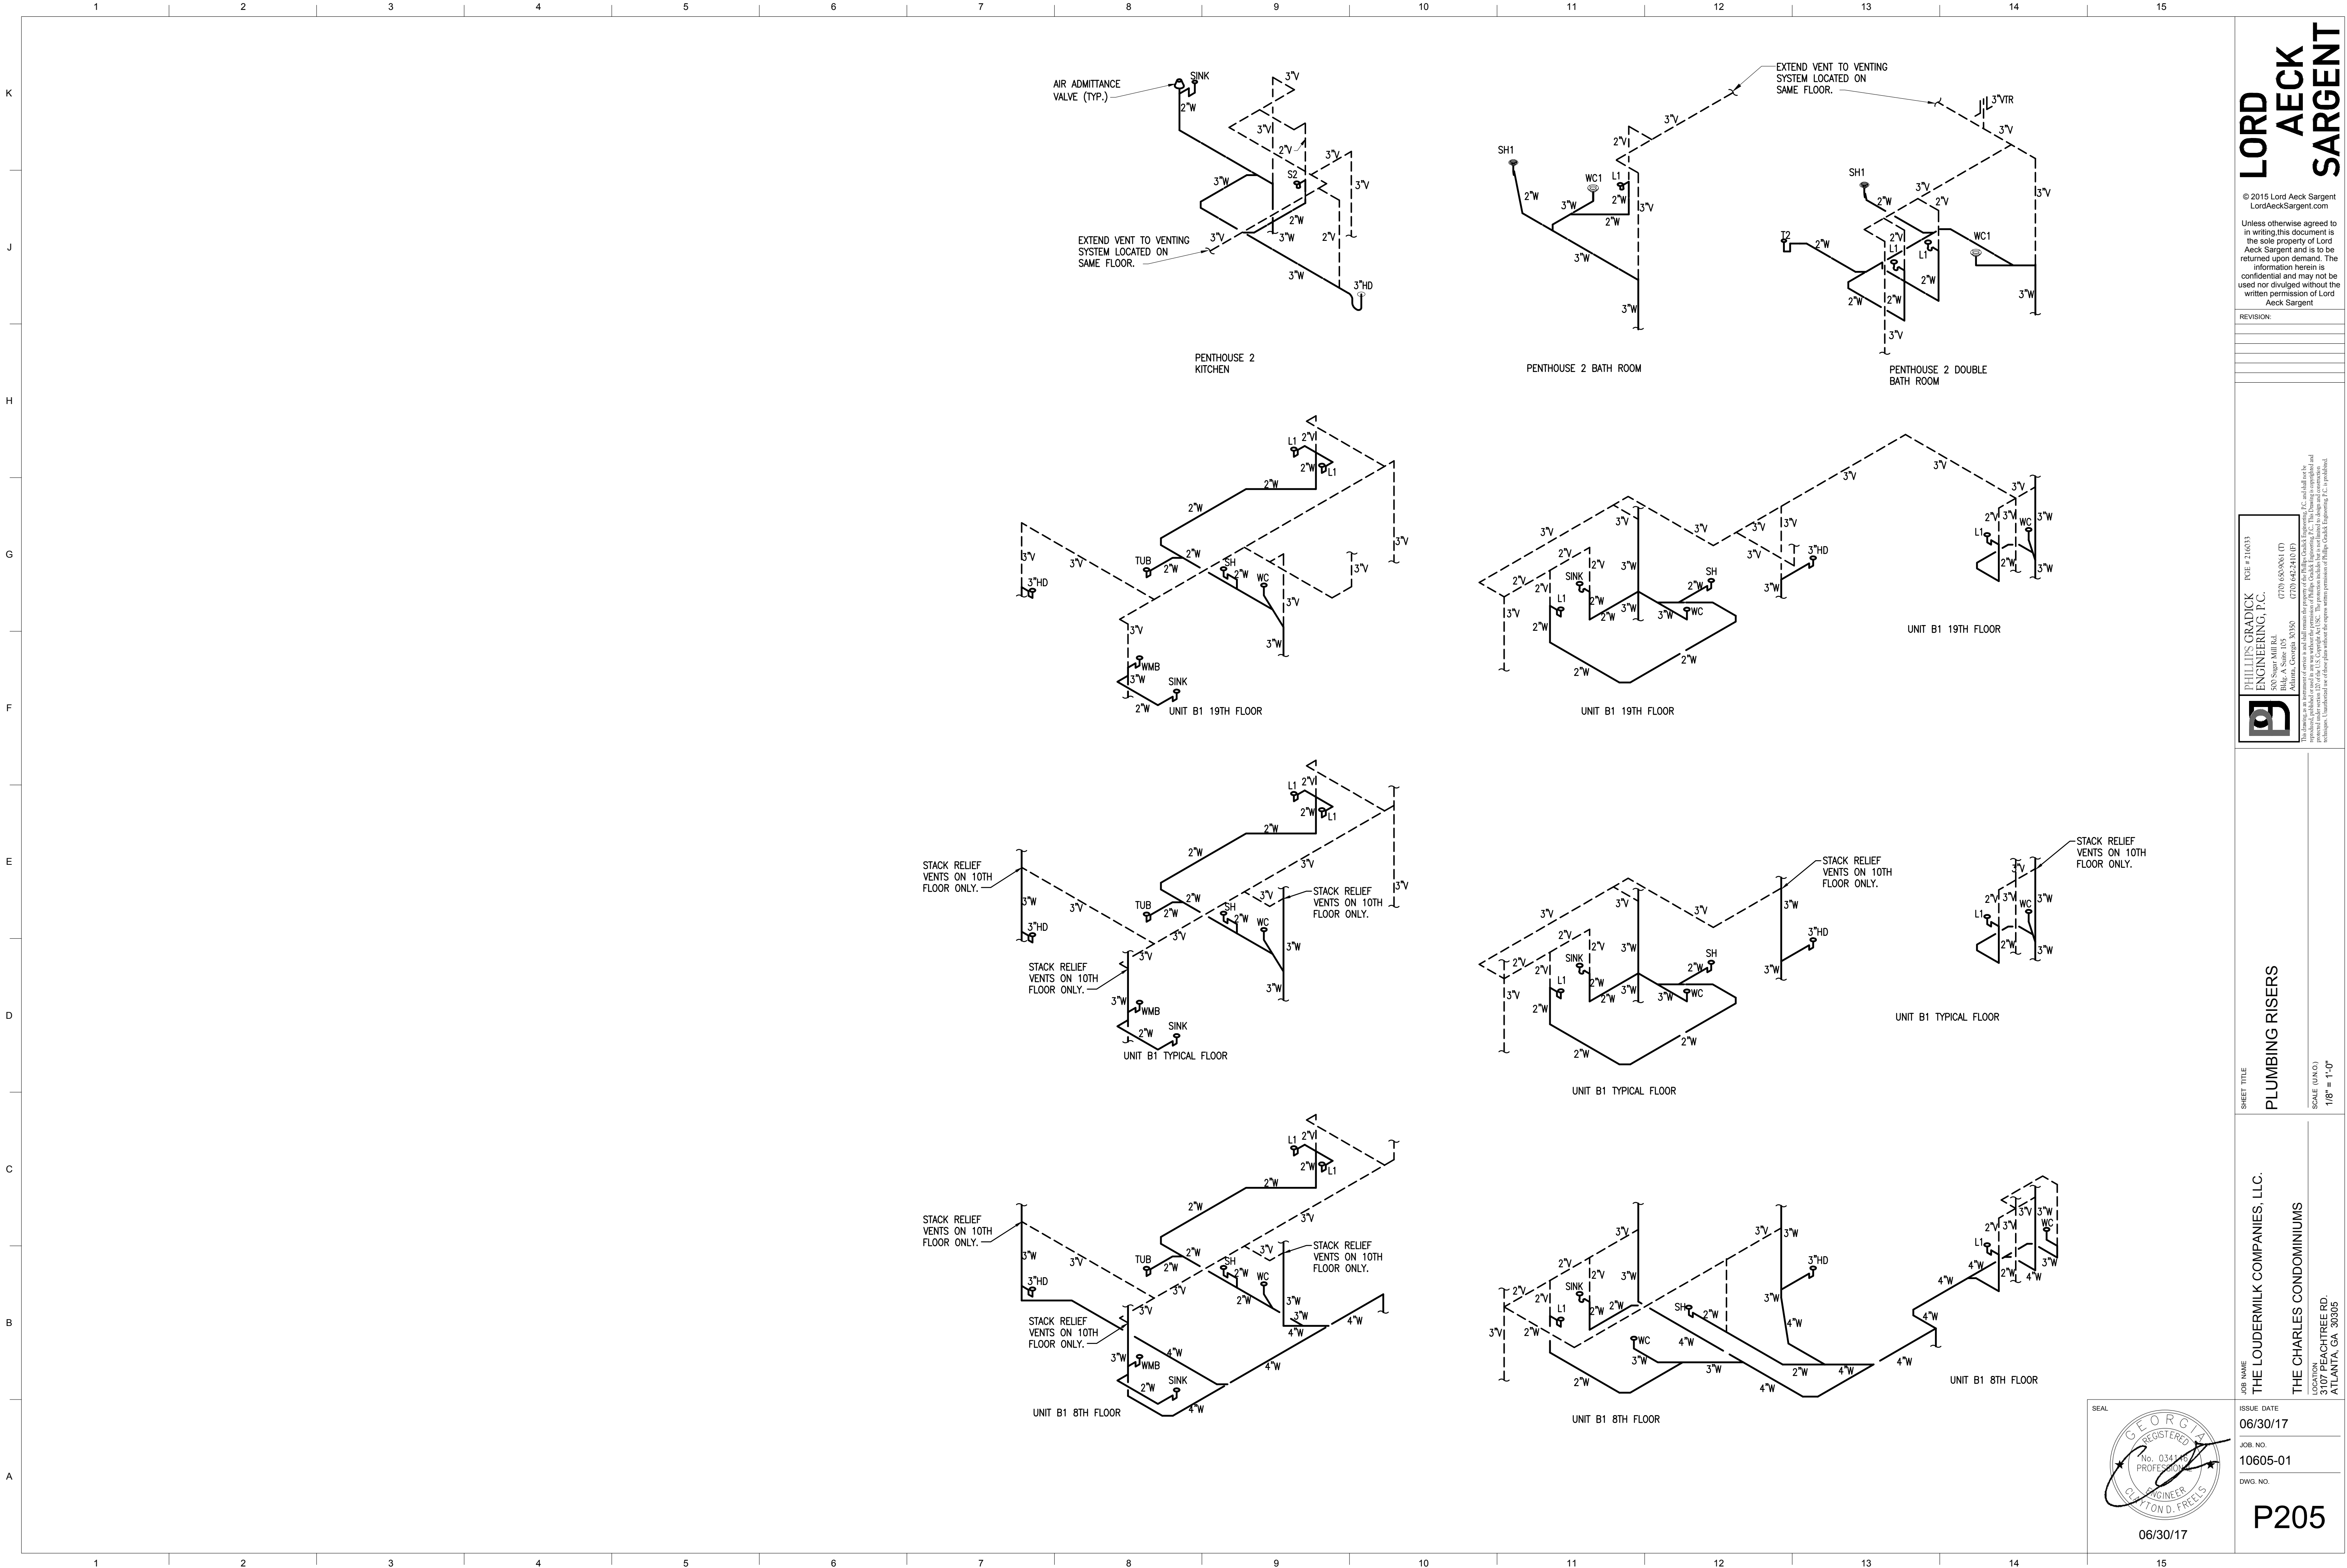

LORD
AECK
SARGENT

© 2015 Lord Aeck Sargent
LordAeckSargent.com

Unless otherwise agreed to in writing, this document is the sole property of Lord Aeck Sargent and is to be returned upon demand. The information herein is confidential and may not be used nor divulged without the written permission of Lord Aeck Sargent

REVISION:

PHILLIPS GRADICK
ENGINEERING, P.C.

PHILLIPS GRADICK ENGINEERING, P.C.
500 Sugar Hill Rd.
Bldg. A Suite 105
Atlanta, Georgia 30328
(770) 655-9161
Fax: (770) 655-9162
www.phillipsgradick.com

PHILLIPS GRADICK ENGINEERING, P.C.
500 Sugar Hill Rd.
Bldg. A Suite 105
Atlanta, Georgia 30328
(770) 655-9161
Fax: (770) 655-9162
www.phillipsgradick.com

SHEET TITLE

PLUMBING RISERS

SCALE (UNITS)
1/8" = 1'-0"


JOB NAME
THE LOUDERMILK COMPANIES, LLC.

THE CHARLES CONDOMINIUMS
3107 PEACHTREE RD.
ATLANTA, GA 30305


ISSUE DATE
06/30/17

JOB NO.
106005-01

DWG. NO.
P205

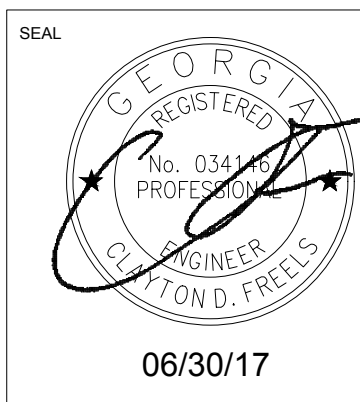

ISSUED FOR CONSTRUCTION

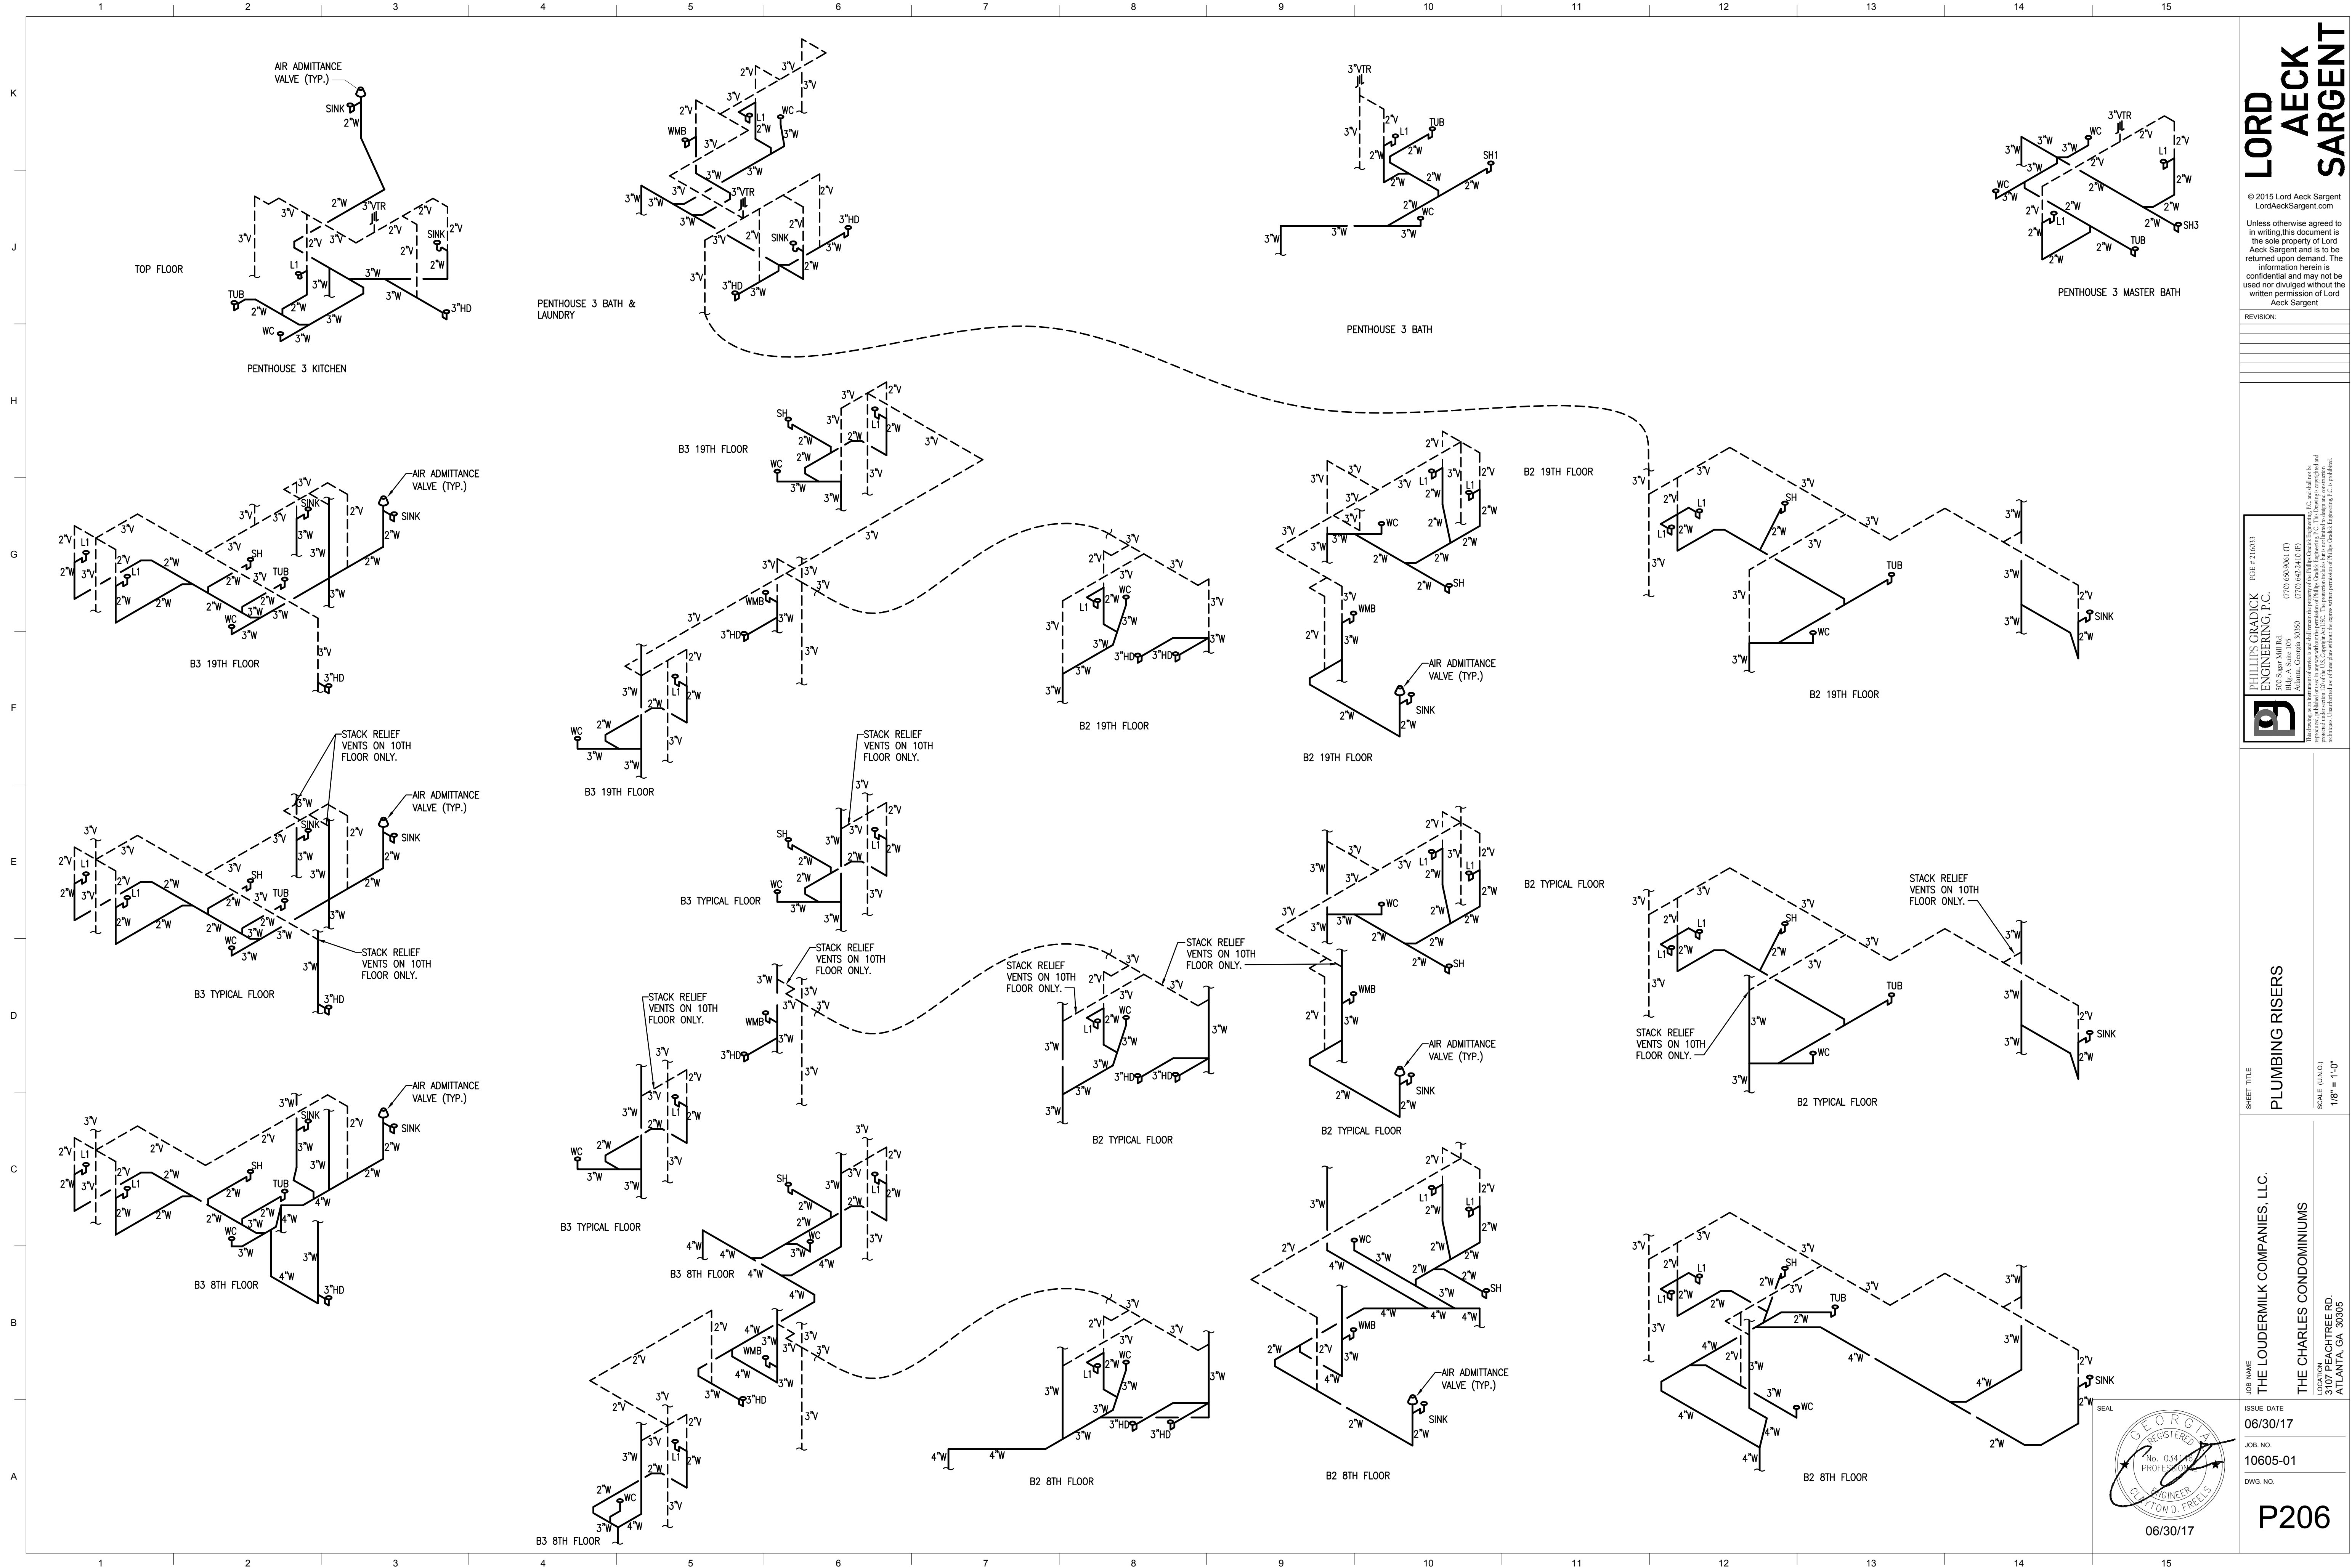

LORD AECK SARGENT

© 2015 Lord Aeck Sargent
LordAeckSargent.com
Unless otherwise agreed to in writing, this document is the sole property of Lord Aeck Sargent and is to be returned upon demand. The information herein is confidential and may not be used nor divulged without the written permission of Lord Aeck Sargent.

REVISION:


PHILLIPS GRADICK ENGINEERING, P.C.
500 Sugar Hill Rd.
Bldg. A Suite 105
Atlanta, GA 30328
(770) 435-9811
Fax: (770) 435-9812
www.phillipsgradick.com

PHILLIPS GRADICK ENGINEERING, P.C.
500 Sugar Hill Rd.
Bldg. A Suite 105
Atlanta, GA 30328
(770) 435-9811
Fax: (770) 435-9812
www.phillipsgradick.com

SHEET TITLE
PLUMBING RISERS
SCALE (INCHES)
1/8" = 1'-0"

JOB NAME
THE LOUDERMILK COMPANIES, LLC.
THE CHARLES CONDOMINIUMS
LOCATION
3107 PEACHTREE RD.
ATLANTA, GA 30305

ISSUE DATE
06/30/17
JOB NO.
10605-01
DWG. NO.
P206

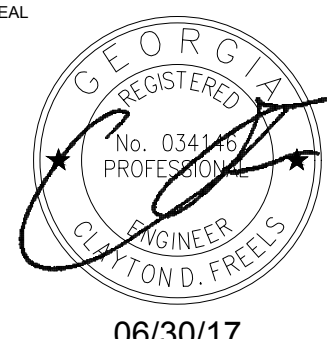

ISSUED FOR CONSTRUCTION